


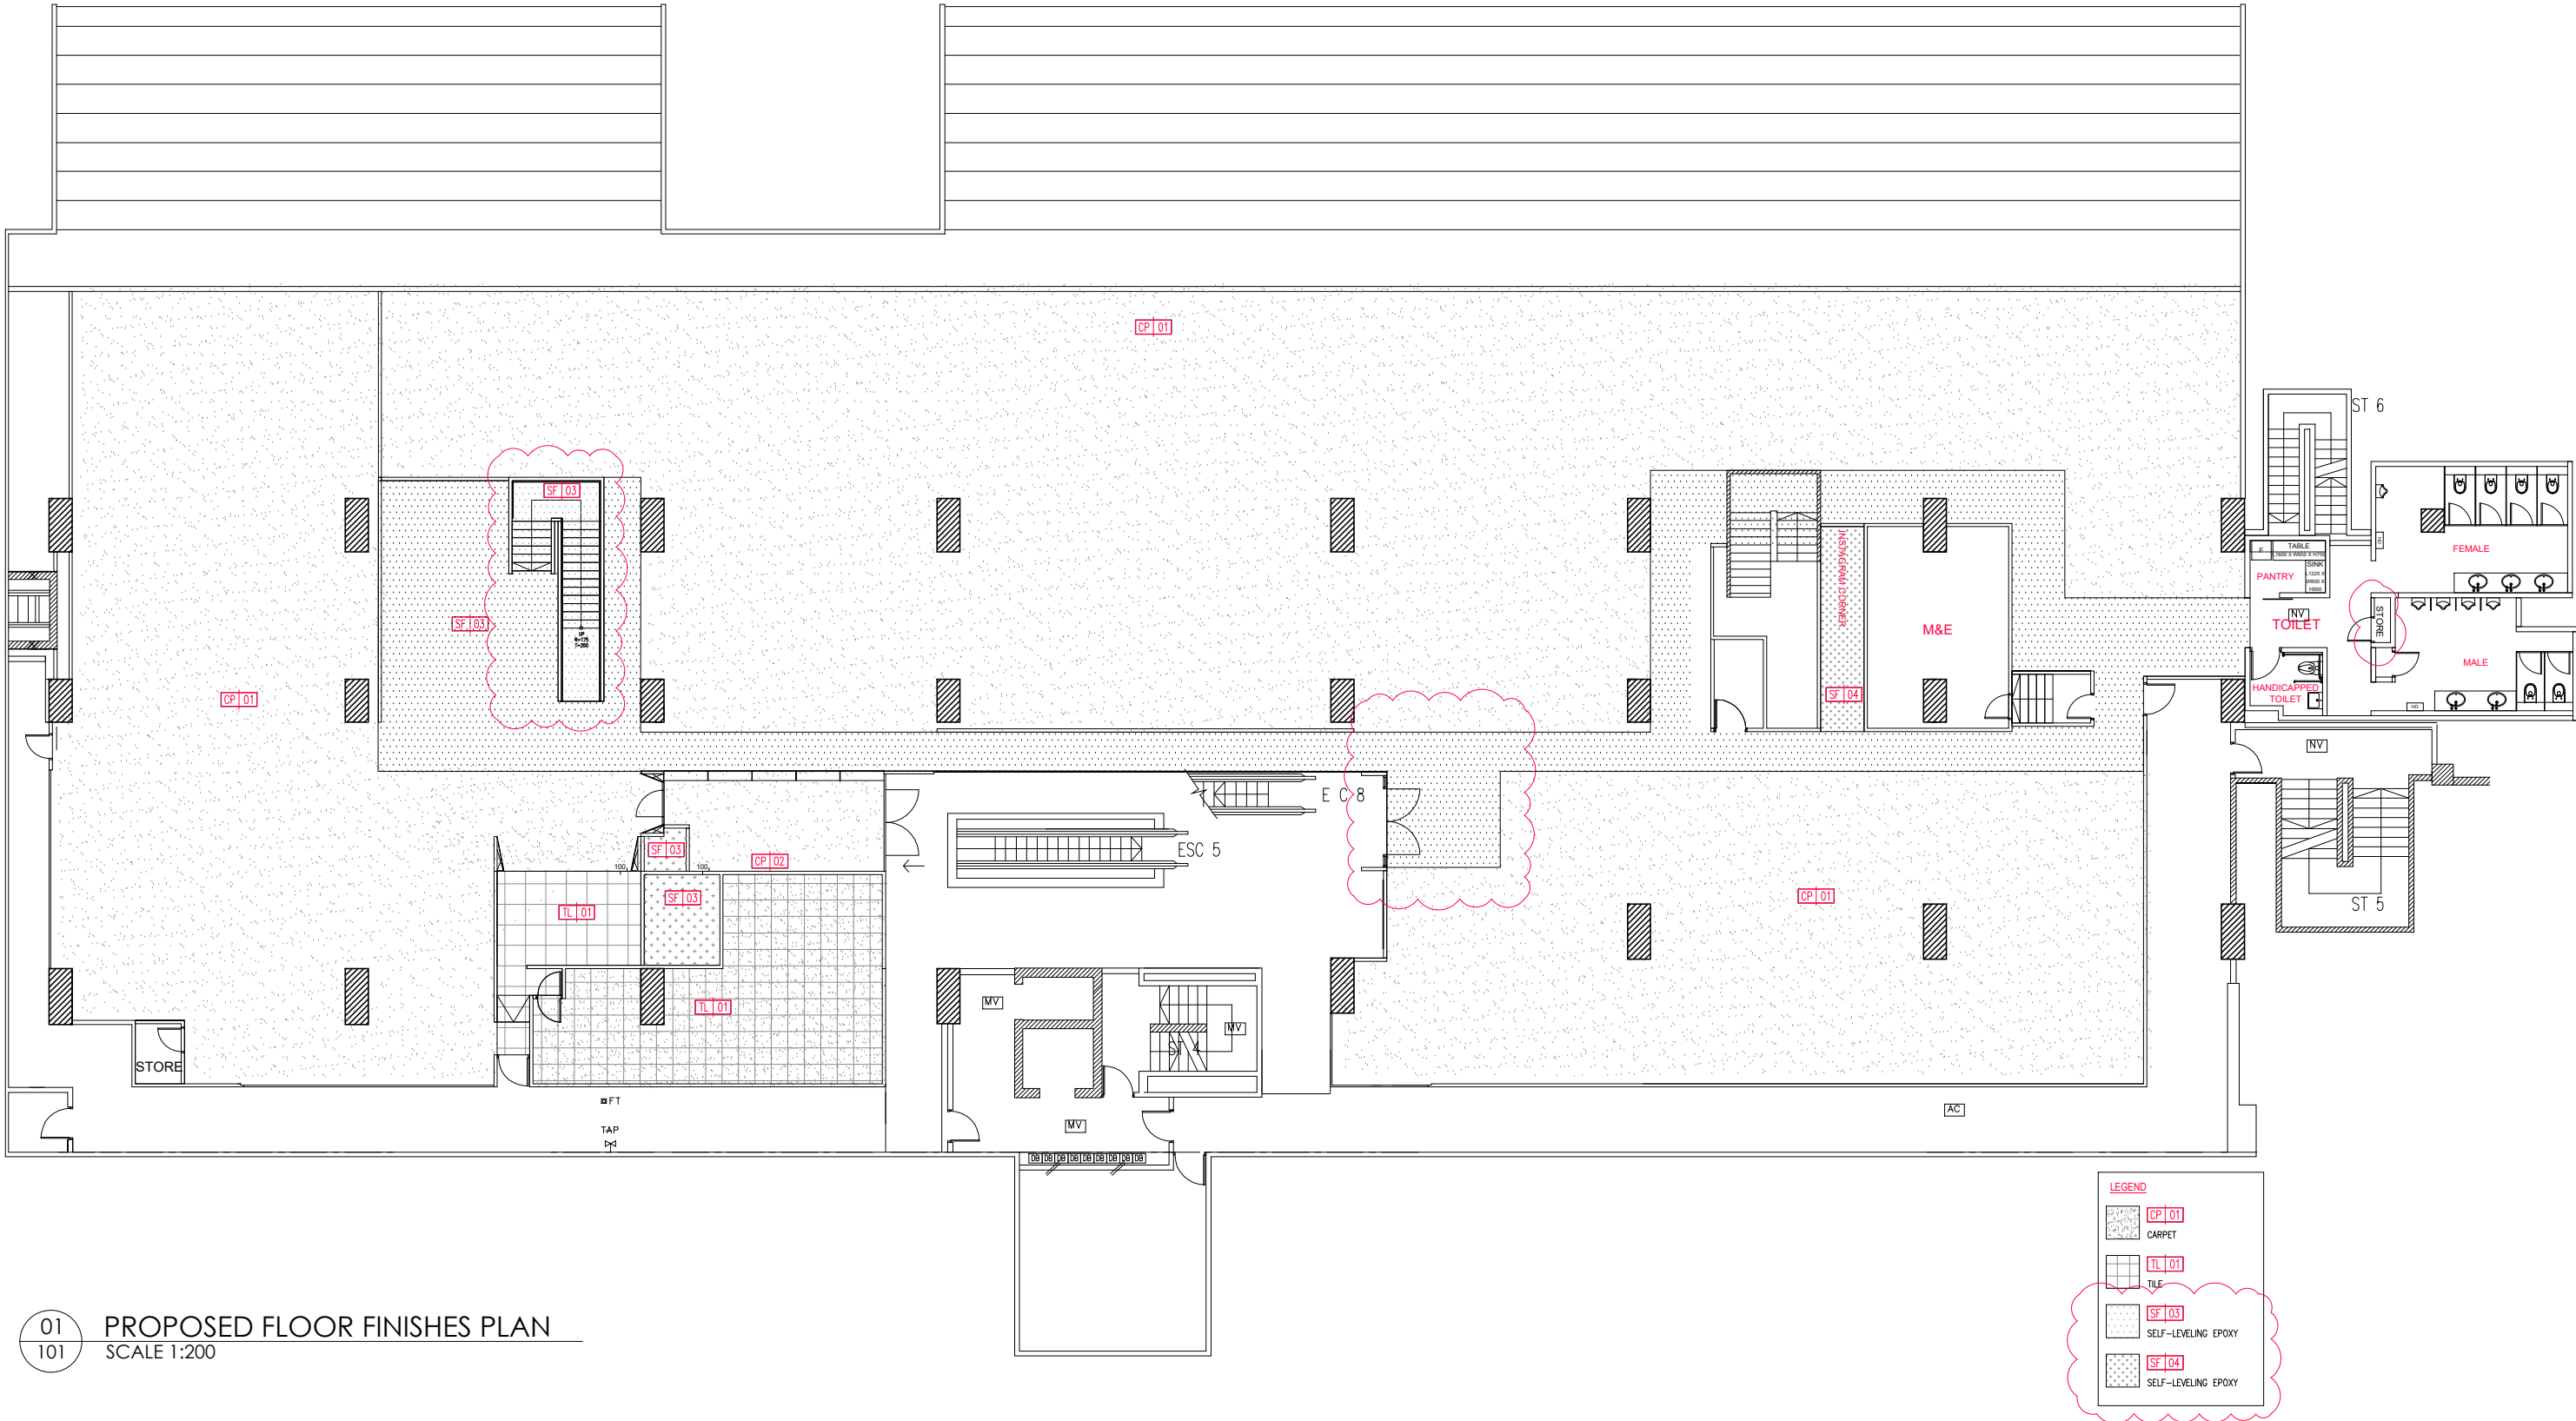

01
101

PROPOSED FLOOR FINISHES PLAN
SCALE 1:200

GENERAL NOTES

ALL DIMENSIONS SHOWN ARE IN MILLIMETRES & SHALL BE VERIFIED ON SITE BY THE CONTRACTOR OR SUB-CONTRACTOR. ALL DIMENSIONS SHOULD NOT BE SCALED FROM THE DRAWING UNLESS OTHERWISE INSTRUCTED. ANY DISCREPANCIES SHALL BE MADE KNOWN TO THE DESIGNER FOR DECISION PRIOR TO PROCEEDING OF THE WORK.

PROJECT TITLE

PROPOSED RENOVATION WORKS TO ROSSA


DRAWING TITLE

PROPOSED FLOOR FINISHES PLAN

SCALE	AS SHOWN (@ A3 PRINT)
DATE	31 AUG 2021
DRAWN	SZM
FILENAME	-
VERSION	H

ORCHITOLGY
(PRIVATE) LIMITED

DRAWING NO. 101

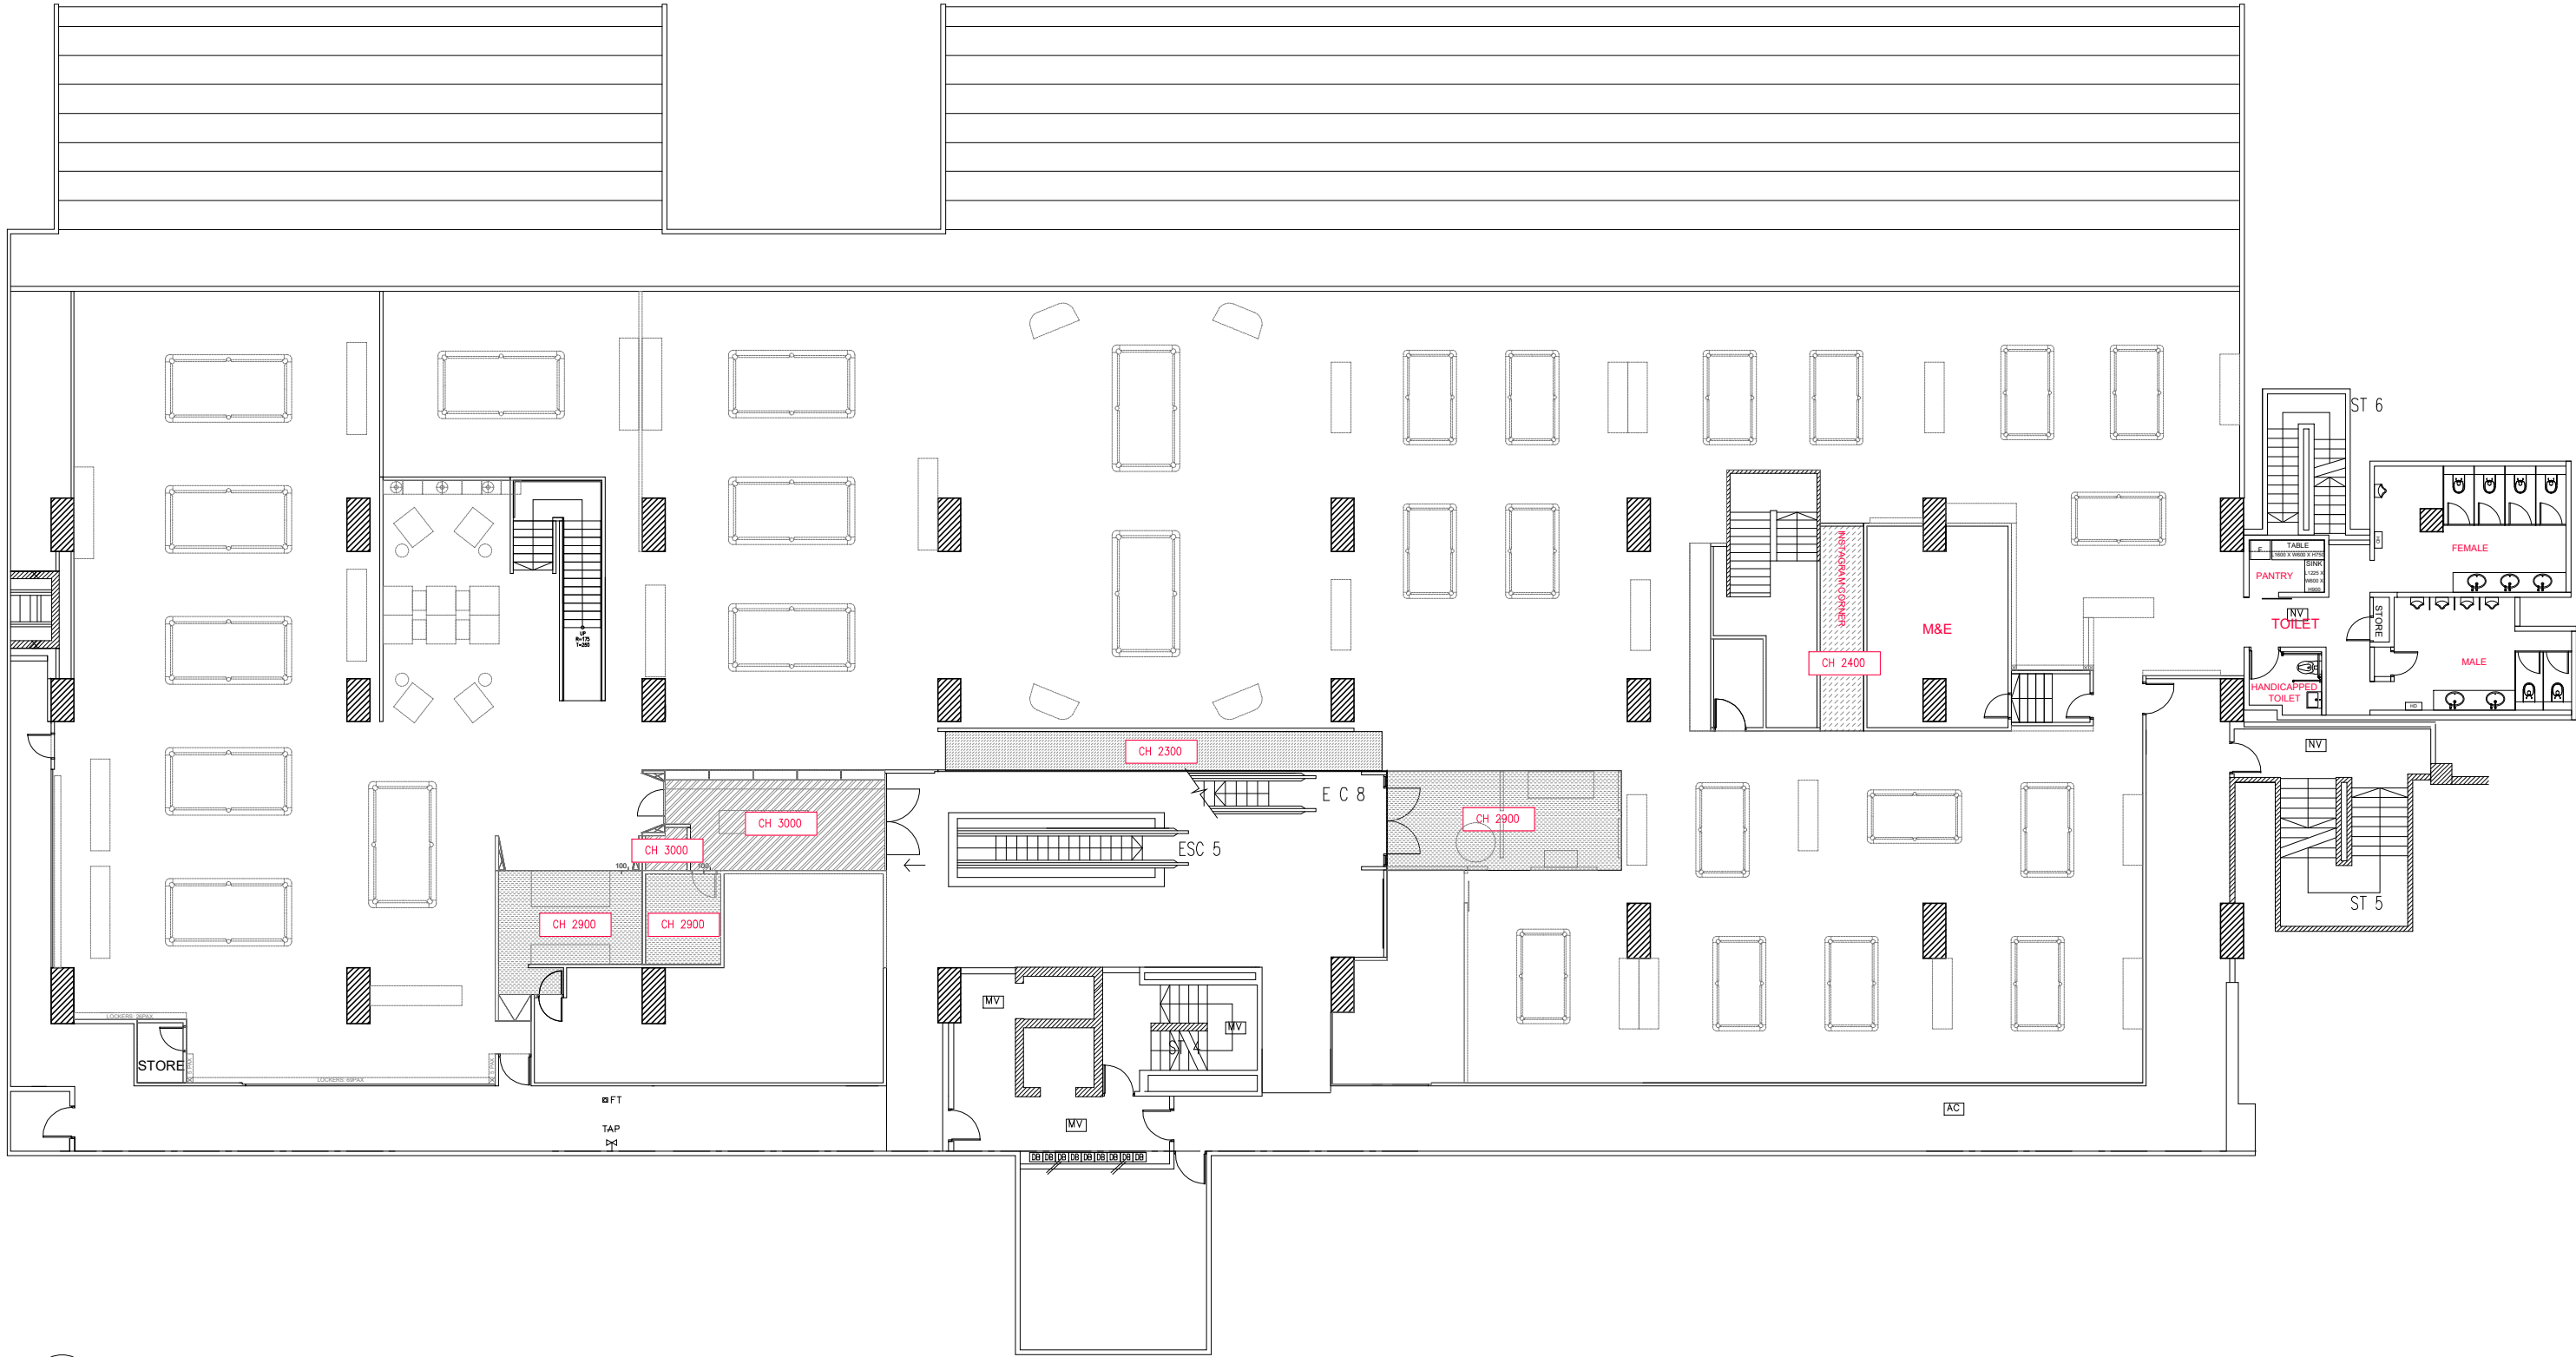

01
102

PROPOSED CEILING PLAN
SCALE 1:200

GENERAL NOTES

ALL DIMENSIONS SHOWN ARE IN MILLIMETRES & SHALL BE VERIFIED ON SITE BY THE CONTRACTOR OR SUB-CONTRACTOR. ALL DIMENSIONS SHOULD NOT BE SCALED FROM THE DRAWING UNLESS OTHERWISE INSTRUCTED. ANY DISCREPANCIES SHALL BE MADE KNOWN TO THE DESIGNER FOR DECISION PRIOR TO PROCEEDING OF THE WORK.

PROJECT TITLE


PROPOSED RENOVATION WORKS TO
ROSSA

DRAWING TITLE

PROPOSED CEILING PLAN

SCALE	AS SHOWN (@ A3 PRINT)
DATE	30 JULY 2021
DRAWN	SZM
FILENAME	-
VERSION	D

ORCHITOLGY
(PRIVATE) LIMITED
DRAWING NO. 102

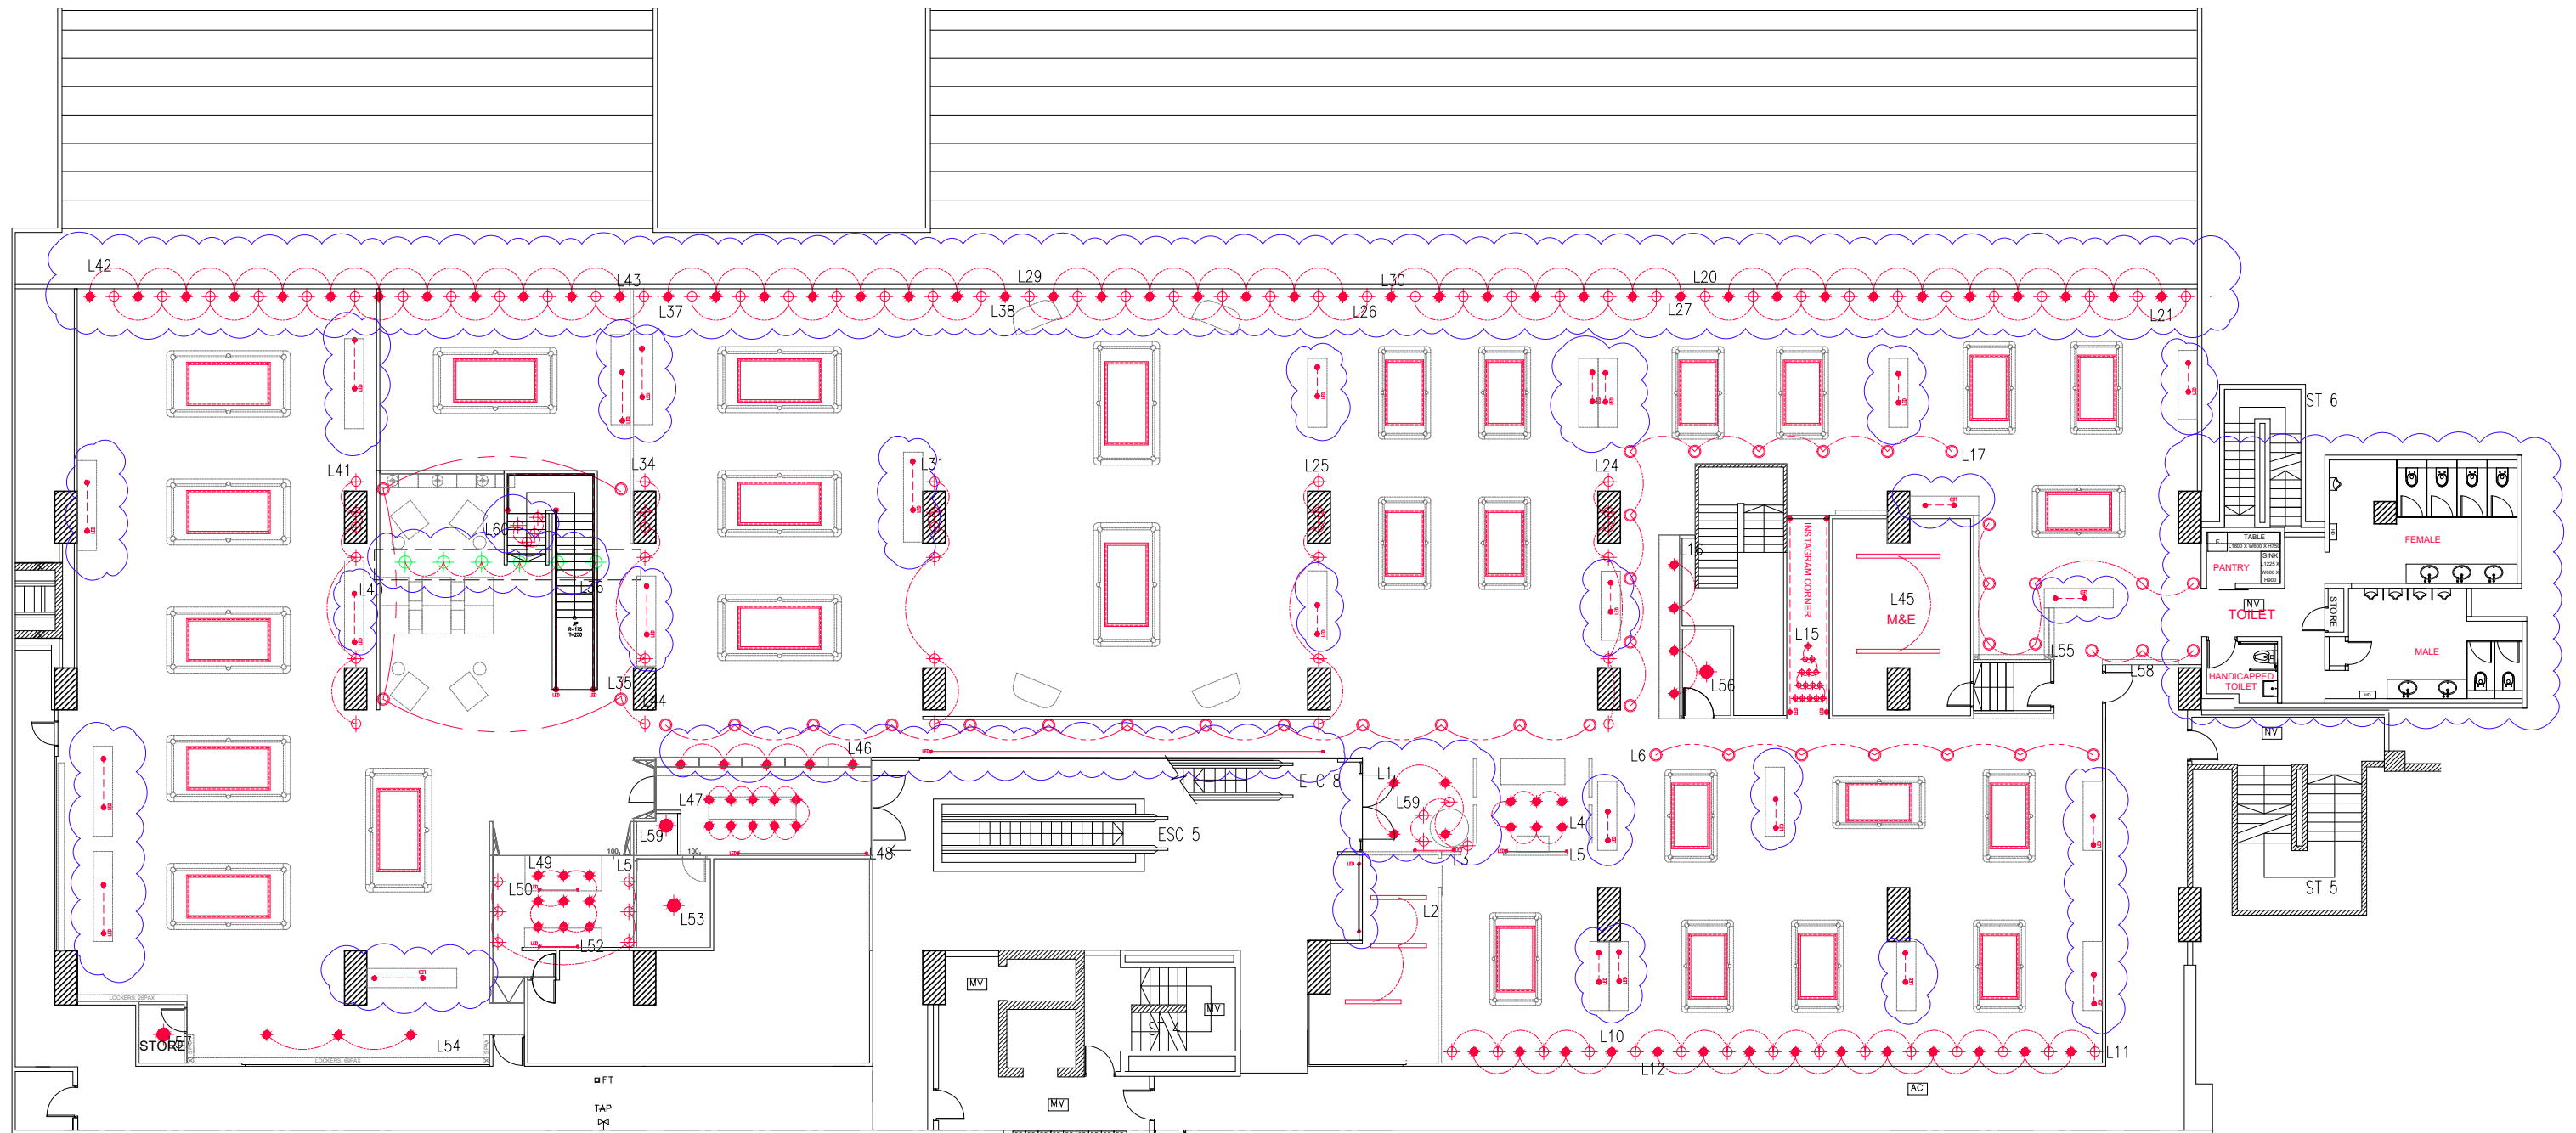

01
103
PROPOSED LIGHTING PLAN
SCALE 1:200

GENERAL NOTES

ALL DIMENSIONS SHOWN ARE IN MILLIMETRES & SHALL BE VERIFIED ON SITE BY THE CONTRACTOR OR SUB-CONTRACTOR.
ALL DIMENSIONS SHOULD NOT BE SCALED FROM THE DRAWING UNLESS OTHERWISE INSTRUCTED. ANY DISCREPANCIES SHALL BE MADE KNOWN TO THE DESIGNER FOR DECISION PRIOR TO PROCEEDING OF THE WORK.

PROJECT TITLE

PROPOSED RENOVATION WORKS TO
ROSSA

DRAWING TITLE

PROPOSED LIGHTING PLAN

SCALE

AS SHOWN (@ A3 PRINT)

DATE

30 AUG 2021

DRAWN

SZM

FILENAME

-


VERSION

J

ORCHITOLGY
(PRIVATE) LIMITED

DRAWING NO.

103

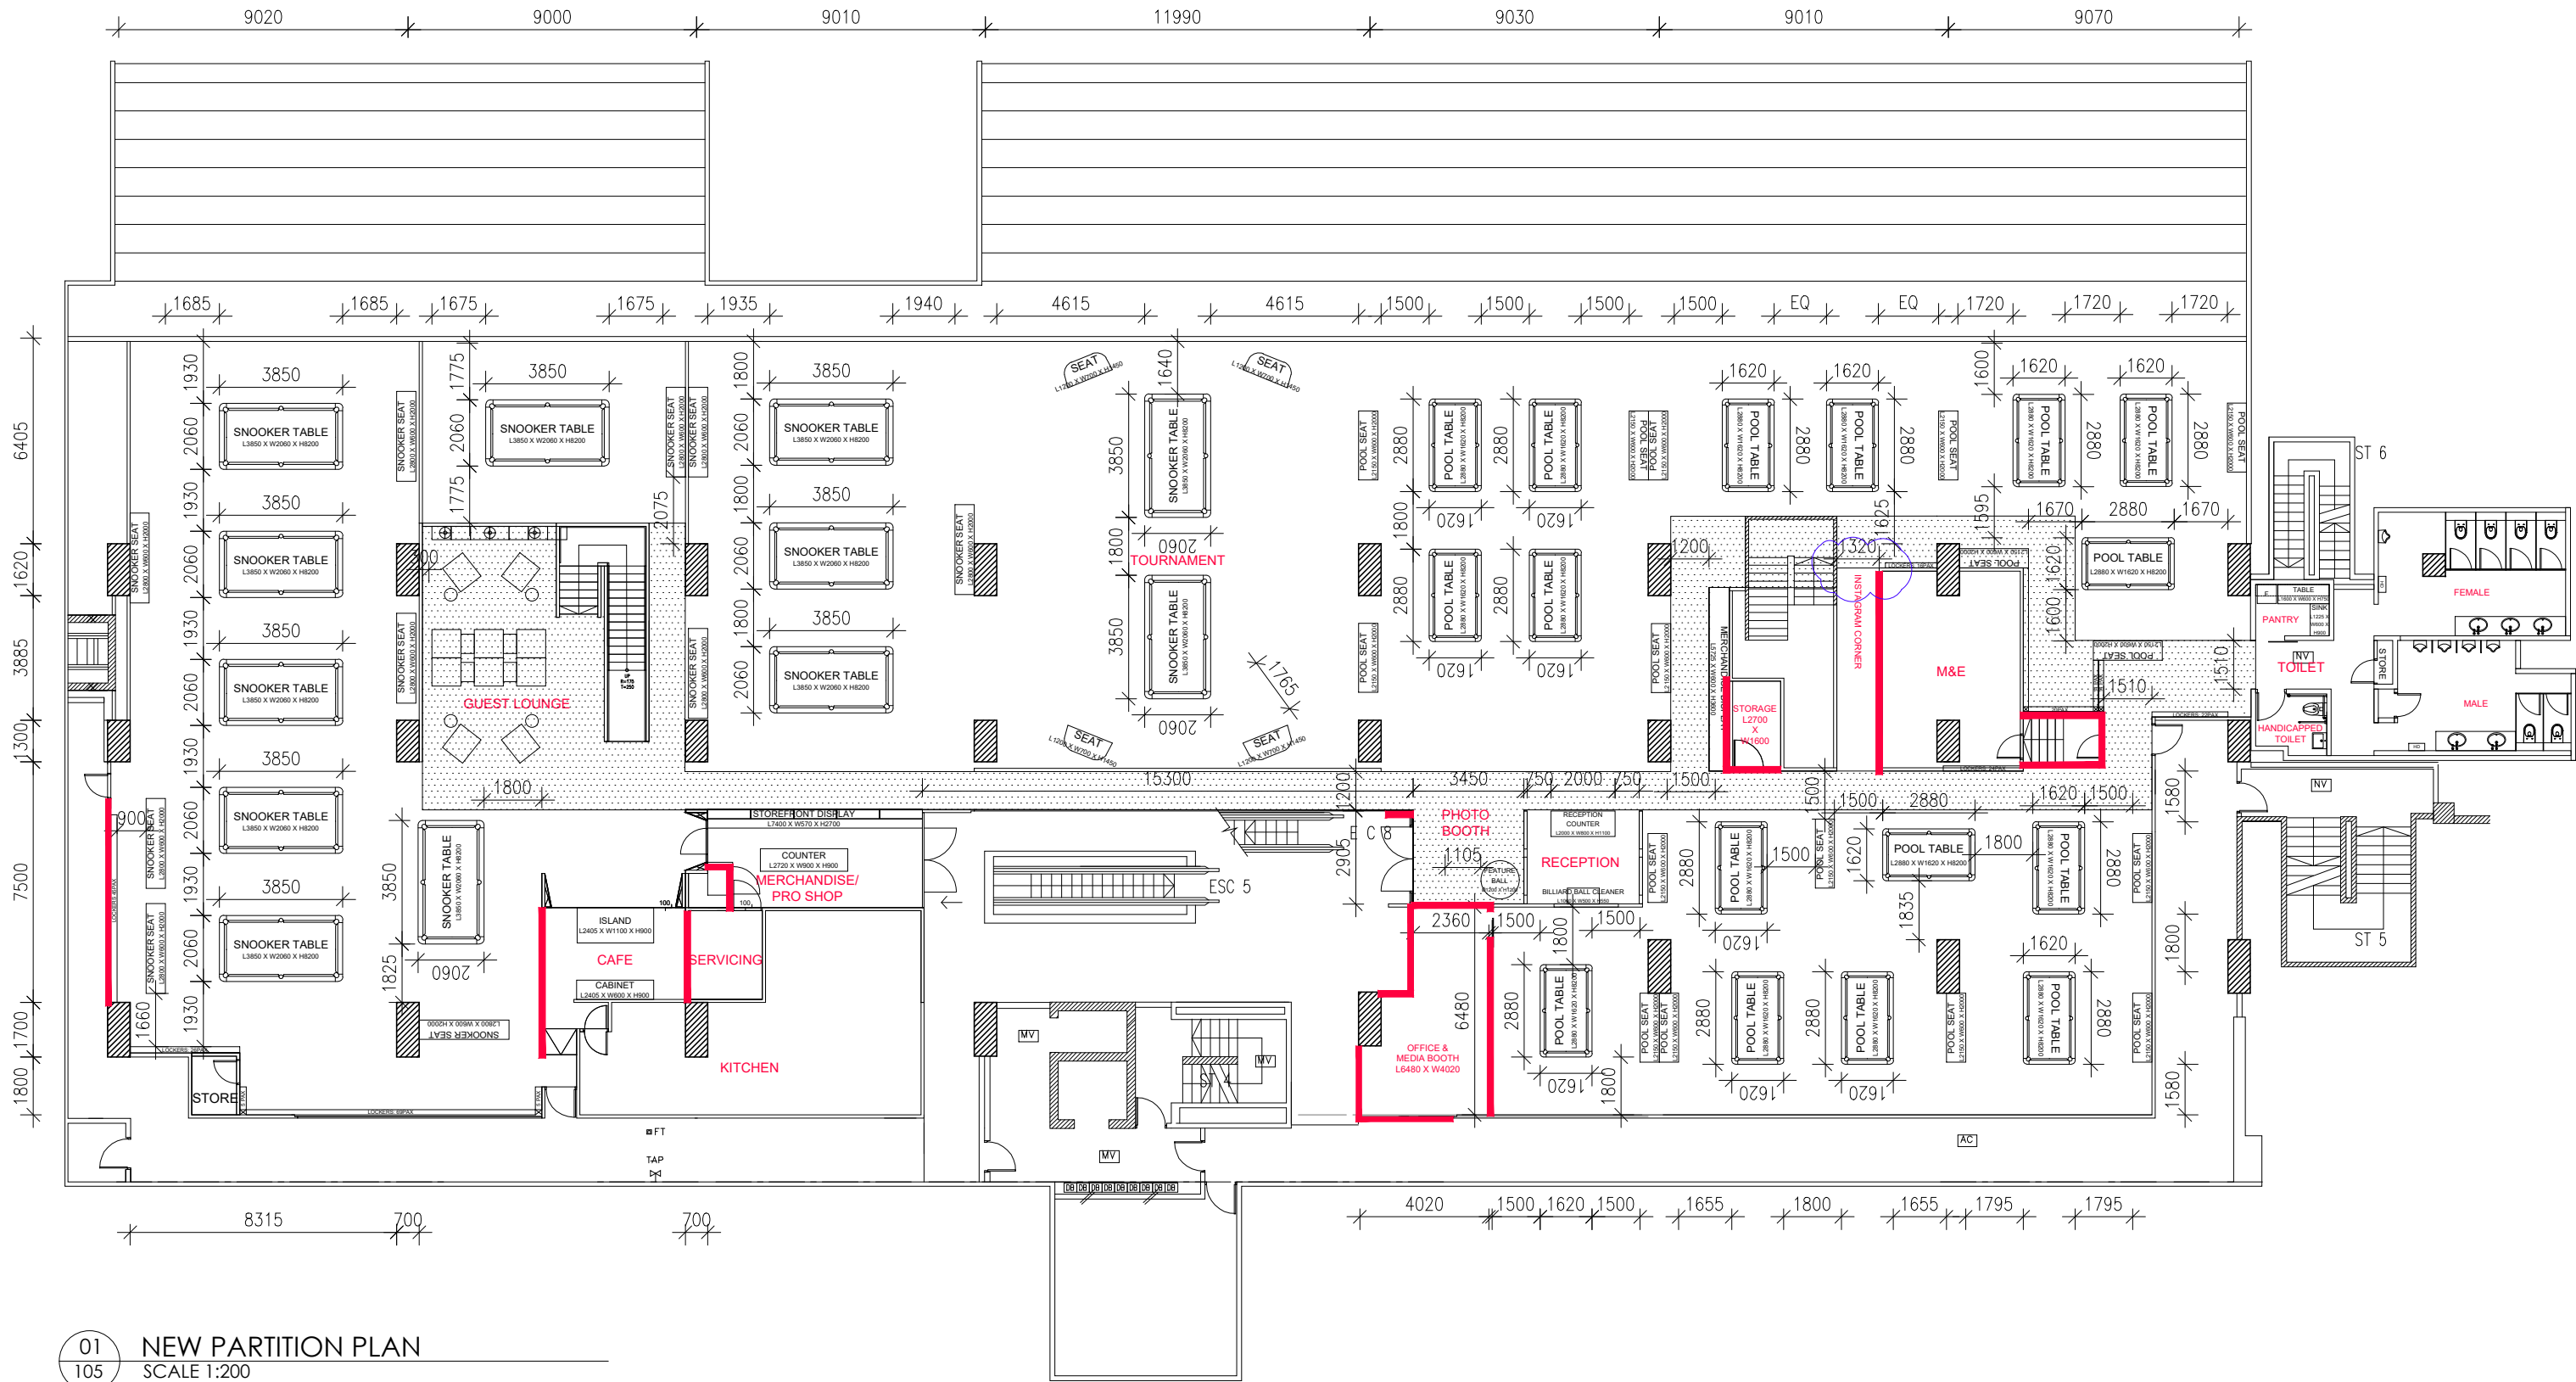

01
105 NEW PARTITION PLAN
SCALE 1:200

GENERAL NOTES

ALL DIMENSIONS SHOWN ARE IN MILLIMETRES & SHALL BE VERIFIED ON SITE BY THE CONTRACTOR OR SUB-CONTRACTOR.

ALL DIMENSIONS SHOULD NOT BE SCALED FROM THE DRAWING UNLESS OTHERWISE INSTRUCTED. ANY DISCREPANCIES SHALL BE MADE KNOWN TO THE DESIGNER FOR DECISION PRIOR TO PROCEEDING OF THE WORK.

PROJECT TITLE

PROPOSED RENOVATION WORKS TO ROSSA


DRAWING TITLE

NEW PARTITION PLAN

SCALE	AS SHOWN (@ A3 PRINT)
DATE	08 SEPT 2021
DRAWN	SY
FILENAME	-
VERSION	D

ORCHITOLGY
(PRIVATE) LIMITED

DRAWING NO. 105

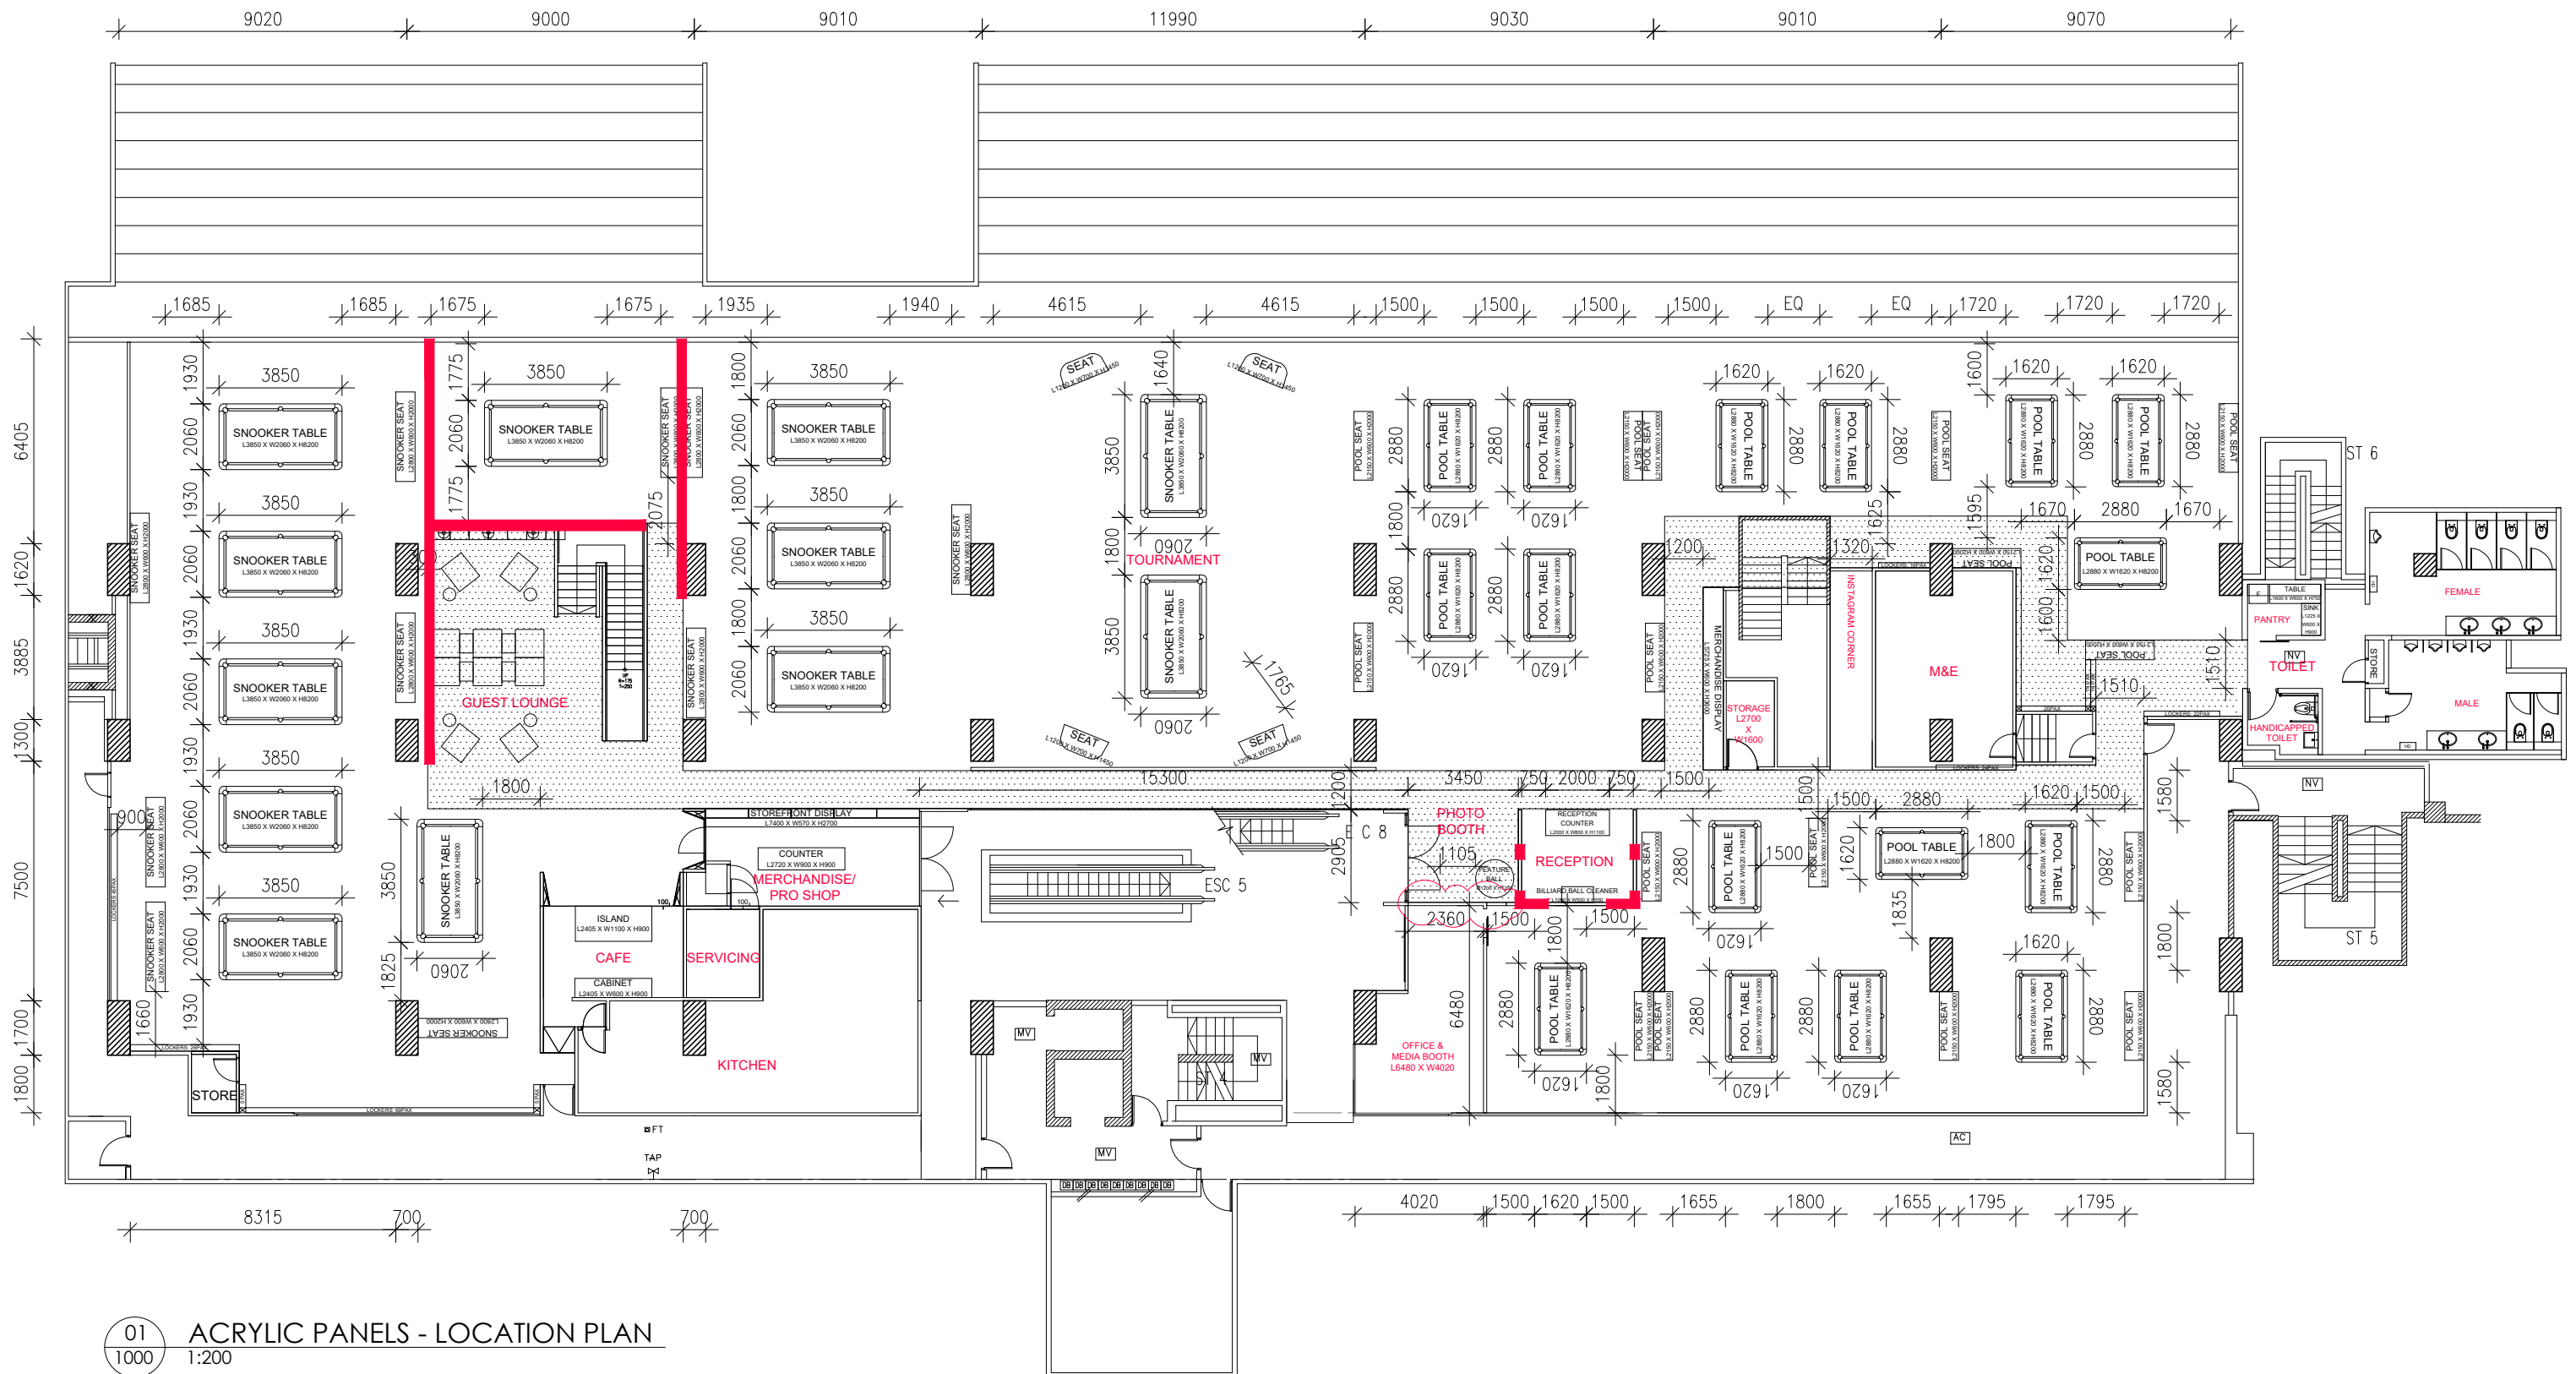

GENERAL NOTES

ALL DIMENSIONS SHOWN ARE IN MILLIMETRES & SHALL BE VERIFIED ON SITE BY THE CONTRACTOR OR SUB-CONTRACTOR.

ALL DIMENSIONS SHOULD NOT BE SCALED FROM THE DRAWING UNLESS OTHERWISE INSTRUCTED. ANY DISCREPANCIES SHALL BE MADE KNOWN TO THE DESIGNER FOR DECISION PRIOR TO PROCEEDING OF THE WORK.


PROJECT TITLE

PROPOSED RENOVATION WORKS TO ROSSA

DRAWING TITLE

ACRYLIC LOCATION PLAN

SCALE	AS SHOWN (@ A3 PRINT)
DATE	01 SEPT 2021
DRAWN	SY
FILENAME	-
VERSION	A

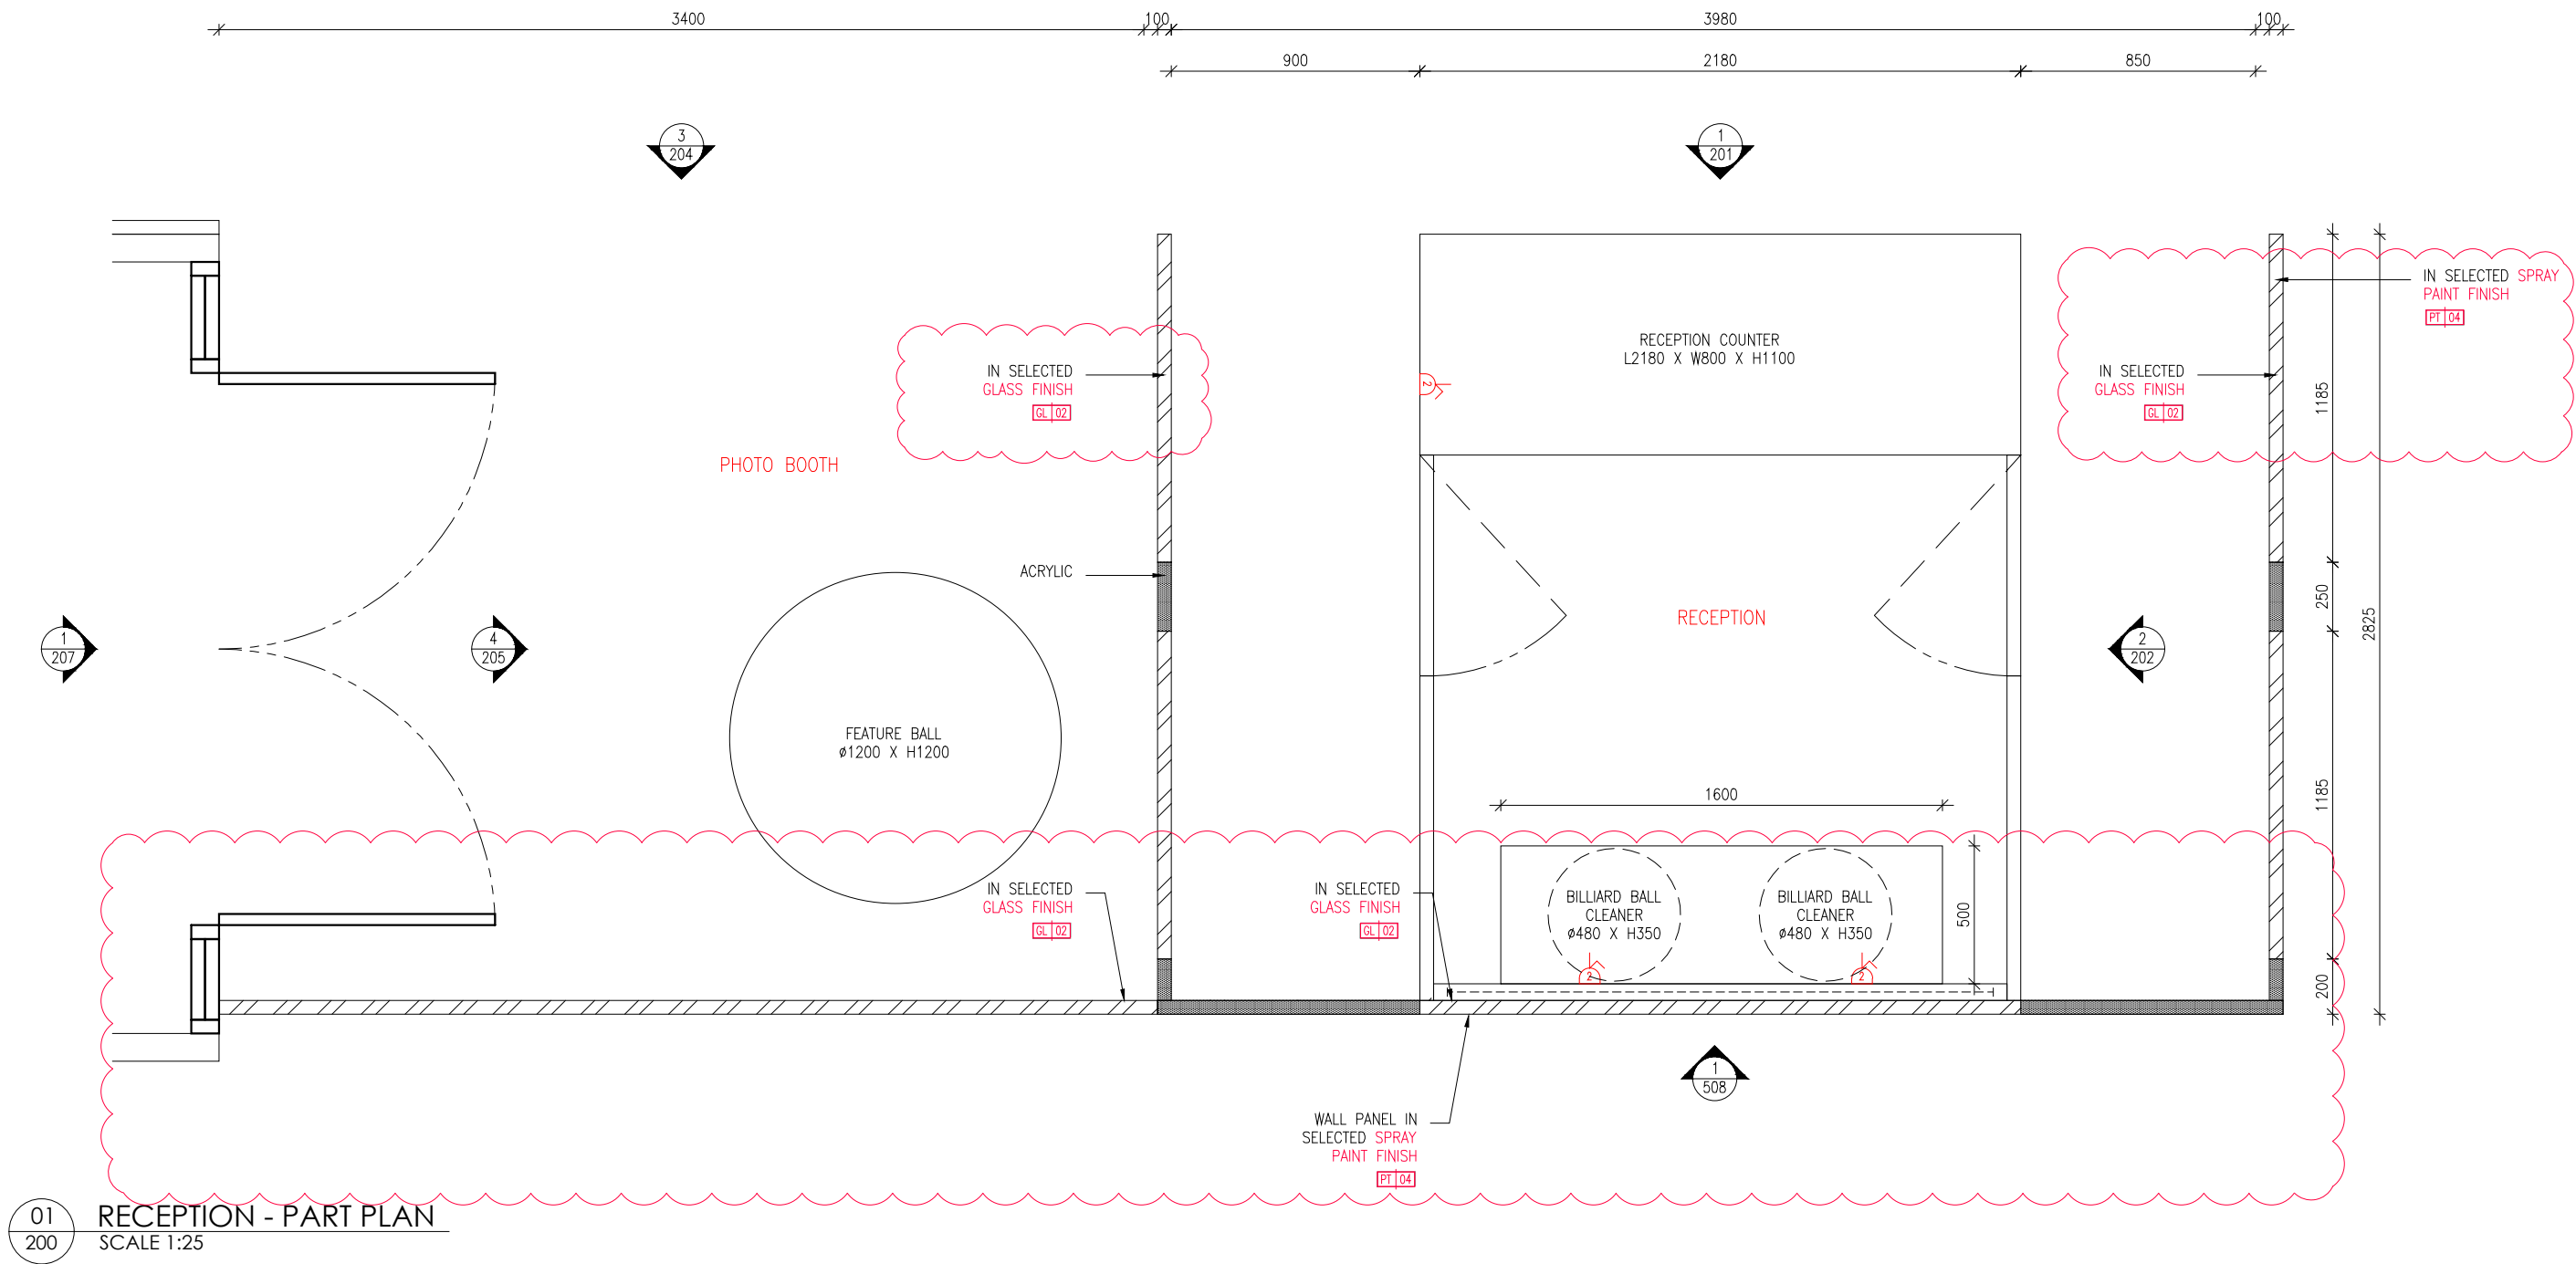

GENERAL NOTES

ALL DIMENSIONS SHOWN ARE IN MILLIMETRES & SHALL BE VERIFIED ON SITE BY THE CONTRACTOR OR SUB-CONTRACTOR.

ALL DIMENSIONS SHOULD NOT BE SCALED FROM THE DRAWING UNLESS OTHERWISE INSTRUCTED. ANY DISCREPANCIES SHALL BE MADE KNOWN TO THE DESIGNER FOR DECISION PRIOR TO PROCEEDING OF THE WORK.

PROJECT TITLE

PROPOSED RENOVATION WORKS TO ROSSA

DRAWING TITLE

RECEPTION PART PLAN


SCALE	AS SHOWN (@ A3 PRINT)
DATE	31 AUG 2021
DRAWN	SZM
FILENAME	-
VERSION	D

ORCHITOLOGY

(PRIVATE) LIMITED

DRAWING NO.

200

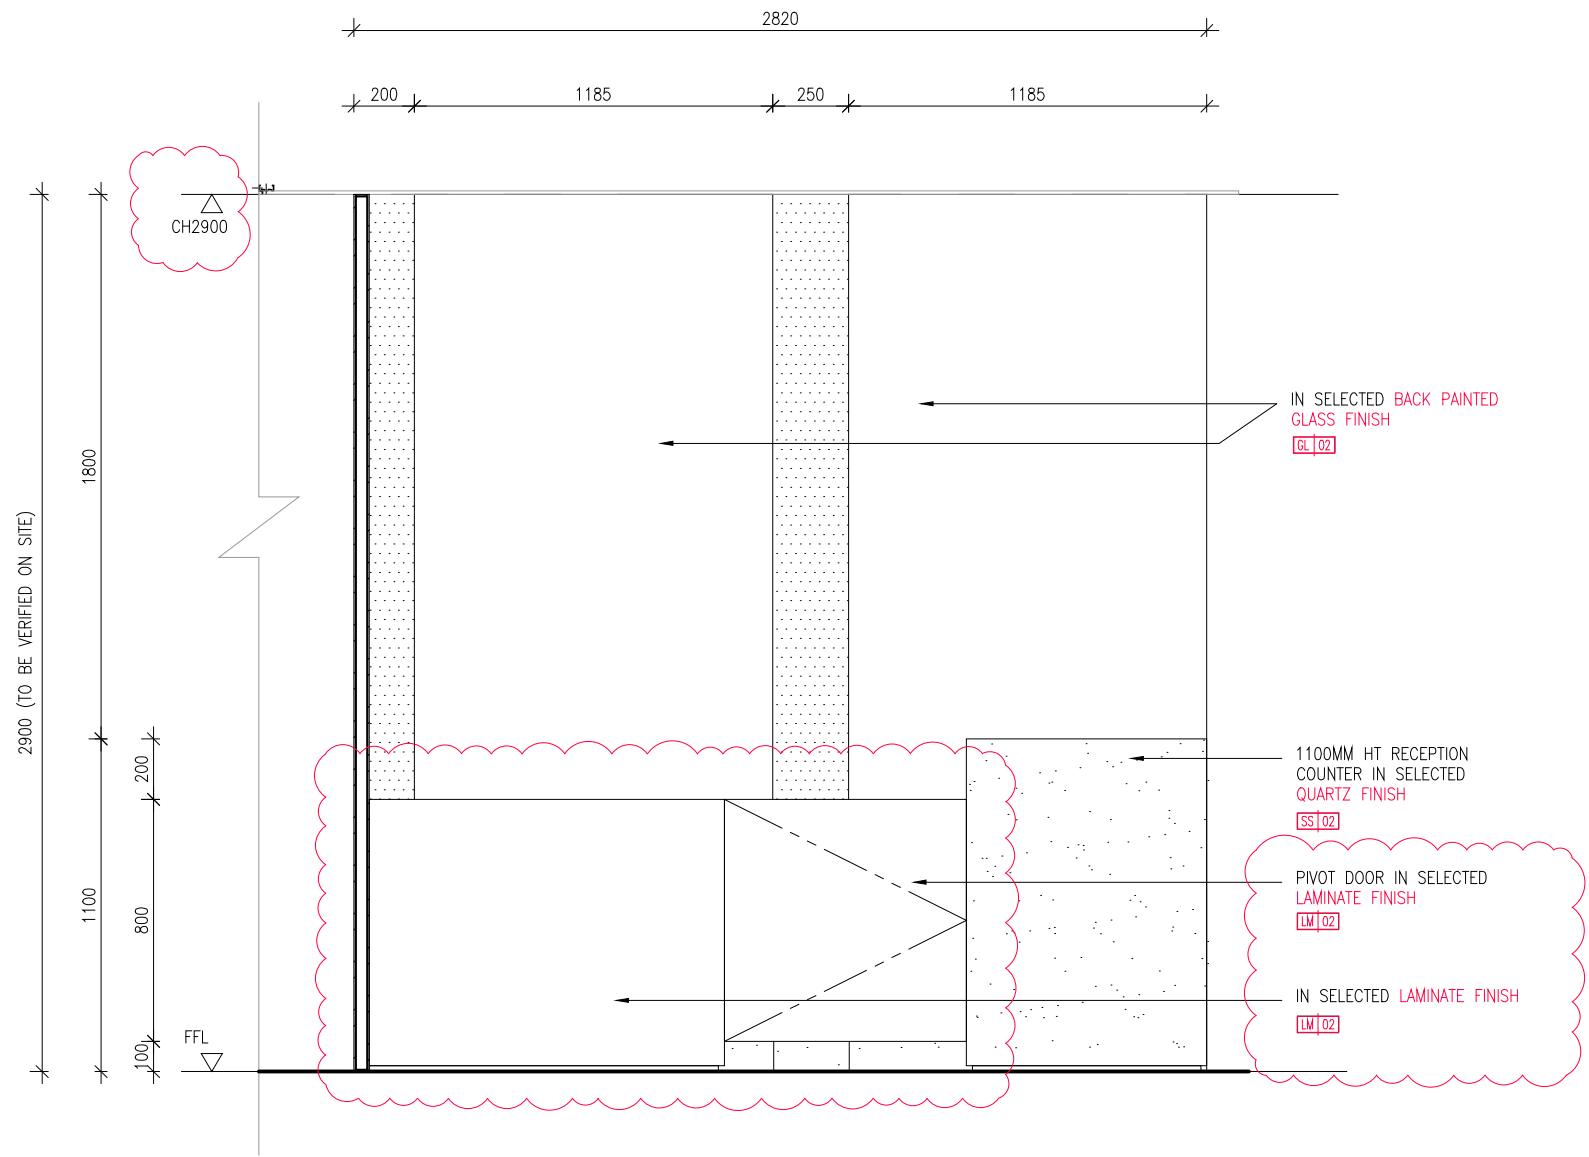

01
202

RECEPTION - ELEVATION 2
SCALE 1:25

GENERAL NOTES

ALL DIMENSIONS SHOWN ARE IN MILLIMETRES & SHALL BE VERIFIED ON SITE BY THE CONTRACTOR OR SUB-CONTRACTOR.

ALL DIMENSIONS SHOULD NOT BE SCALED FROM THE DRAWING UNLESS OTHERWISE INSTRUCTED. ANY DISCREPANCIES SHALL BE MADE KNOWN TO THE DESIGNER FOR DECISION PRIOR TO PROCEEDING OF THE WORK.

PROJECT TITLE

PROPOSED RENOVATION WORKS TO ROSSA





DRAWING TITLE

RECEPTION - ELEVATION 2


SCALE	AS SHOWN (@ A3 PRINT)
DATE	31 AUG 2021
DRAWN	SZM
FILENAME	-
VERSION	D

OTCHITOLOGY
(PRIVATE) LIMITED

DRAWING NO. 202

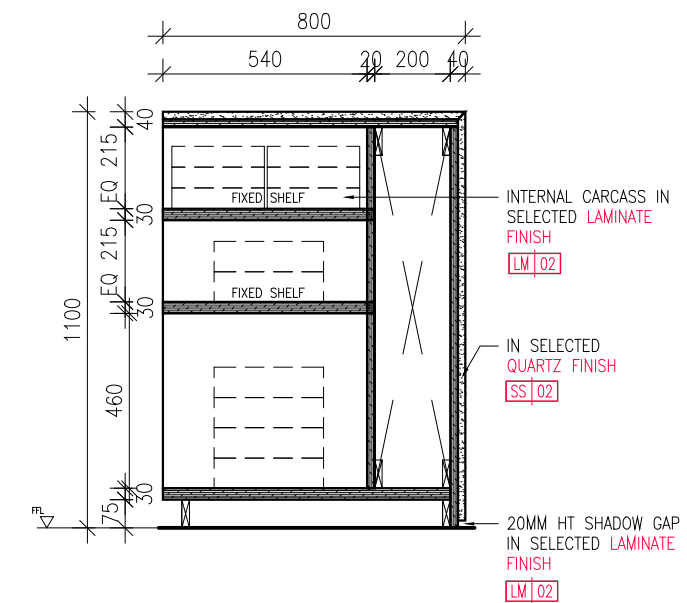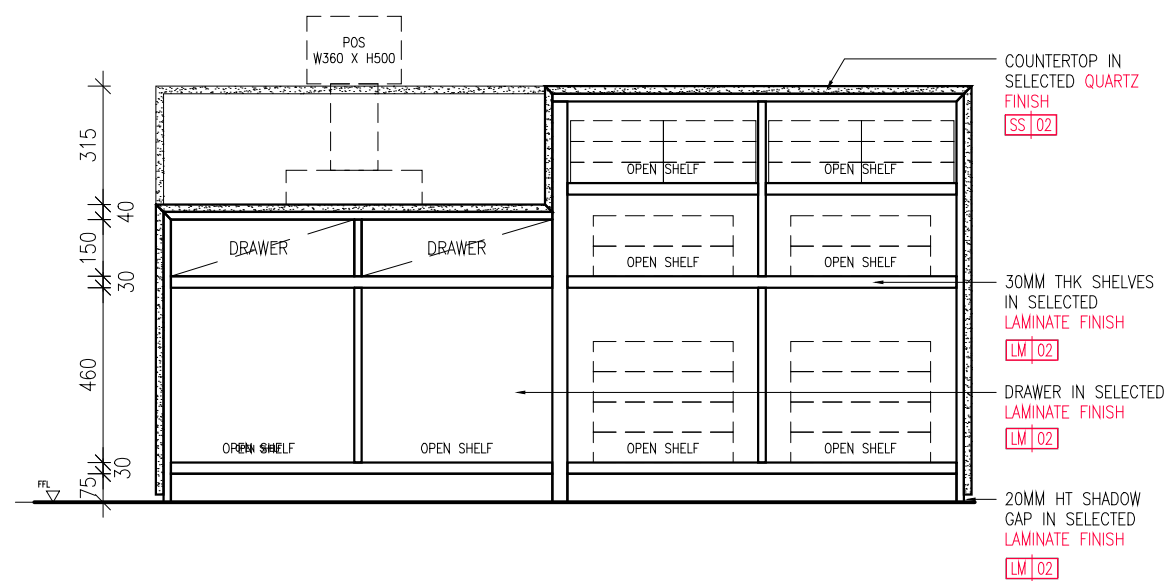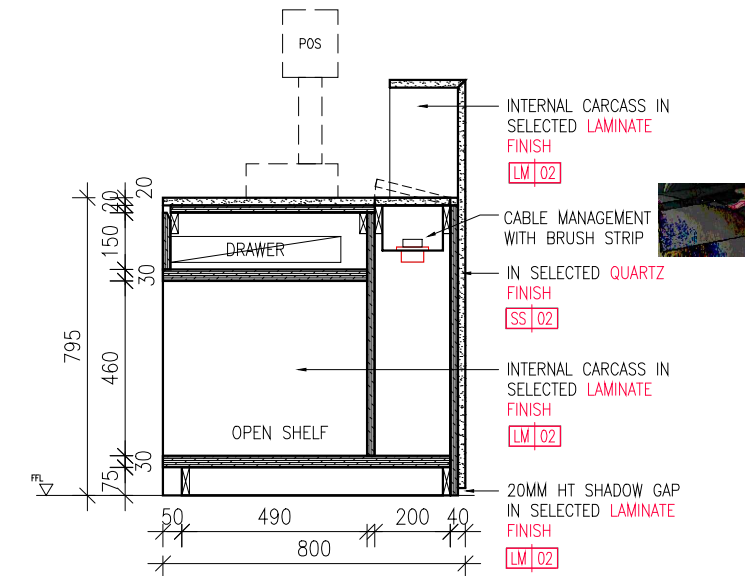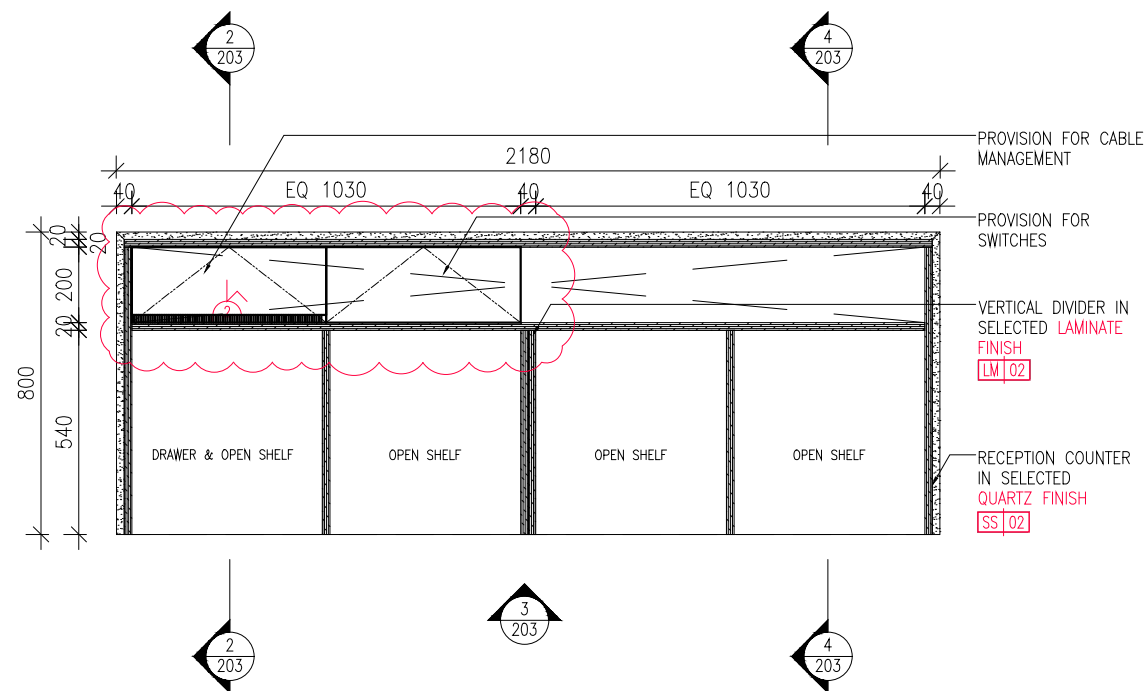

203

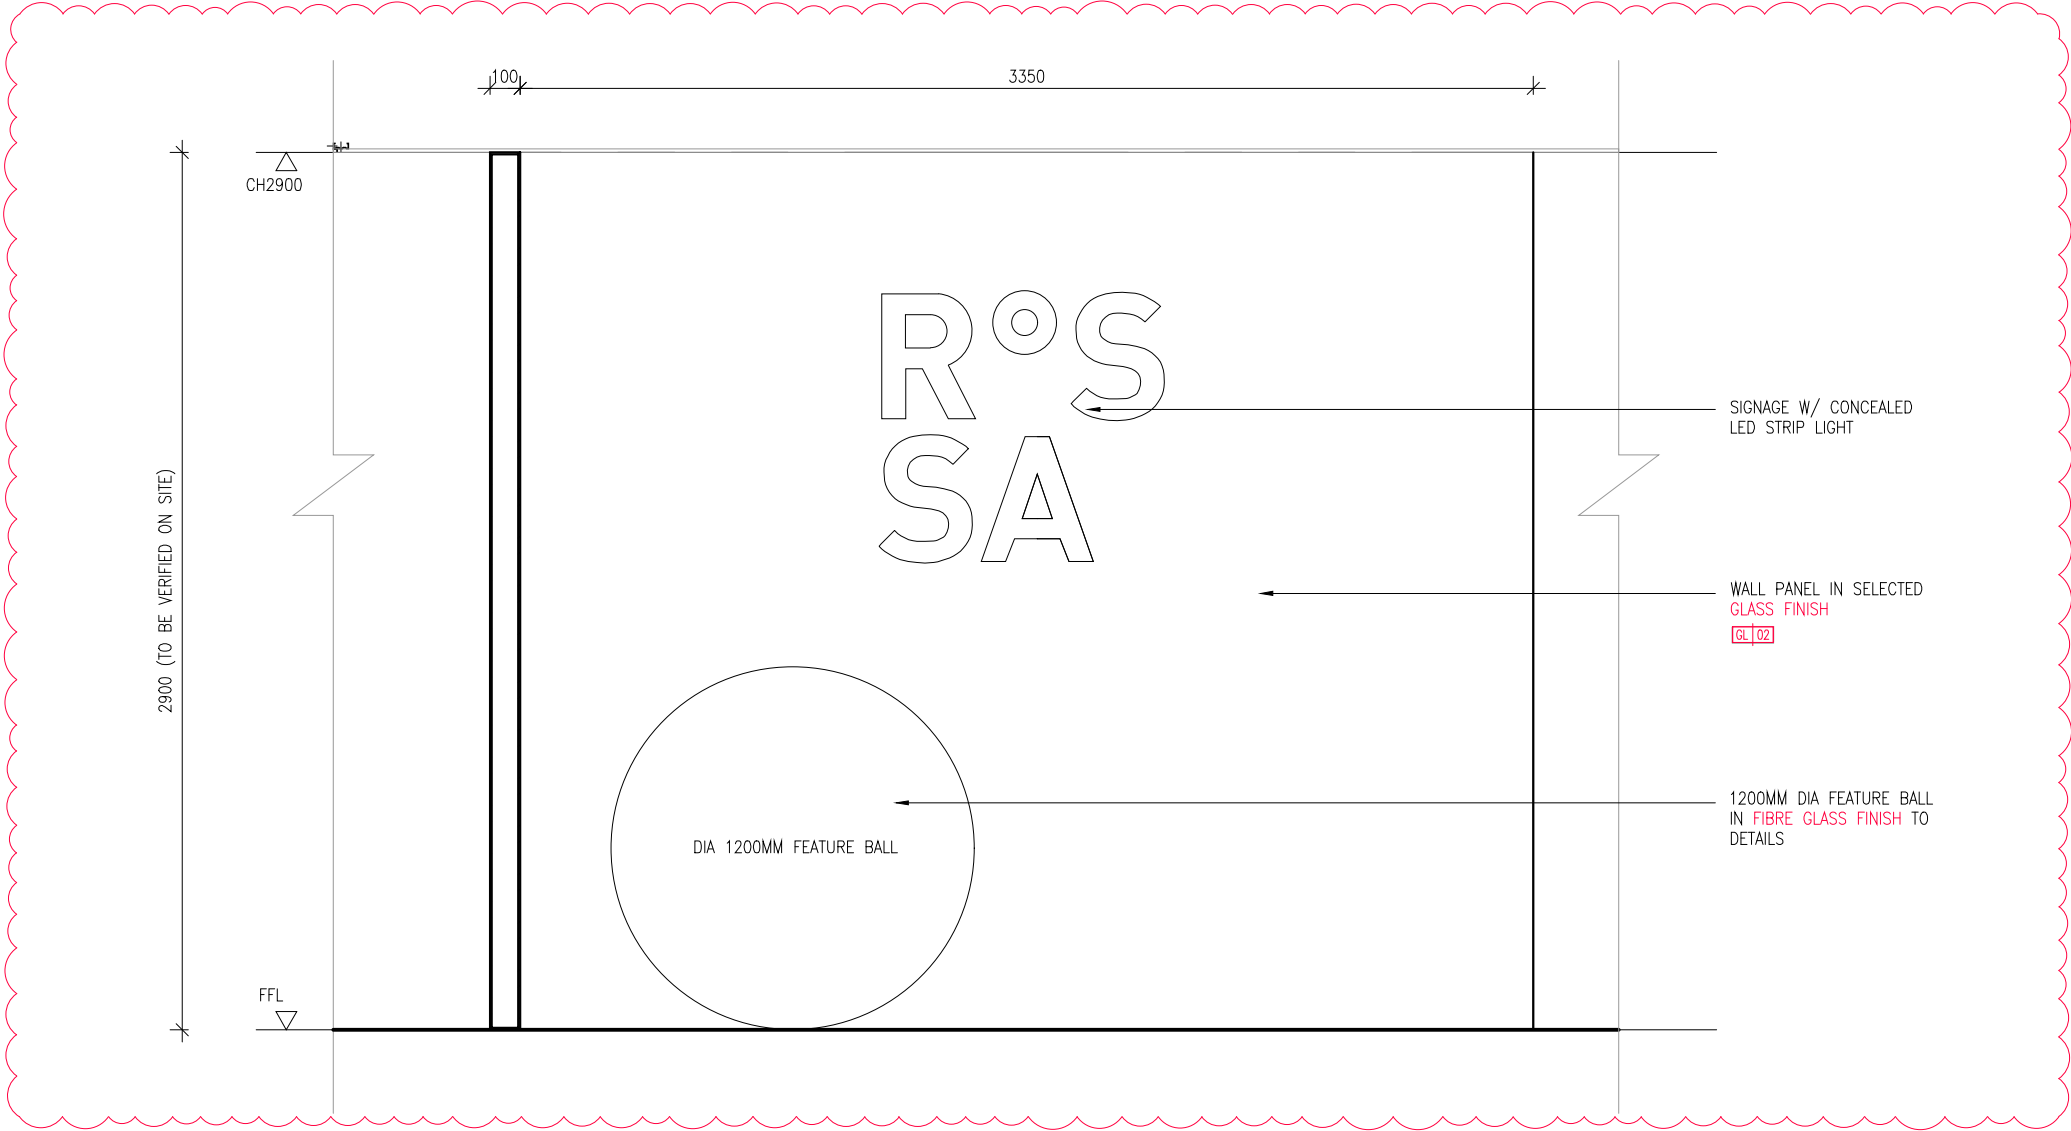

01
204

PHOTO BOOTH - ELEVATION 3
SCALE 1:25

GENERAL NOTES

ALL DIMENSIONS SHOWN ARE IN MILLIMETRES & SHALL BE VERIFIED ON SITE BY THE CONTRACTOR OR SUB-CONTRACTOR. ALL DIMENSIONS SHOULD NOT BE SCALED FROM THE DRAWING UNLESS OTHERWISE INSTRUCTED. ANY DISCREPANCIES SHALL BE MADE KNOWN TO THE DESIGNER FOR DECISION PRIOR TO PROCEEDING OF THE WORK.

PROJECT TITLE

PROPOSED RENOVATION WORKS TO ROSSA


DRAWING TITLE

PHOTO BOOTH - ELEVATION 3

SCALE	AS SHOWN (@ A3 PRINT)
DATE	31 AUG 2021
DRAWN	SZM
FILENAME	-
VERSION	C

OTCHITOLOGY
(PRIVATE) LIMITED

DRAWING NO. 204

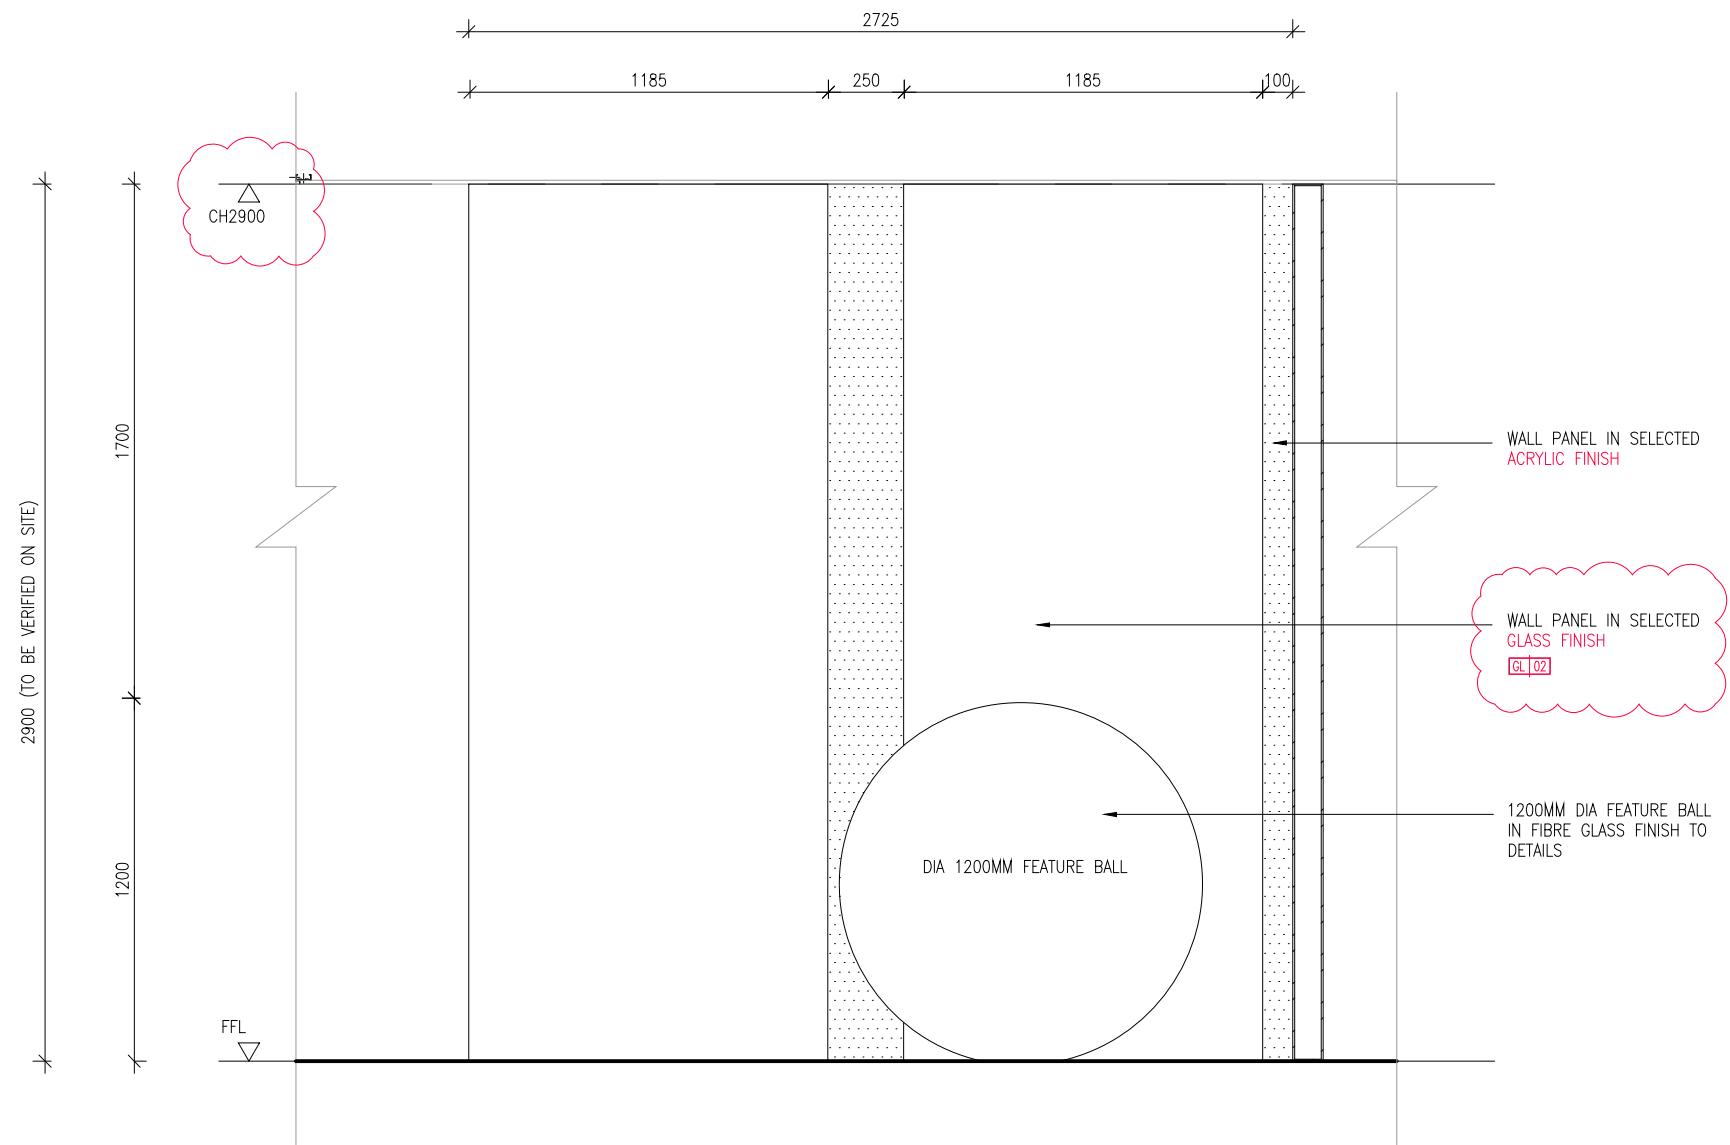

01 PHOTO BOOTH - ELEVATION 4
205 SCALE 1:25

GENERAL NOTES

ALL DIMENSIONS SHOWN ARE IN MILLIMETRES & SHALL BE VERIFIED ON SITE BY THE CONTRACTOR OR SUB-CONTRACTOR.

ALL DIMENSIONS SHOULD NOT BE SCALED FROM THE DRAWING UNLESS OTHERWISE INSTRUCTED. ANY DISCREPANCIES SHALL BE MADE KNOWN TO THE DESIGNER FOR DECISION PRIOR TO PROCEEDING OF THE WORK.

PROJECT TITLE

PROPOSED RENOVATION WORKS TO ROSSA



DRAWING TITLE

PHOTO BOOTH - ELEVATION 4

SCALE	AS SHOWN (@ A3 PRINT)
DATE	31 AUG 2021
DRAWN	SZM
FILENAME	-
VERSION	C

ORCHITOLOGY
(PRIVATE) LIMITED

DRAWING NO. 205

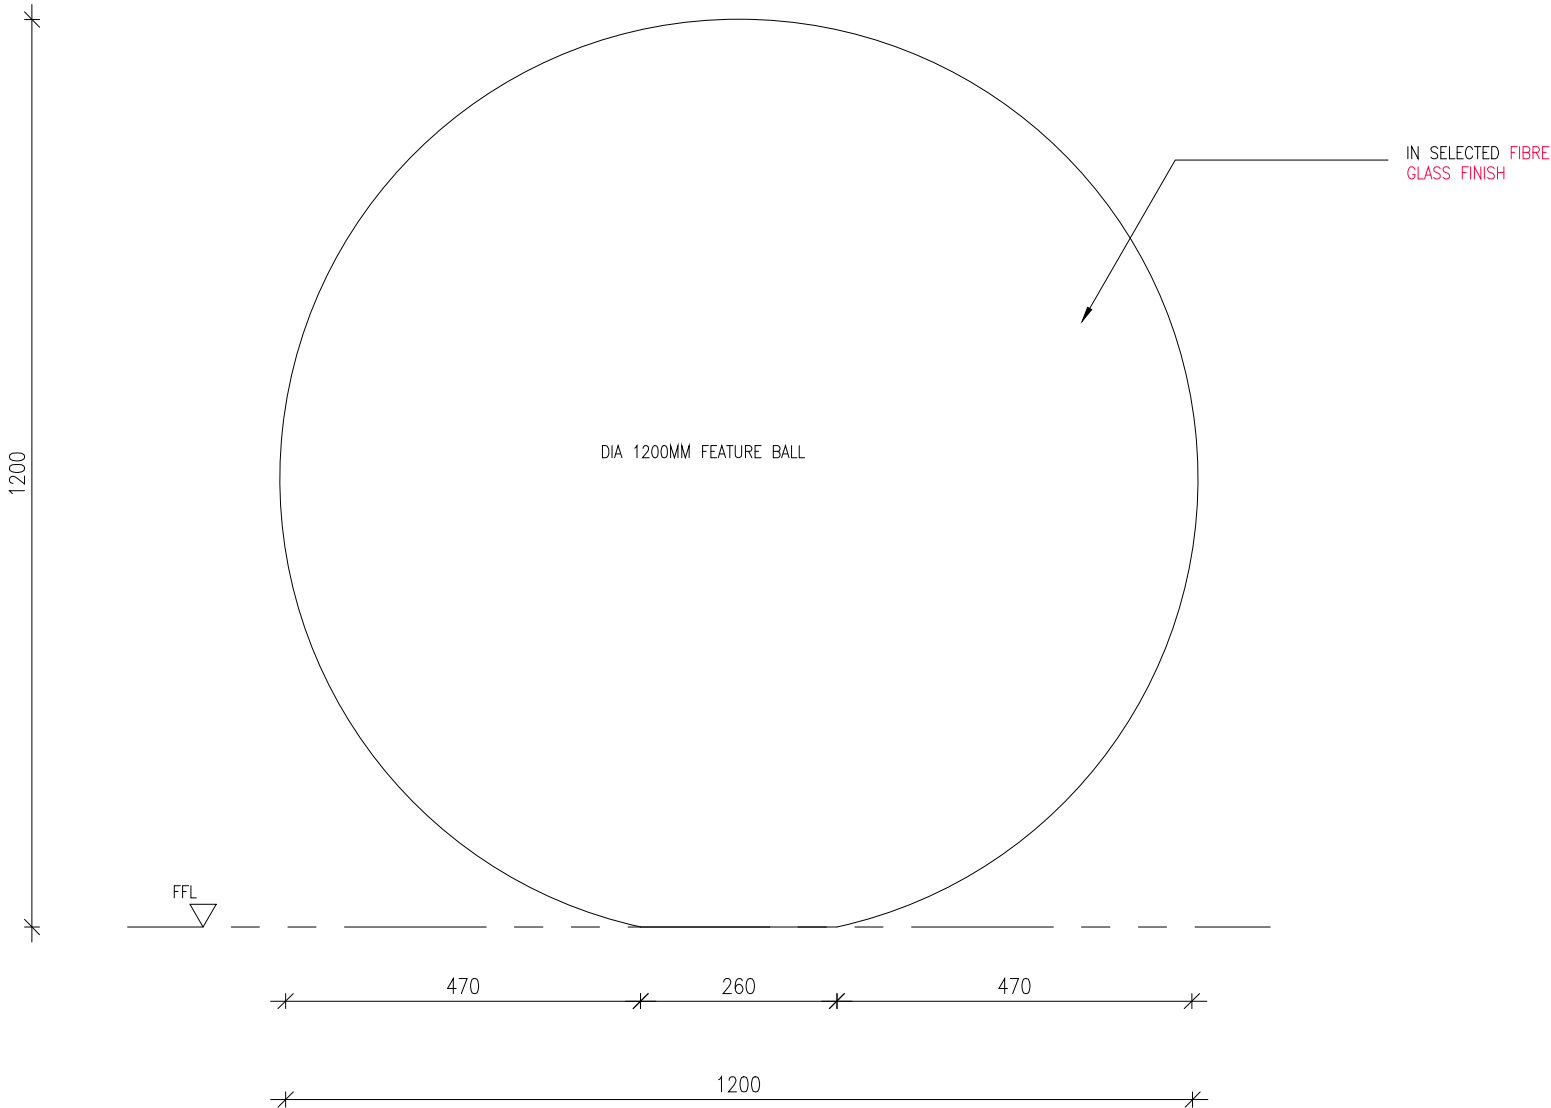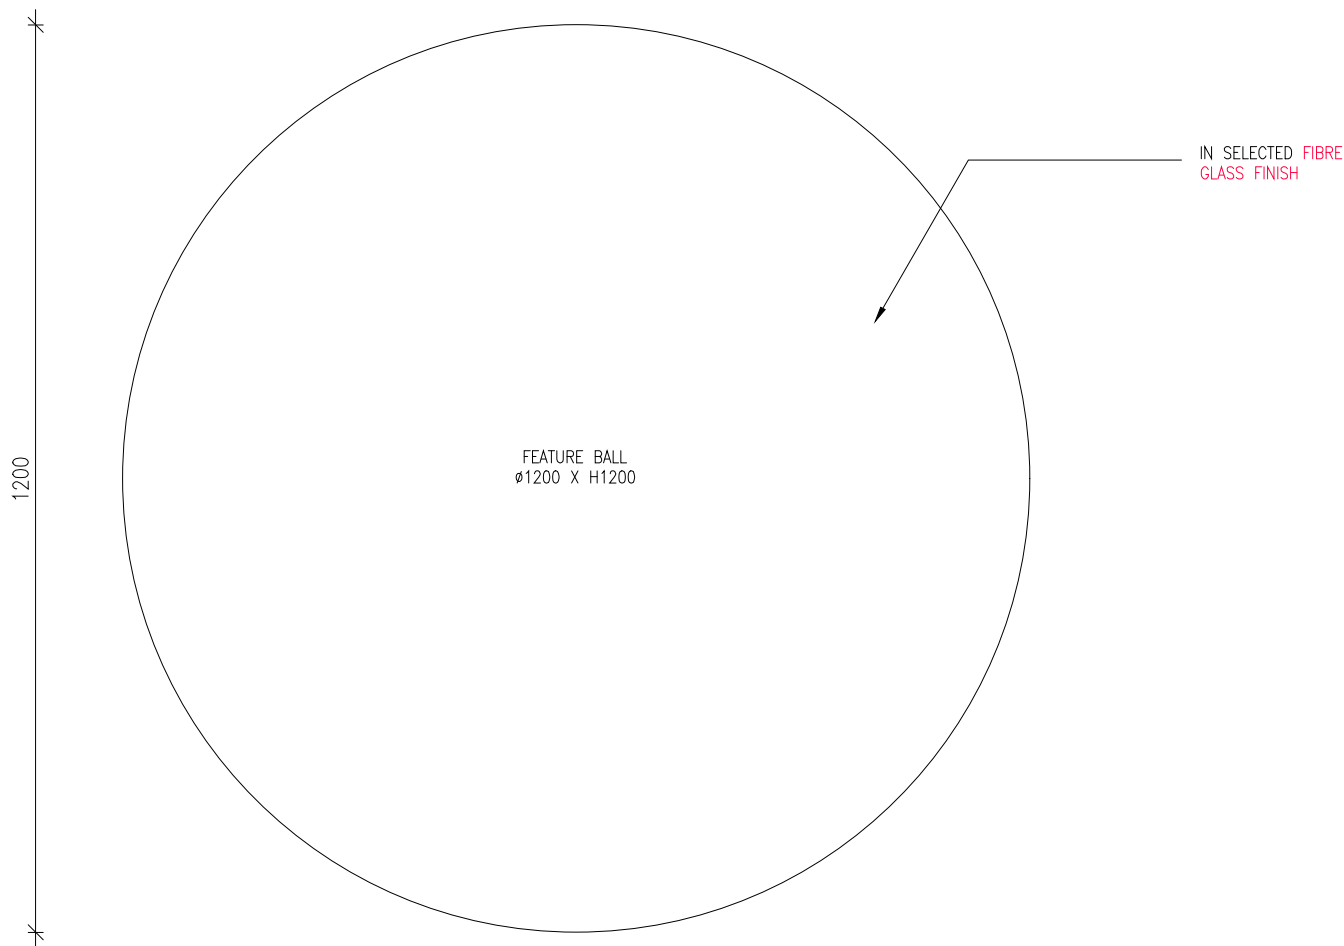

01
206

PHOTO BOOTH - DETAILS

SCALE 1:10

GENERAL NOTES

ALL DIMENSIONS SHOWN ARE IN MILLIMETRES & SHALL BE VERIFIED ON SITE BY THE CONTRACTOR OR SUB-CONTRACTOR.

ALL DIMENSIONS SHOULD NOT BE SCALED FROM THE DRAWING UNLESS OTHERWISE INSTRUCTED. ANY DISCREPANCIES SHALL BE MADE KNOWN TO THE DESIGNER FOR DECISION PRIOR TO PROCEEDING OF THE WORK.


PROJECT TITLE

PROPOSED RENOVATION WORKS TO ROSSA

DRAWING TITLE

PHOTO BOOTH - DETAILS

SCALE	AS SHOWN (@ A3 PRINT)
DATE	JUNE 2021
DRAWN	SZM
FILENAME	-
VERSION	-

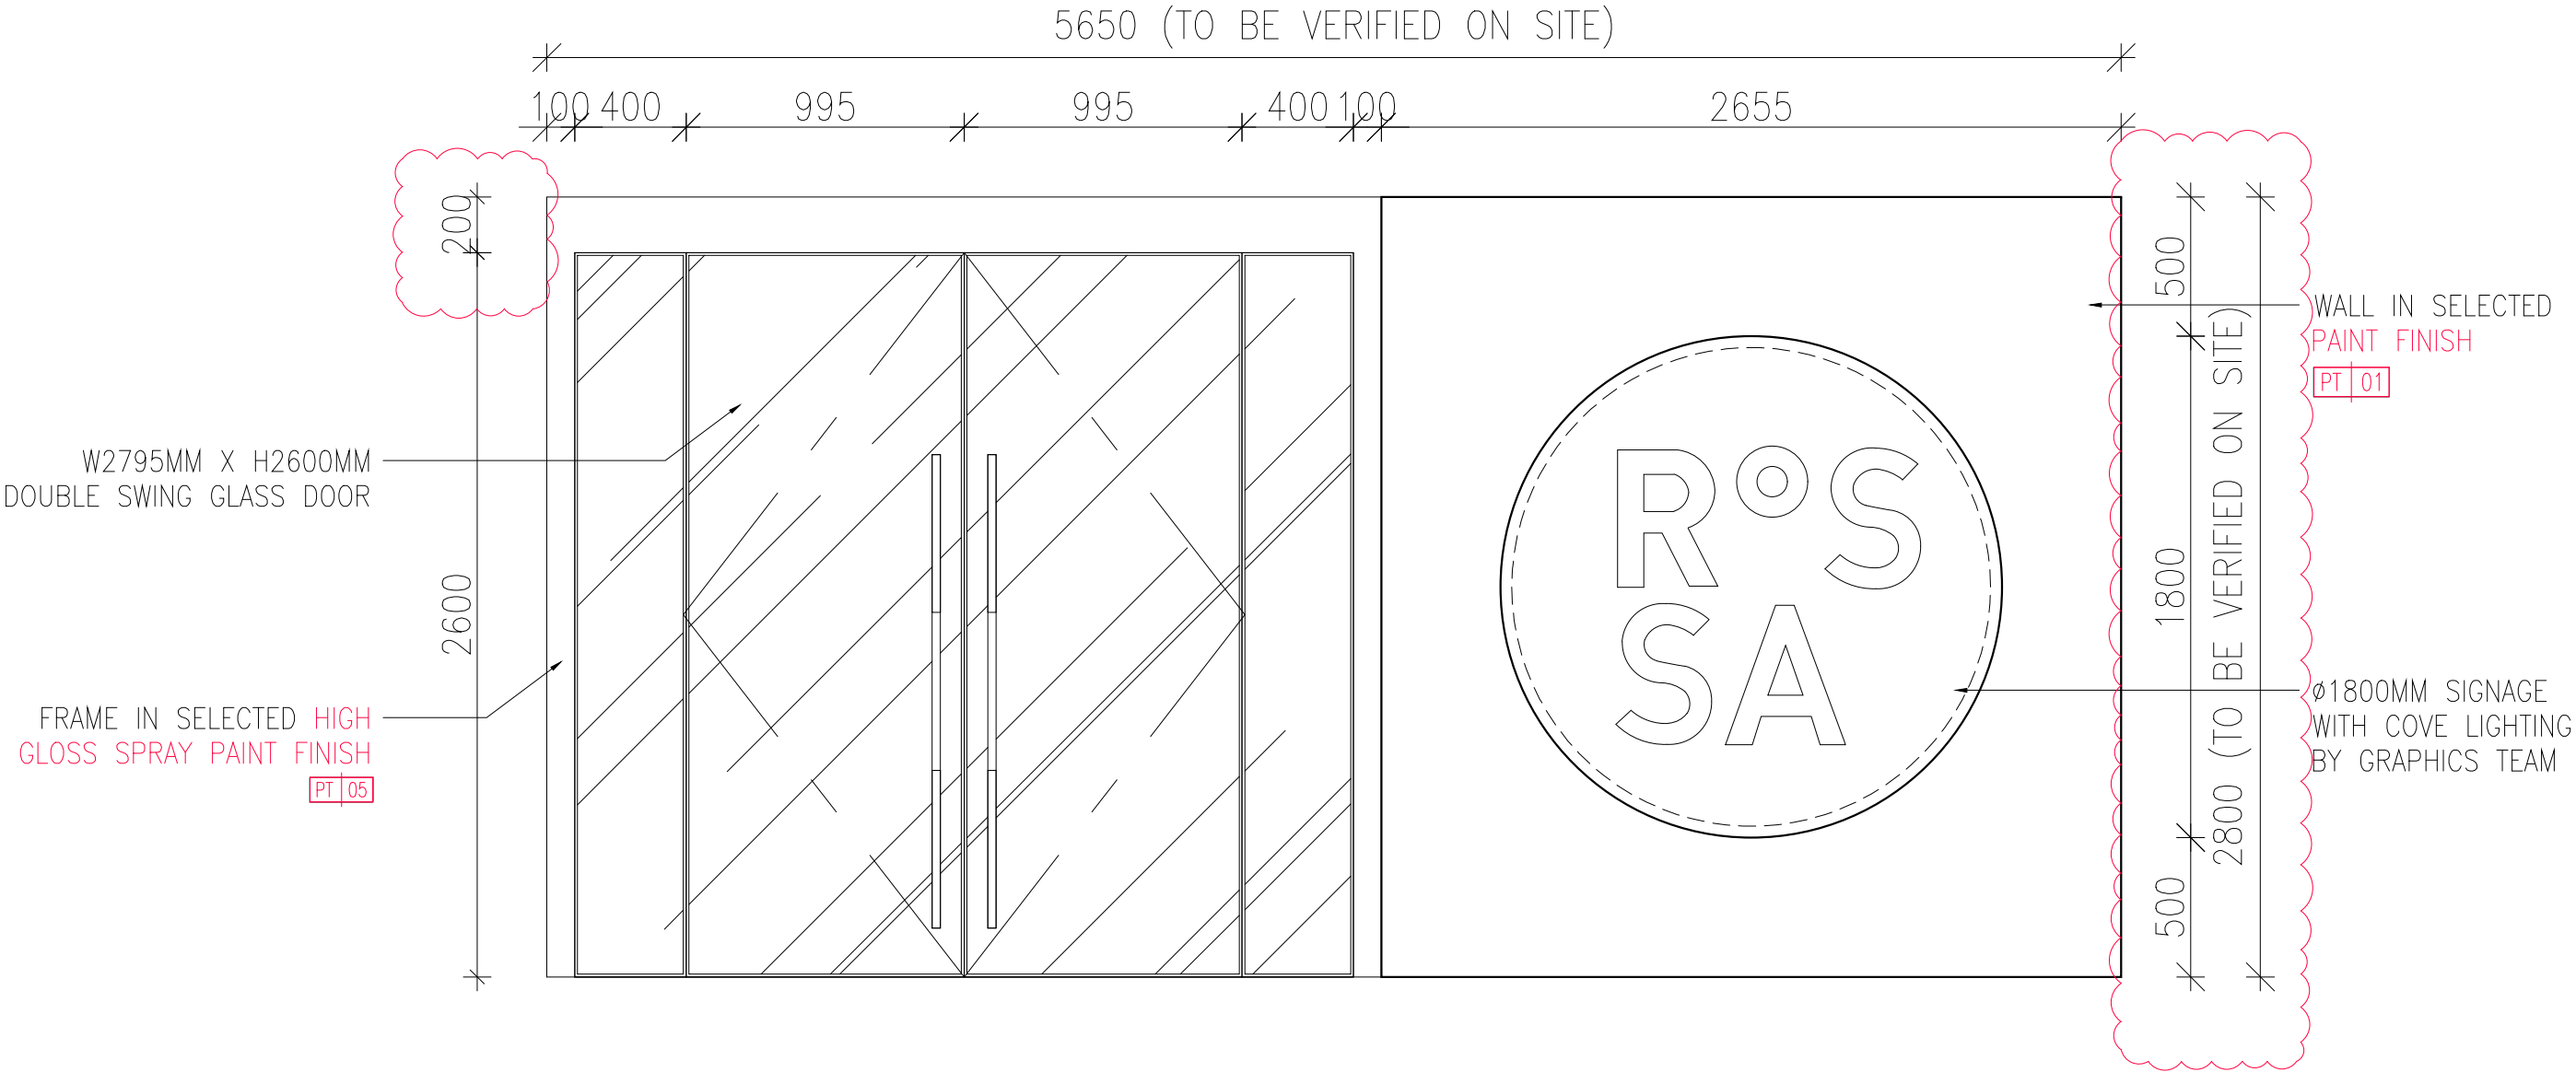

01
207

ENTRANCE - ELEVATION
SCALE 1:25

GENERAL NOTES

ALL DIMENSIONS SHOWN ARE IN MILLIMETRES & SHALL BE VERIFIED ON SITE BY THE CONTRACTOR OR SUB-CONTRACTOR.

ALL DIMENSIONS SHOULD NOT BE SCALED FROM THE DRAWING UNLESS OTHERWISE INSTRUCTED. ANY DISCREPANCIES SHALL BE MADE KNOWN TO THE DESIGNER FOR DECISION PRIOR TO PROCEEDING OF THE WORK.

PROJECT TITLE

PROPOSED RENOVATION WORKS TO
ROSSA

DRAWING TITLE


ENTRANCE - ELEVATION

SCALE	AS SHOWN (@ A3 PRINT)
DATE	01 SEPT 2021
DRAWN	SY
FILENAME	-
VERSION	B


OFCHITOL
(PRIVATE) LIMITED

DRAWING NO.

207

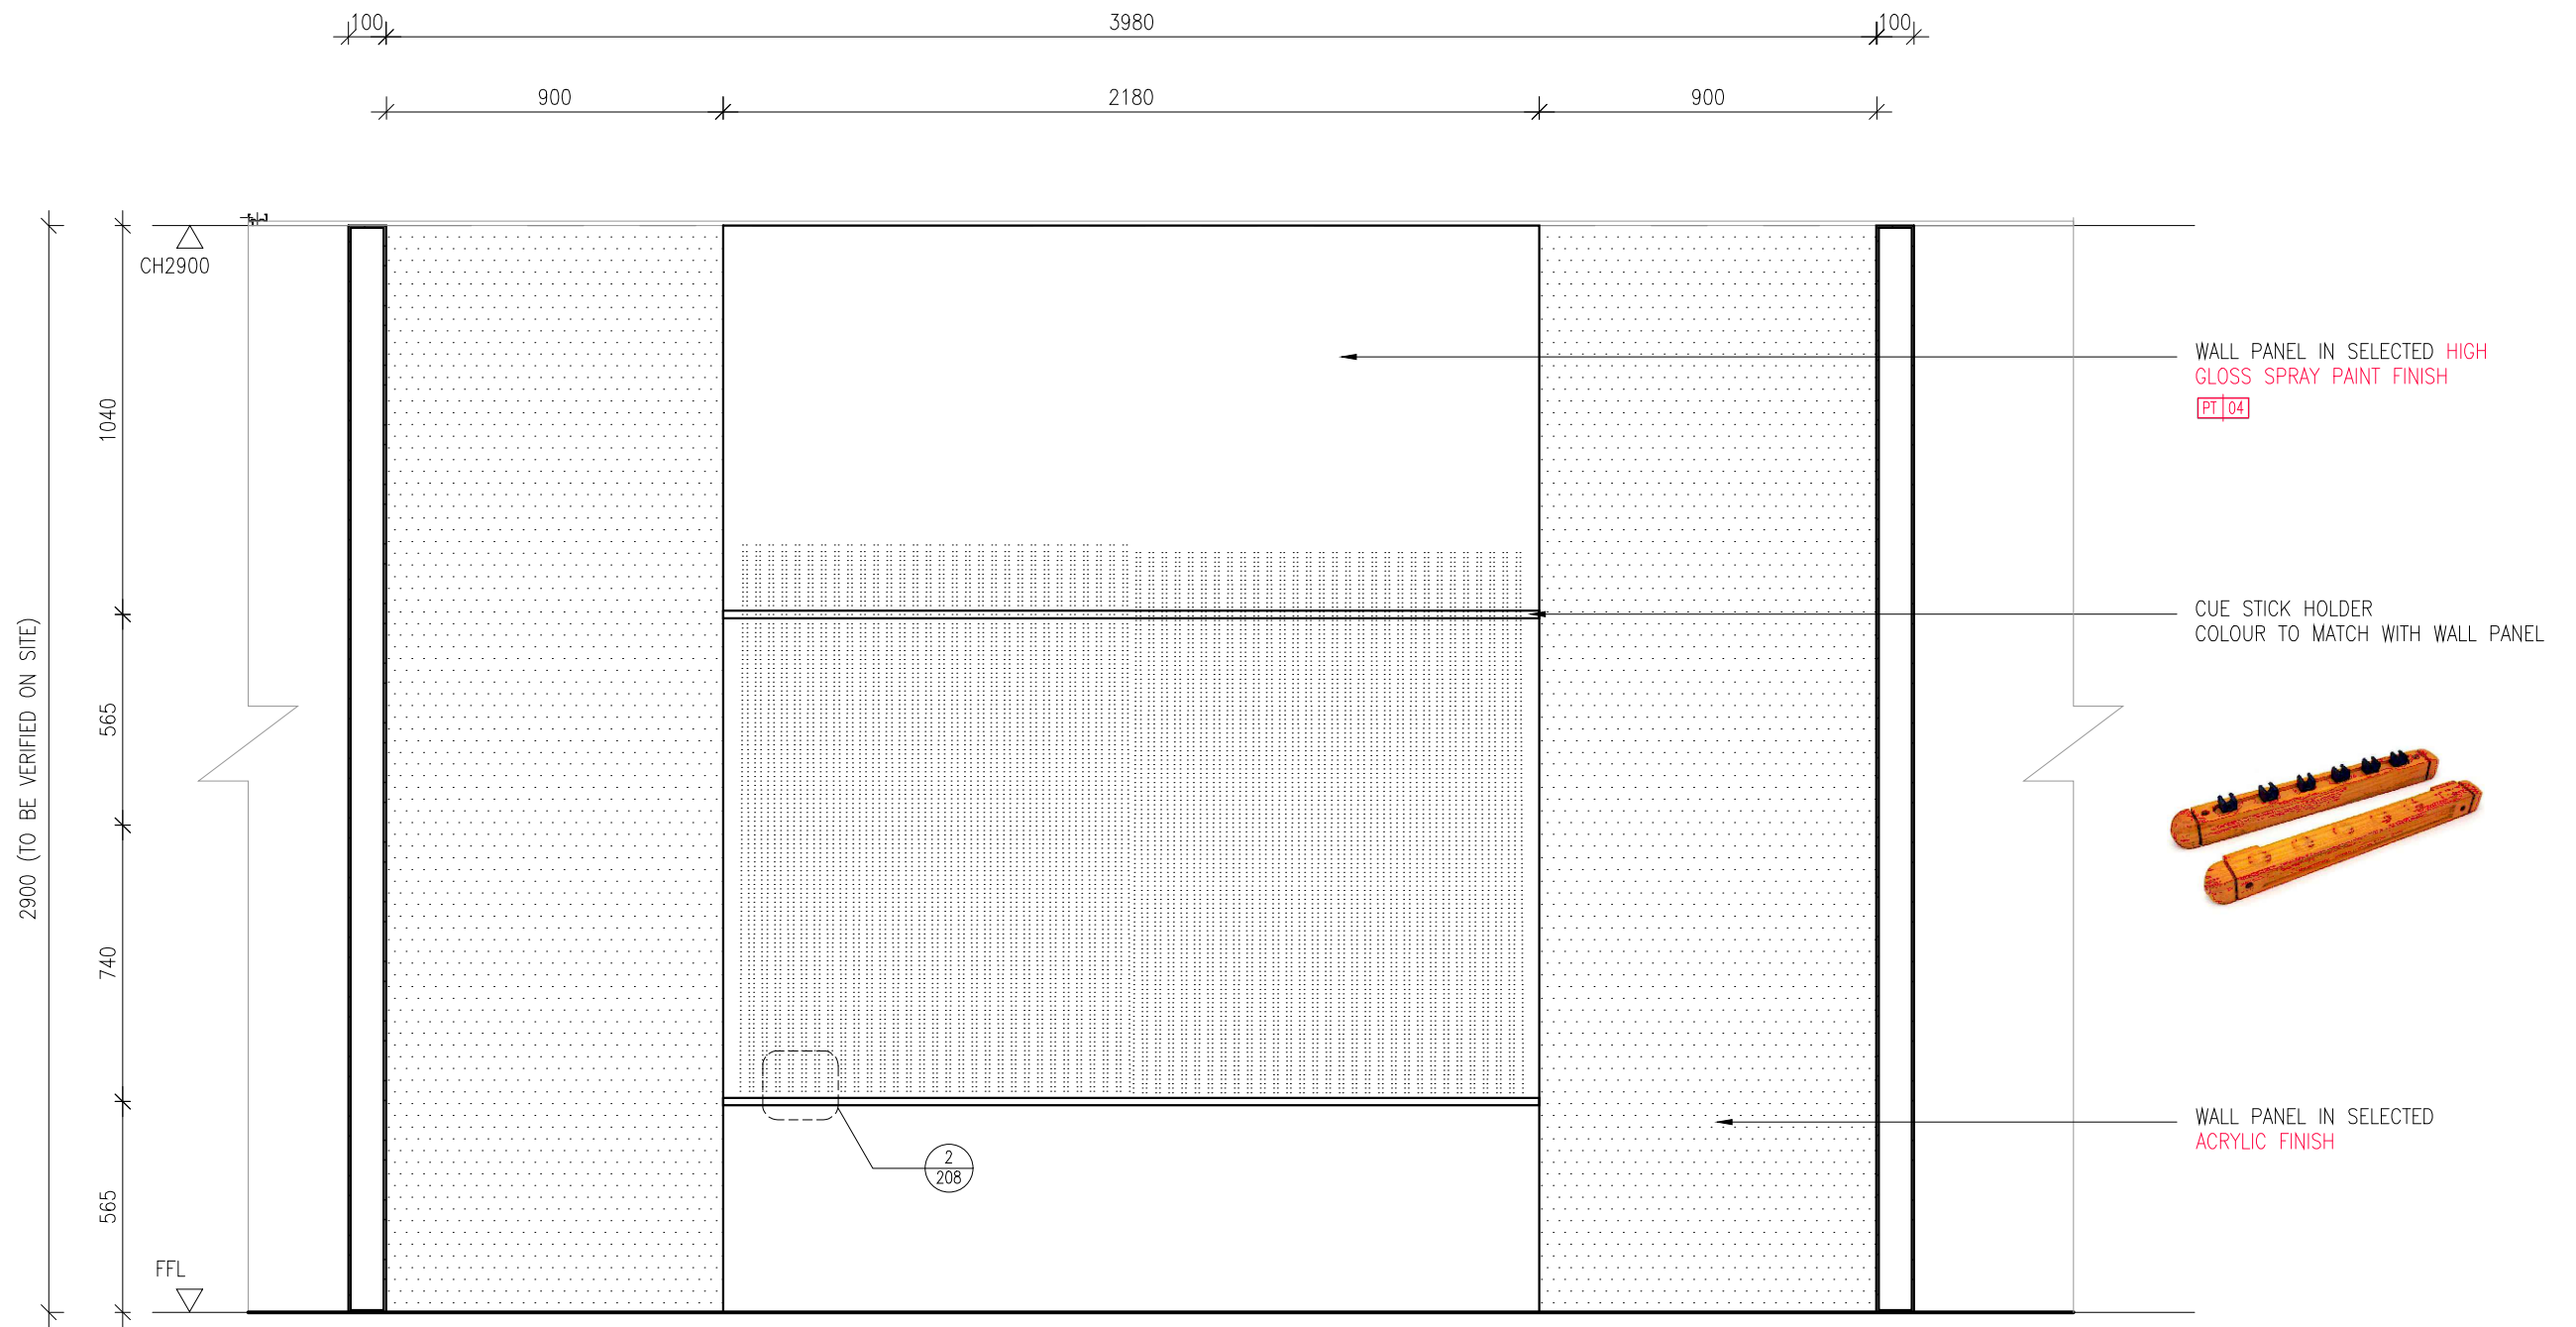

01
208
RECEPTION - ELEVATION 5
SCALE 1:20

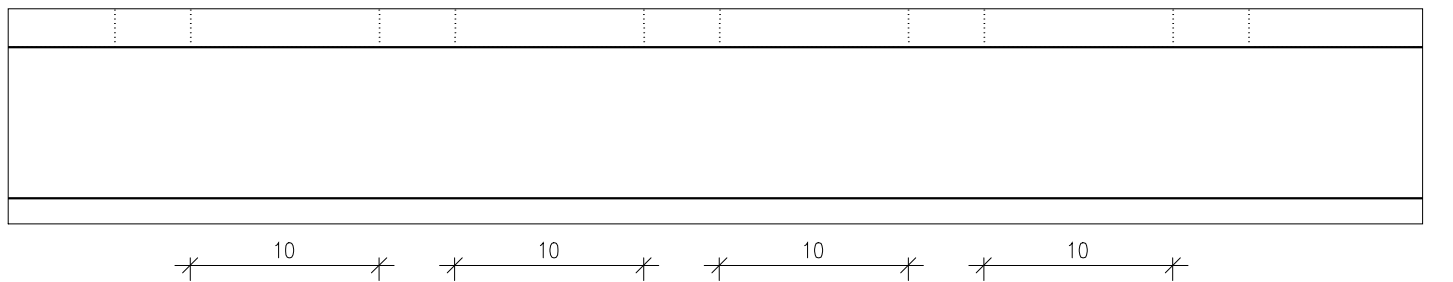

02
208
DETAIL
SCALE 1:1

GENERAL NOTES

ALL DIMENSIONS SHOWN ARE IN MILLIMETRES & SHALL BE VERIFIED ON SITE BY THE CONTRACTOR OR SUB-CONTRACTOR.
ALL DIMENSIONS SHOULD NOT BE SCALED FROM THE DRAWING UNLESS OTHERWISE INSTRUCTED. ANY DISCREPANCIES SHALL BE MADE KNOWN TO THE DESIGNER FOR DECISION PRIOR TO PROCEEDING OF THE WORK.

PROJECT TITLE

PROPOSED RENOVATION WORKS TO
ROSSA

DRAWING TITLE

RECEPTION - ELEVATION 5

SCALE

AS SHOWN (@ A3 PRINT)

DATE

31 AUG 2021

DRAWN

SY

FILENAME

-


VERSION

D


OTCHITOLOGY
(PRIVATE) LIMITED

DRAWING NO.


208

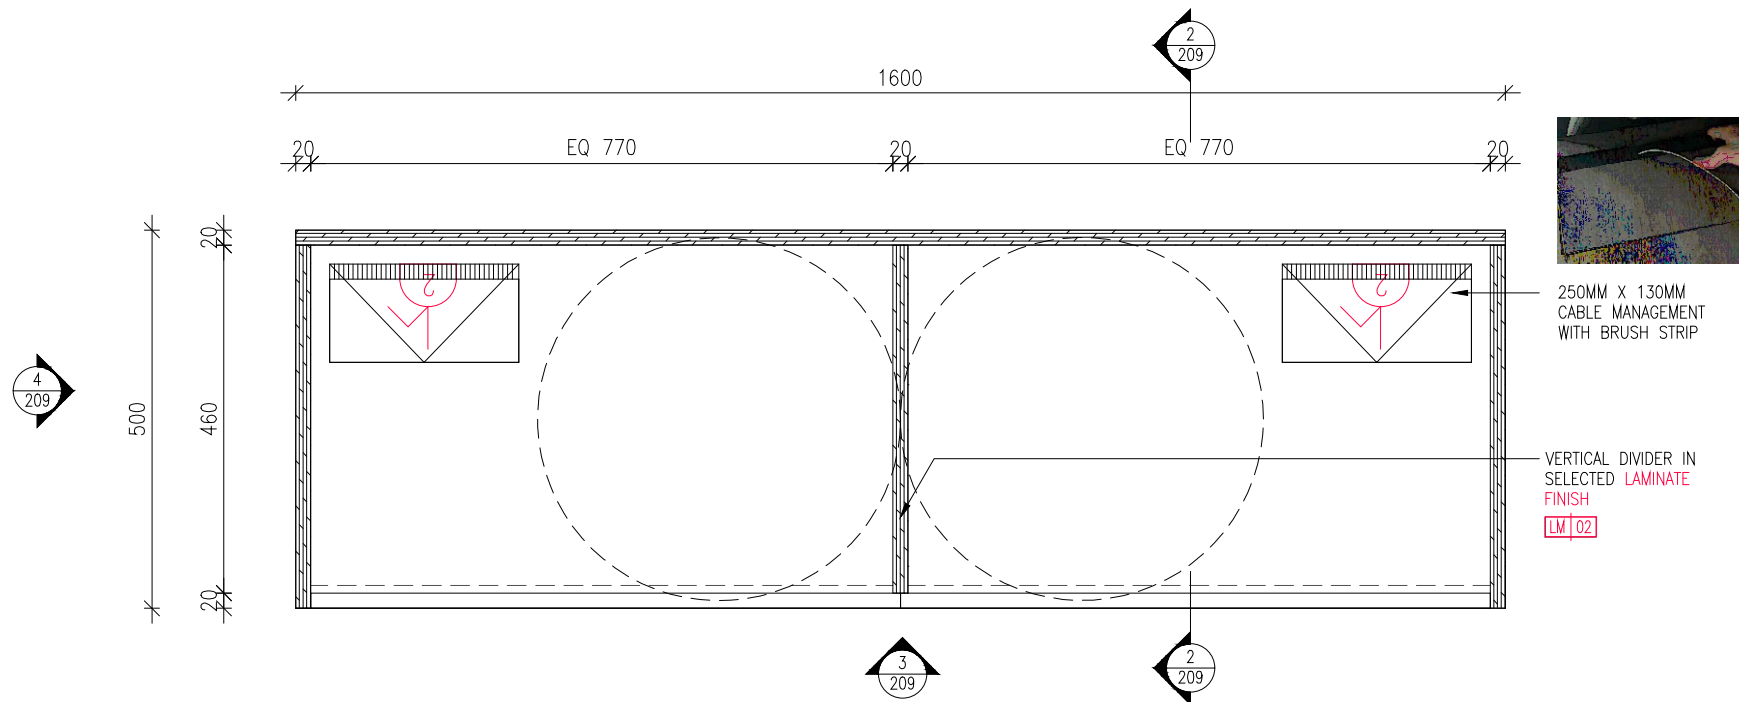


01 BILLIARD BALL CLEANER CABINET - PLAN
209 SCALE 1:10

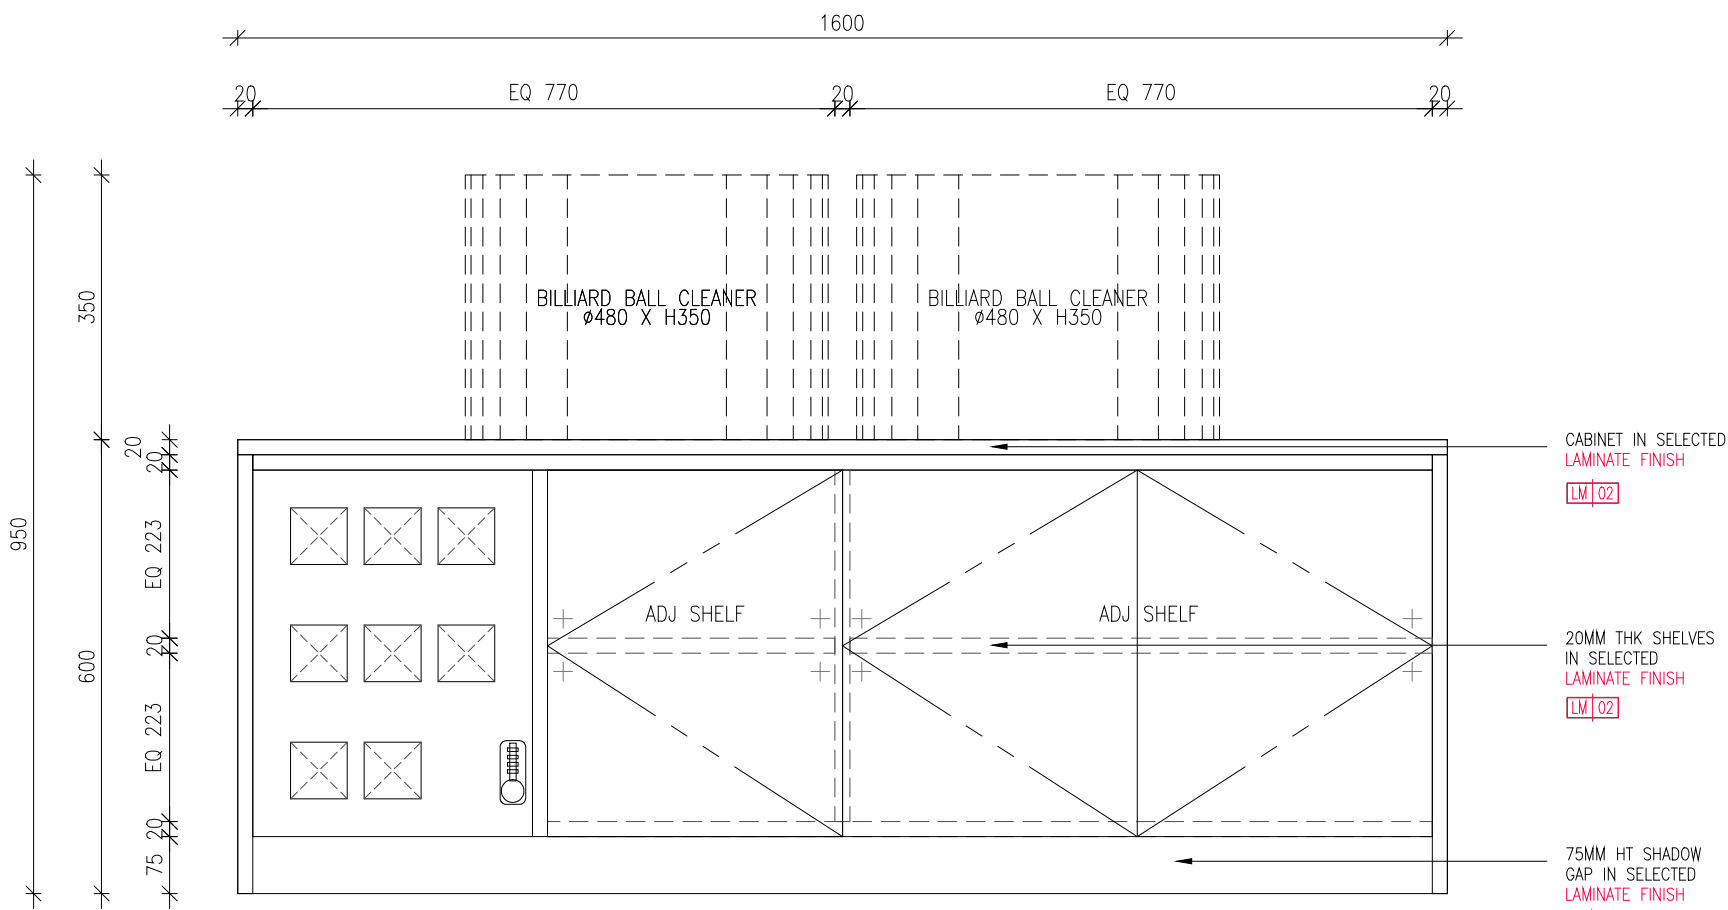

03 BILLIARD BALL CLEANER CABINET - FRONT
209 SCALE 1:10

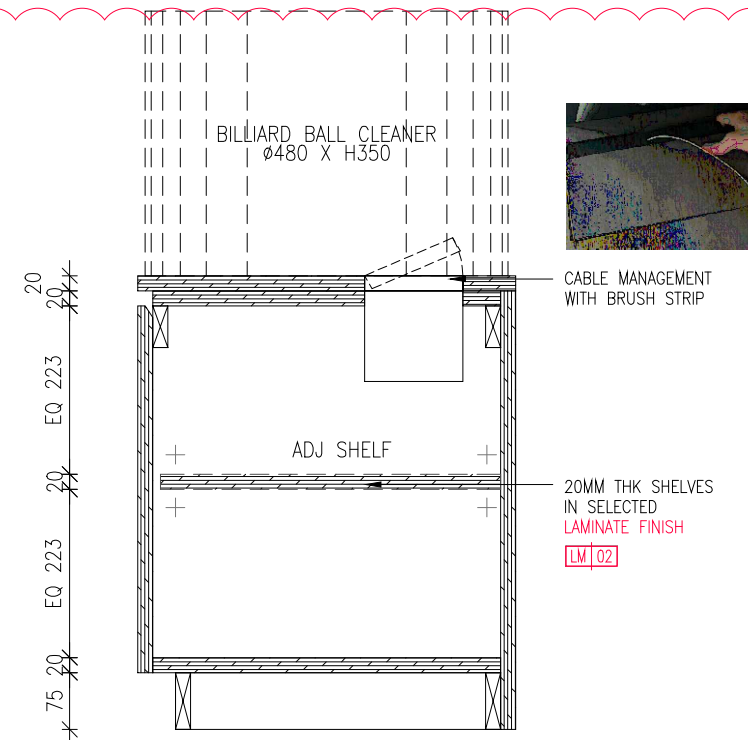

02 BILLIARD BALL CLEANER CABINET - SECTION
209 SCALE 1:10

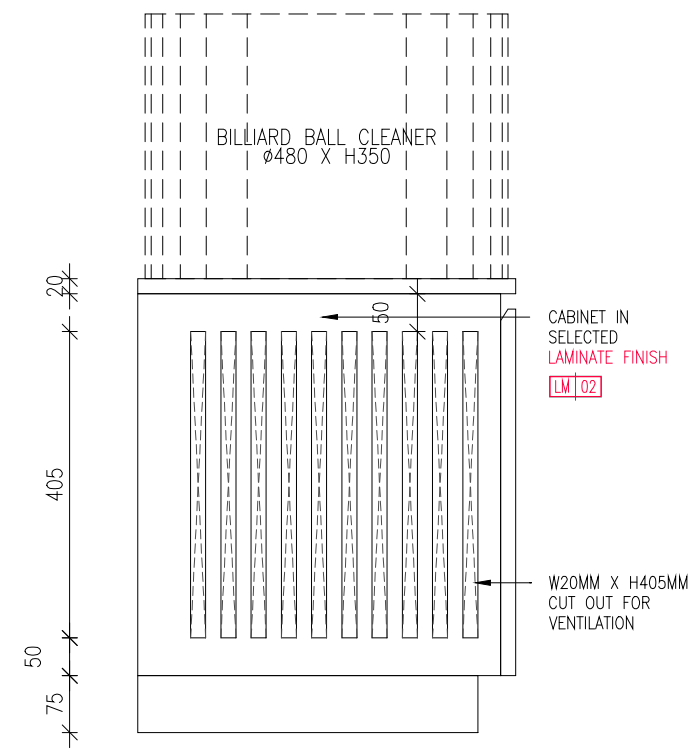

04 CABINET - SIDE ELEVATION
209 SCALE 1:5

GENERAL NOTES

ALL DIMENSIONS SHOWN ARE IN MILLIMETRES & SHALL BE VERIFIED ON SITE BY THE CONTRACTOR OR SUB-CONTRACTOR. ALL DIMENSIONS SHOULD NOT BE SCALED FROM THE DRAWING UNLESS OTHERWISE INSTRUCTED. ANY DISCREPANCIES SHALL BE MADE KNOWN TO THE DESIGNER FOR DECISION PRIOR TO PROCEEDING OF THE WORK.

PROJECT TITLE

PROPOSED RENOVATION WORKS TO ROSSA

DRAWING TITLE

BILLIARD BALL CLEANER CABINET - DETAIL

SCALE AS SHOWN (@ A3 PRINT)

DATE 31 AUG 2021


DRAWN SY

FILENAME -


VERSION -

ORCHITOLGY
(PRIVATE) LIMITED

DRAWING NO. 209

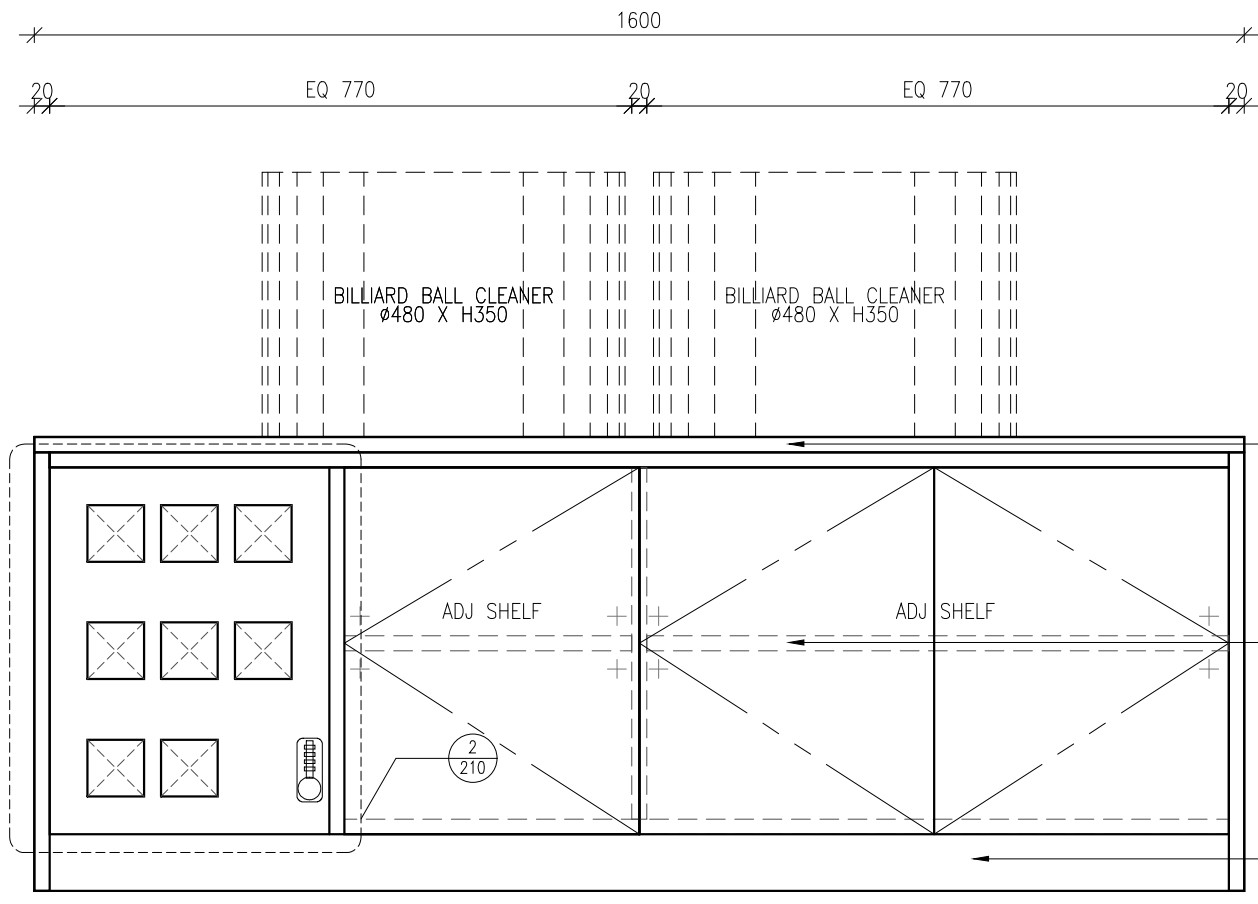

01 BILLIARD BALL CLEANER CABINET - FRONT
210 SCALE 1:10

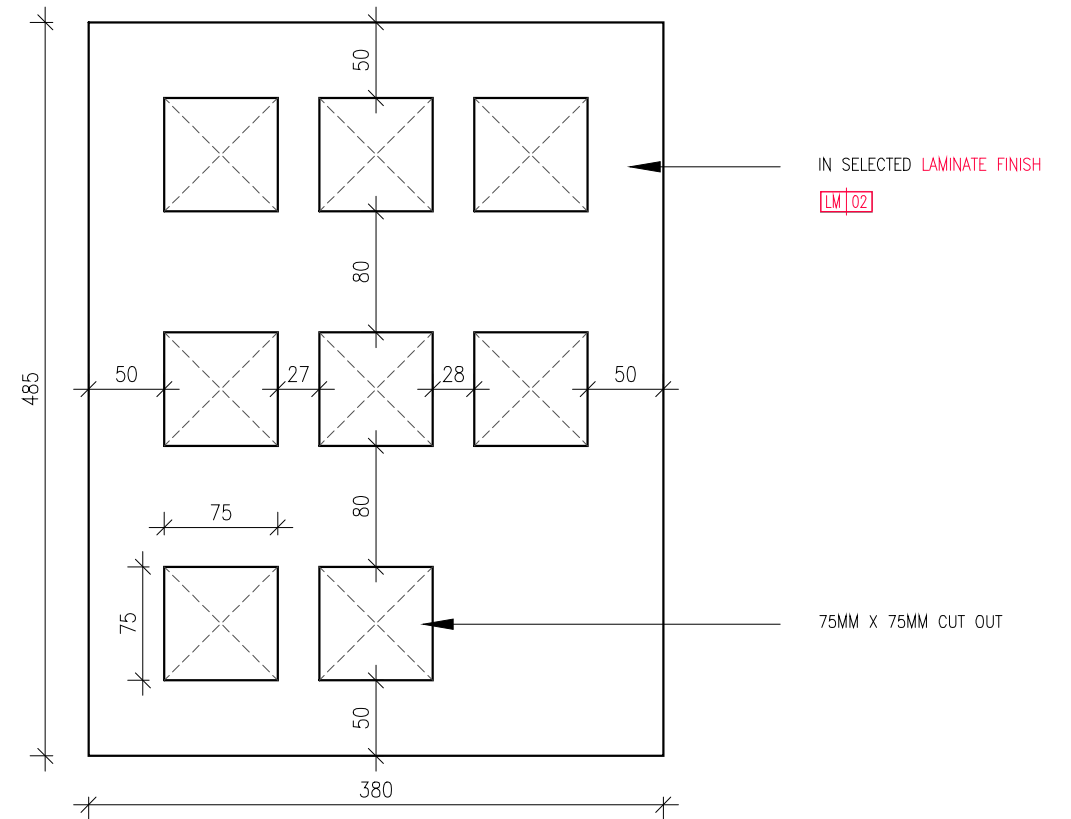

02 PANEL FOR BYPASS SWITCH DETAIL
210 SCALE 1:5

GENERAL NOTES

ALL DIMENSIONS SHOWN ARE IN MILLIMETRES & SHALL BE VERIFIED ON SITE BY THE CONTRACTOR OR SUB-CONTRACTOR.

ALL DIMENSIONS SHOULD NOT BE SCALED FROM THE DRAWING UNLESS OTHERWISE INSTRUCTED. ANY DISCREPANCIES SHALL BE MADE KNOWN TO THE DESIGNER FOR DECISION PRIOR TO PROCEEDING OF THE WORK.

PROJECT TITLE

PROPOSED RENOVATION WORKS TO ROSSA

DRAWING TITLE

BILLIARD BALL CLEANER CABINET - DETAIL

SCALE AS SHOWN (@ A3 PRINT)

DATE 31 AUG 2021


DRAWN SY

FILENAME -


VERSION -

ORCHITOLGY
(PRIVATE) LIMITED


DRAWING NO. 210

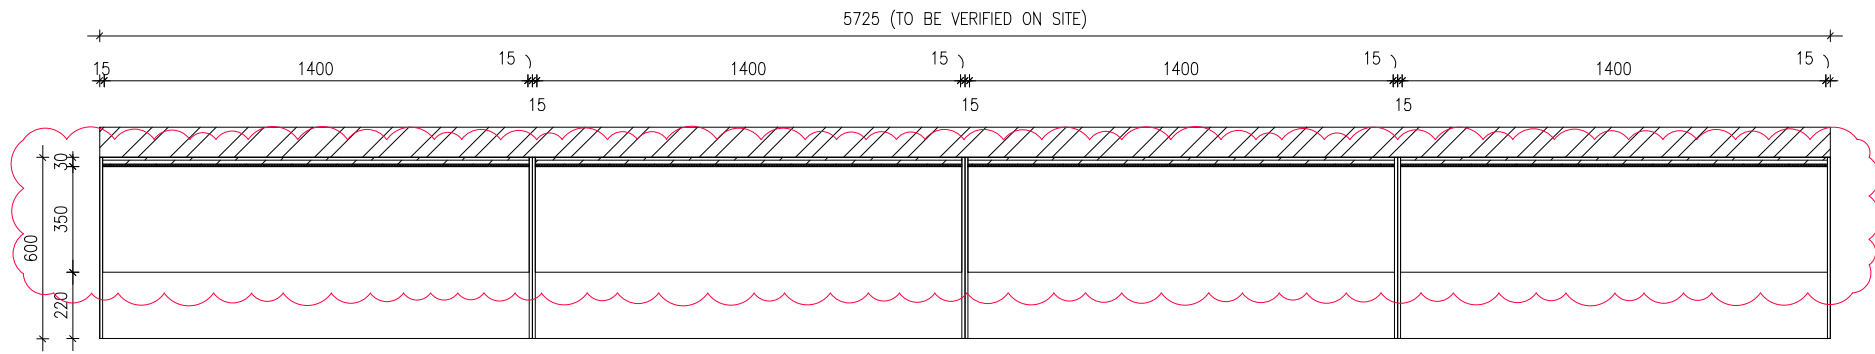

01
300
MERCHANDISE DISPLAY - PART PLAN
SCALE 1:25

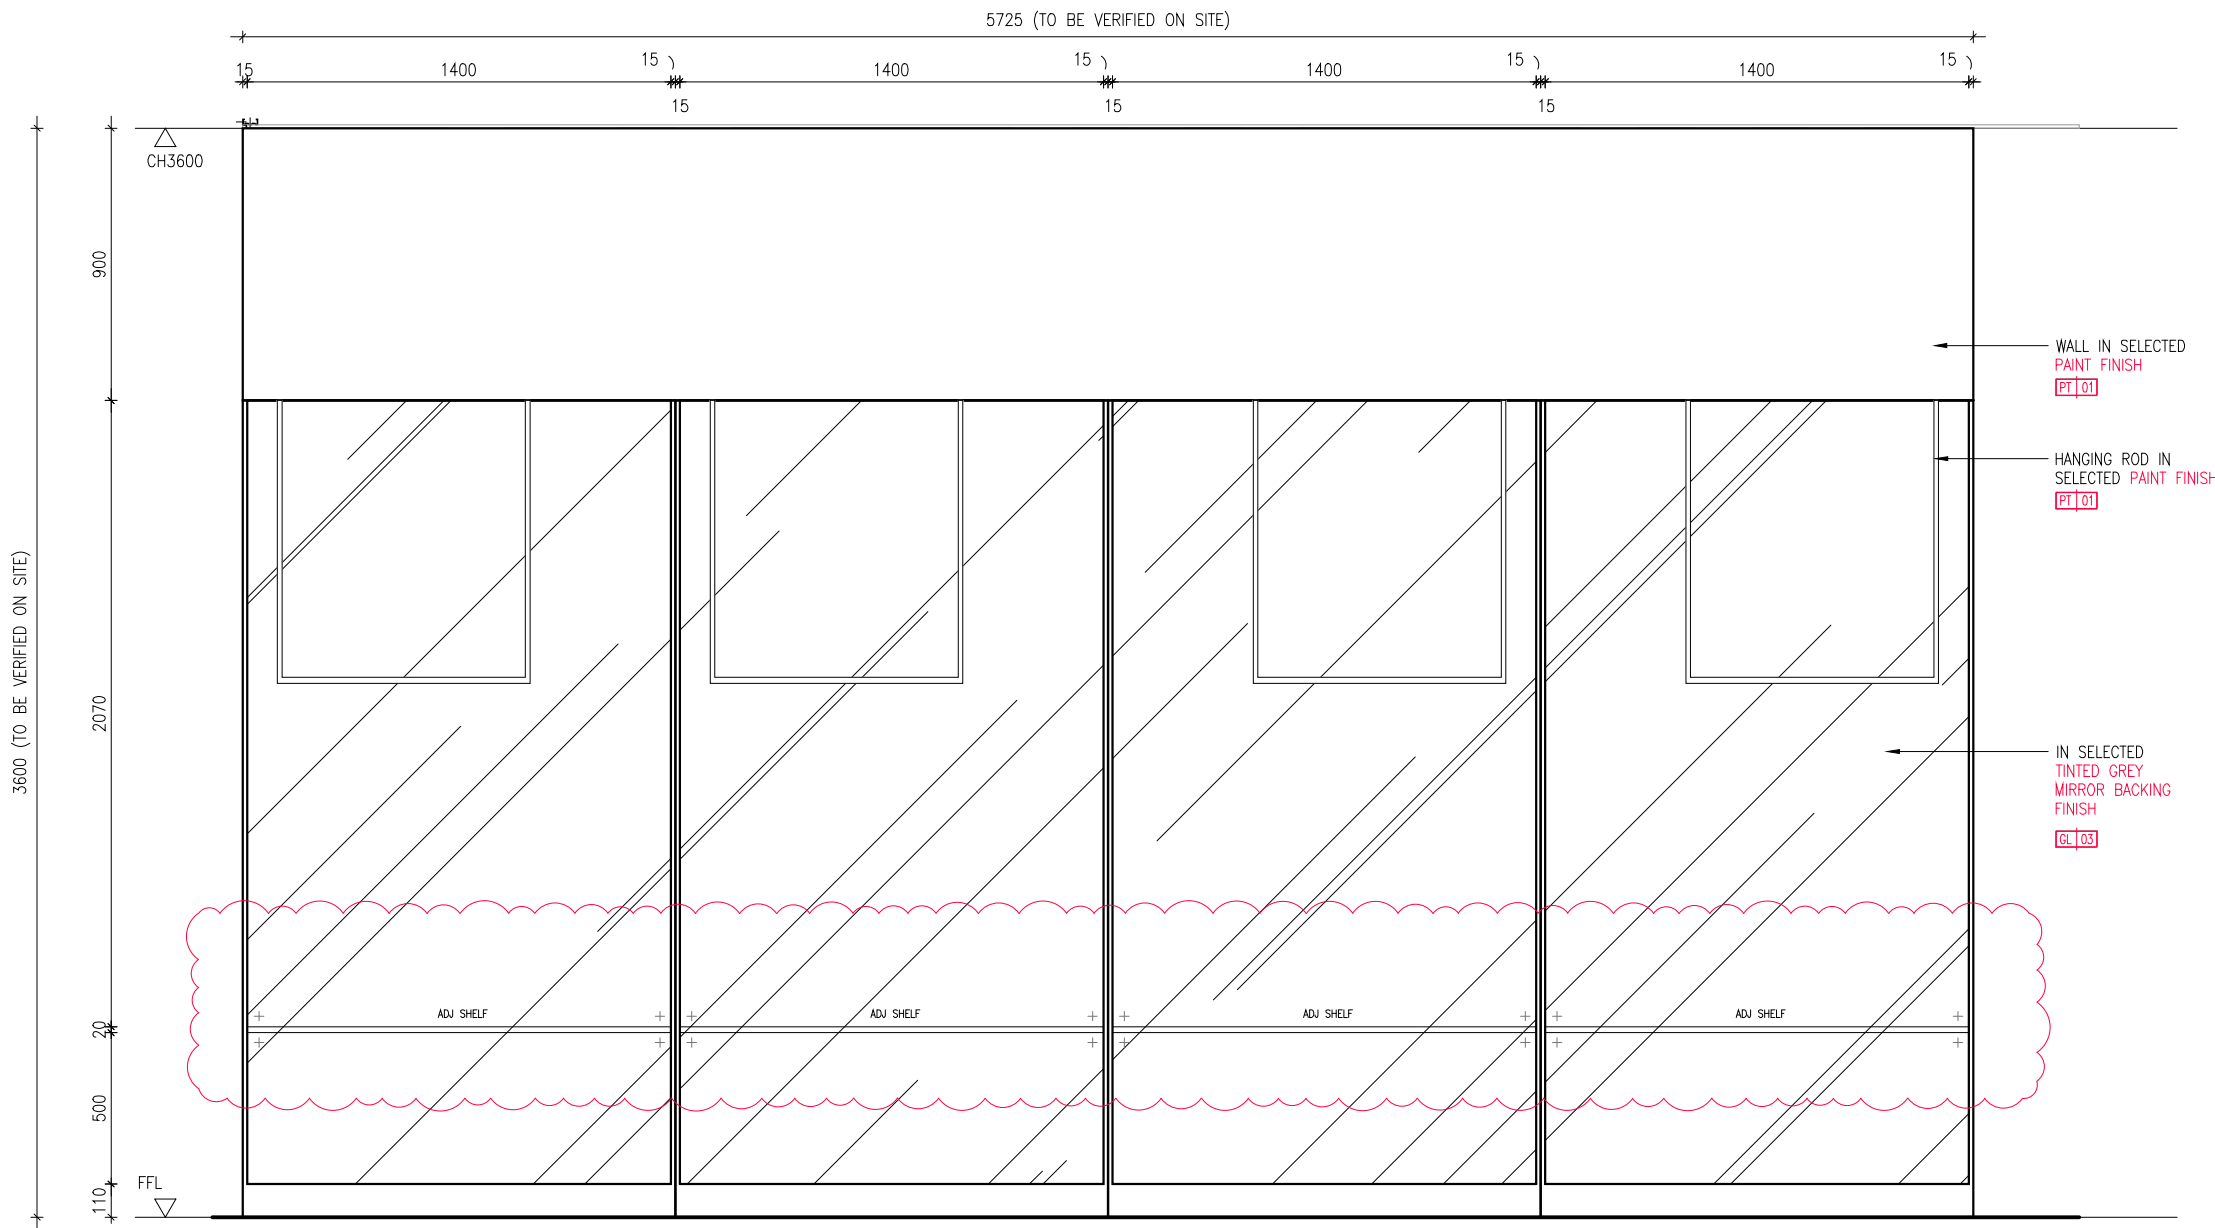

02
300
MERCHANDISE DISPLAY - ELEVATION
SCALE 1:25

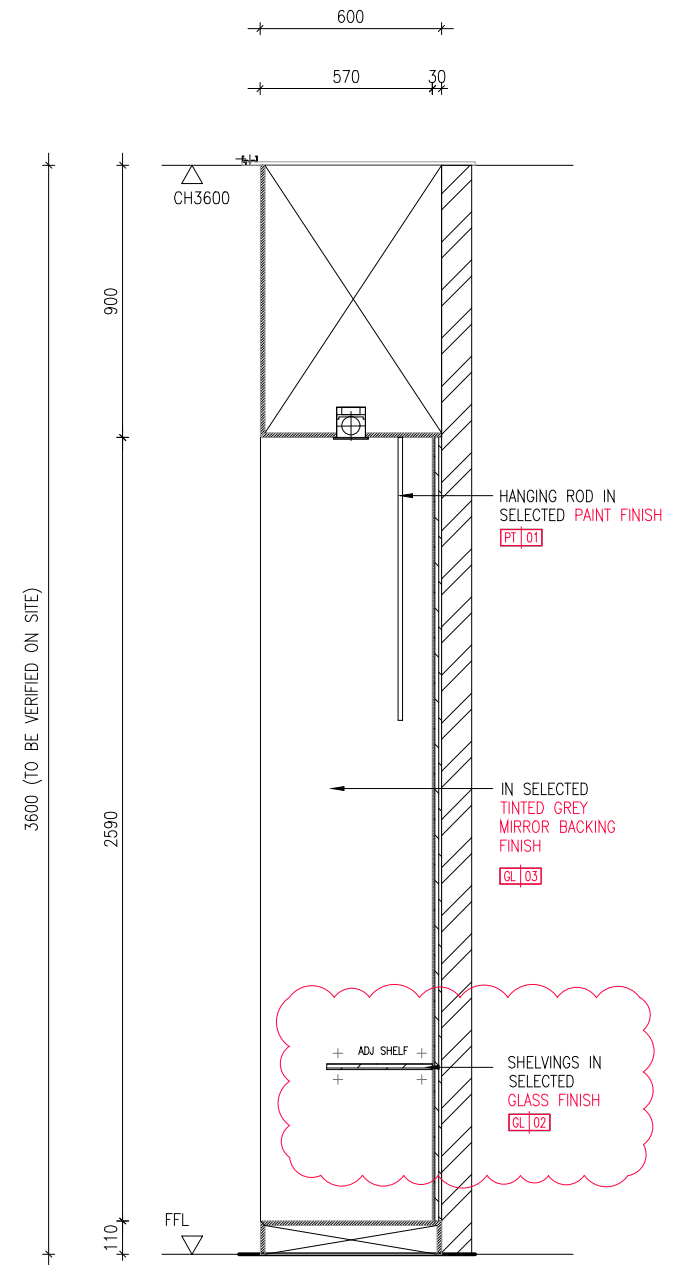

03
300
MERCHANDISE DISPLAY - SECTION
SCALE 1:25

GENERAL NOTES

ALL DIMENSIONS SHOWN ARE IN MILLIMETRES & SHALL BE VERIFIED ON SITE BY THE CONTRACTOR OR SUB-CONTRACTOR.

ALL DIMENSIONS SHOULD NOT BE SCALED FROM THE DRAWING UNLESS OTHERWISE INSTRUCTED. ANY DISCREPANCIES SHALL BE MADE KNOWN TO THE DESIGNER FOR DECISION PRIOR TO PROCEEDING OF THE WORK.

PROJECT TITLE

PROPOSED RENOVATION WORKS TO ROSSA

DRAWING TITLE

MERCHANDISE DISPLAY

SCALE AS SHOWN (@ A3 PRINT)

DATE 31 AUG 2021

DRAWN SZM


FILENAME -

VERSION C

ORCHITOLGY
(PRIVATE) LIMITED


DRAWING NO. 300

PEDESTAL B

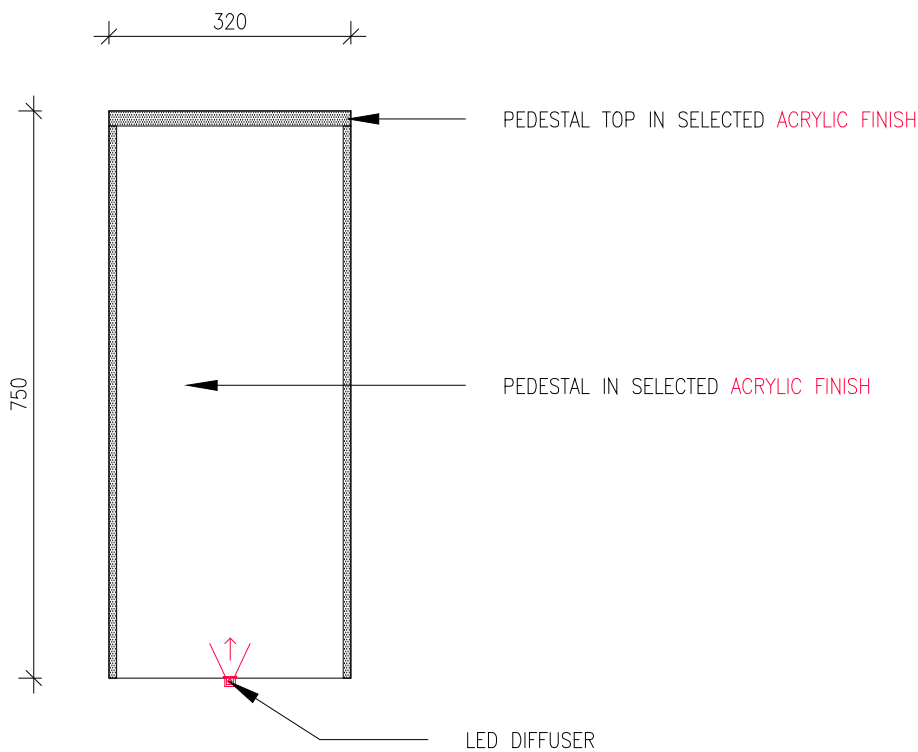


01
301 STAIRCASE PEDESTAL B - ELEVATION
SCALE 1:10


PEDESTAL D

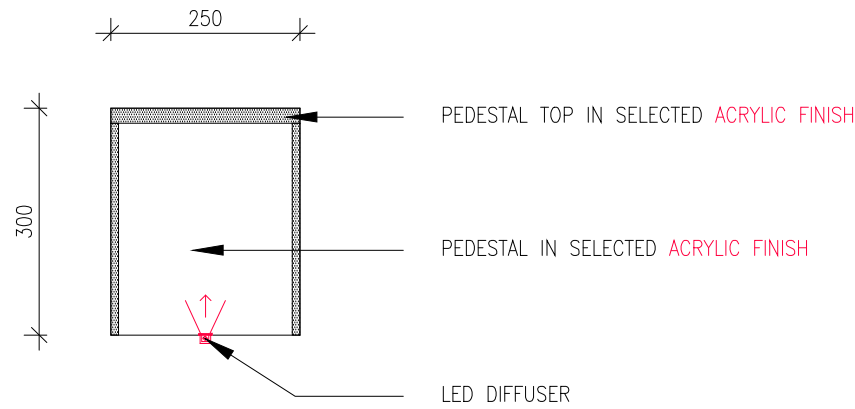

02
301 STAIRCASE PEDESTAL D - ELEVATION
SCALE 1:10

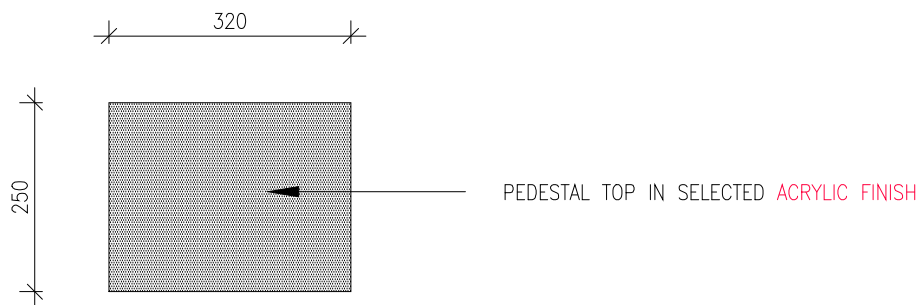

03
301 STAIRCASE PEDESTAL B - PLAN
SCALE 1:10

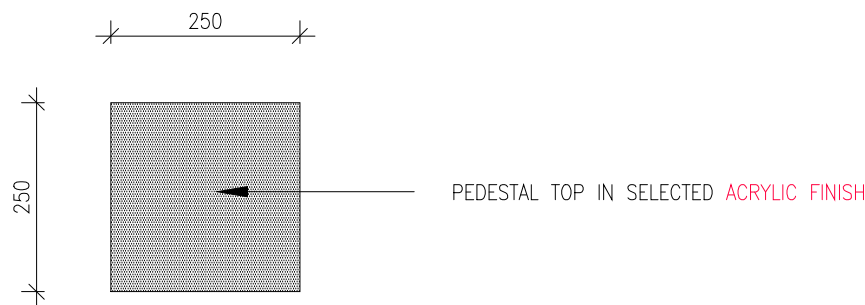

04
301 STAIRCASE PEDESTAL D - PLAN
SCALE 1:10

GENERAL NOTES

ALL DIMENSIONS SHOWN ARE IN MILLIMETRES & SHALL BE VERIFIED ON SITE BY THE CONTRACTOR OR SUB-CONTRACTOR.

ALL DIMENSIONS SHOULD NOT BE SCALED FROM THE DRAWING UNLESS OTHERWISE INSTRUCTED. ANY DISCREPANCIES SHALL BE MADE KNOWN TO THE DESIGNER FOR DECISION PRIOR TO PROCEEDING OF THE WORK.

PROJECT TITLE

PROPOSED RENOVATION WORKS TO ROSSA


DRAWING TITLE

STAIRCASE - PEDESTAL DETAIL

SCALE	AS SHOWN (@ A3 PRINT)
DATE	31 AUG 2021
DRAWN	SY
FILENAME	-
VERSION	B

ORCHITOLOGY
(PRIVATE) LIMITED

DRAWING NO. 301

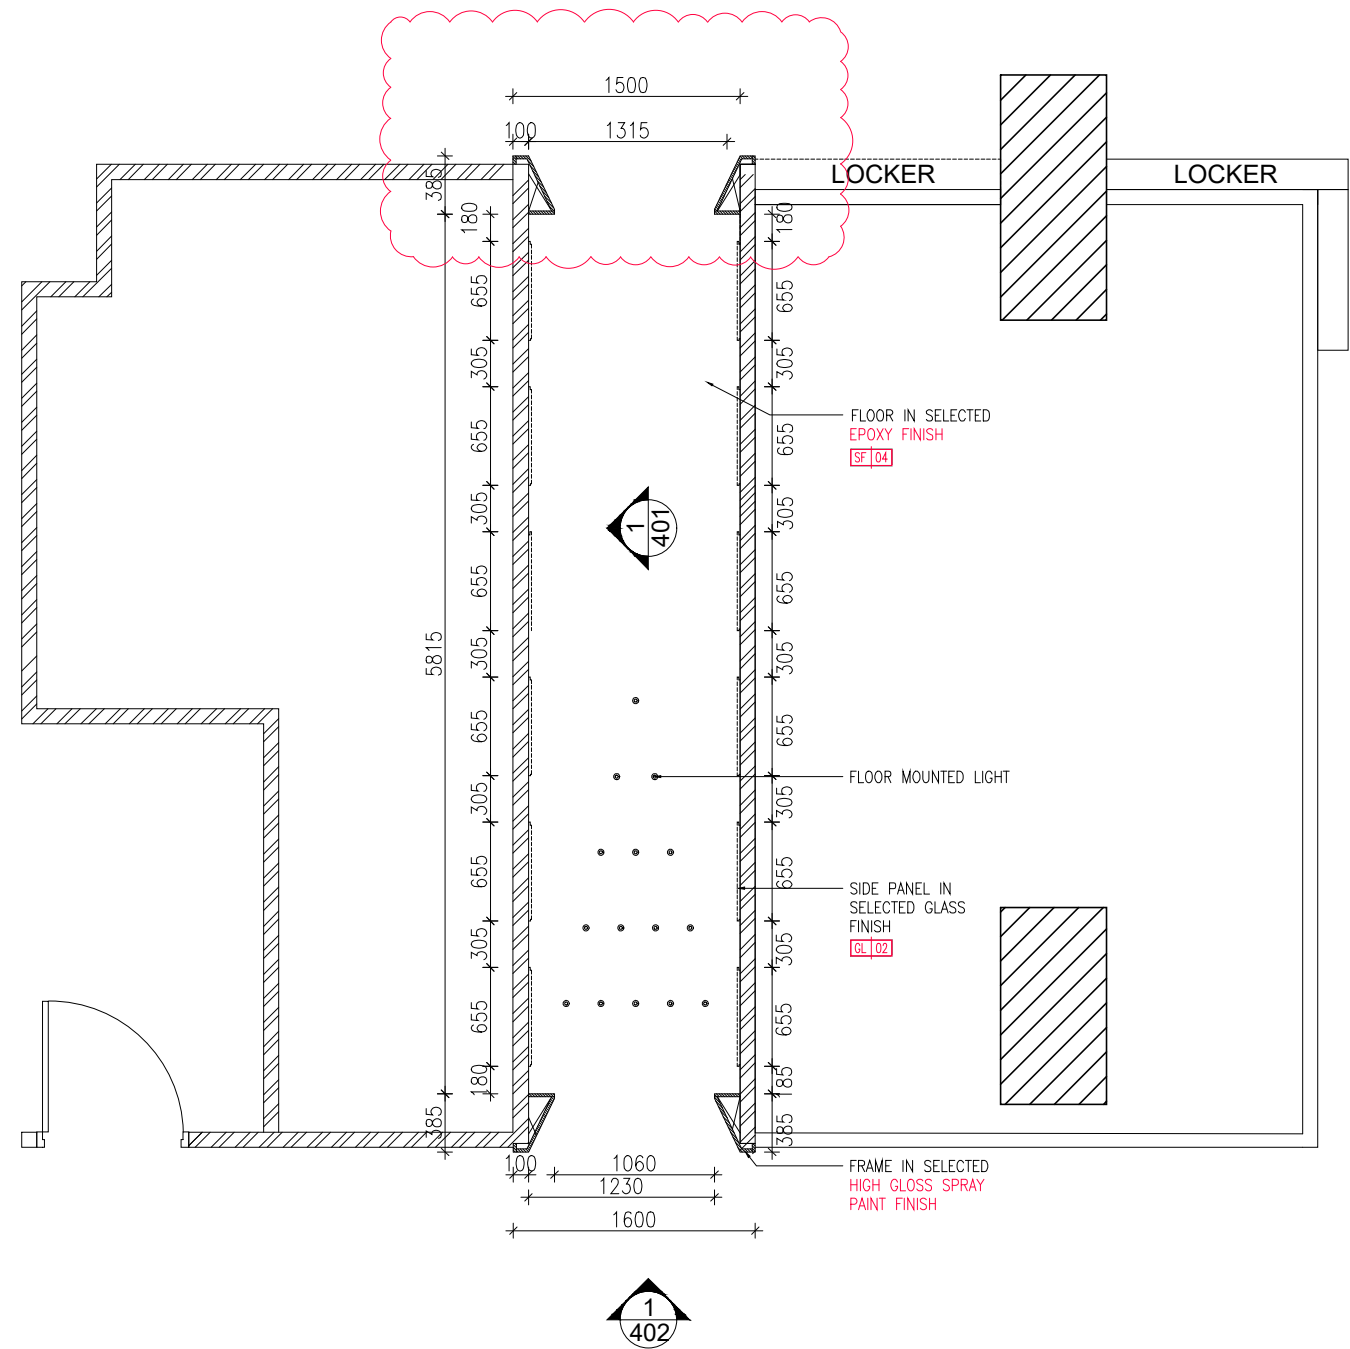

01
400

INSTAGRAM CORNER - PART PLAN
SCALE 1:50

GENERAL NOTES

ALL DIMENSIONS SHOWN ARE IN MILLIMETRES & SHALL BE VERIFIED ON SITE BY THE CONTRACTOR OR SUB-CONTRACTOR. ALL DIMENSIONS SHOULD NOT BE SCALED FROM THE DRAWING UNLESS OTHERWISE INSTRUCTED. ANY DISCREPANCIES SHALL BE MADE KNOWN TO THE DESIGNER FOR DECISION PRIOR TO PROCEEDING OF THE WORK.


PROJECT TITLE

PROPOSED RENOVATION WORKS TO ROSSA

DRAWING TITLE

INSTAGRAM CORNER - PART PLAN

SCALE	AS SHOWN (@ A3 PRINT)
DATE	08 SEPT 2021
DRAWN	KB
FILENAME	-
VERSION	A

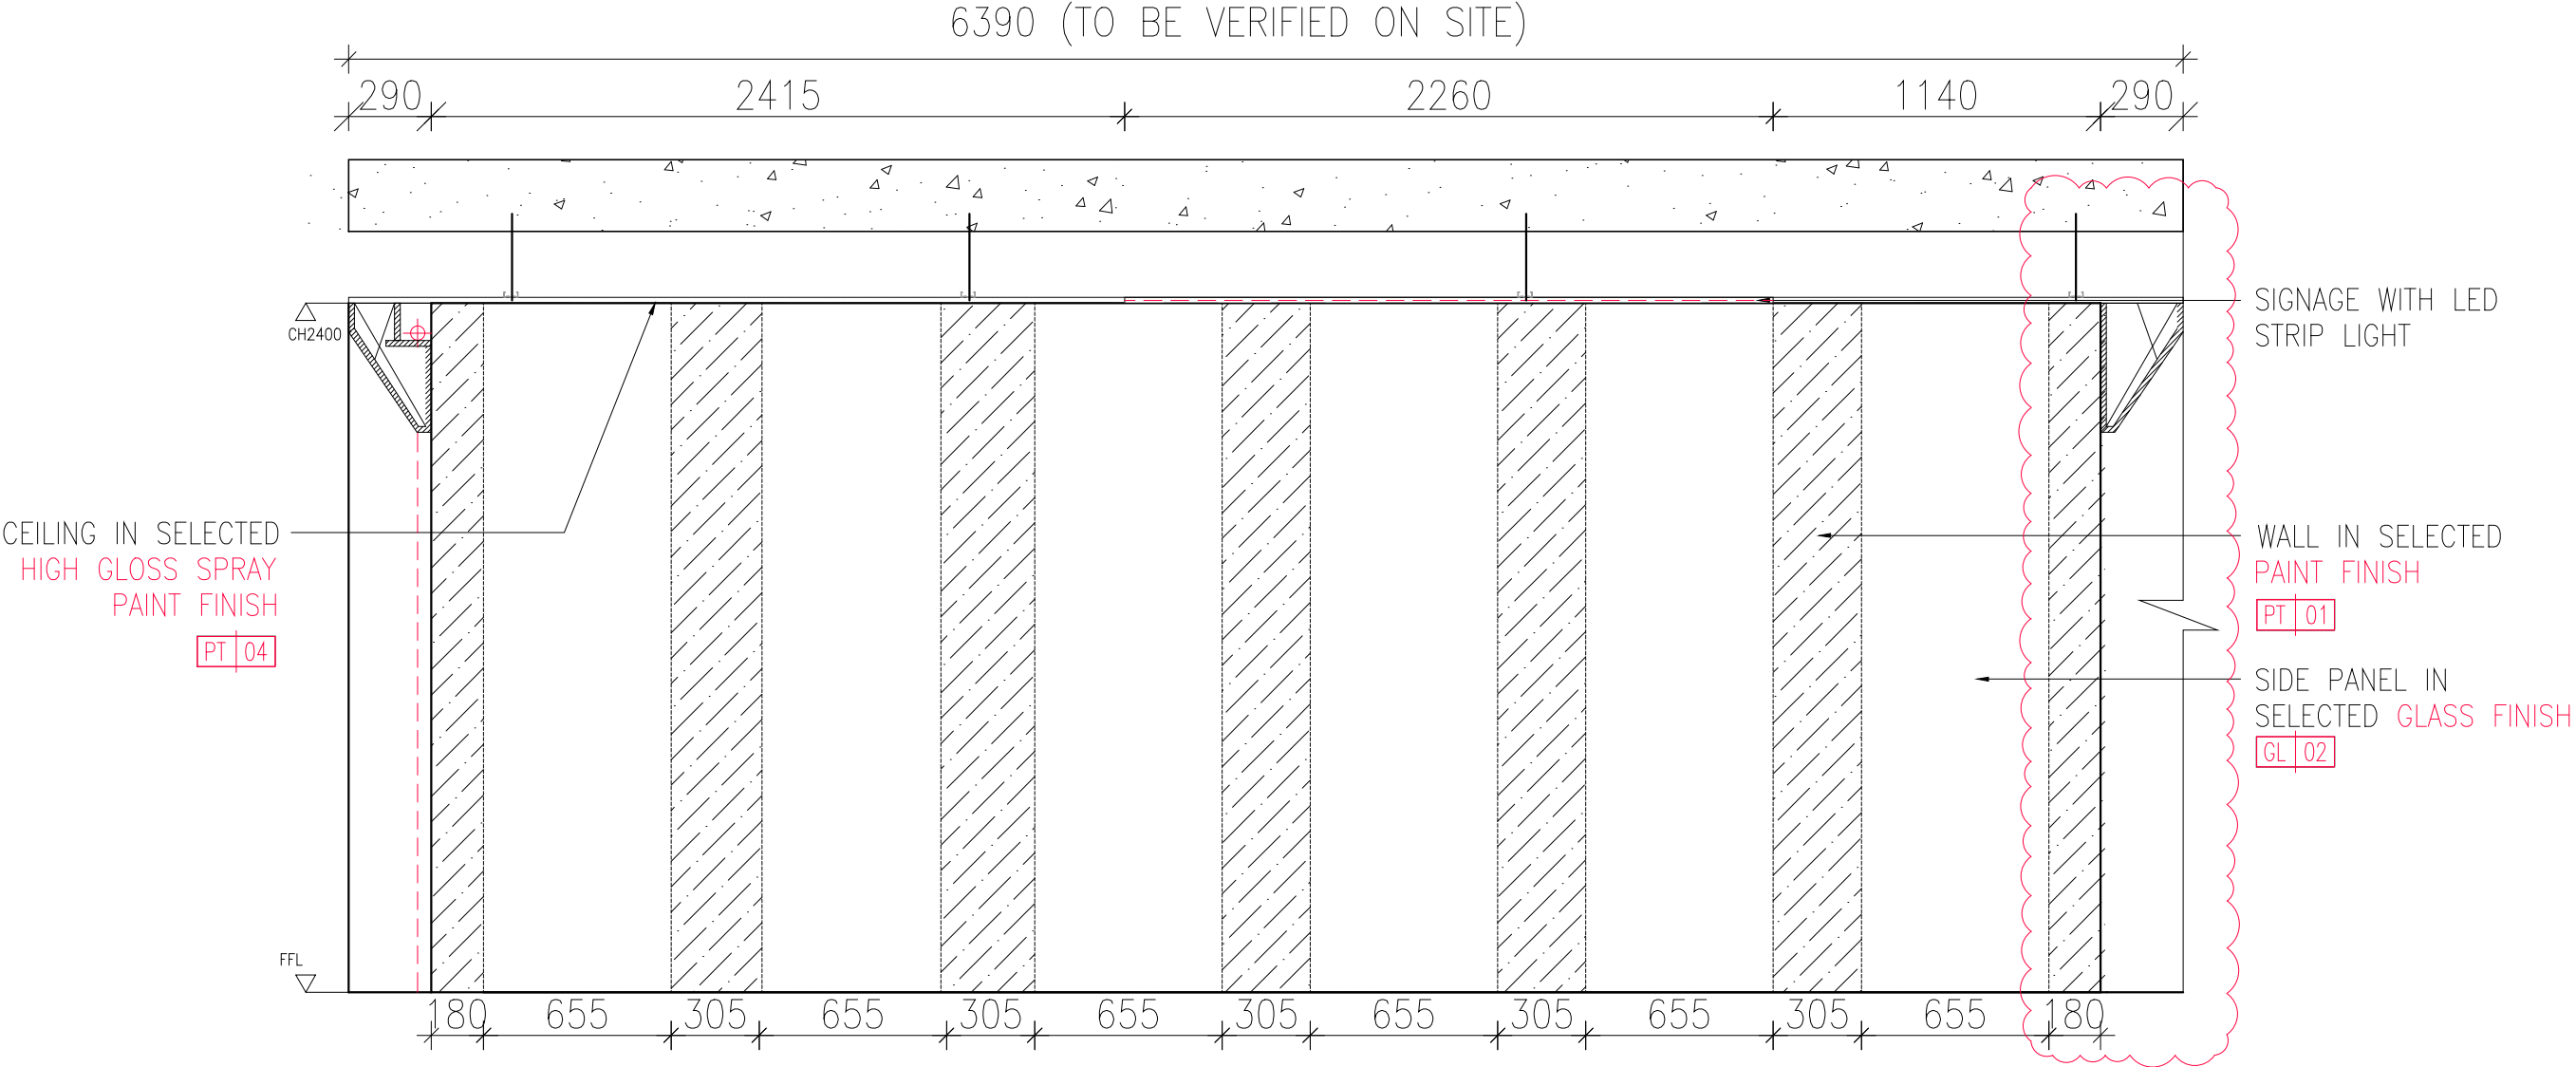

GENERAL NOTES

ALL DIMENSIONS SHOWN ARE IN MILLIMETRES & SHALL BE VERIFIED ON SITE BY THE CONTRACTOR OR SUB-CONTRACTOR.

ALL DIMENSIONS SHOULD NOT BE SCALED FROM THE DRAWING UNLESS OTHERWISE INSTRUCTED. ANY DISCREPANCIES SHALL BE MADE KNOWN TO THE DESIGNER FOR DECISION PRIOR TO PROCEEDING OF THE WORK.

PROJECT TITLE

PROPOSED RENOVATION WORKS TO ROSSA


DRAWING TITLE

INSTAGRAM CORNER - ELEVATION 1

SCALE	AS SHOWN (@ A3 PRINT)
DATE	08 SEPT 2021
DRAWN	KB
FILENAME	-
VERSION	A

OICHI TOLOGY
(PRIVATE) LIMITED

DRAWING NO. 401

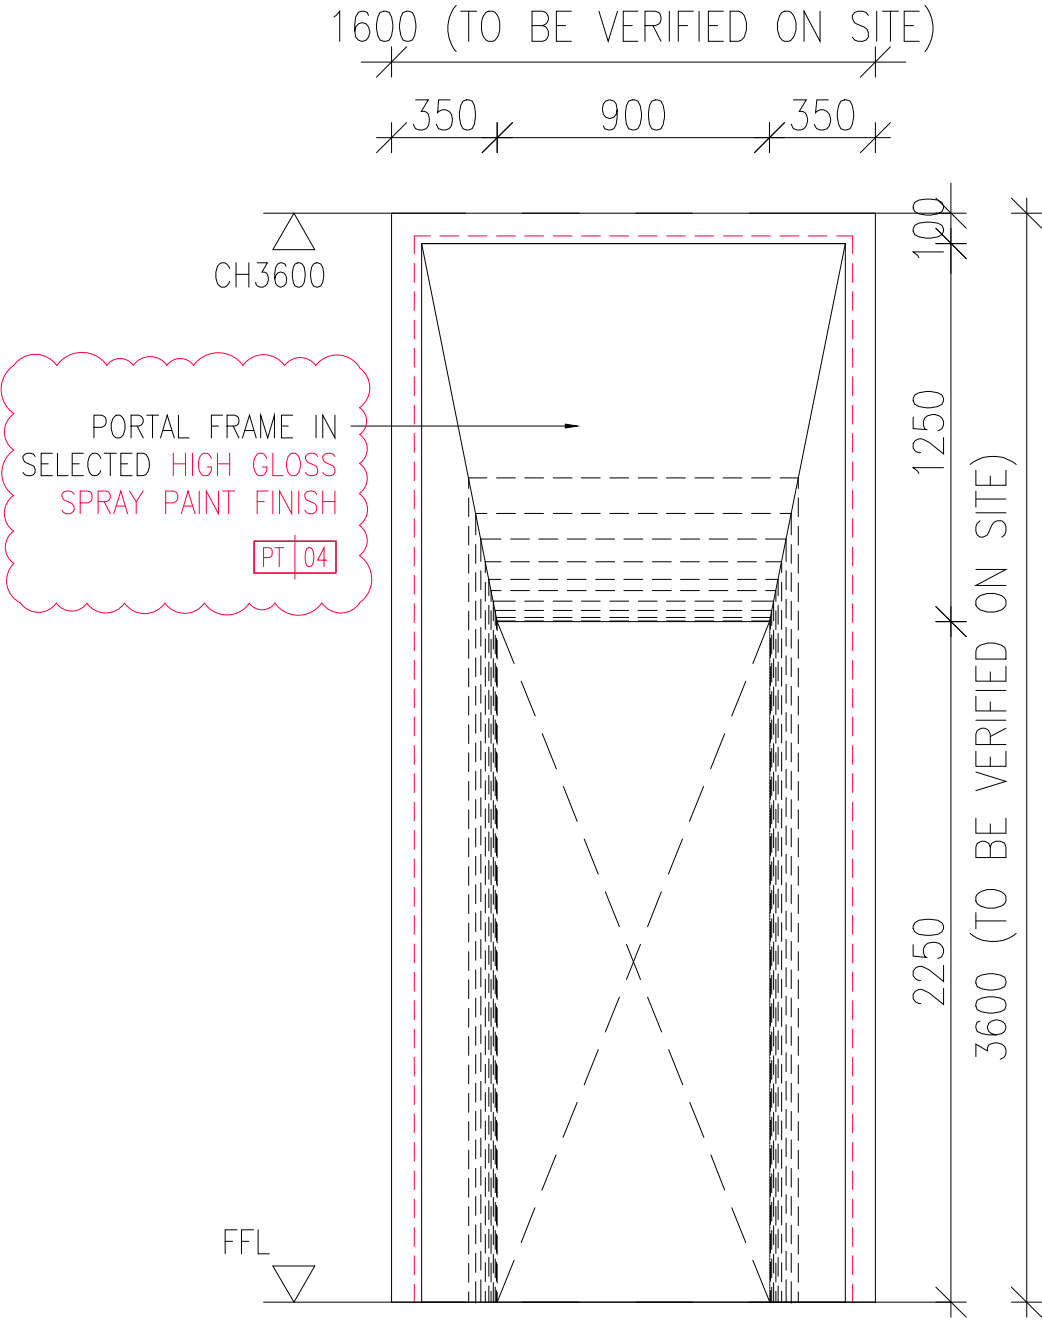

01 402 INSTAGRAM CORNER ELEVATION 2
SCALE 1:25

GENERAL NOTES

ALL DIMENSIONS SHOWN ARE IN MILLIMETRES & SHALL BE VERIFIED ON SITE BY THE CONTRACTOR OR SUB-CONTRACTOR. ALL DIMENSIONS SHOULD NOT BE SCALED FROM THE DRAWING UNLESS OTHERWISE INSTRUCTED. ANY DISCREPANCIES SHALL BE MADE KNOWN TO THE DESIGNER FOR DECISION PRIOR TO PROCEEDING OF THE WORK.


PROJECT TITLE

PROPOSED RENOVATION WORKS TO ROSSA

DRAWING TITLE

INSTAGRAM CORNER - ELEVATION 2

SCALE	AS SHOWN (@ A3 PRINT)
DATE	JUNE 2021
DRAWN	KB
FILENAME	-
VERSION	A

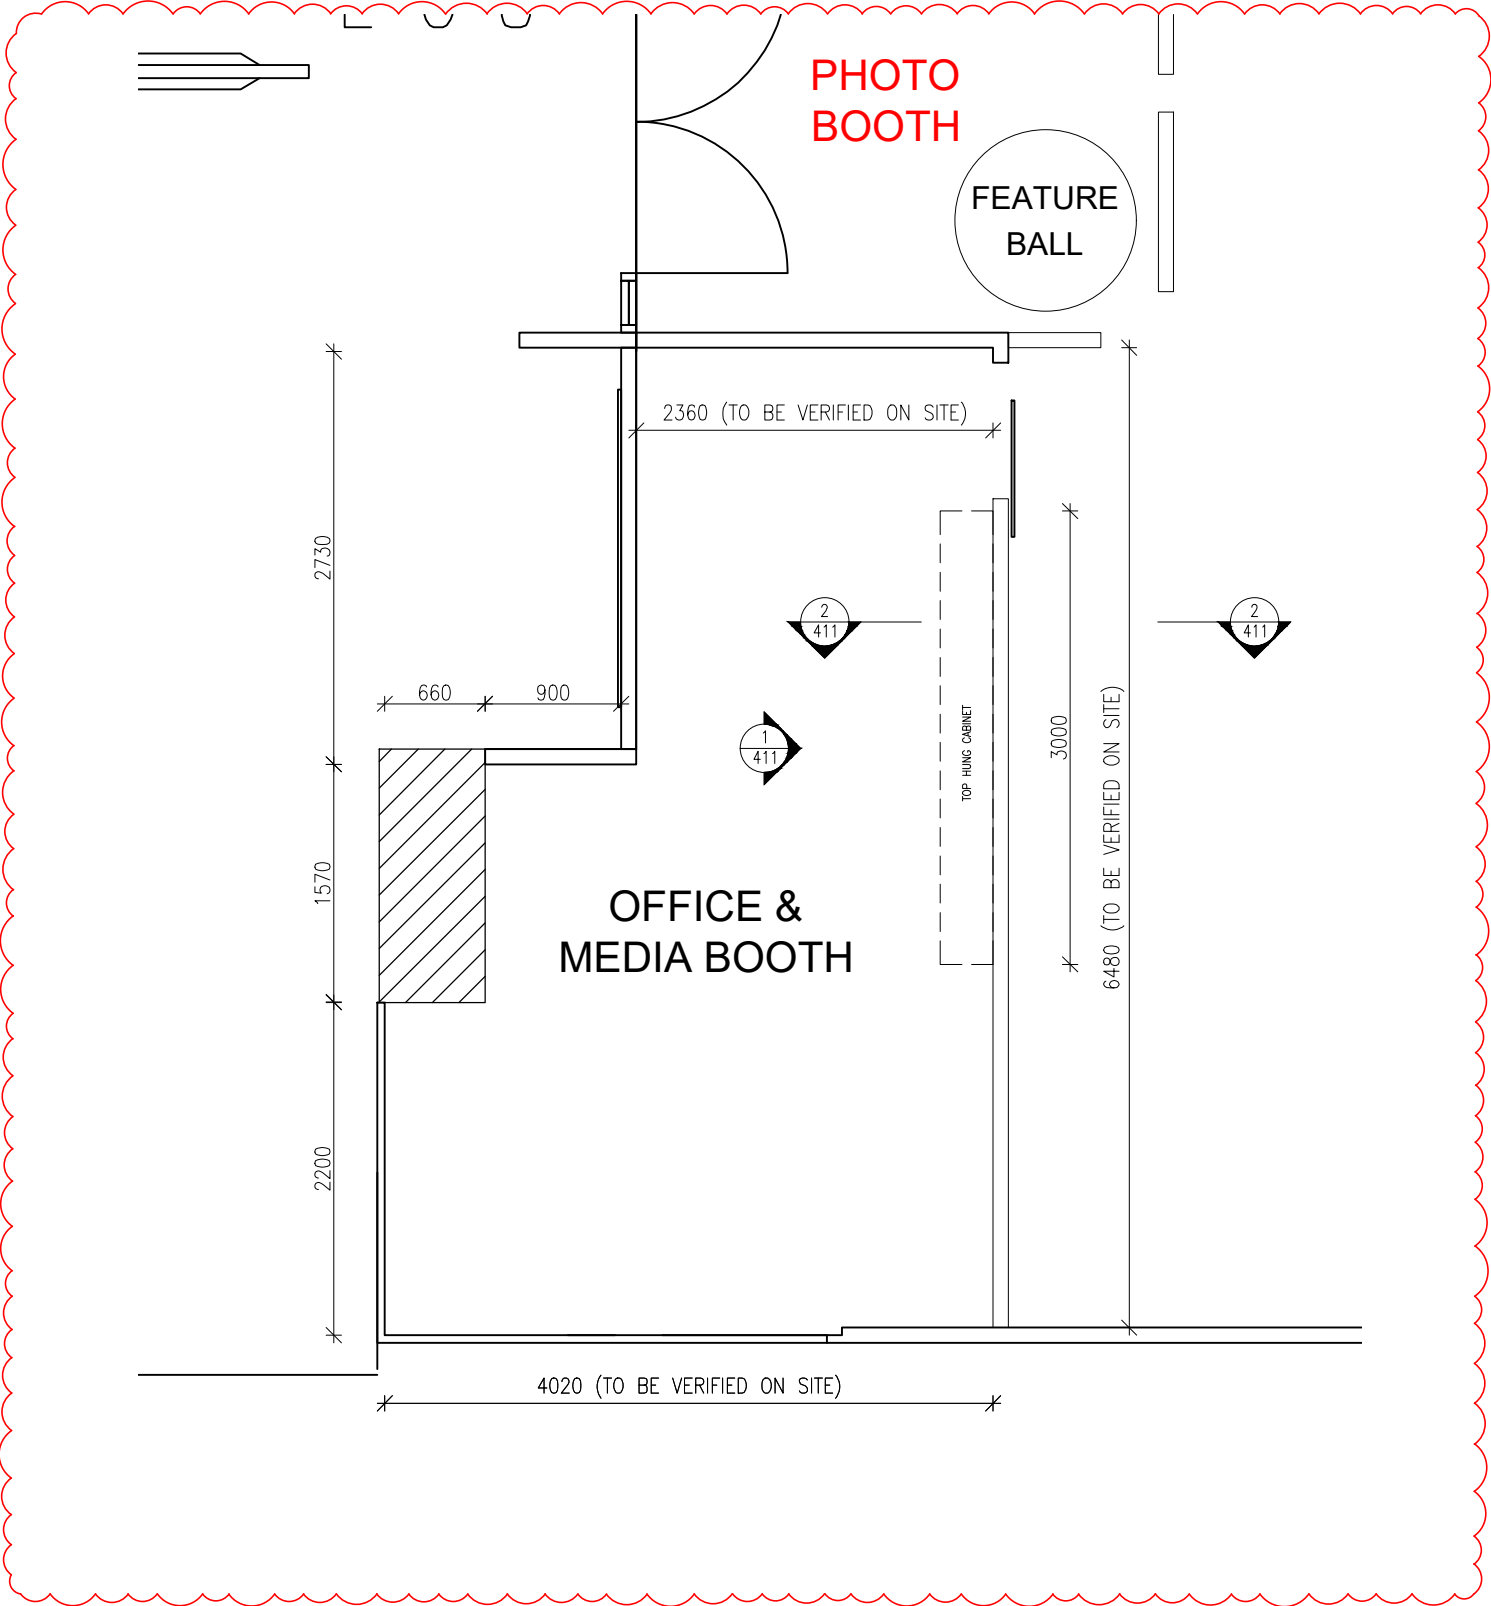

01
410 OFFICE & MEDIA BOOTH - PART PLAN
SCALE 1:50

GENERAL NOTES

ALL DIMENSIONS SHOWN ARE IN MILLIMETRES & SHALL BE VERIFIED ON SITE BY THE CONTRACTOR OR SUB-CONTRACTOR.

ALL DIMENSIONS SHOULD NOT BE SCALED FROM THE DRAWING UNLESS OTHERWISE INSTRUCTED. ANY DISCREPANCIES SHALL BE MADE KNOWN TO THE DESIGNER FOR DECISION PRIOR TO PROCEEDING OF THE WORK.

PROJECT TITLE

PROPOSED RENOVATION WORKS TO ROSSA


DRAWING TITLE

OFFICE & MEDIA BOOTH - PART PLAN


SCALE	AS SHOWN (@ A3 PRINT)
DATE	28 AUG 2021
DRAWN	SY
FILENAME	-
VERSION	B

ORCHITOLOGY
(PRIVATE) LIMITED

DRAWING NO. 410

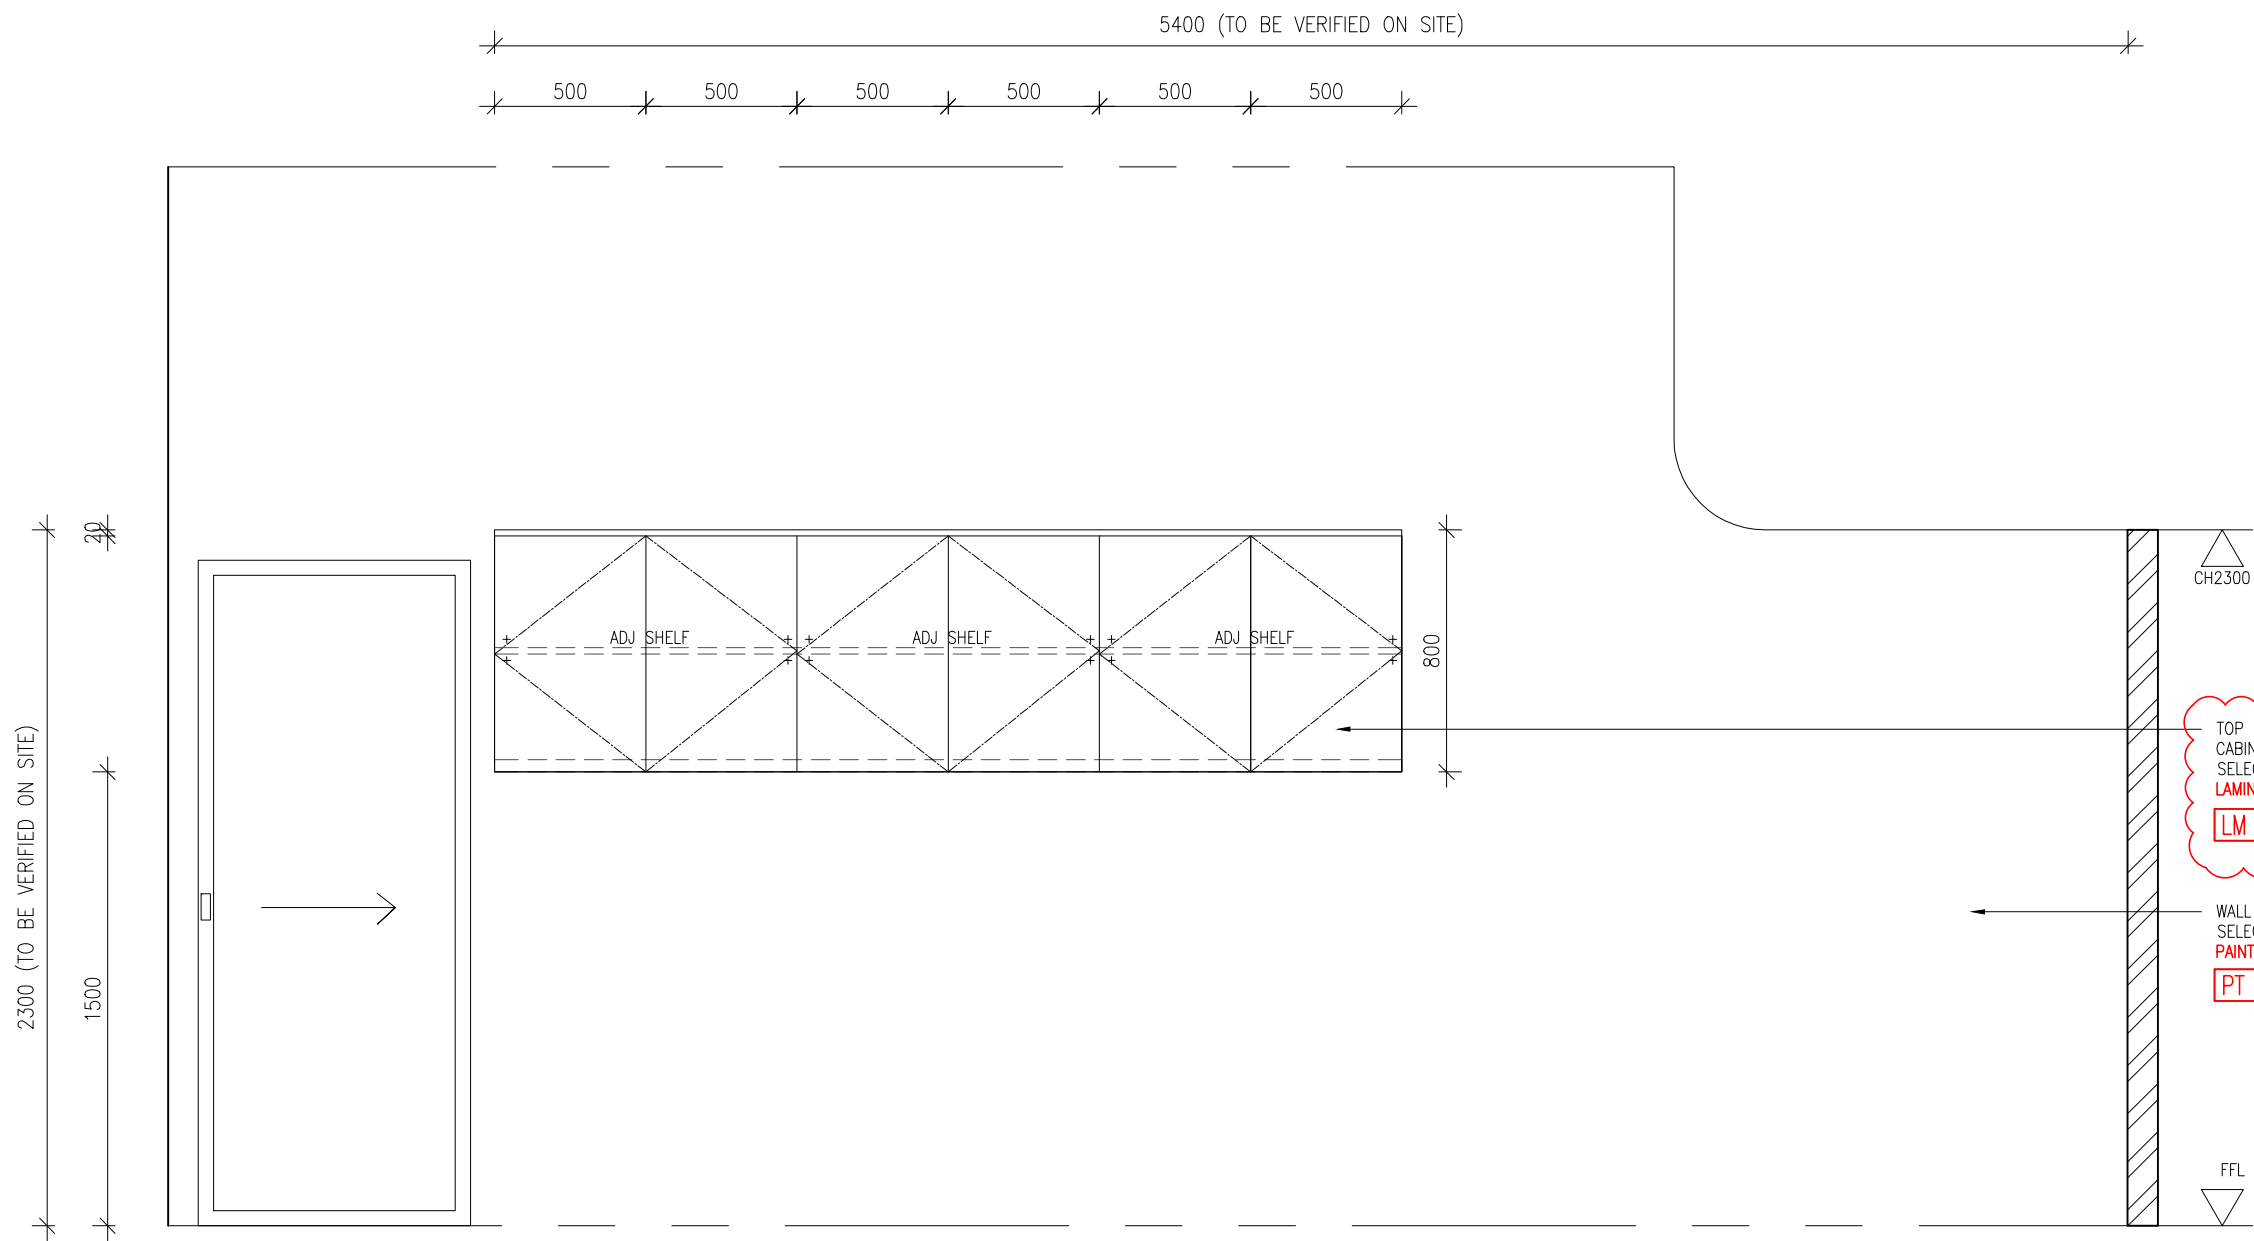

01 OFFICE & MEDIA BOOTH - ELEVATION
411 SCALE 1:25

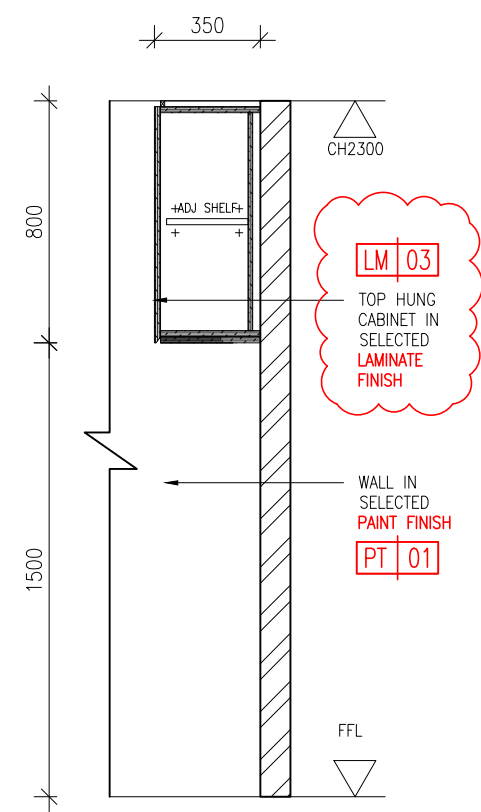

02 OFFICE & MEDIA BOOTH - SECTION
411 SCALE 1:25

GENERAL NOTES

ALL DIMENSIONS SHOWN ARE IN MILLIMETRES & SHALL BE VERIFIED ON SITE BY THE CONTRACTOR OR SUB-CONTRACTOR.

ALL DIMENSIONS SHOULD NOT BE SCALED FROM THE DRAWING UNLESS OTHERWISE INSTRUCTED. ANY DISCREPANCIES SHALL BE MADE KNOWN TO THE DESIGNER FOR DECISION PRIOR TO PROCEEDING OF THE WORK.

PROJECT TITLE

PROPOSED RENOVATION WORKS TO ROSSA


DRAWING TITLE

OFFICE & MEDIA BOOTH - ELEVATION & SECTION

SCALE	AS SHOWN (@ A3 PRINT)
DATE	28 AUG 2021
DRAWN	SY
FILENAME	-
VERSION	C


OFCHITOLOG
(PRIVATE) LIMITED

DRAWING NO. 411

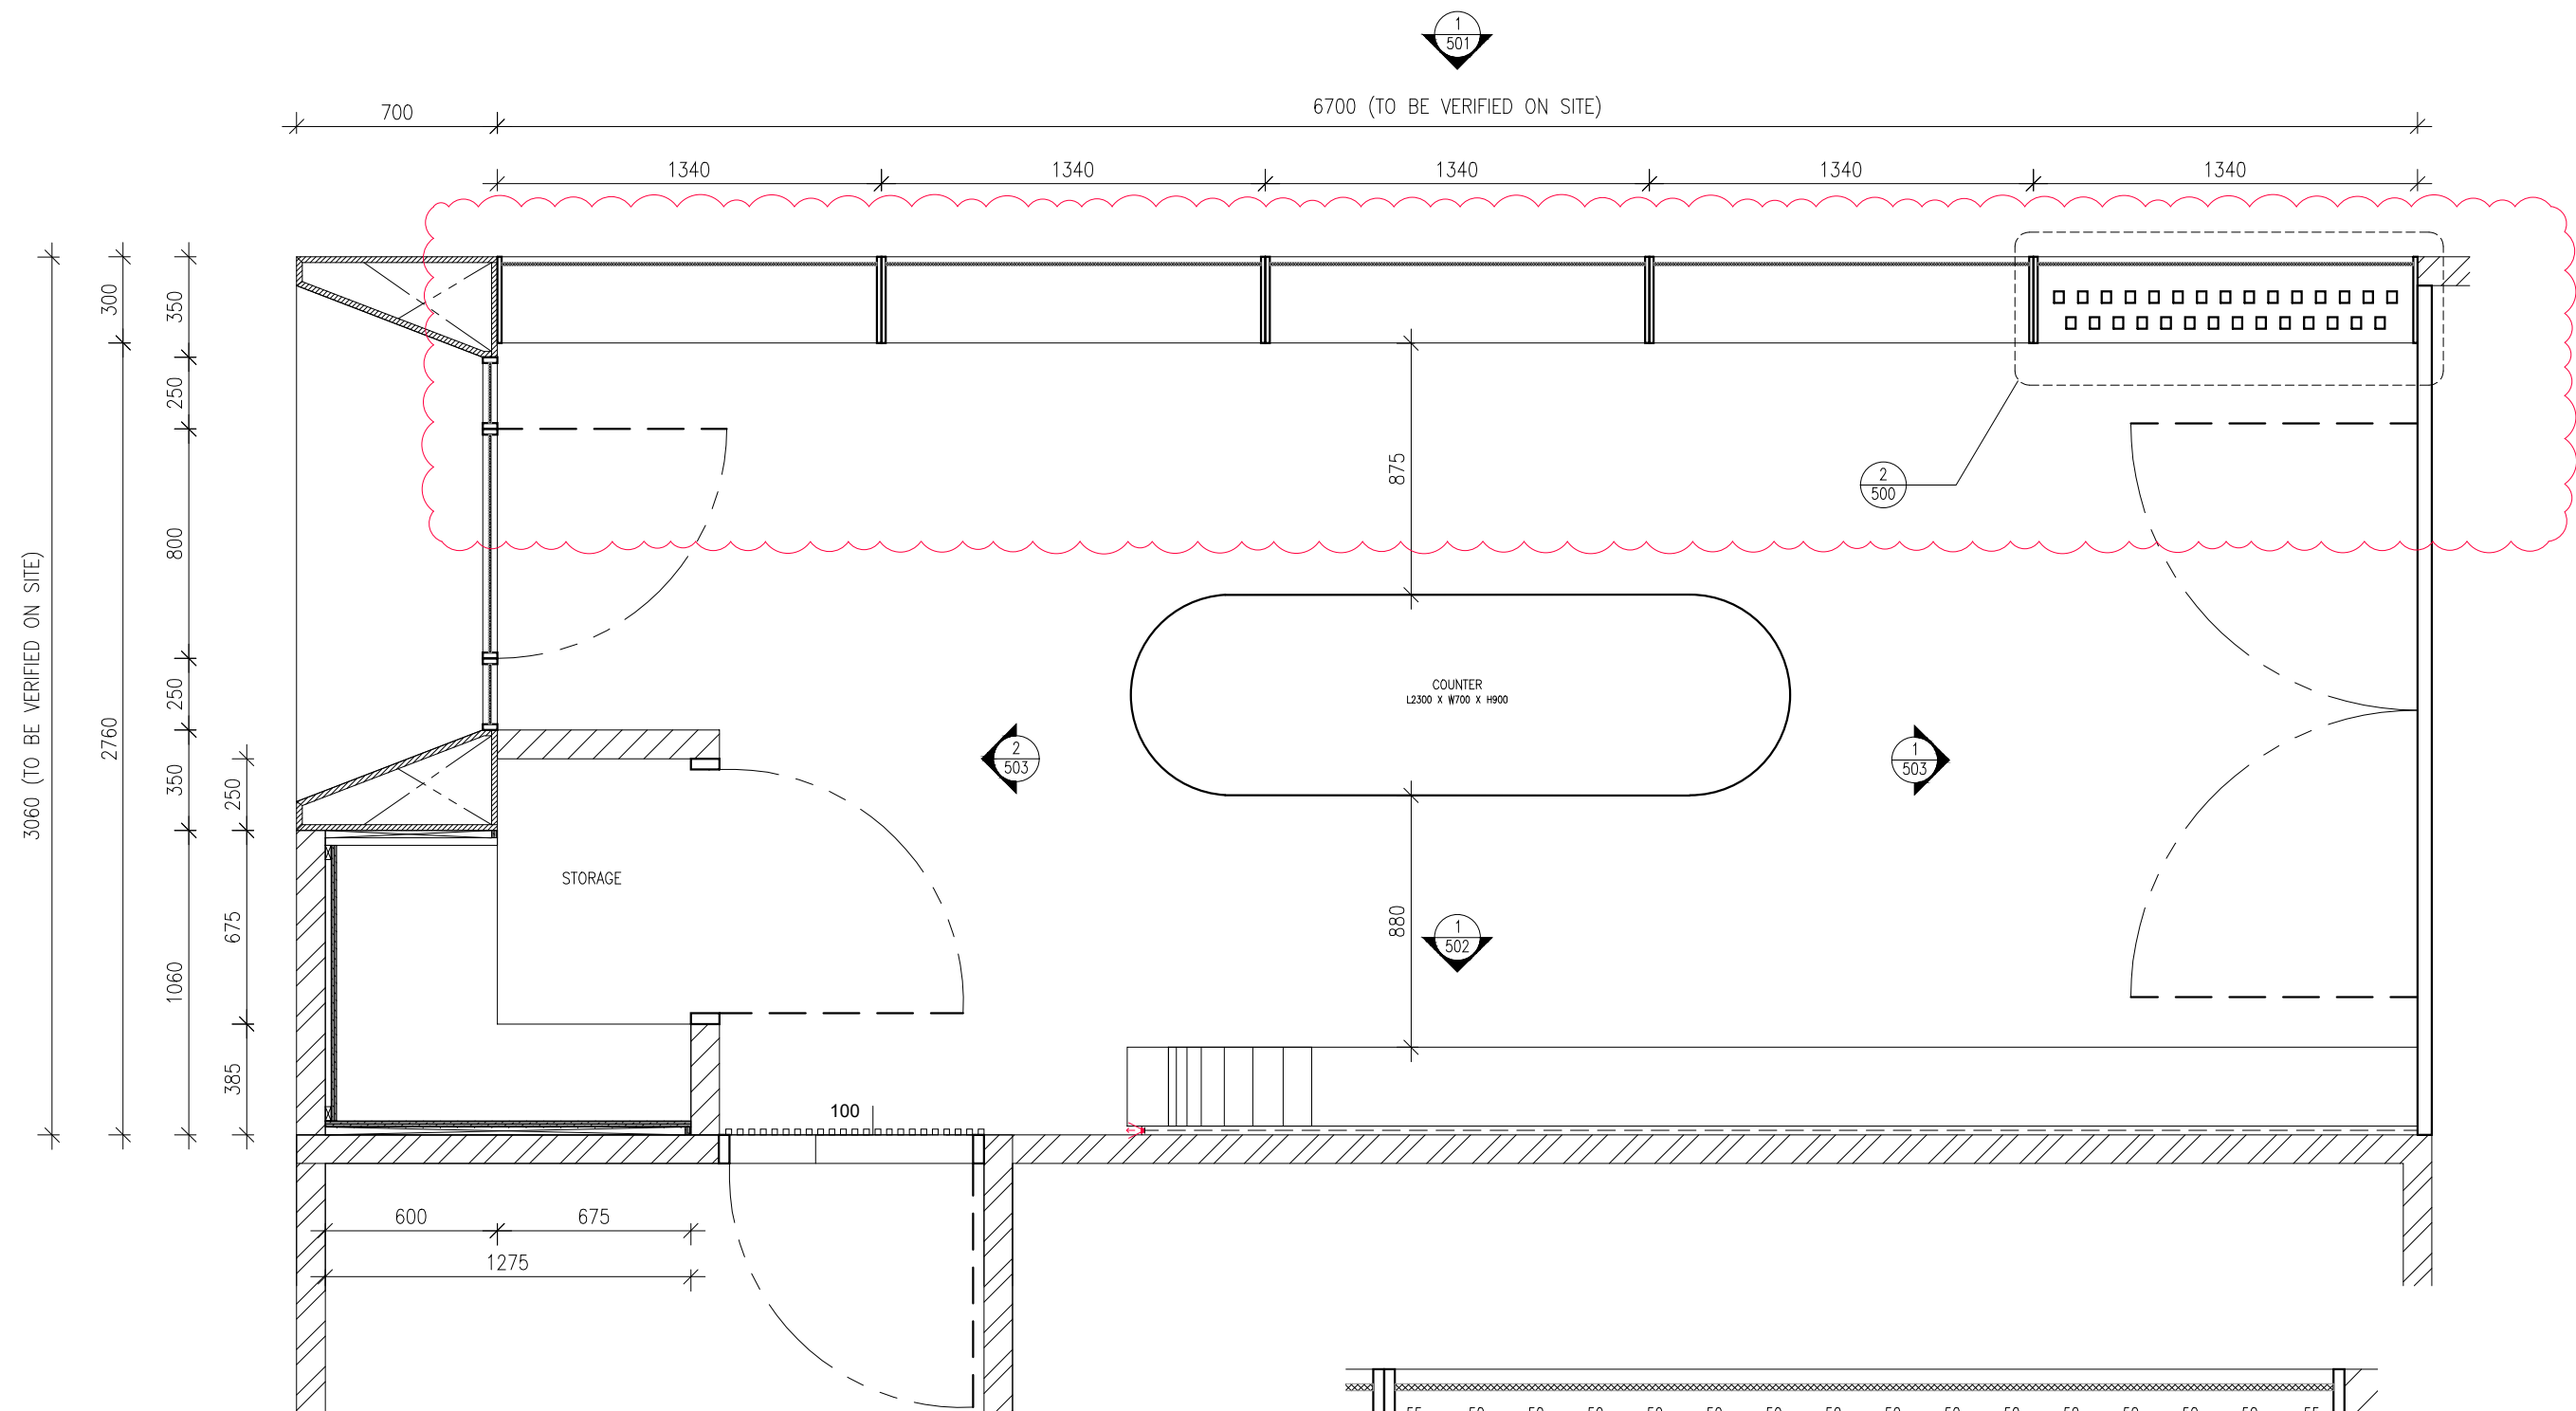

01
500

PRO SHOP - PART PLAN
SCALE 1:25

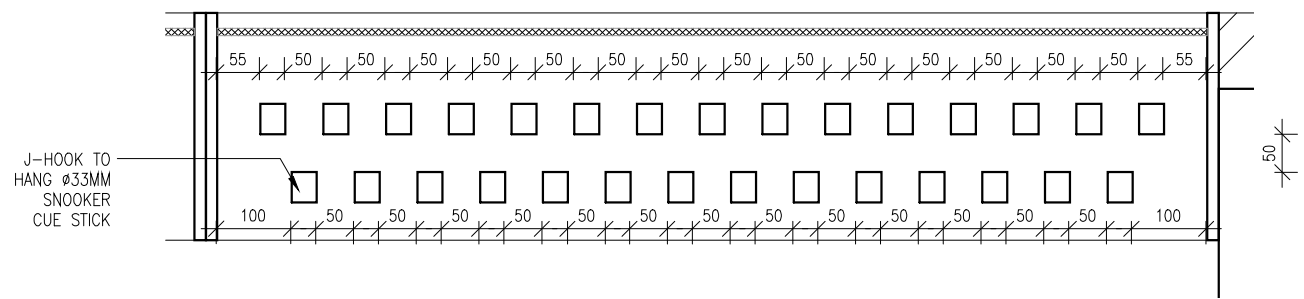

02
500

SNOOKER CUE STICK LOCATION
SCALE 1:10

GENERAL NOTES

ALL DIMENSIONS SHOWN ARE IN MILLIMETRES & SHALL BE VERIFIED ON SITE BY THE CONTRACTOR OR SUB-CONTRACTOR.

ALL DIMENSIONS SHOULD NOT BE SCALED FROM THE DRAWING UNLESS OTHERWISE INSTRUCTED. ANY DISCREPANCIES SHALL BE MADE KNOWN TO THE DESIGNER FOR DECISION PRIOR TO PROCEEDING OF THE WORK.

PROJECT TITLE

PROPOSED RENOVATION WORKS TO ROSSA


DRAWING TITLE

PRO SHOP - PART PLAN

SCALE	AS SHOWN (@ A3 PRINT)
DATE	31 AUG 2021
DRAWN	SZM
FILENAME	-
VERSION	D


OICHITOLOGY
(PRIVATE) LIMITED

DRAWING NO. 500

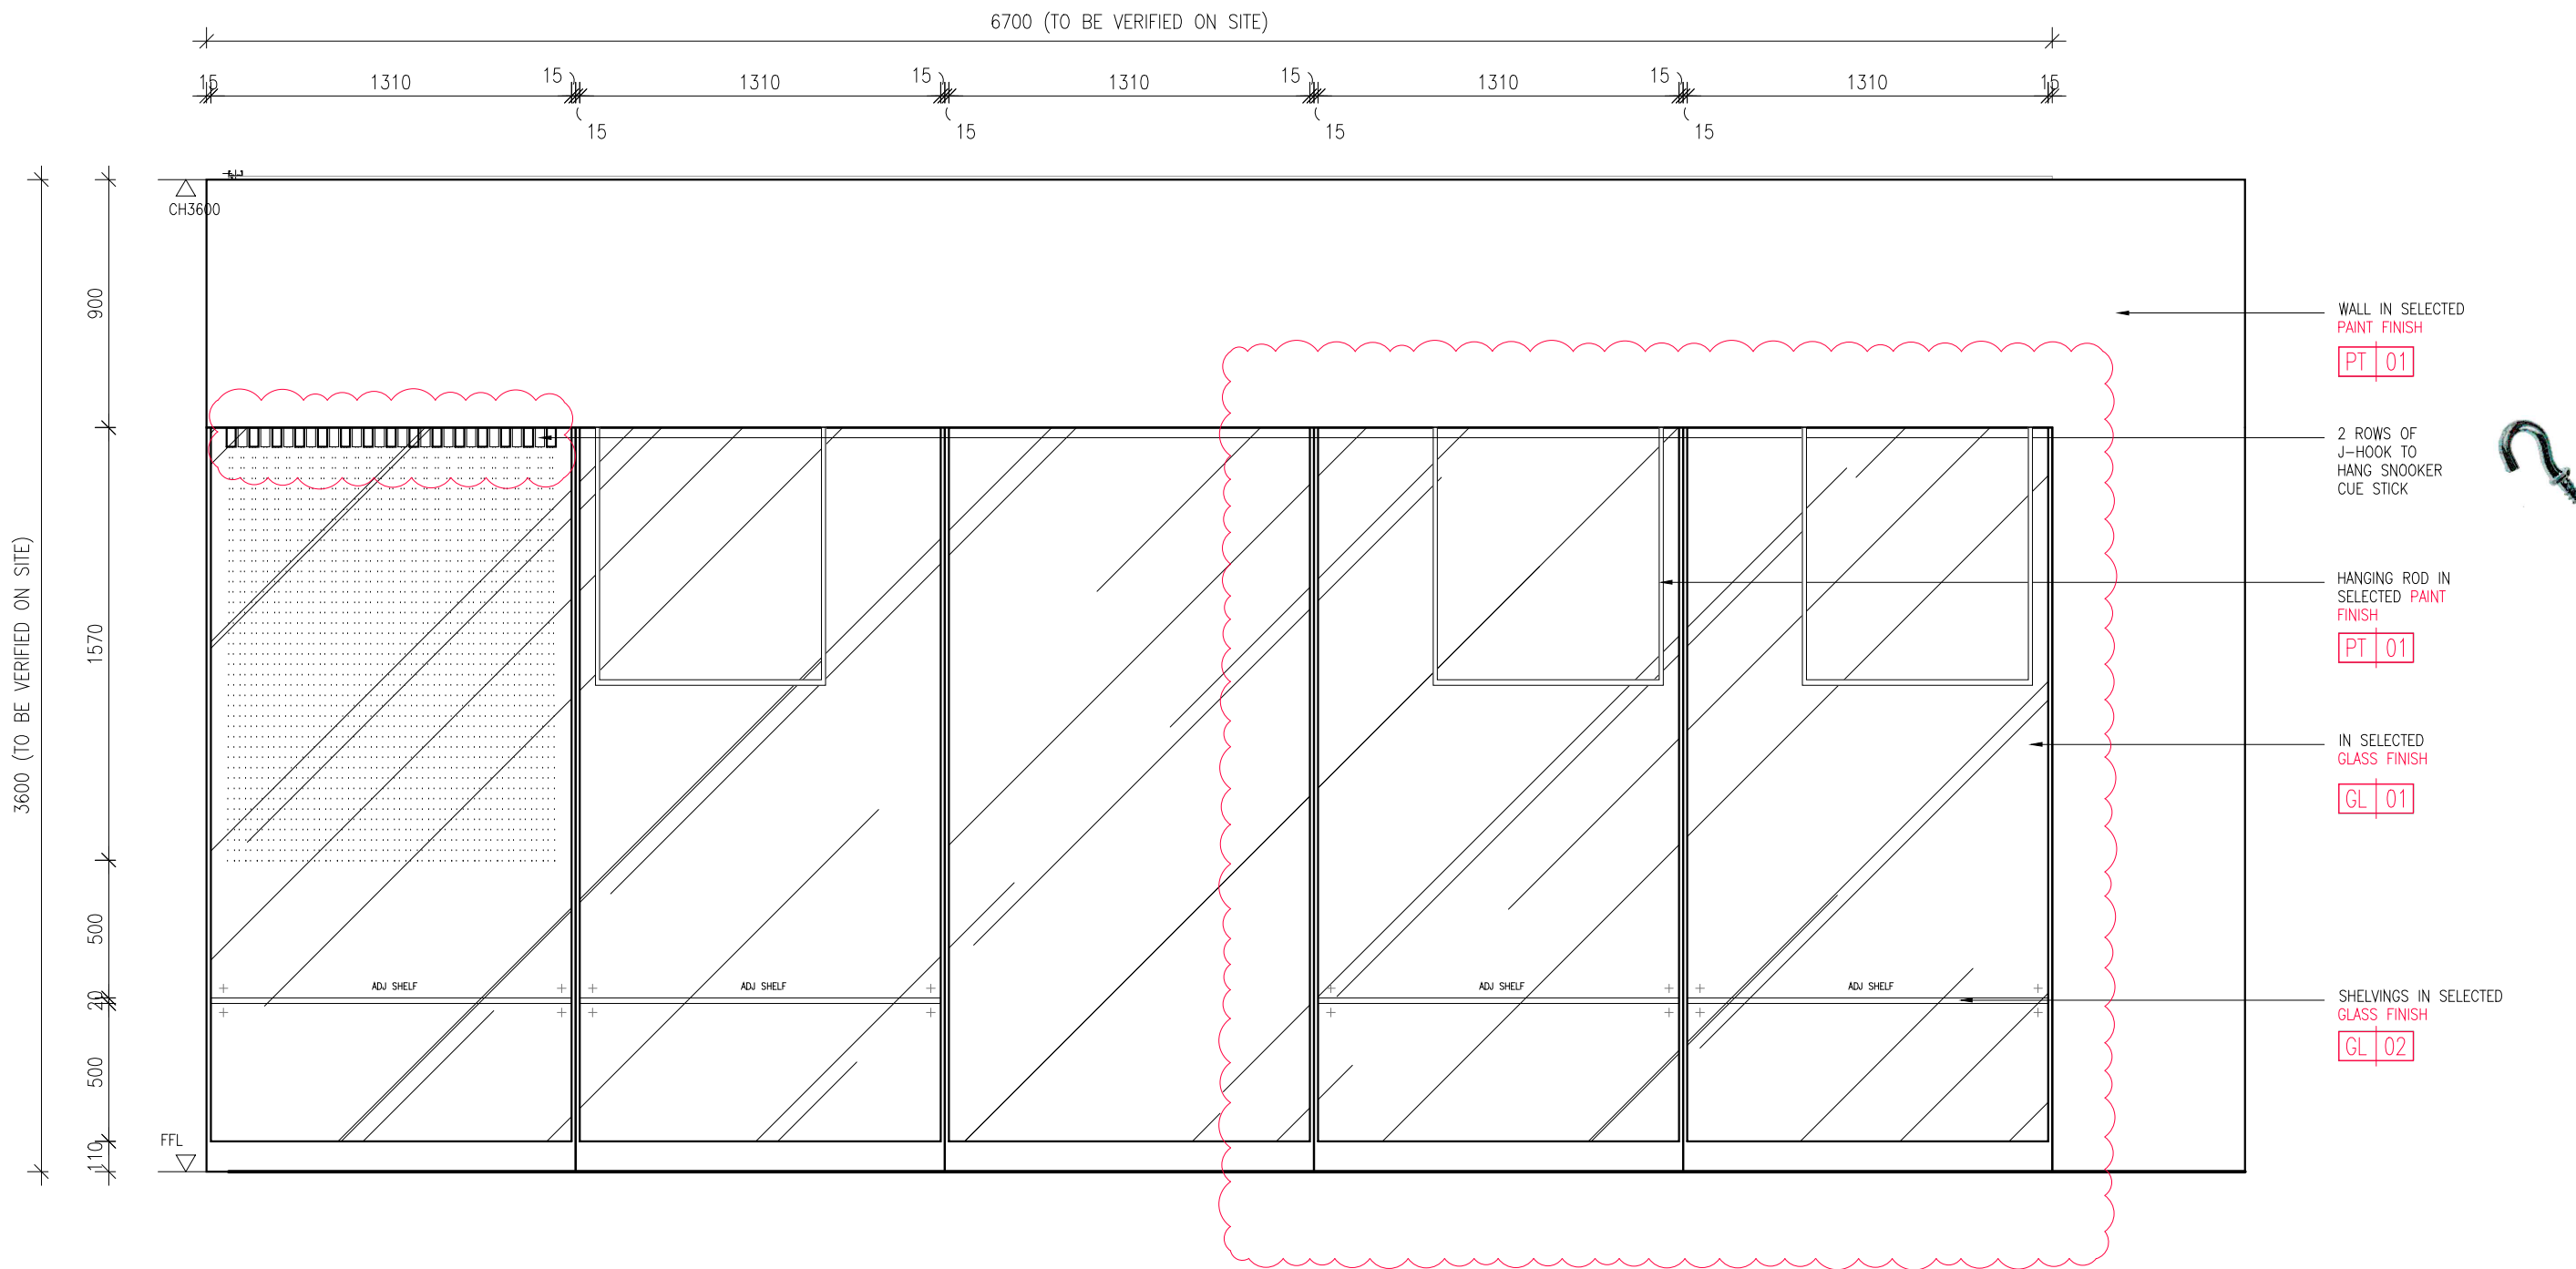


01
501

PRO SHOP - ELEVATION 1
SCALE 1:25

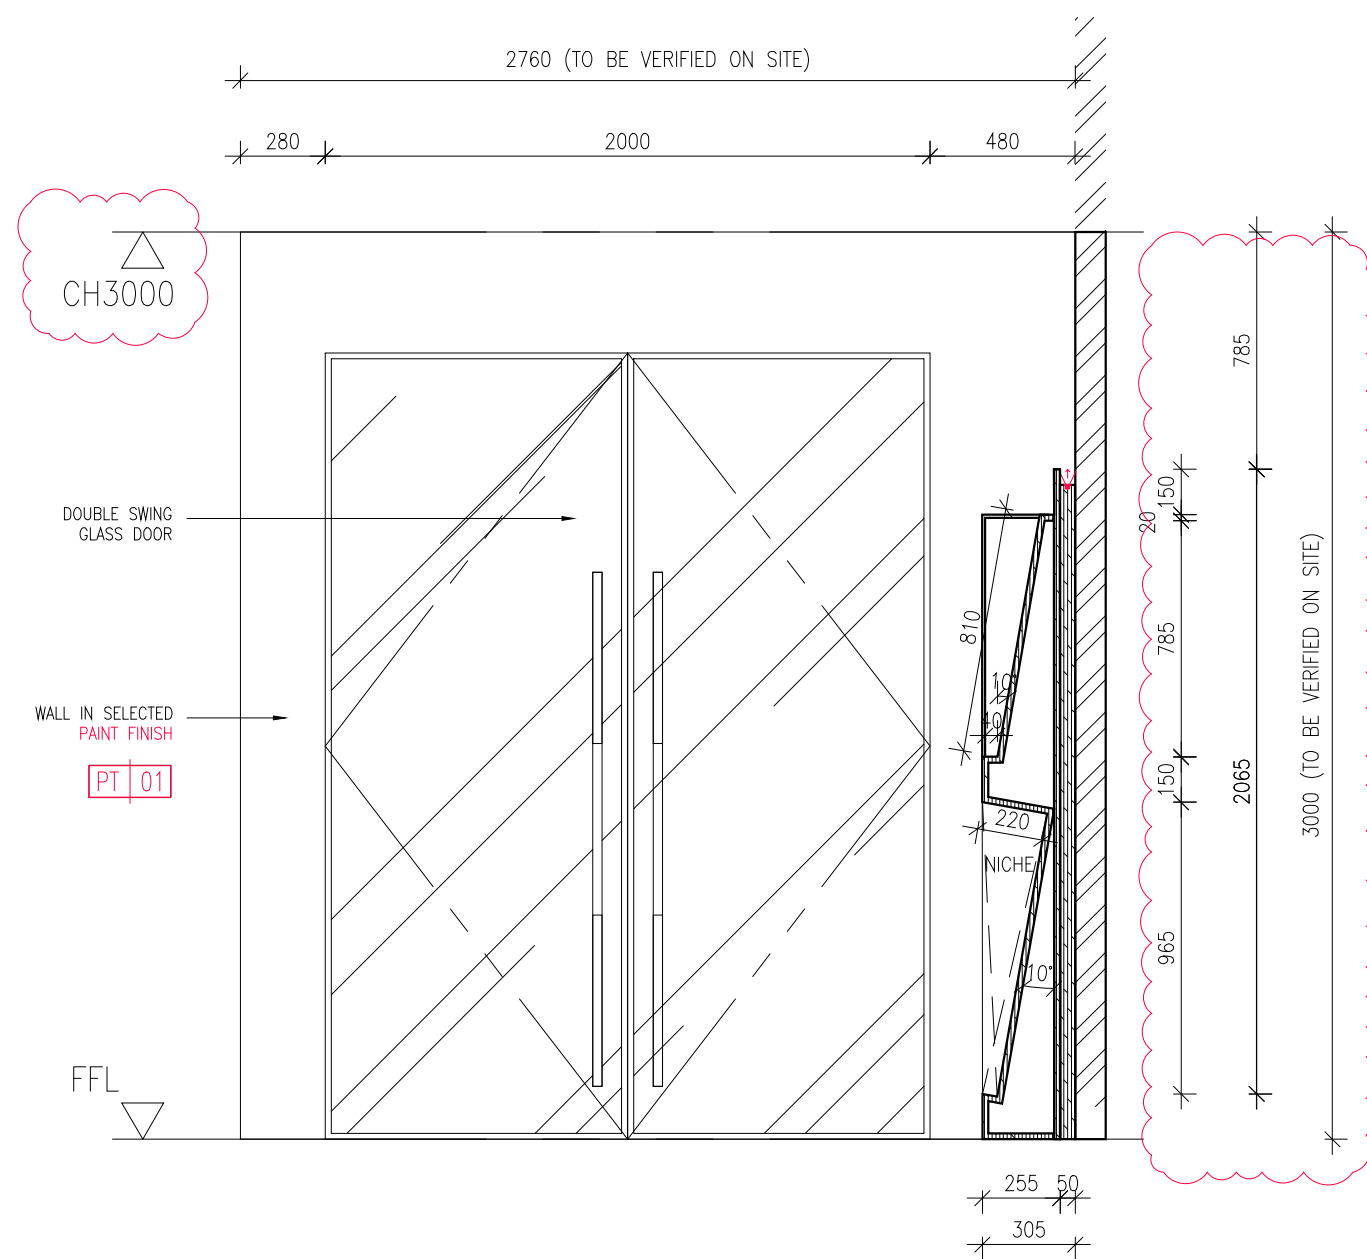

01
503
PRO SHOP - ELEVATION 3
SCALE 1:25

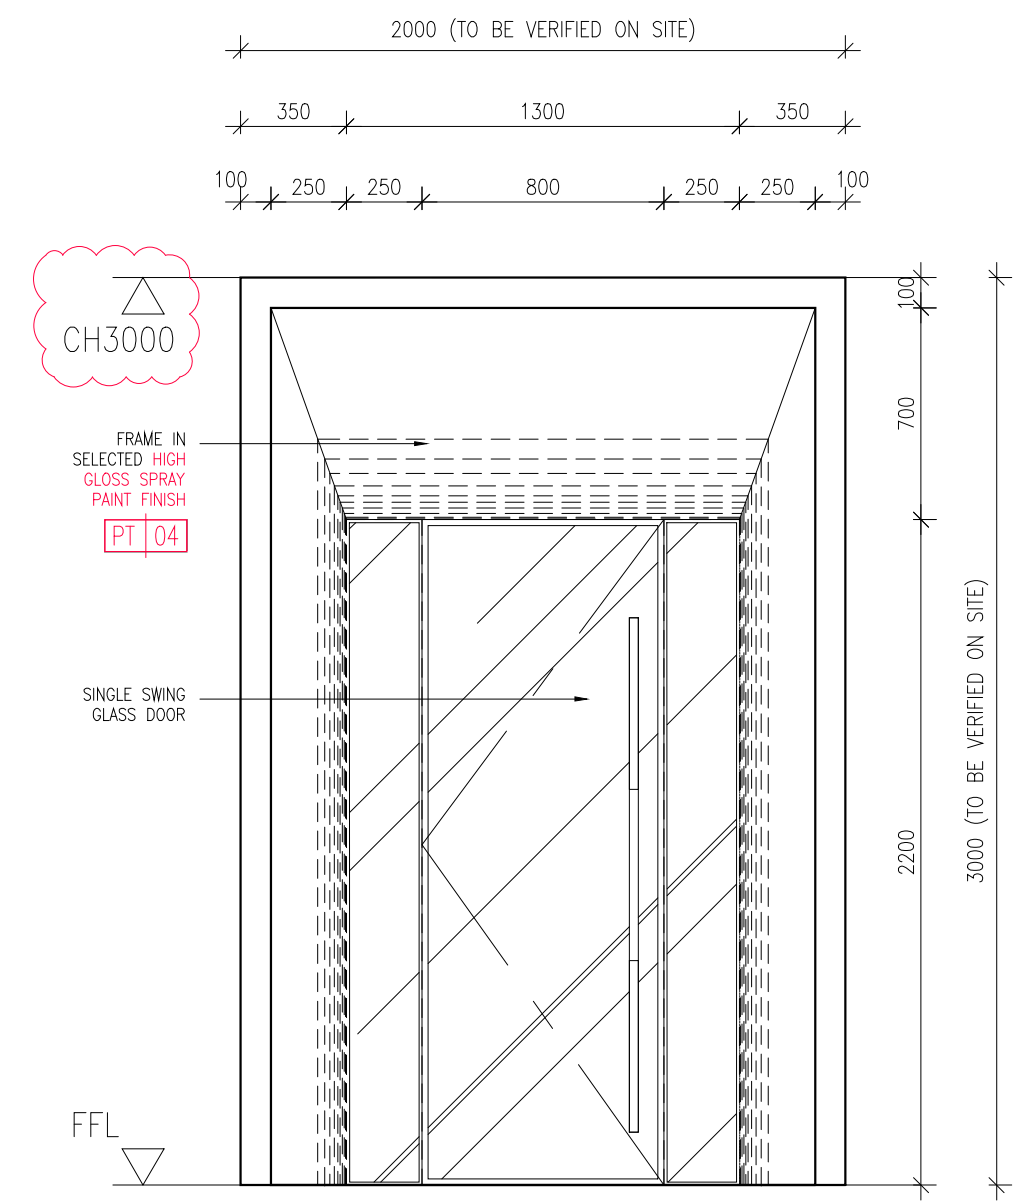

02
503
PRO SHOP - ELEVATION 4
SCALE 1:25

GENERAL NOTES

ALL DIMENSIONS SHOWN ARE IN MILLIMETRES & SHALL BE VERIFIED ON SITE BY THE CONTRACTOR OR SUB-CONTRACTOR. ALL DIMENSIONS SHOULD NOT BE SCALED FROM THE DRAWING UNLESS OTHERWISE INSTRUCTED. ANY DISCREPANCIES SHALL BE MADE KNOWN TO THE DESIGNER FOR DECISION PRIOR TO PROCEEDING OF THE WORK.

PROJECT TITLE


PROPOSED RENOVATION WORKS TO
ROSSA

DRAWING TITLE

PRO SHOP - ELEVATION 3 & 4

SCALE	AS SHOWN (@ A3 PRINT)
DATE	30 AUG 2021
DRAWN	SY
FILENAME	-
VERSION	C

ORCHITOLOG
(PRIVATE) LIMITED
DRAWING NO. 503

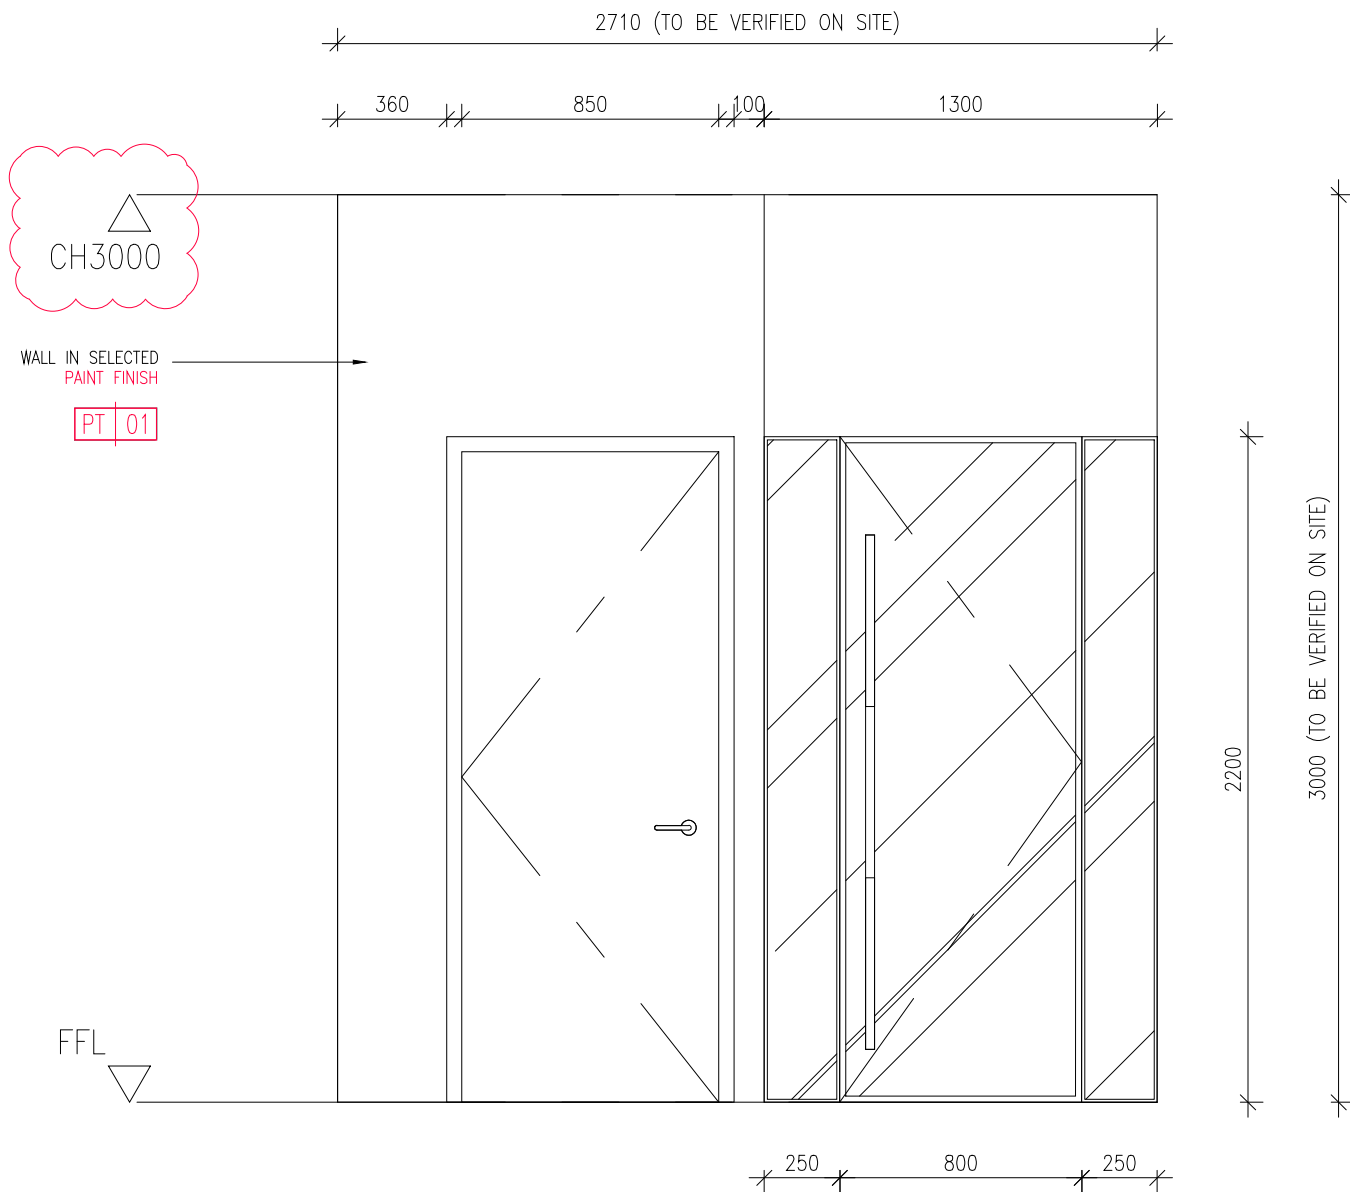

01
504

PRO SHOP - ELEVATION 5

SCALE 1:25

GENERAL NOTES

ALL DIMENSIONS SHOWN ARE IN MILLIMETRES & SHALL BE VERIFIED ON SITE BY THE CONTRACTOR OR SUB-CONTRACTOR. ALL DIMENSIONS SHOULD NOT BE SCALED FROM THE DRAWING UNLESS OTHERWISE INSTRUCTED. ANY DISCREPANCIES SHALL BE MADE KNOWN TO THE DESIGNER FOR DECISION PRIOR TO PROCEEDING OF THE WORK.


PROJECT TITLE

PROPOSED RENOVATION WORKS TO ROSSA

DRAWING TITLE

PRO SHOP - ELEVATION 5

SCALE	AS SHOWN (@ A3 PRINT)
DATE	30 AUG 2021
DRAWN	SY
FILENAME	-
VERSION	C

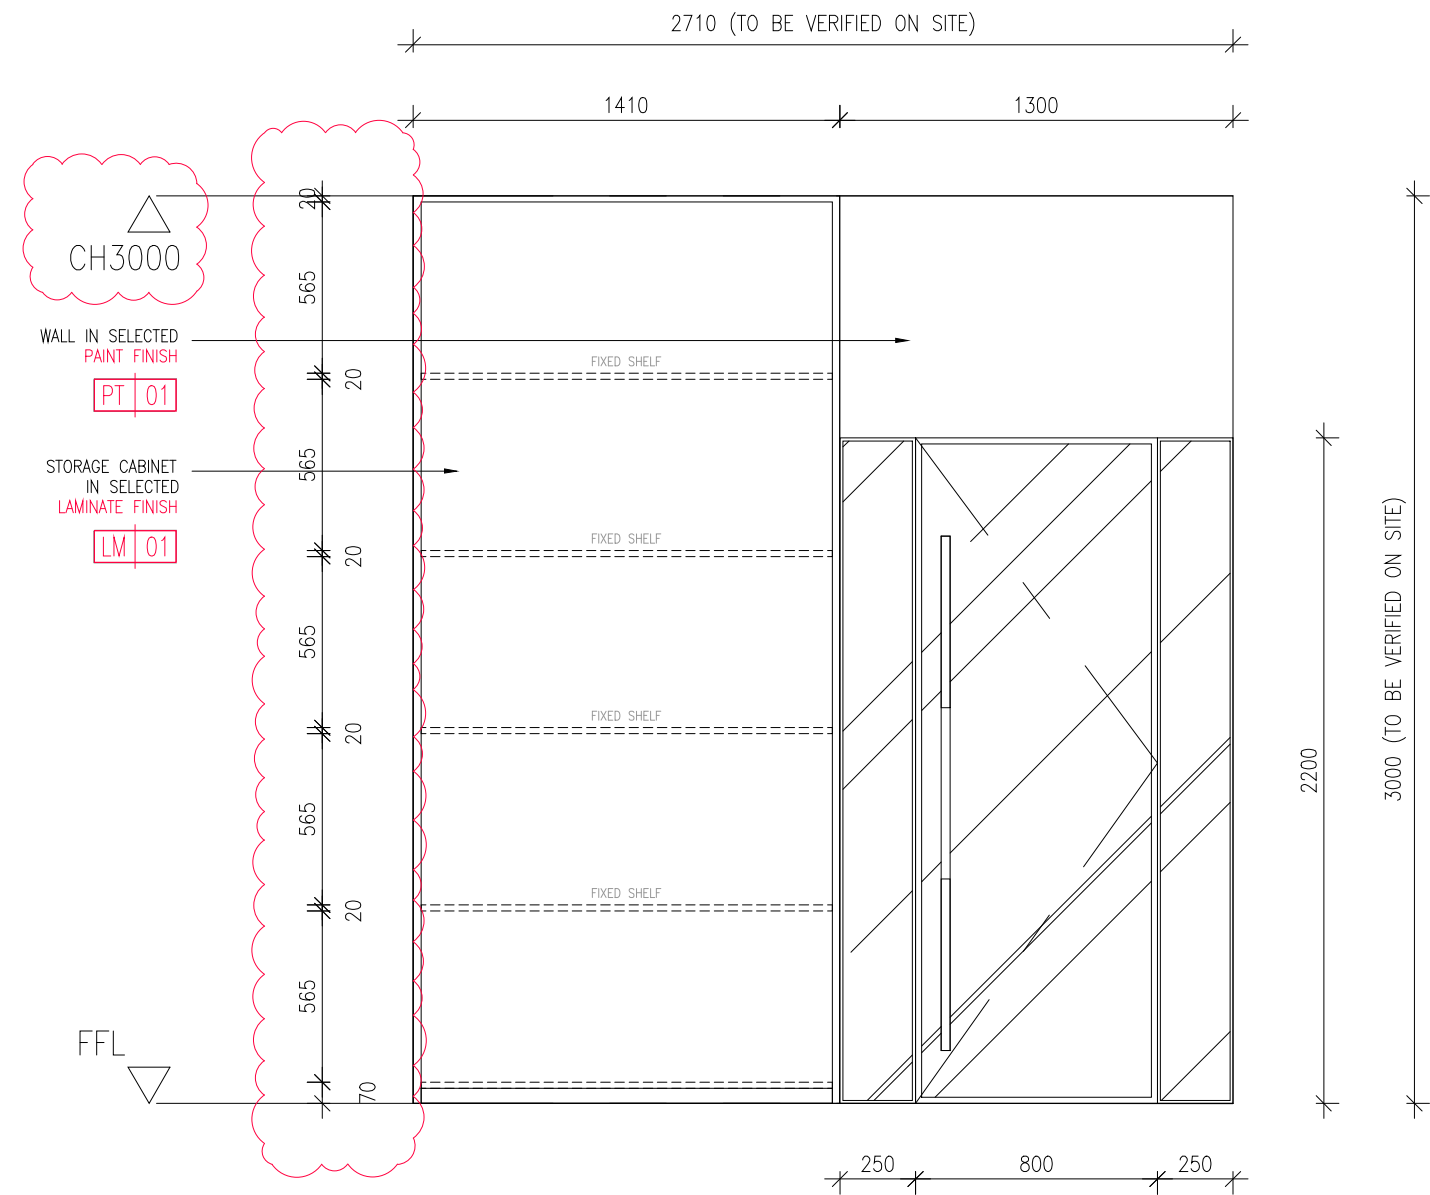

01
505

PRO SHOP - ELEVATION 5
SCALE 1:25

GENERAL NOTES

ALL DIMENSIONS SHOWN ARE IN MILLIMETRES & SHALL BE VERIFIED ON SITE BY THE CONTRACTOR OR SUB-CONTRACTOR.
ALL DIMENSIONS SHOULD NOT BE SCALED FROM THE DRAWING UNLESS OTHERWISE INSTRUCTED. ANY DISCREPANCIES SHALL BE MADE KNOWN TO THE DESIGNER FOR DECISION PRIOR TO PROCEEDING OF THE WORK.

PROJECT TITLE

PROPOSED RENOVATION WORKS TO
ROSSA

DRAWING TITLE

PRO SHOP - ELEVATION 5 (INTERNAL)

SCALE

AS SHOWN (@ A3 PRINT)

DATE

30 AUG 2021

DRAWN

SY

FILENAME

-


VERSION

B


ORCHITOL
(PRIVATE) LIMITED

DRAWING NO.


505

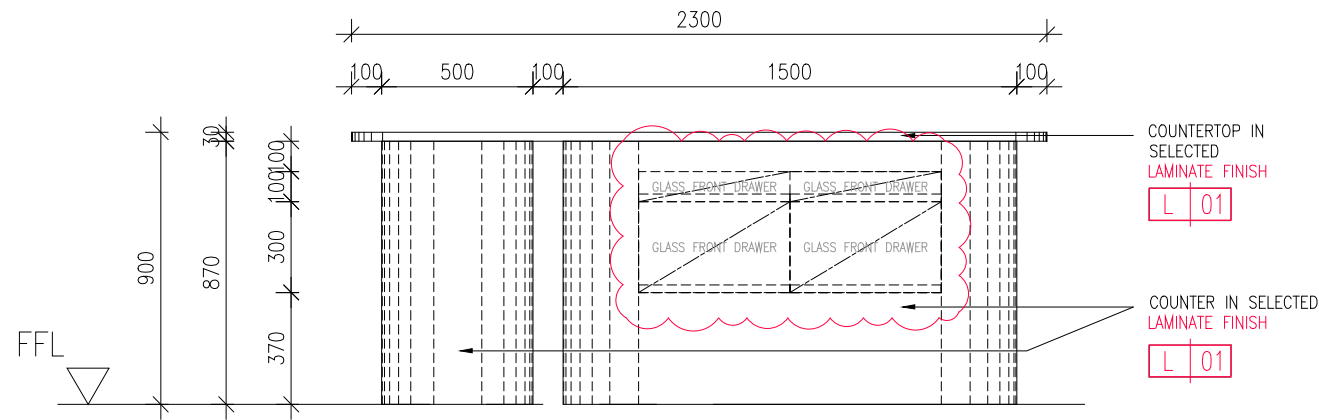

01 PRO SHOP COUNTER - ELEVATION 1
511 SCALE 1:25

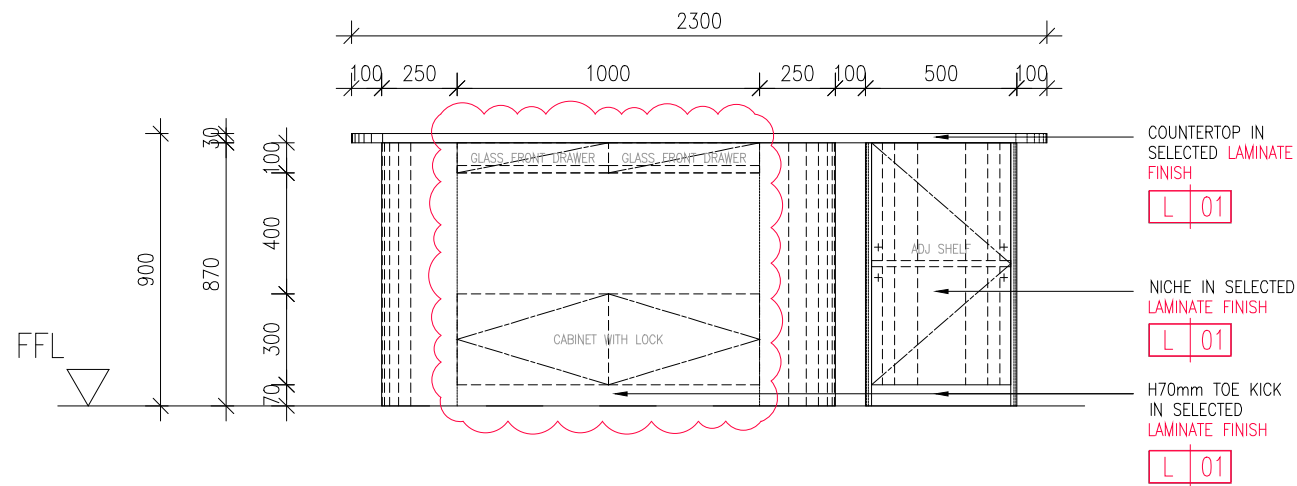

02 PRO SHOP COUNTER - ELEVATION 2
511 SCALE 1:25

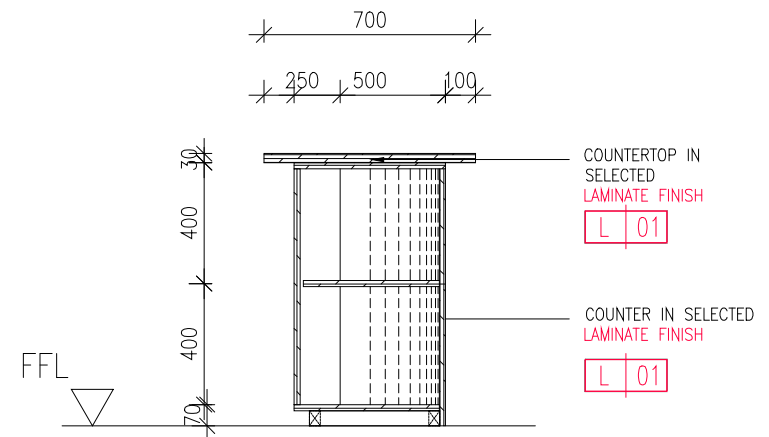

03 PRO SHOP COUNTER - ELEVATION 3
511 SCALE 1:25

GENERAL NOTES

ALL DIMENSIONS SHOWN ARE IN MILLIMETRES & SHALL BE VERIFIED ON SITE BY THE CONTRACTOR OR SUB-CONTRACTOR.
ALL DIMENSIONS SHOULD NOT BE SCALED FROM THE DRAWING UNLESS OTHERWISE INSTRUCTED. ANY DISCREPANCIES SHALL BE MADE KNOWN TO THE DESIGNER FOR DECISION PRIOR TO PROCEEDING OF THE WORK.

PROJECT TITLE

PROPOSED RENOVATION WORKS TO
ROSSA

DRAWING TITLE

PRO SHOP COUNTER - ELEVATIONS

SCALE

AS SHOWN (@ A3 PRINT)

DATE

18 AUG 2021

DRAWN

SY

FILENAME

-


VERSION

B


ORCHITOL
(PRIVATE) LIMITED

DRAWING NO.

511

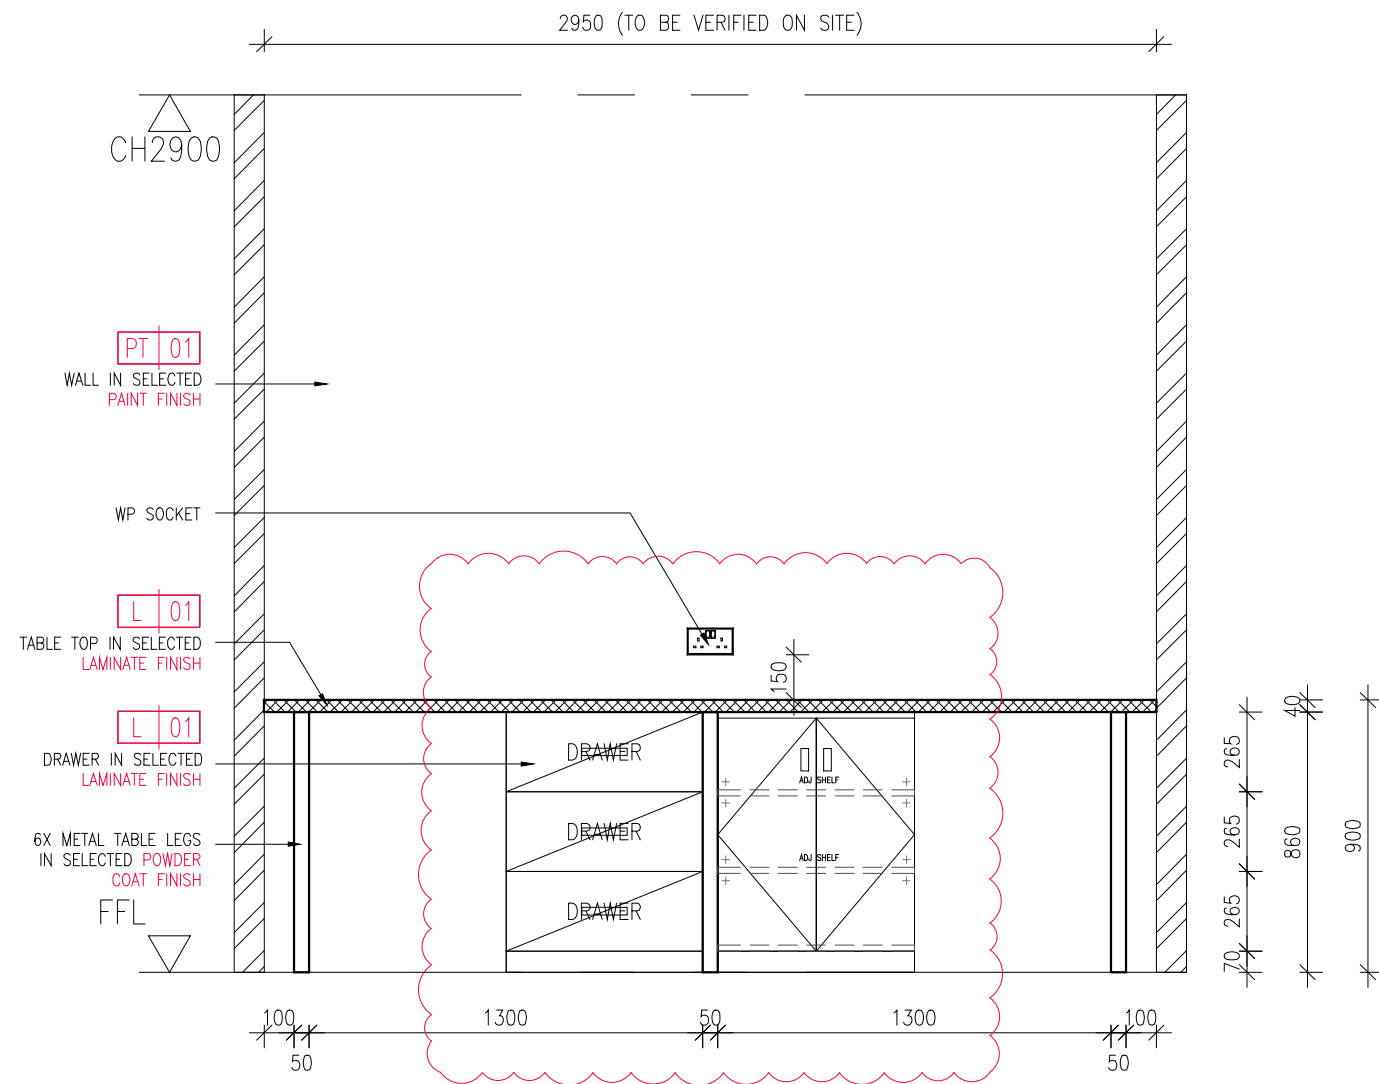

01 EQUIPMENT SERVICING ROOM - ELEVATION
SCALE 1:25

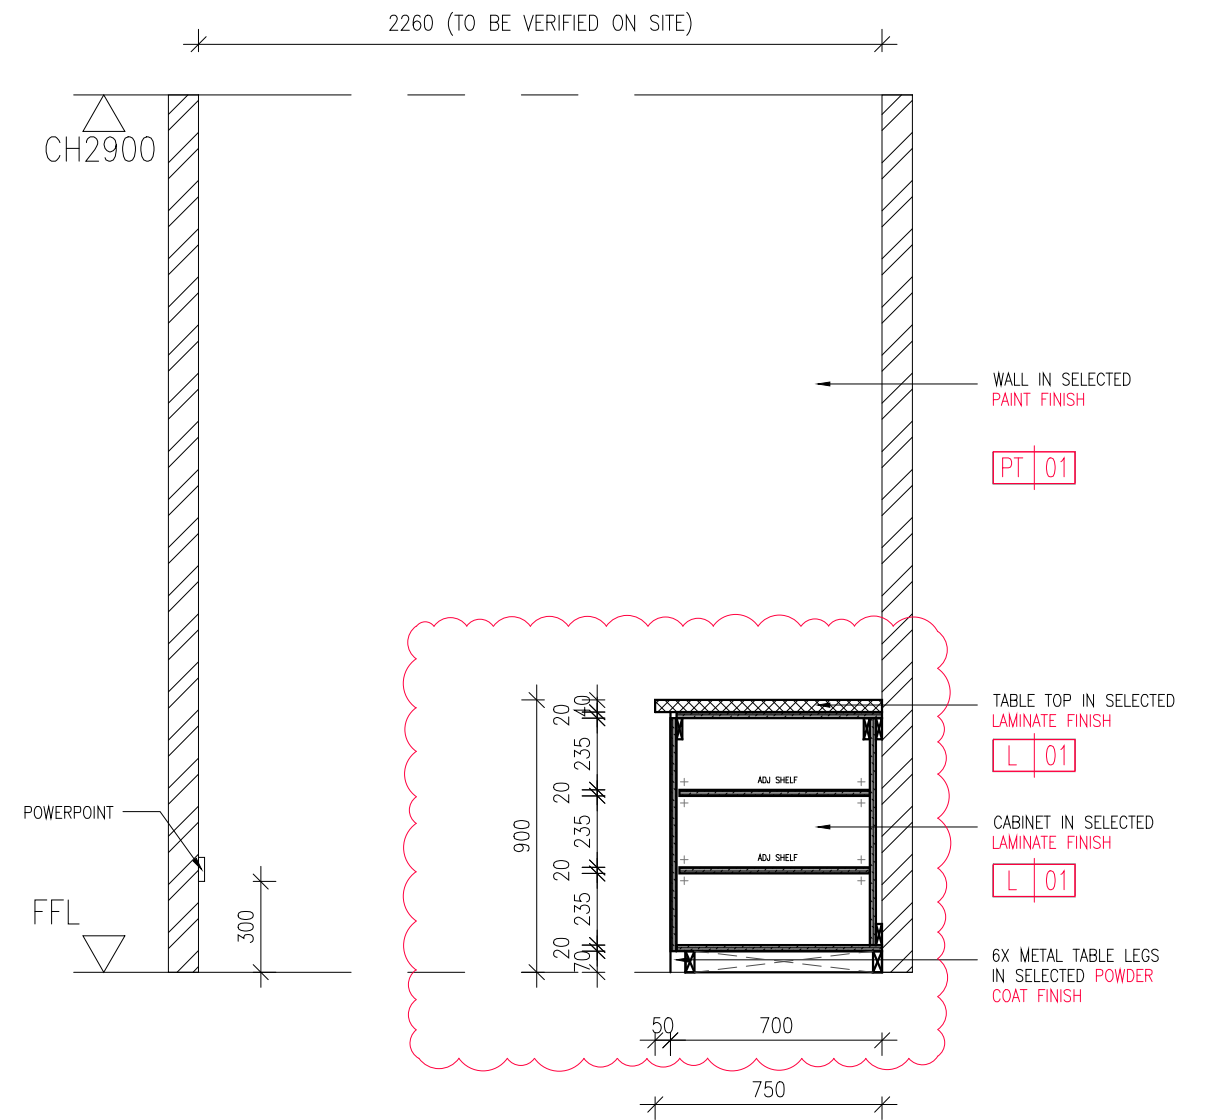

02 EQUIPMENT SERVICING ROOM - SECTION
SCALE 1:25

GENERAL NOTES

ALL DIMENSIONS SHOWN ARE IN MILLIMETRES & SHALL BE VERIFIED ON SITE BY THE CONTRACTOR OR SUB-CONTRACTOR.
ALL DIMENSIONS SHOULD NOT BE SCALED FROM THE DRAWING UNLESS OTHERWISE INSTRUCTED. ANY DISCREPANCIES SHALL BE MADE KNOWN TO THE DESIGNER FOR DECISION PRIOR TO PROCEEDING OF THE WORK.

PROJECT TITLE

PROPOSED RENOVATION WORKS TO ROSSA

DRAWING TITLE

EQUIPMENT SERVICING ROOM - ELEVATION & SECTION

SCALE

AS SHOWN (@ A3 PRINT)

DATE

30 AUG 2021

DRAWN

SY

FILENAME

-


VERSION

B

ORCHITOLOG
(PRIVATE) LIMITED

DRAWING NO.

521

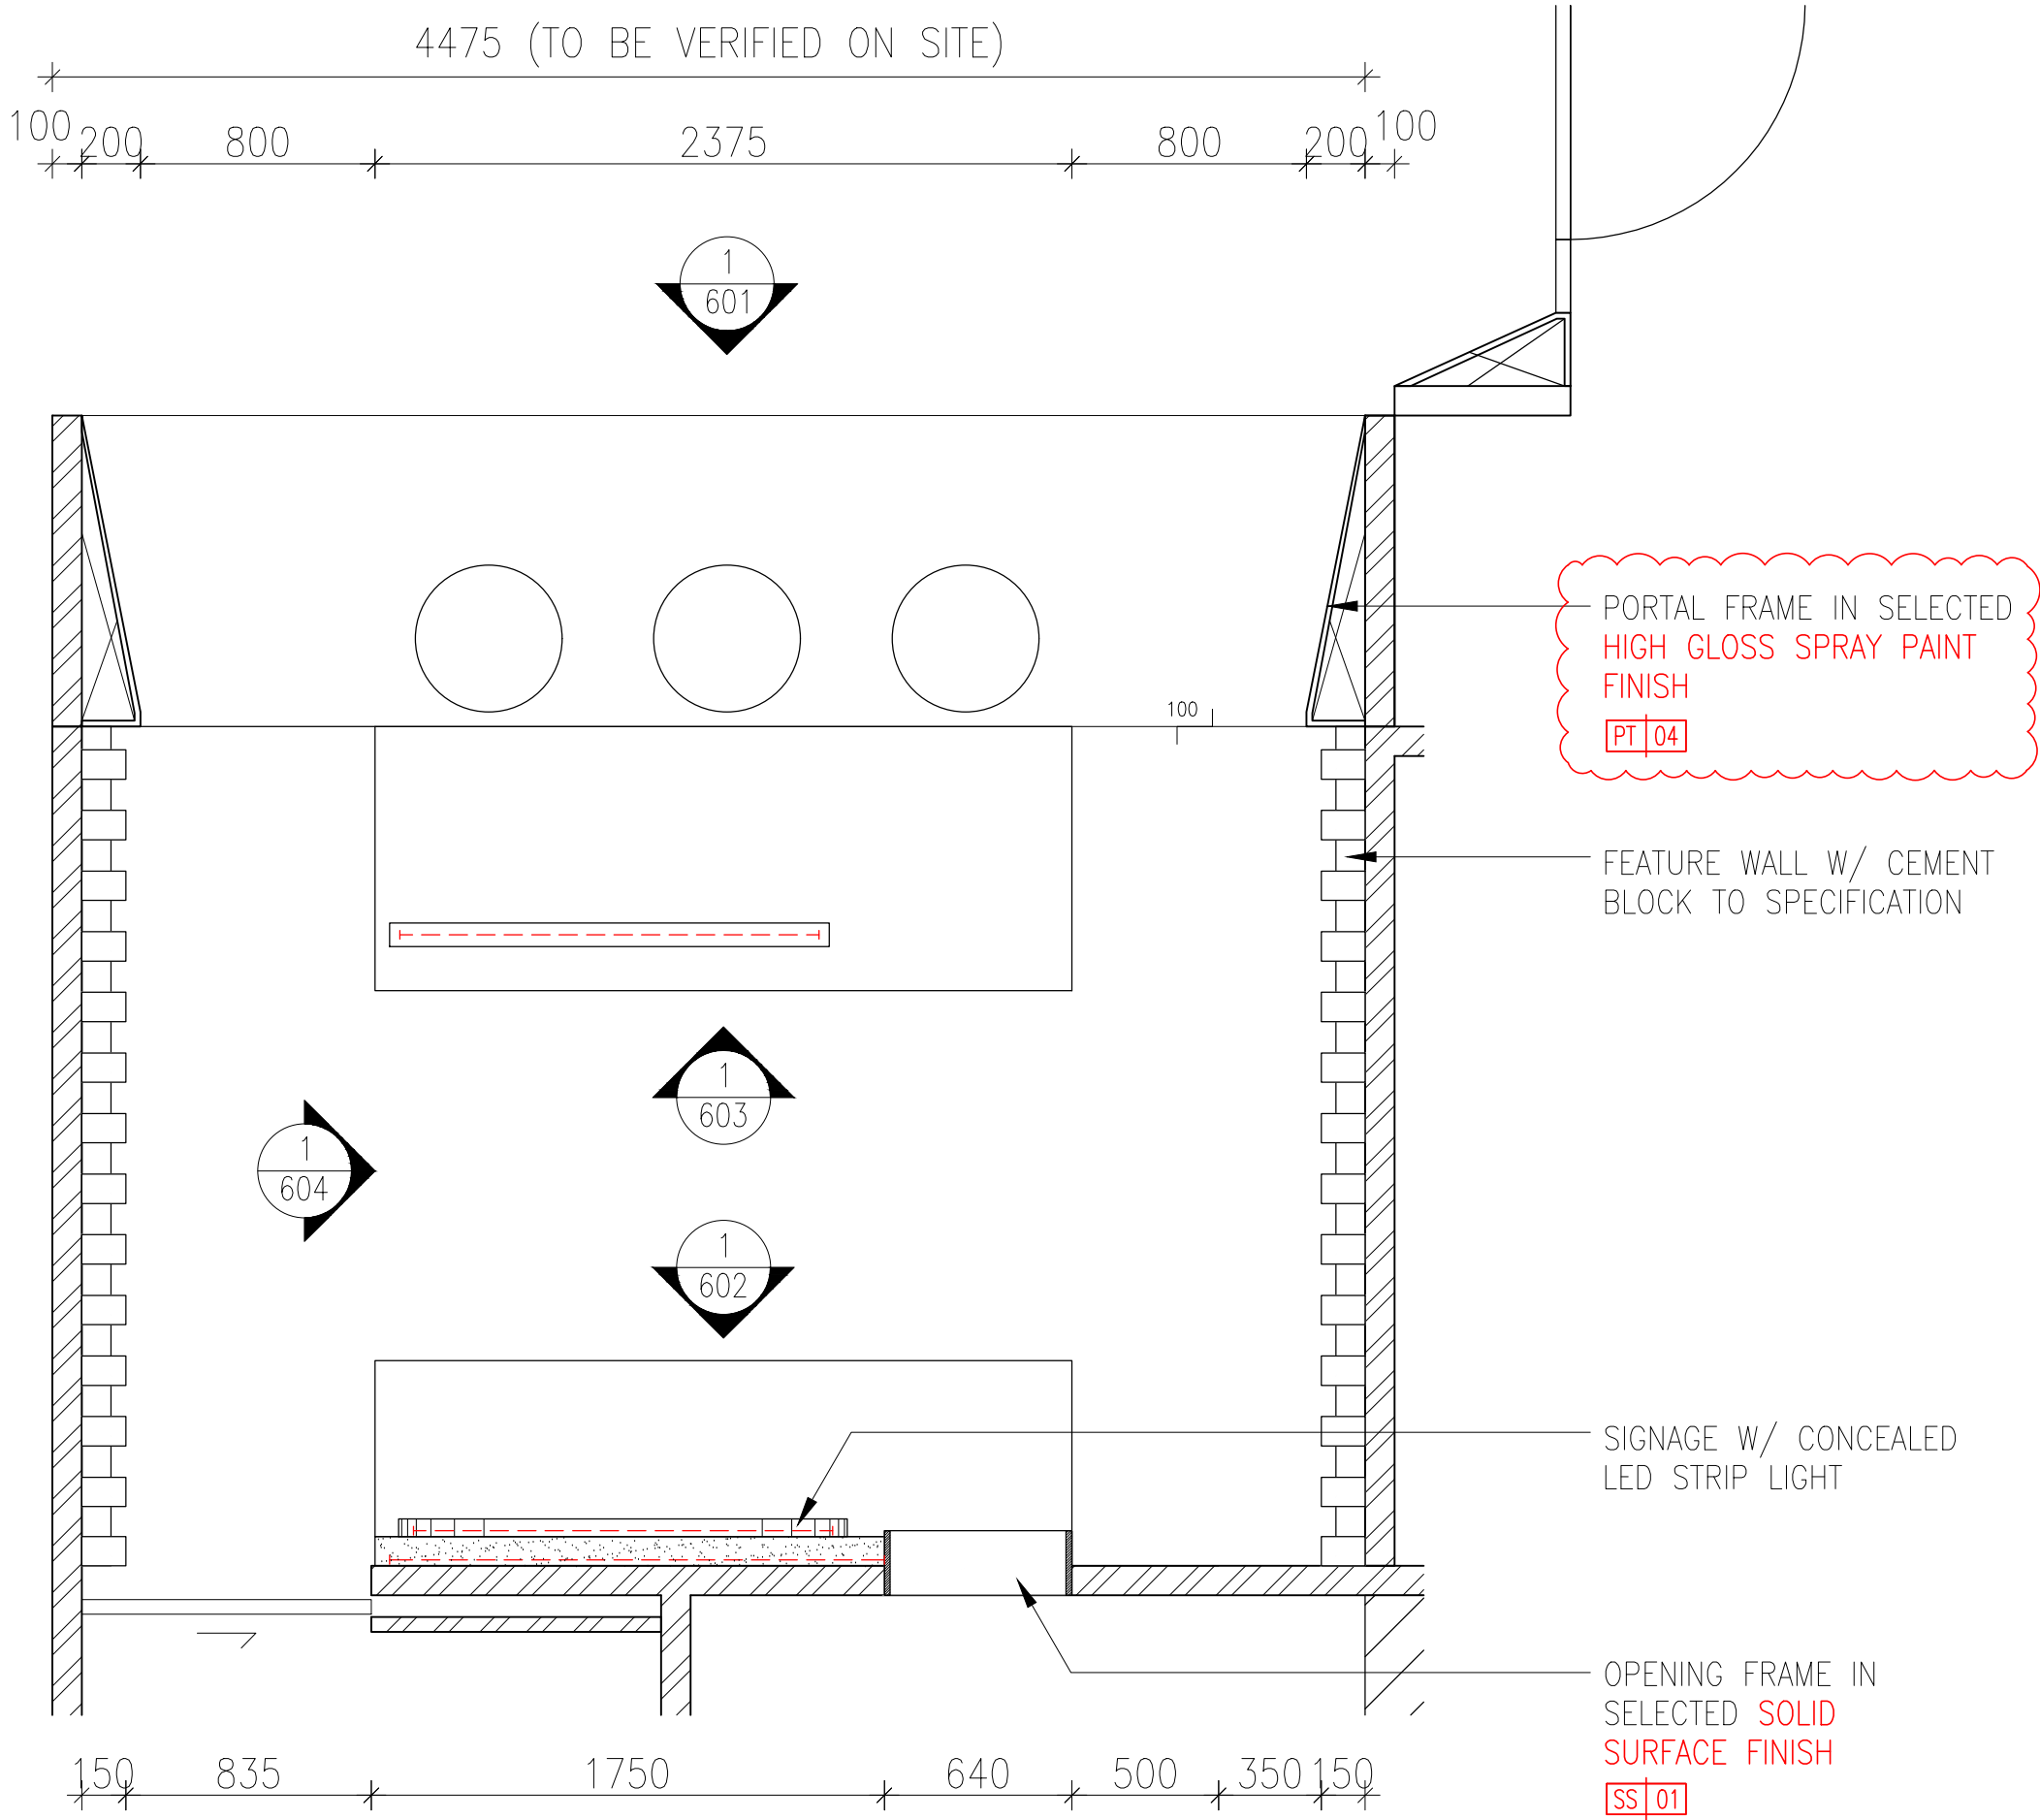

GENERAL NOTES

ALL DIMENSIONS SHOWN ARE IN MILLIMETRES & SHALL BE VERIFIED ON SITE BY THE CONTRACTOR OR SUB-CONTRACTOR.

ALL DIMENSIONS SHOULD NOT BE SCALED FROM THE DRAWING UNLESS OTHERWISE INSTRUCTED. ANY DISCREPANCIES SHALL BE MADE KNOWN TO THE DESIGNER FOR DECISION PRIOR TO PROCEEDING OF THE WORK.

PROJECT TITLE

PROPOSED RENOVATION WORKS TO ROSSA


DRAWING TITLE

CAFÉ PART PLAN

SCALE	AS SHOWN (@ A3 PRINT)
DATE	JUNE 2021
DRAWN	SZM
FILENAME	-
VERSION	B

ORCHITOLOGY
(PRIVATE) LIMITED

DRAWING NO. 600

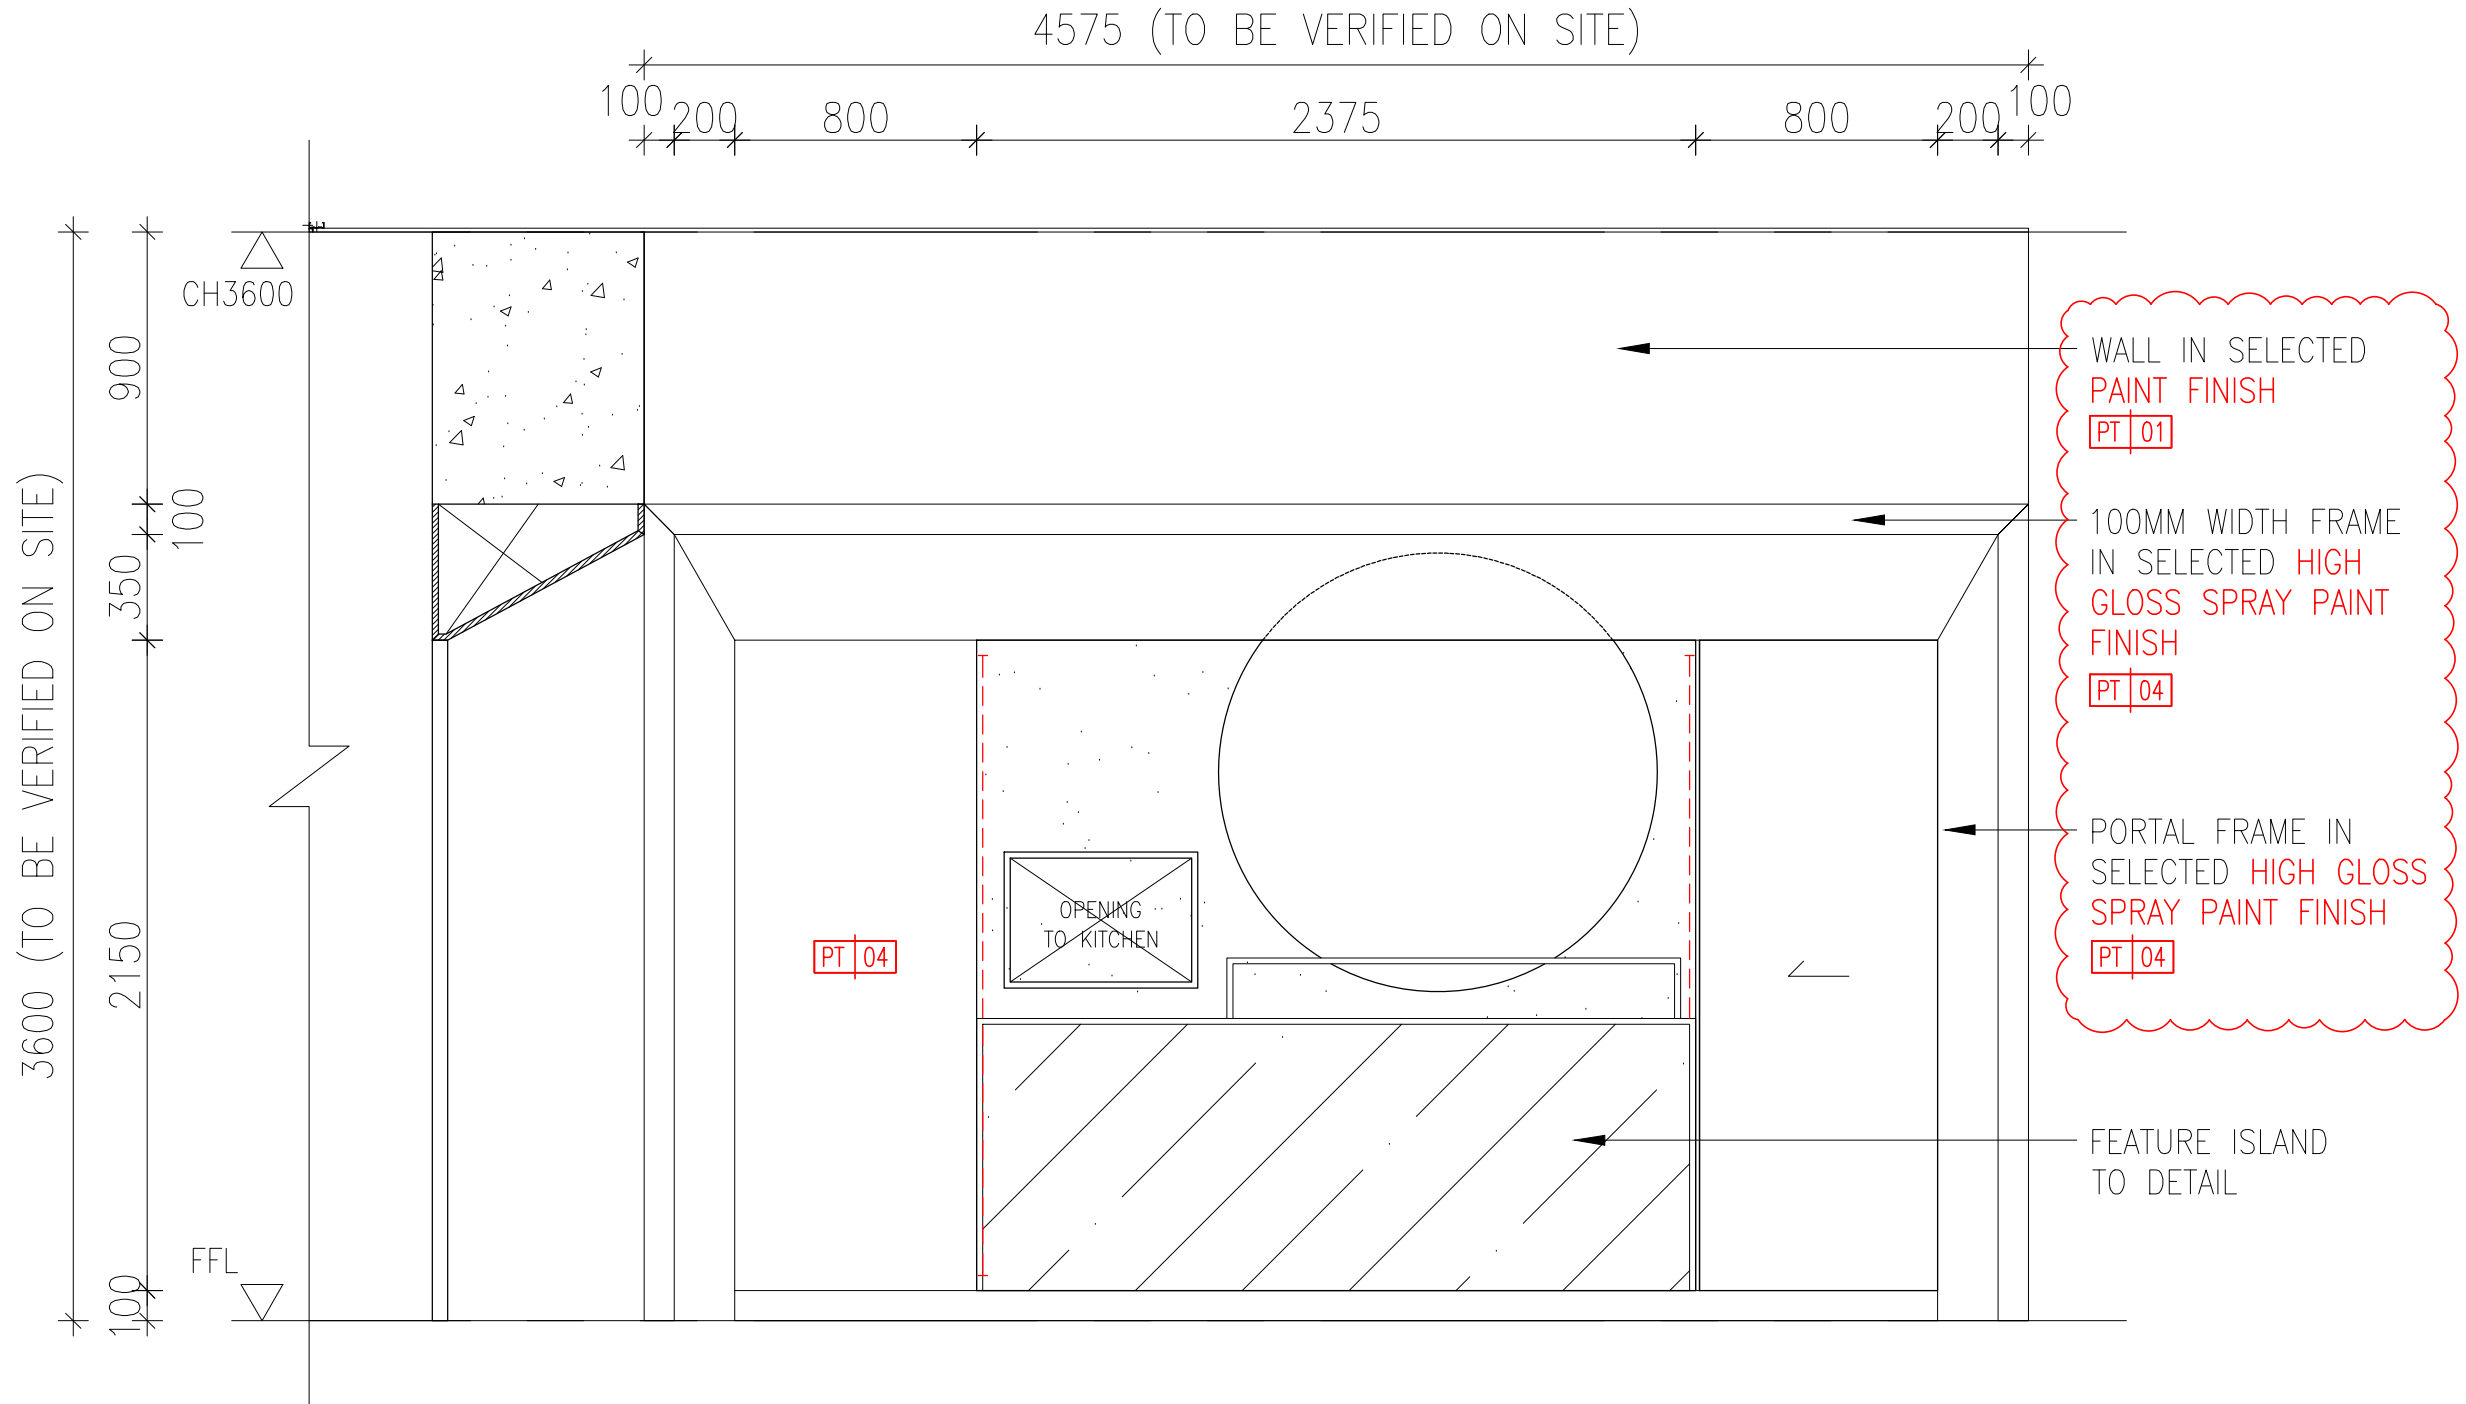

01
601 CAFÉ ELEVATION 1
SCALE 1:25

GENERAL NOTES

ALL DIMENSIONS SHOWN ARE IN MILLIMETRES & SHALL BE VERIFIED ON SITE BY THE CONTRACTOR OR SUB-CONTRACTOR. ALL DIMENSIONS SHOULD NOT BE SCALED FROM THE DRAWING UNLESS OTHERWISE INSTRUCTED. ANY DISCREPANCIES SHALL BE MADE KNOWN TO THE DESIGNER FOR DECISION PRIOR TO PROCEEDING OF THE WORK.

PROJECT TITLE


PROPOSED RENOVATION WORKS TO ROSSA

DRAWING TITLE

CAFÉ ELEVATION 1

SCALE	AS SHOWN (@ A3 PRINT)
DATE	JUNE 2021
DRAWN	SZM
FILENAME	-
VERSION	B

ORCHITOLOGY
(PRIVATE) LIMITED
DRAWING NO. 601

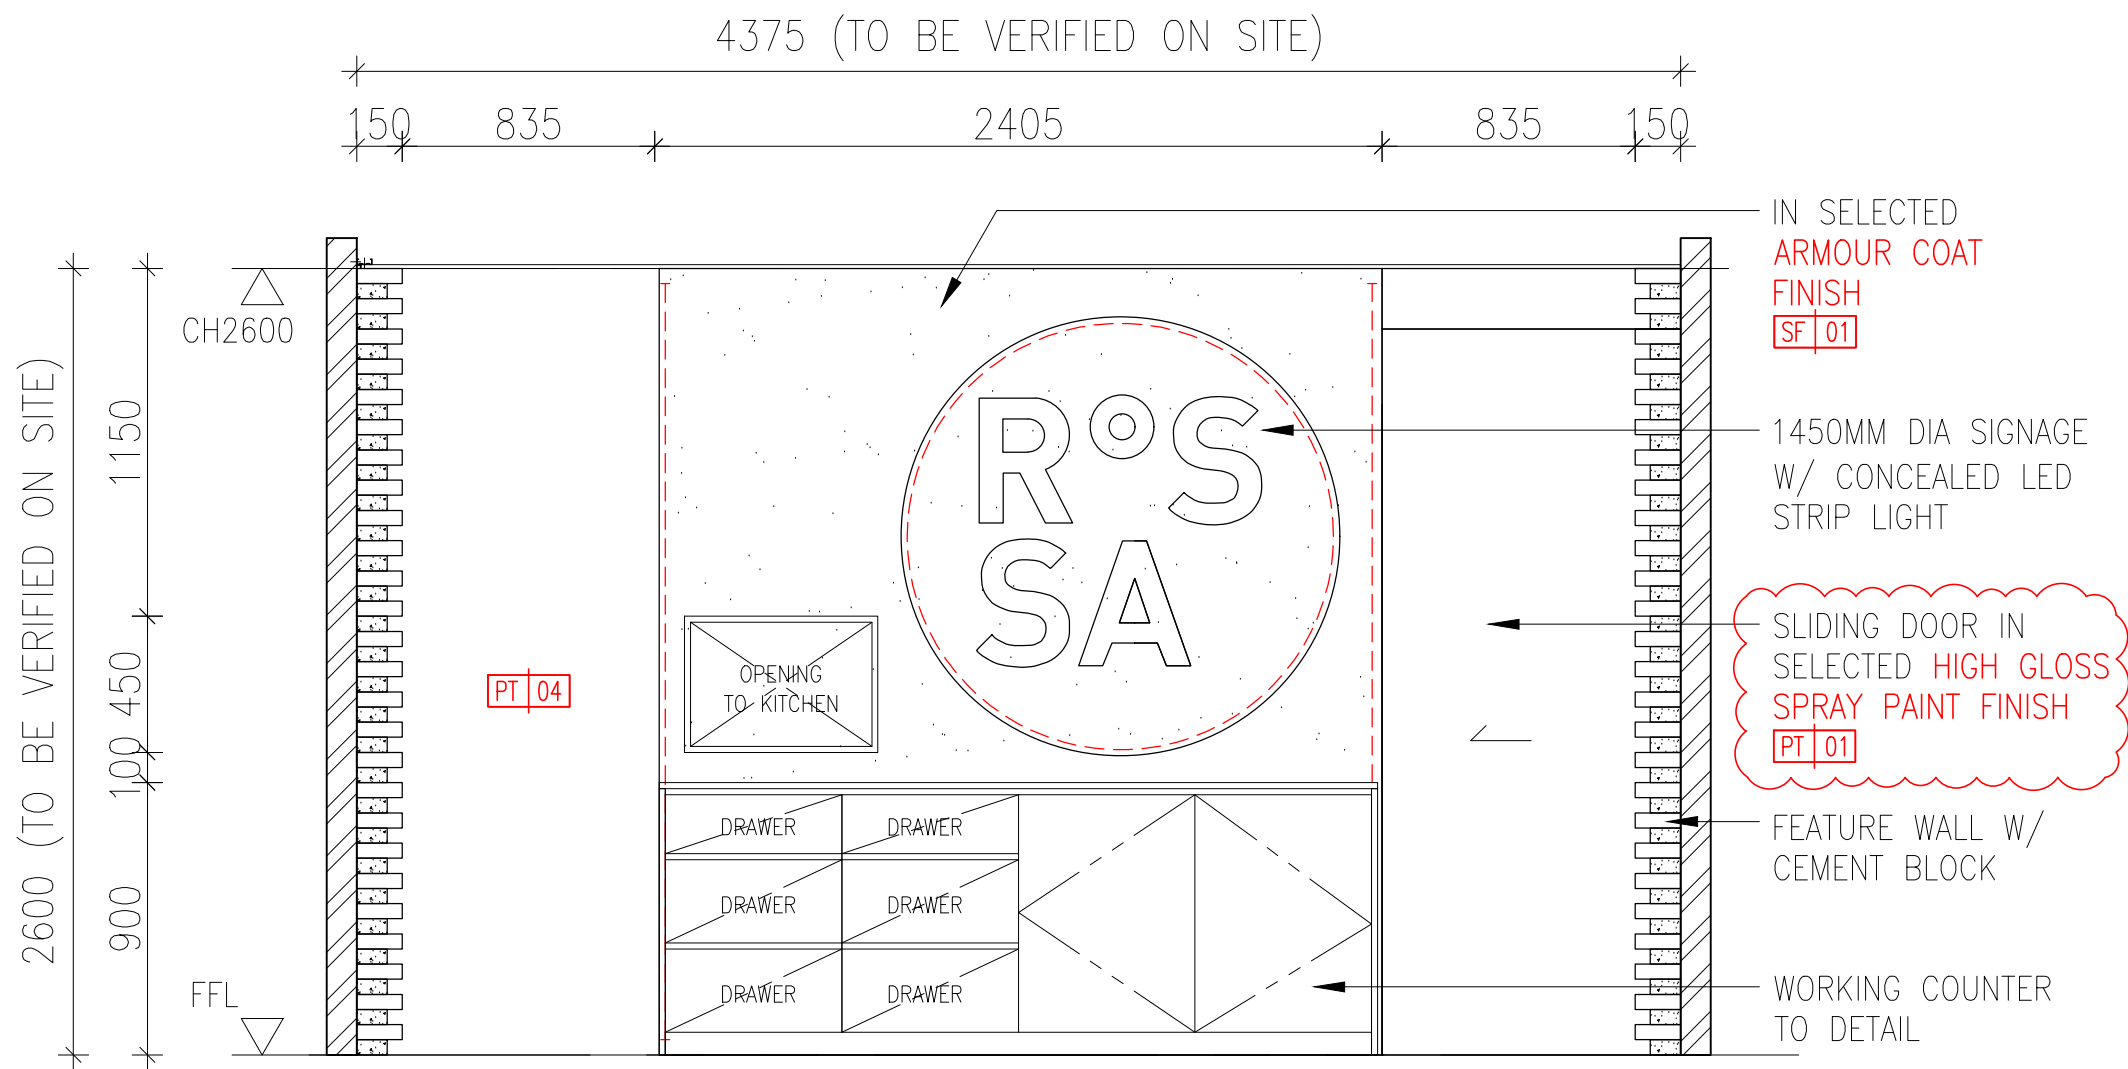

01 CAFÉ ELEVATION 2
602 SCALE 1:25

GENERAL NOTES

ALL DIMENSIONS SHOWN ARE IN MILLIMETRES & SHALL BE VERIFIED ON SITE BY THE CONTRACTOR OR SUB-CONTRACTOR. ALL DIMENSIONS SHOULD NOT BE SCALED FROM THE DRAWING UNLESS OTHERWISE INSTRUCTED. ANY DISCREPANCIES SHALL BE MADE KNOWN TO THE DESIGNER FOR DECISION PRIOR TO PROCEEDING OF THE WORK.

PROJECT TITLE


PROPOSED RENOVATION WORKS TO ROSSA

DRAWING TITLE

CAFÉ ELEVATION 2

SCALE	AS SHOWN (@ A3 PRINT)
DATE	JUNE 2021
DRAWN	SZM
FILENAME	-
VERSION	B

ORCHITOLGY
(PRIVATE) LIMITED
DRAWING NO. 602

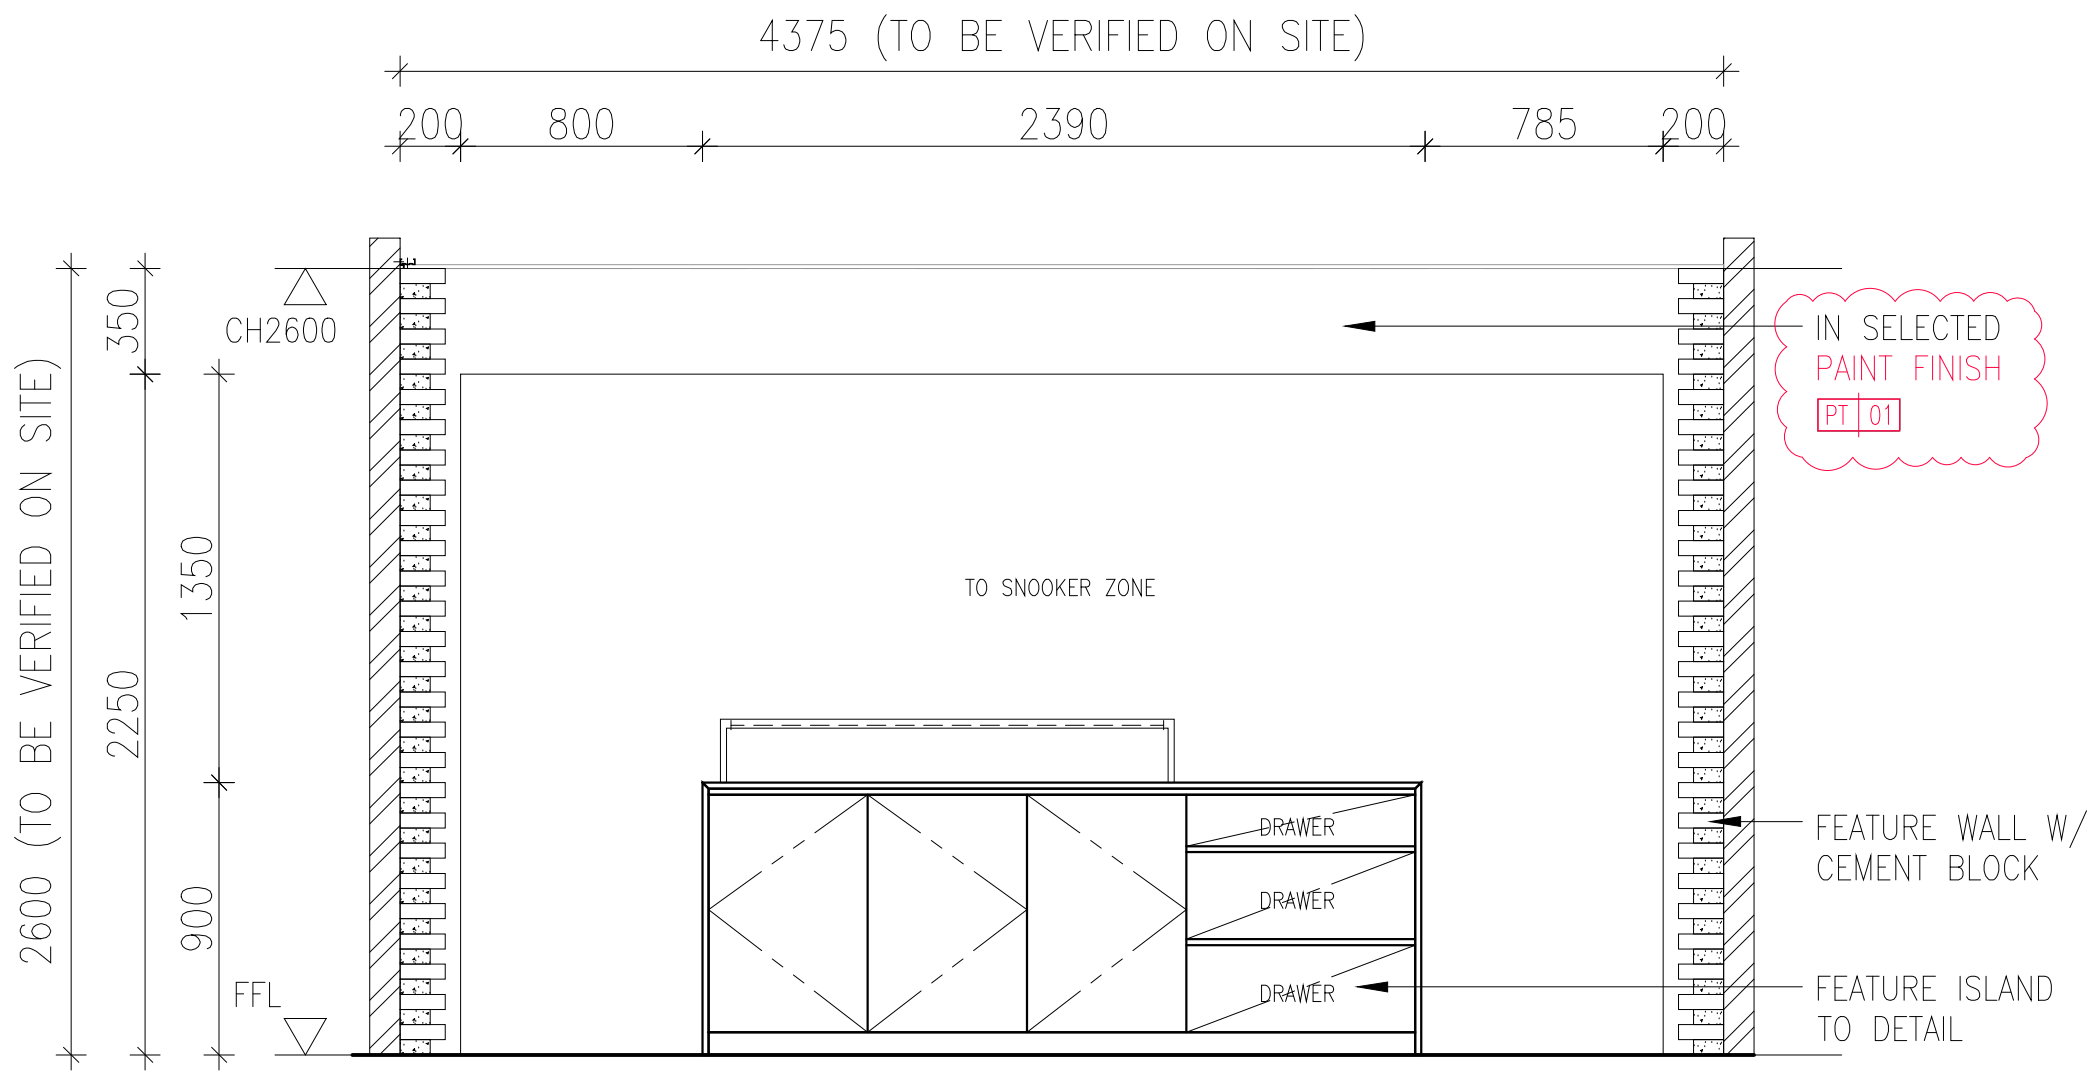

1
603 CAFÉ ELEVATION 3
SCALE 1:25

GENERAL NOTES

ALL DIMENSIONS SHOWN ARE IN MILLIMETRES & SHALL BE VERIFIED ON SITE BY THE CONTRACTOR OR SUB-CONTRACTOR.

ALL DIMENSIONS SHOULD NOT BE SCALED FROM THE DRAWING UNLESS OTHERWISE INSTRUCTED. ANY DISCREPANCIES SHALL BE MADE KNOWN TO THE DESIGNER FOR DECISION PRIOR TO PROCEEDING OF THE WORK.

PROJECT TITLE


PROPOSED RENOVATION WORKS TO ROSSA

DRAWING TITLE

CAFÉ ELEVATION 3

SCALE	AS SHOWN (@ A3 PRINT)
DATE	JUNE 2021
DRAWN	SZM
FILENAME	-
VERSION	A

ORCHITOLOGY
(PRIVATE) LIMITED
DRAWING NO. 603

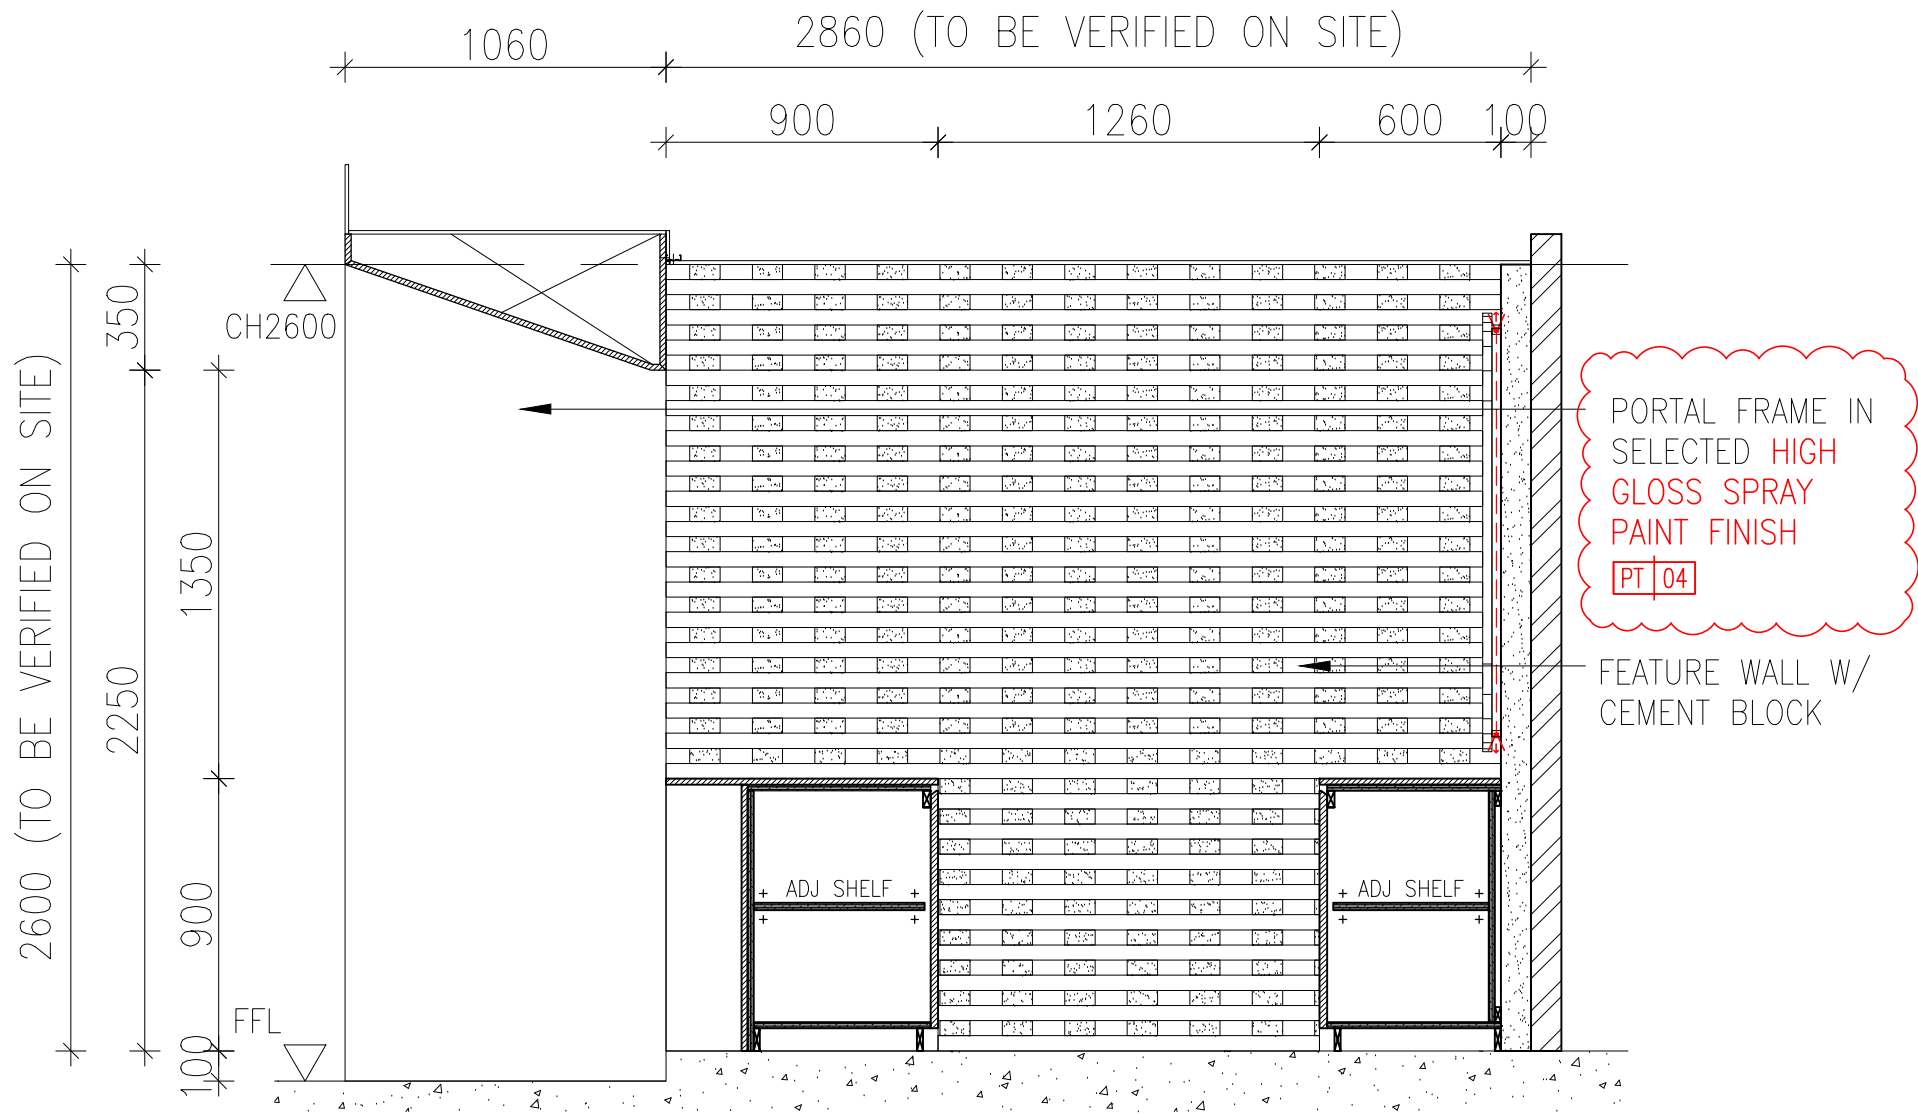

01
604 CAFÉ ELEVATION 4
SCALE 1:25

GENERAL NOTES

ALL DIMENSIONS SHOWN ARE IN MILLIMETRES & SHALL BE VERIFIED ON SITE BY THE CONTRACTOR OR SUB-CONTRACTOR.

ALL DIMENSIONS SHOULD NOT BE SCALED FROM THE DRAWING UNLESS OTHERWISE INSTRUCTED. ANY DISCREPANCIES SHALL BE MADE KNOWN TO THE DESIGNER FOR DECISION PRIOR TO PROCEEDING OF THE WORK.

PROJECT TITLE

PROPOSED RENOVATION WORKS TO ROSSA


DRAWING TITLE

CAFÉ ELEVATION 4


SCALE	AS SHOWN (@ A3 PRINT)
DATE	JUNE 2021
DRAWN	SZM
FILENAME	-
VERSION	B

ORCHITOLOGY
(PRIVATE) LIMITED


DRAWING NO. 604

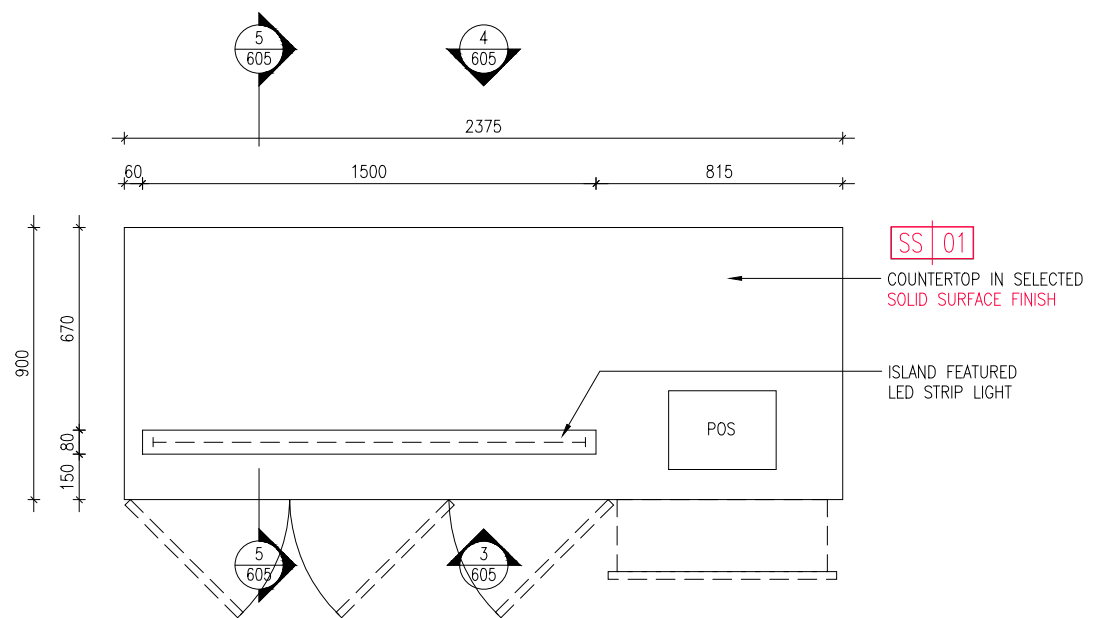


01 605 CAFÉ - FEATURE ISLAND - PART PLAN
SCALE 1:25

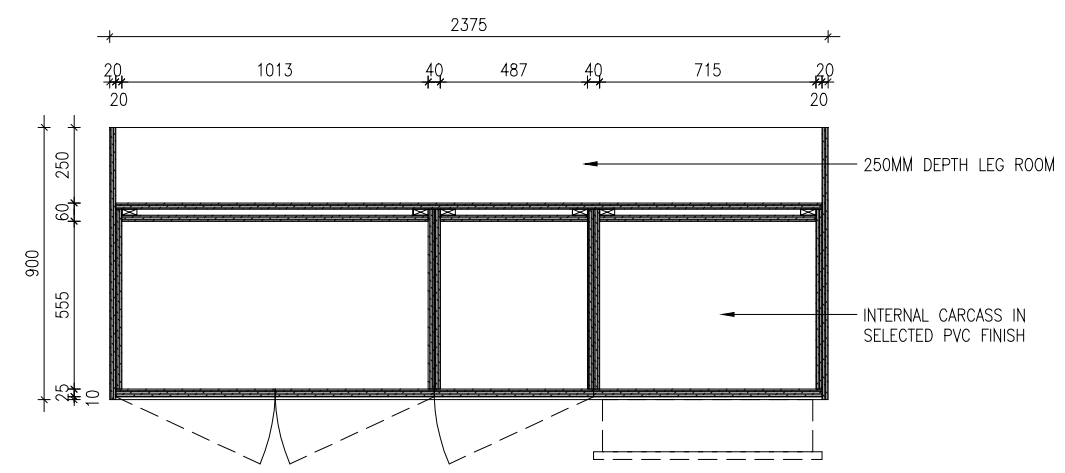


02 605 CAFÉ - FEATURE ISLAND - SECTIONAL PART PLAN
SCALE 1:25

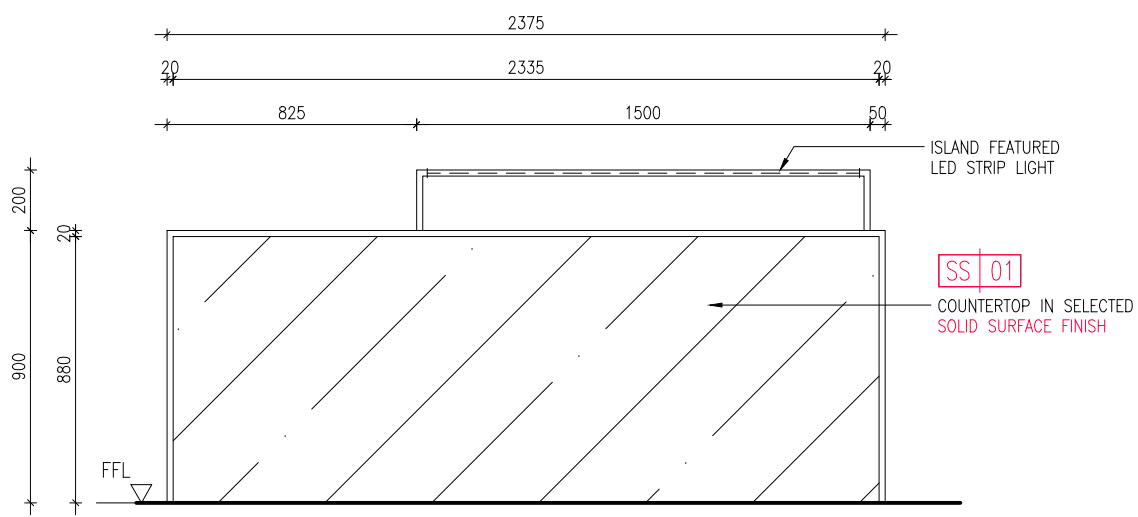

03 605 CAFÉ - FEATURE ISLAND - ELEVATION 1
SCALE 1:25

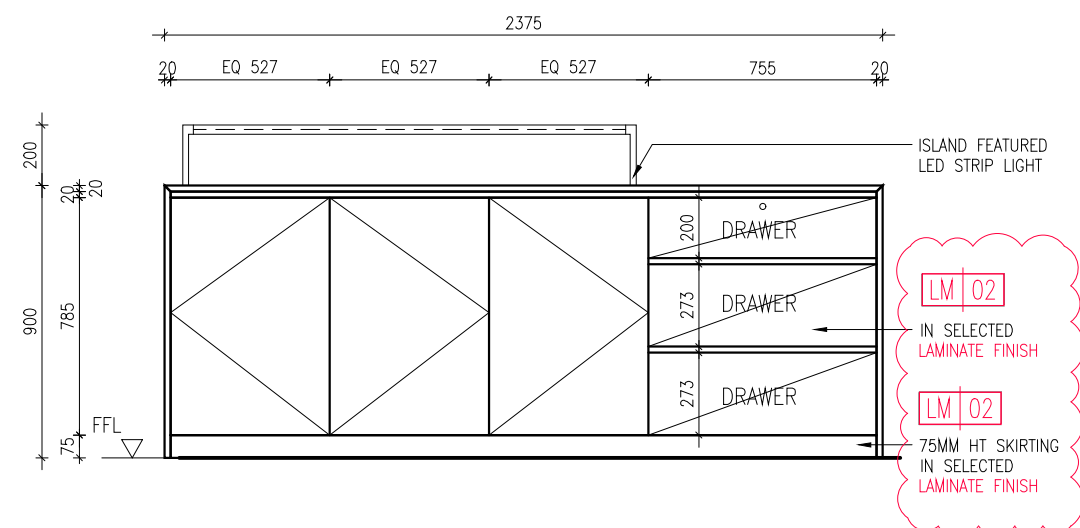

04 605 CAFÉ - FEATURE ISLAND - ELEVATION 2
SCALE 1:25

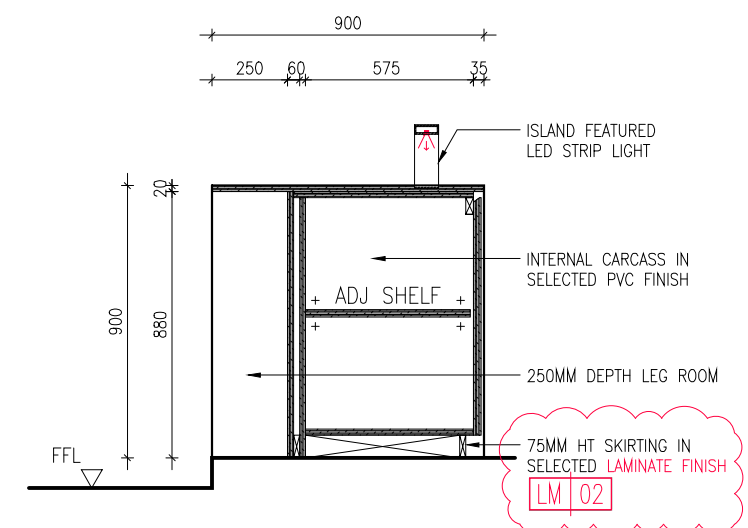

05 605 CAFÉ - FEATURE ISLAND - SECTION
SCALE 1:25

GENERAL NOTES

ALL DIMENSIONS SHOWN ARE IN MILLIMETRES & SHALL BE VERIFIED ON SITE BY THE CONTRACTOR OR SUB-CONTRACTOR.
ALL DIMENSIONS SHOULD NOT BE SCALED FROM THE DRAWING UNLESS OTHERWISE INSTRUCTED. ANY DISCREPANCIES SHALL BE MADE KNOWN TO THE DESIGNER FOR DECISION PRIOR TO PROCEEDING OF THE WORK.

PROJECT TITLE


PROPOSED RENOVATION WORKS TO ROSSA

DRAWING TITLE


CAFÉ - FEATURE ISLAND DETAIL

SCALE	AS SHOWN (@ A3 PRINT)
DATE	JUNE 2021
DRAWN	SZM
FILENAME	-
VERSION	B


ORCHITOLGY
(PRIVATE) LIMITED
DRAWING NO. 605

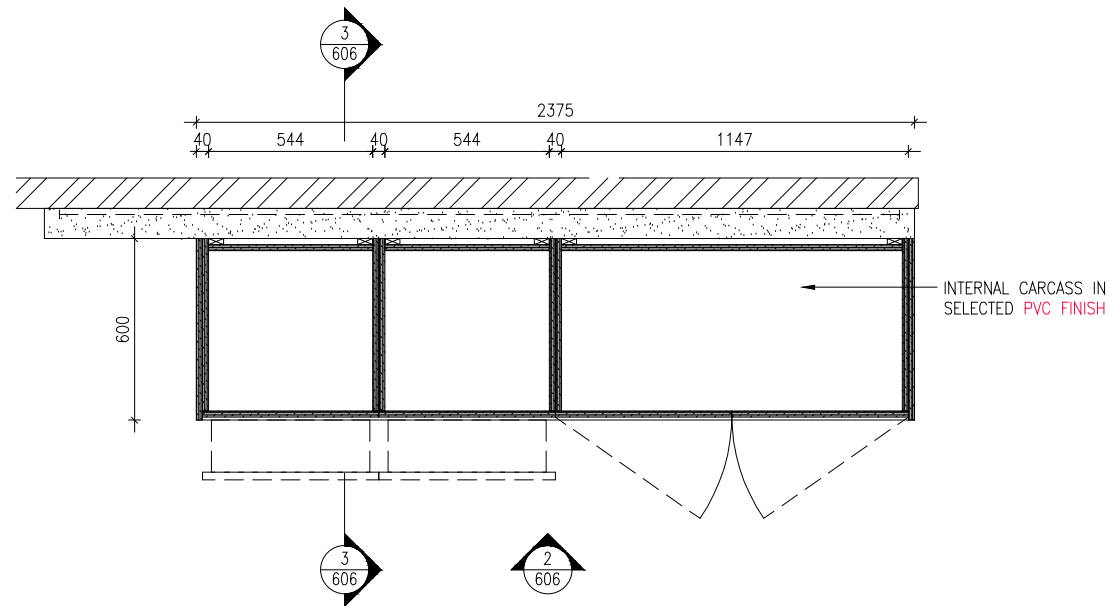

01
606 CAFÉ WORKING COUNTER - SECTIONAL PLAN VIEW
SCALE 1:25

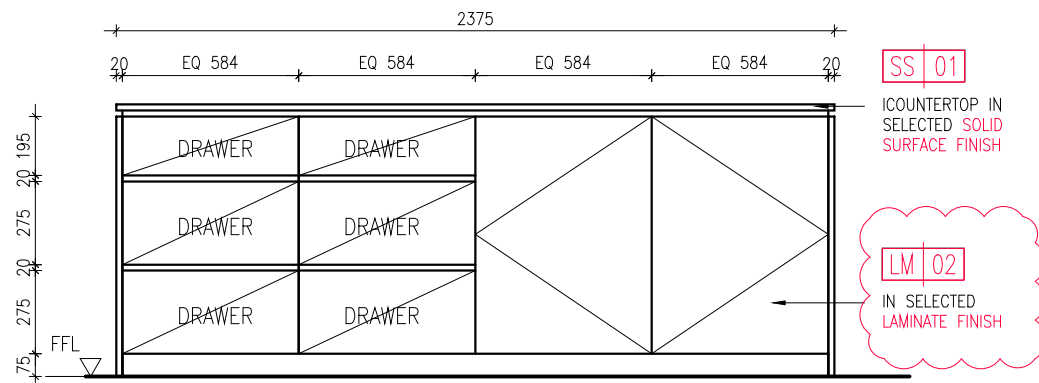

02
606 CAFÉ WORKING COUNTER - ELEVATION 1
SCALE 1:25

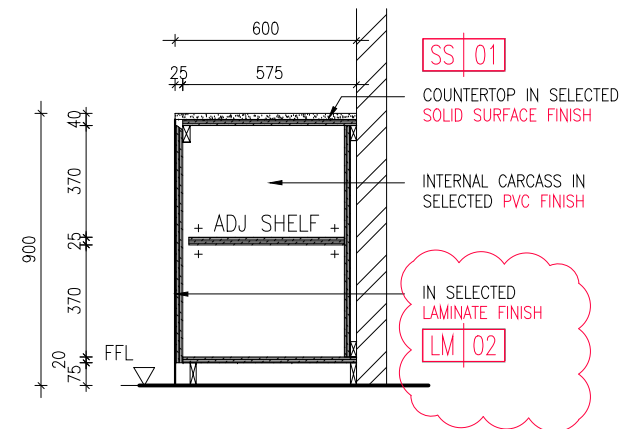

03
606 CAFÉ WORKING COUNTER - SECTION
SCALE 1:25

GENERAL NOTES

ALL DIMENSIONS SHOWN ARE IN MILLIMETRES & SHALL BE VERIFIED ON SITE BY THE CONTRACTOR OR SUB-CONTRACTOR.

ALL DIMENSIONS SHOULD NOT BE SCALED FROM THE DRAWING UNLESS OTHERWISE INSTRUCTED. ANY DISCREPANCIES SHALL BE MADE KNOWN TO THE DESIGNER FOR DECISION PRIOR TO PROCEEDING OF THE WORK.

PROJECT TITLE

PROPOSED RENOVATION WORKS TO ROSSA

DRAWING TITLE

CAFÉ - WORKING COUNTER DETAIL

SCALE AS SHOWN (@ A3 PRINT)

DATE JUNE 2021

DRAWN SZM


FILENAME -

VERSION B

ORCHITOL

(PRIVATE) LIMITED

DRAWING NO. 606

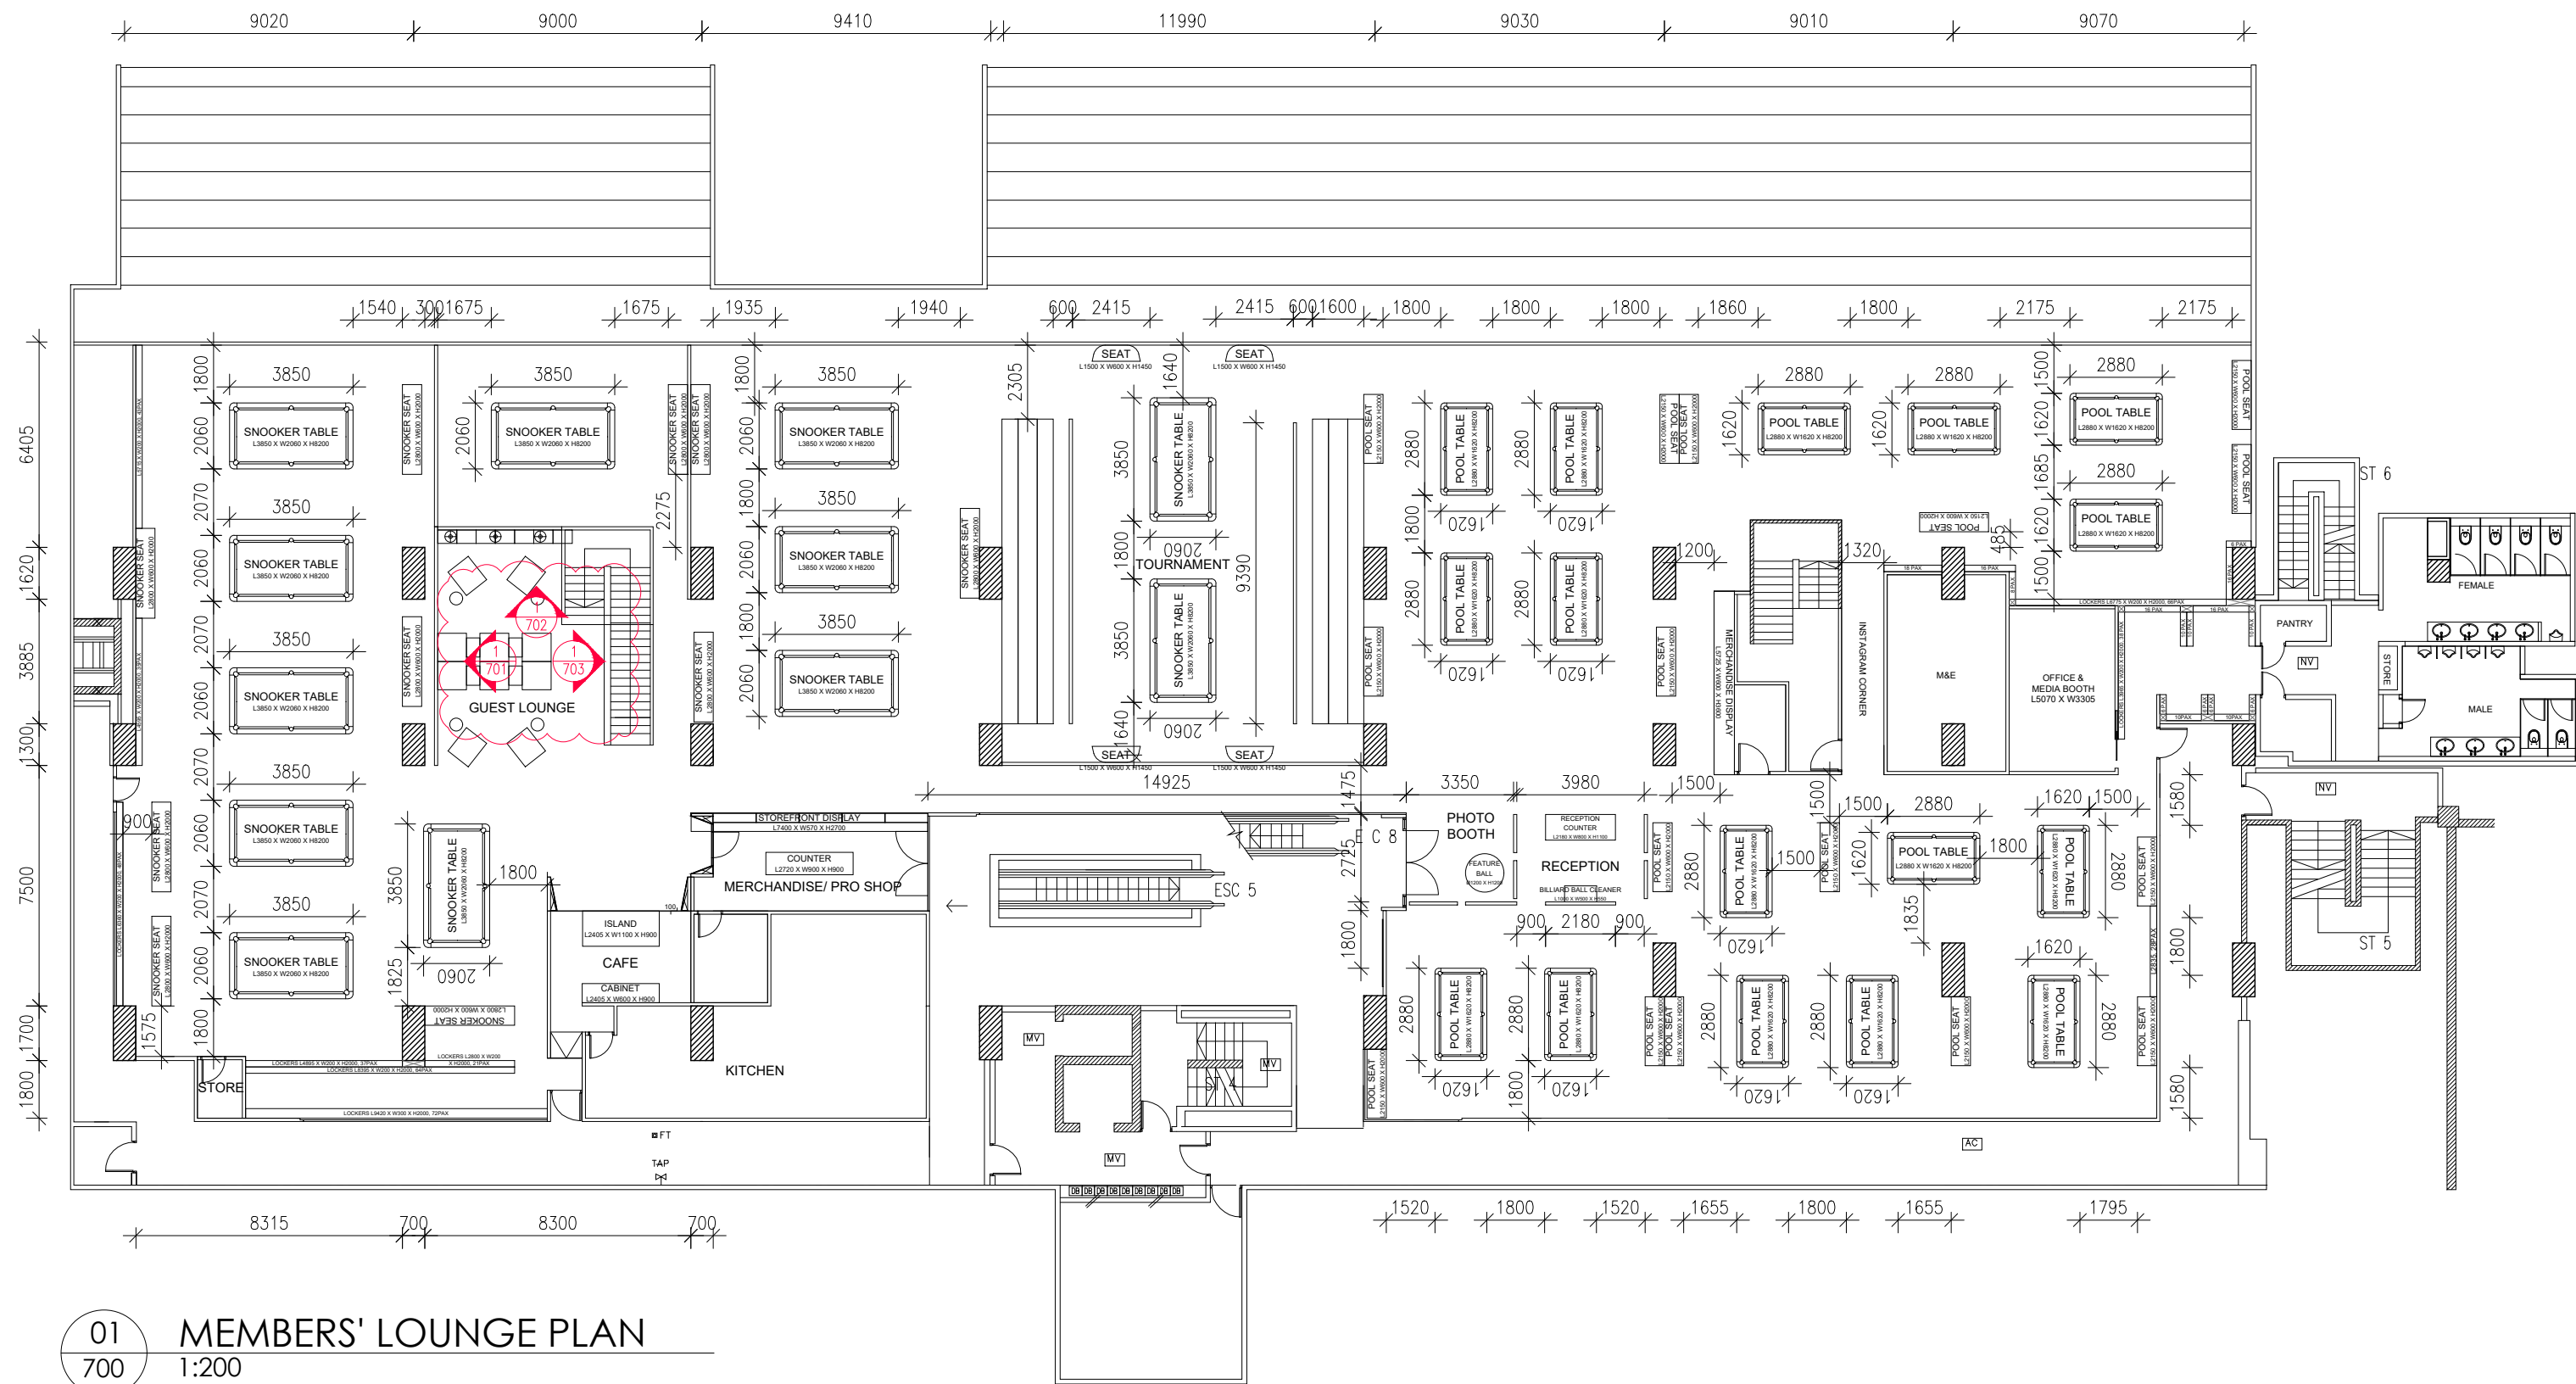

GENERAL NOTES

ALL DIMENSIONS SHOWN ARE IN MILLIMETRES & SHALL BE VERIFIED ON SITE BY THE CONTRACTOR OR SUB-CONTRACTOR.
ALL DIMENSIONS SHOULD NOT BE SCALED FROM THE DRAWING UNLESS OTHERWISE INSTRUCTED. ANY DISCREPANCIES SHALL BE MADE KNOWN TO THE DESIGNER FOR DECISION PRIOR TO PROCEEDING OF THE WORK.

PROJECT TITLE

PROPOSED RENOVATION WORKS TO
ROSSA

DRAWING TITLE

MEMBERS' LOUNGE PLAN

SCALE

AS SHOWN (@A3 PRINT)

DATE

07 JUL 2021

DRAWN

SY

FILENAME

ROSSA


VERSION

A

OICHITOLOGY
(PRIVATE) LIMITED

DRAWING NO.

700

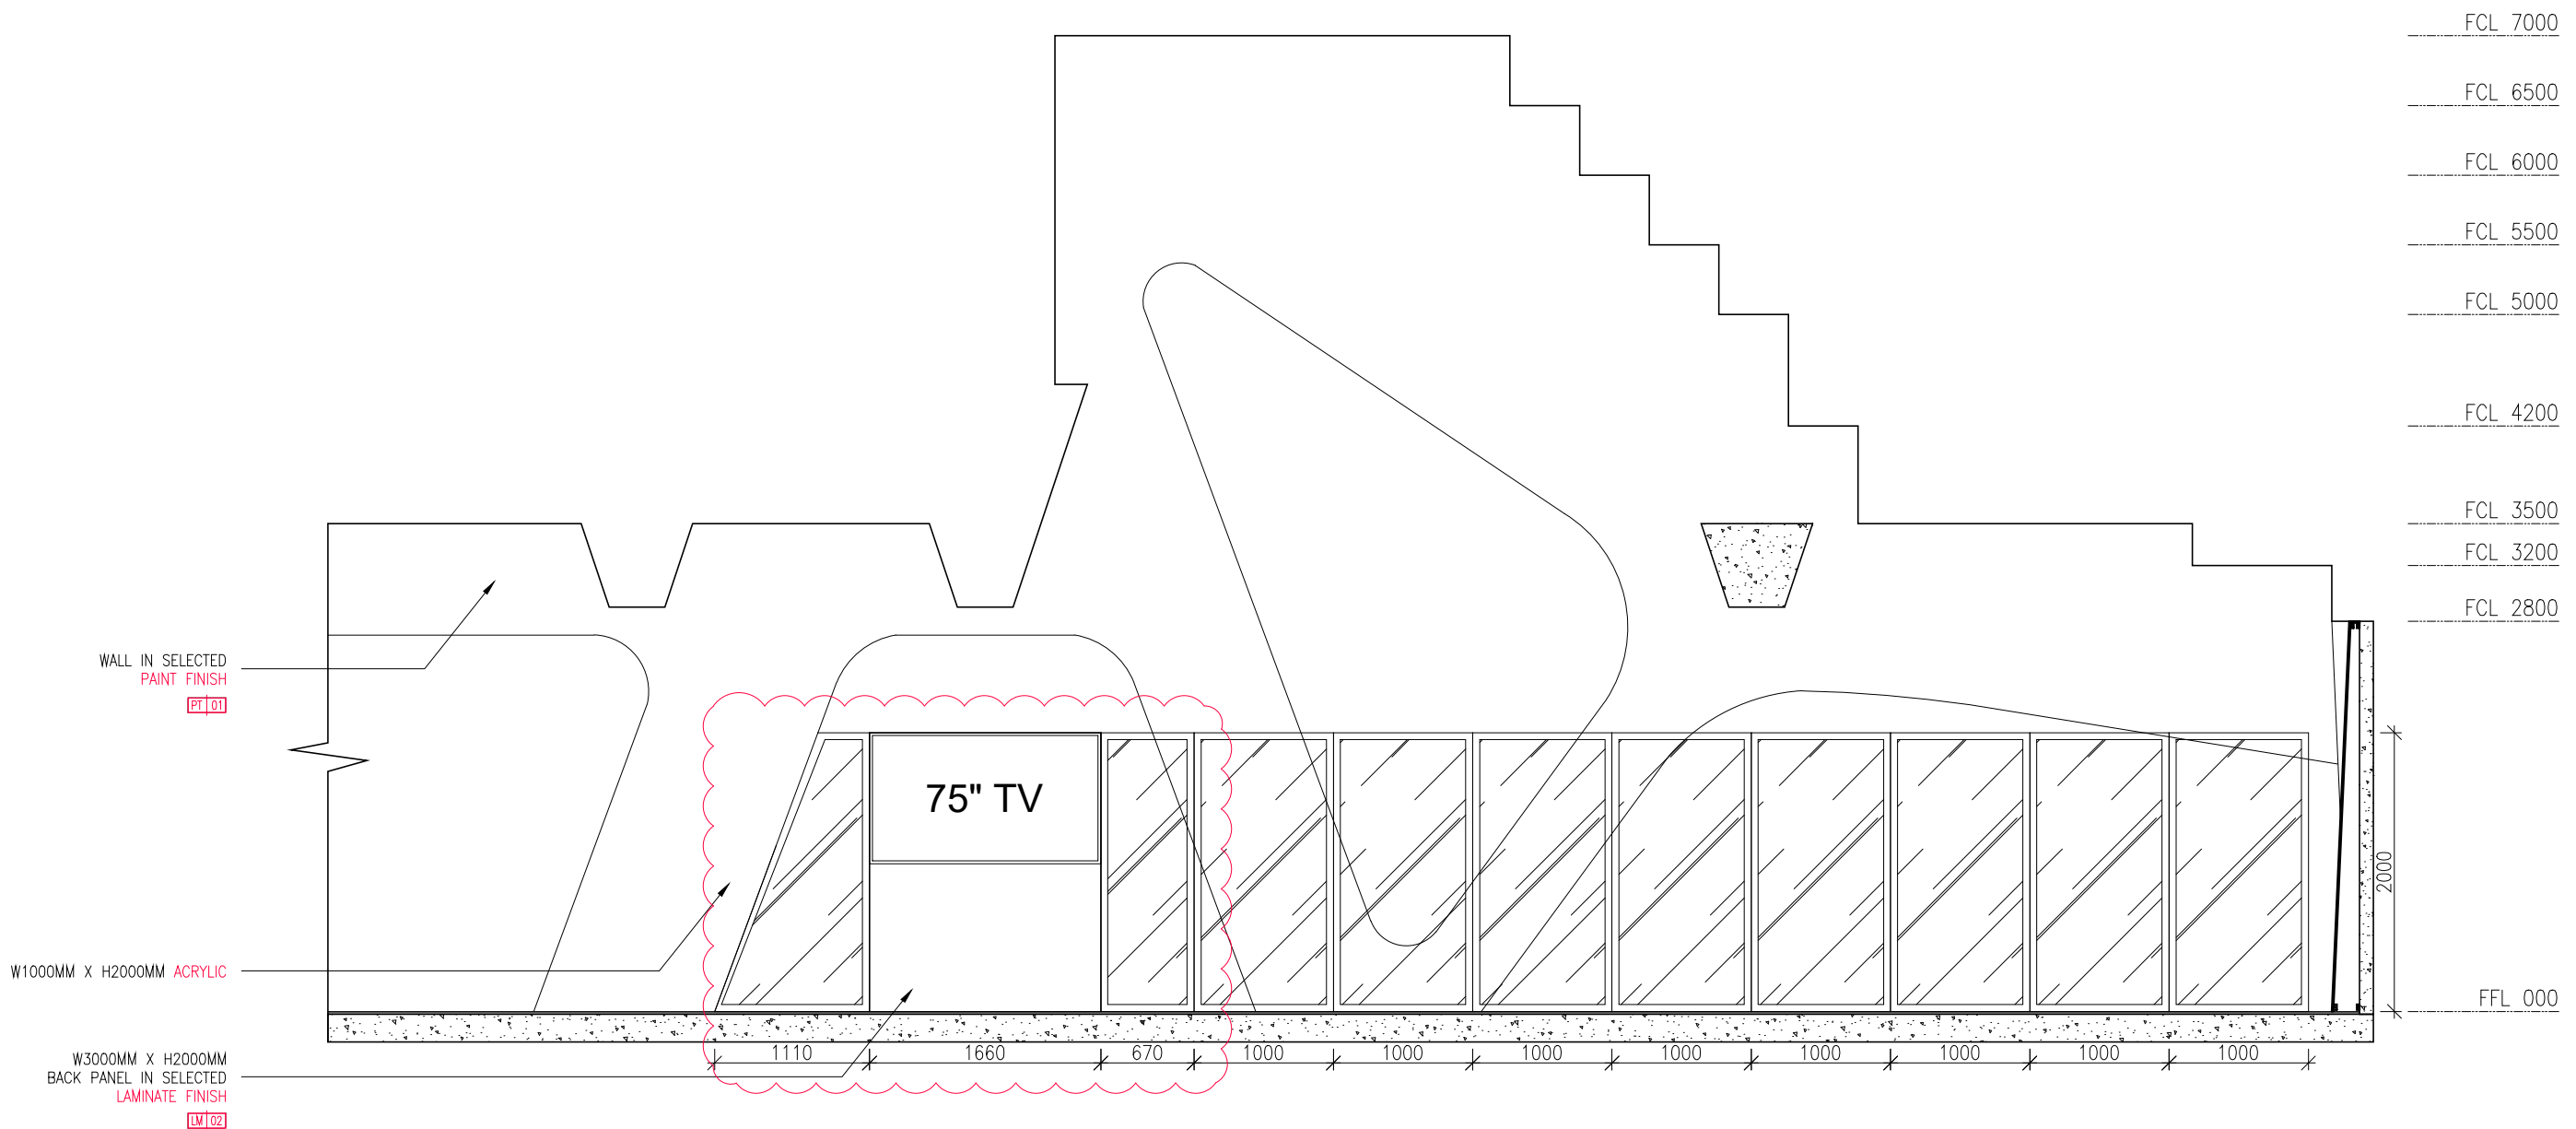

01
701 MEMBERS' LOUNGE ELEVATION
1:50

GENERAL NOTES

ALL DIMENSIONS SHOWN ARE IN MILLIMETRES & SHALL BE VERIFIED ON SITE BY THE CONTRACTOR OR SUB-CONTRACTOR.
ALL DIMENSIONS SHOULD NOT BE SCALED FROM THE DRAWING UNLESS OTHERWISE INSTRUCTED. ANY DISCREPANCIES SHALL BE MADE KNOWN TO THE DESIGNER FOR DECISION PRIOR TO PROCEEDING OF THE WORK.

PROJECT TITLE

PROPOSED RENOVATION WORKS TO ROSSA

DRAWING TITLE


MEMBERS' LOUNGE ELEVATION

SCALE	AS SHOWN (@A3 PRINT)
DATE	08 SEPT 2021
DRAWN	SY
FILENAME	ROSSA
VERSION	B

OICHITOLOGY
(PRIVATE) LIMITED

DRAWING NO.

701

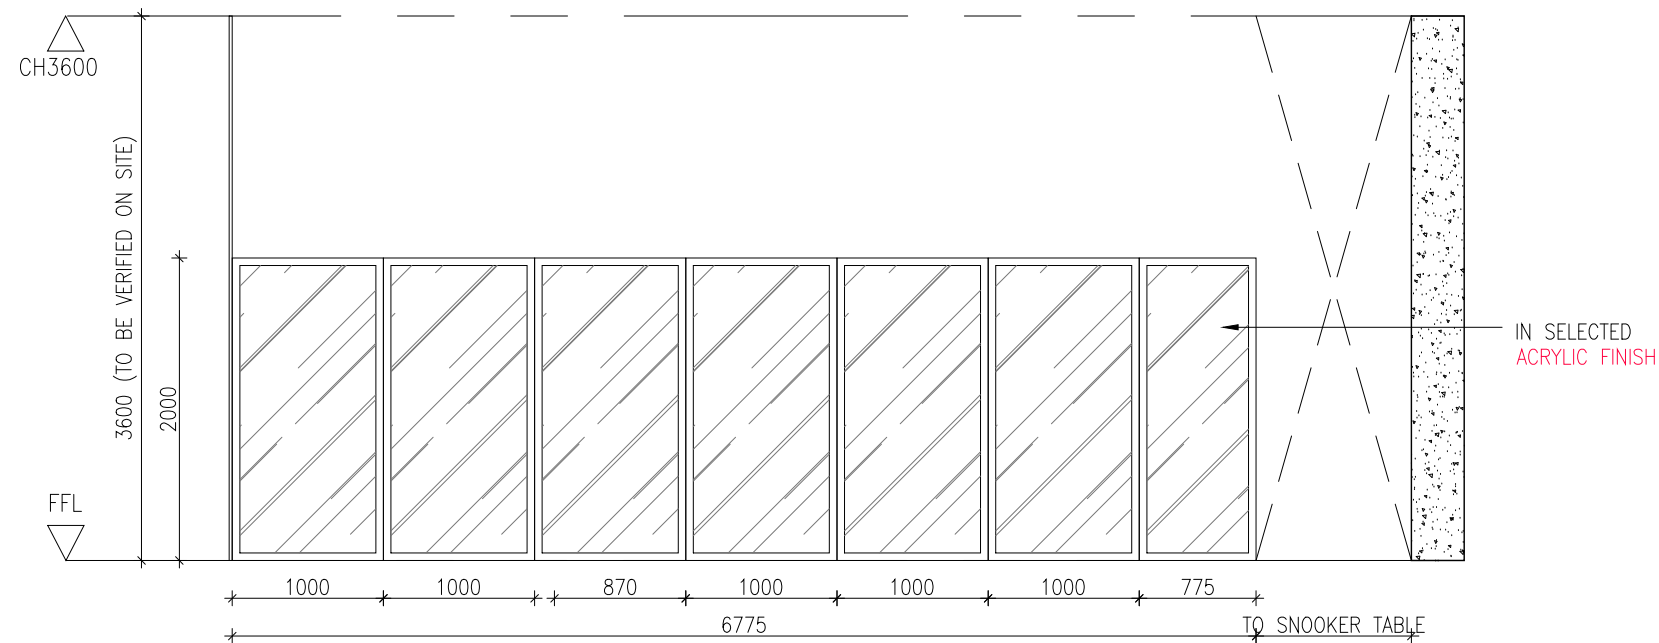

01
702

MEMBERS' LOUNGE ELEVATION

1:50

GENERAL NOTES

ALL DIMENSIONS SHOWN ARE IN MILLIMETRES & SHALL BE VERIFIED ON SITE BY THE CONTRACTOR OR SUB-CONTRACTOR.
ALL DIMENSIONS SHOULD NOT BE SCALED FROM THE DRAWING UNLESS OTHERWISE INSTRUCTED. ANY DISCREPANCIES SHALL BE MADE KNOWN TO THE DESIGNER FOR DECISION PRIOR TO PROCEEDING OF THE WORK.

PROJECT TITLE

PROPOSED RENOVATION WORKS TO
ROSSA

DRAWING TITLE

MEMBERS' LOUNGE ELEVATION

SCALE

AS SHOWN (@A3 PRINT)

DATE

07 JUL 2021

DRAWN

KB

FILENAME

ROSSA


VERSION

-

OICHI TOLOGY
(PRIVATE) LIMITED

DRAWING NO.

702

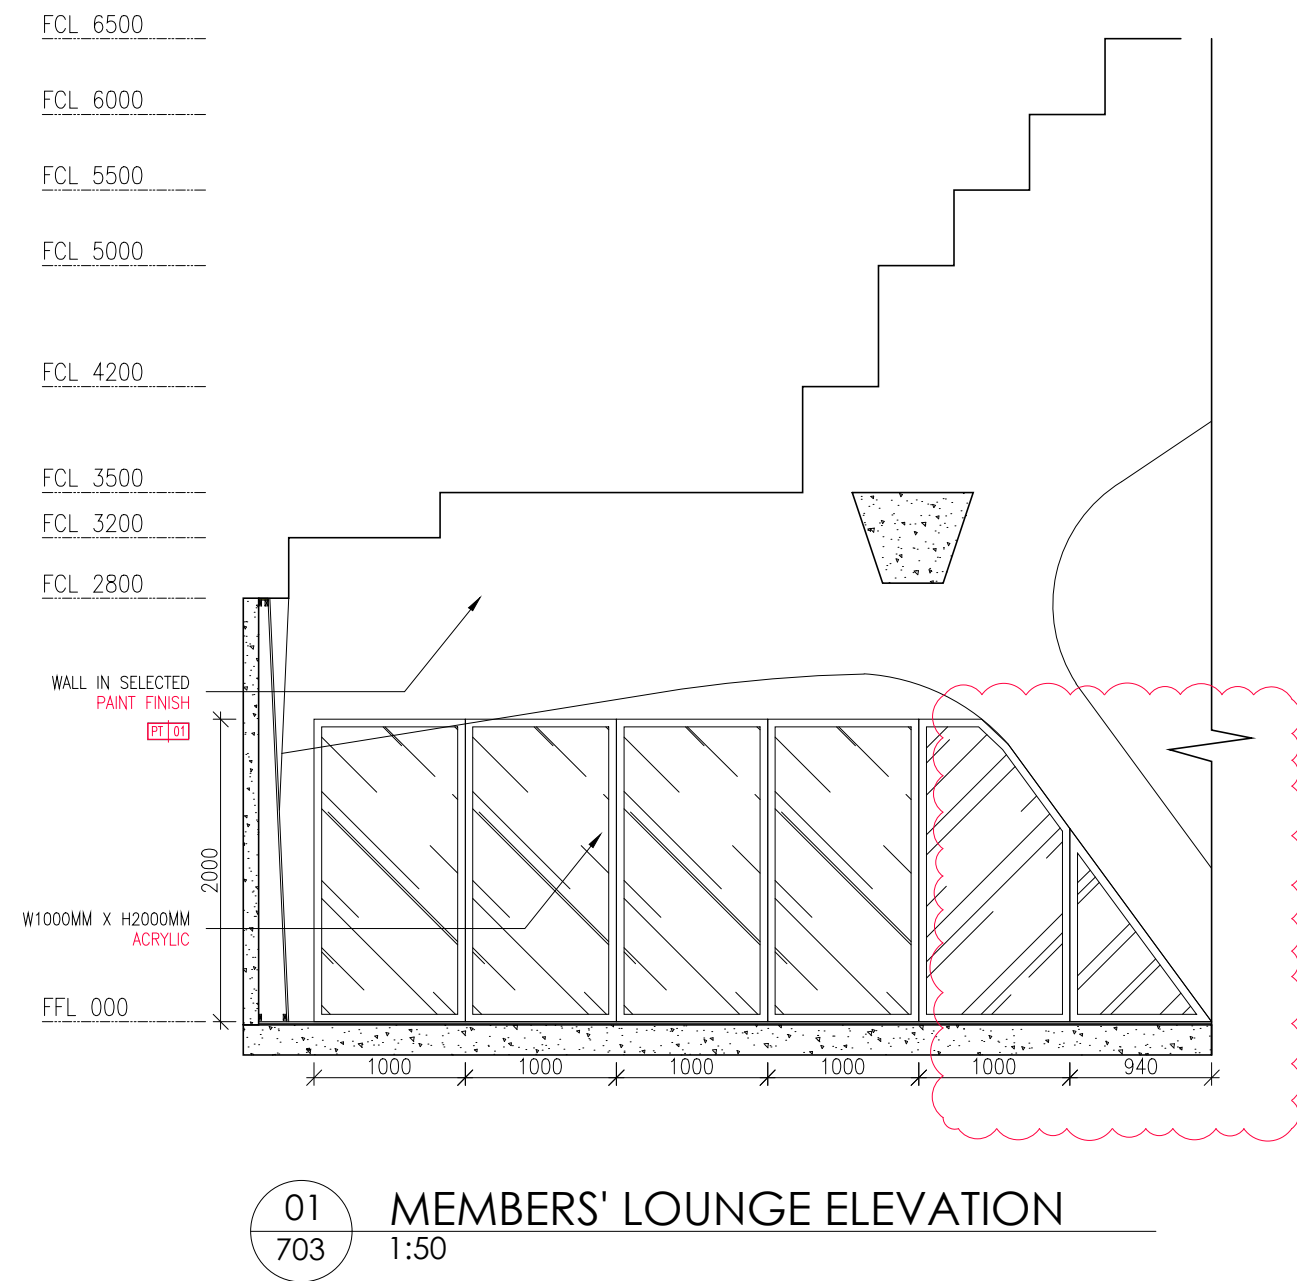

GENERAL NOTES

ALL DIMENSIONS SHOWN ARE IN MILLIMETRES & SHALL BE VERIFIED ON SITE BY THE CONTRACTOR OR SUB-CONTRACTOR.
ALL DIMENSIONS SHOULD NOT BE SCALED FROM THE DRAWING UNLESS OTHERWISE INSTRUCTED. ANY DISCREPANCIES SHALL BE MADE KNOWN TO THE DESIGNER FOR DECISION PRIOR TO PROCEEDING OF THE WORK.

PROJECT TITLE

PROPOSED RENOVATION WORKS TO
ROSSA

DRAWING TITLE

MEMBERS' LOUNGE ELEVATION

SCALE

AS SHOWN (@A3 PRINT)

DATE

08 SEPT 2021

DRAWN

SY

FILENAME

ROSSA

VERSION

A

OICHI TOLOGY
(PRIVATE) LIMITED

DRAWING NO.

703



1
800

KEY PLAN – FEATURE WALL LOCATION

SCALE 1:200

GENERAL NOTES

ALL DIMENSIONS SHOWN ARE IN MILLIMETRES & SHALL BE VERIFIED ON SITE BY THE CONTRACTOR OR SUB-CONTRACTOR.
ALL DIMENSIONS SHOULD NOT BE SCALED FROM THE DRAWING UNLESS OTHERWISE INSTRUCTED. ANY DISCREPANCIES SHALL BE MADE KNOWN TO THE DESIGNER FOR DECISION PRIOR TO PROCEEDING OF THE WORK.

PROJECT TITLE

PROPOSED RENOVATION WORKS TO
ROSSA

DRAWING TITLE

KEY PLAN - FEATURE WALL
LOCATION

SCALE

DATE

DRAWN

FILENAME

VERSION

AS SHOWN (@A3 PRINT)

22 JUL 2021

SY


ROSSA

A


ORCHITOLGY
(PRIVATE) LIMITED

DRAWING NO.


800

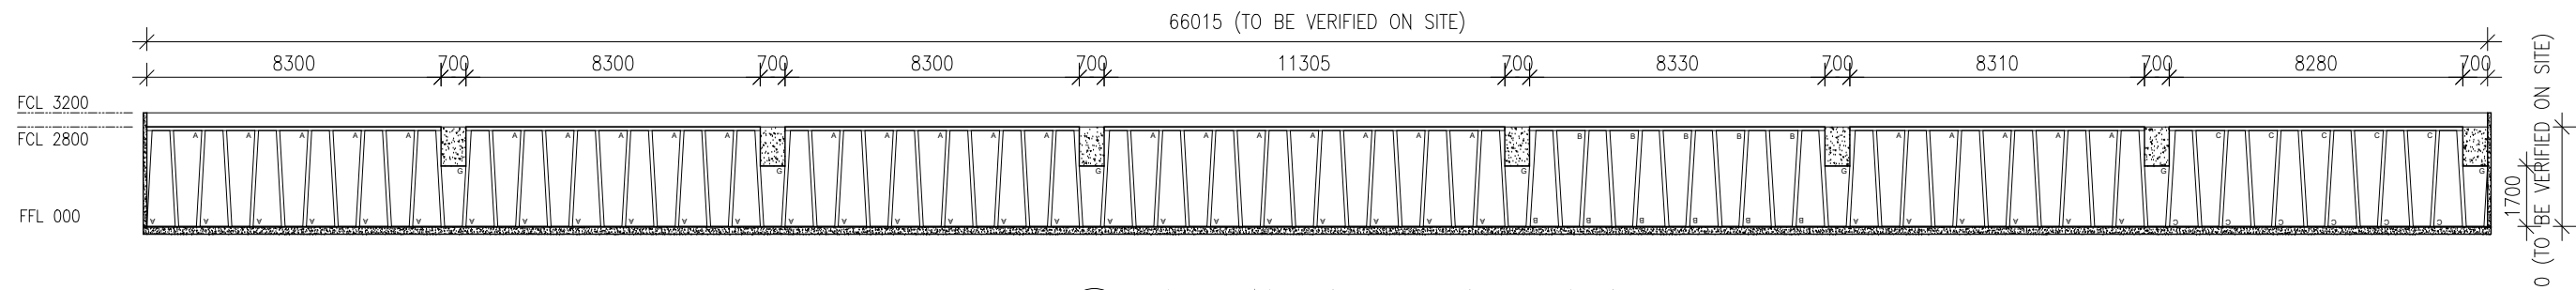


1 FEATURE WALL SNOOKER ZONE ELEVATION
802 SCALE 1:200

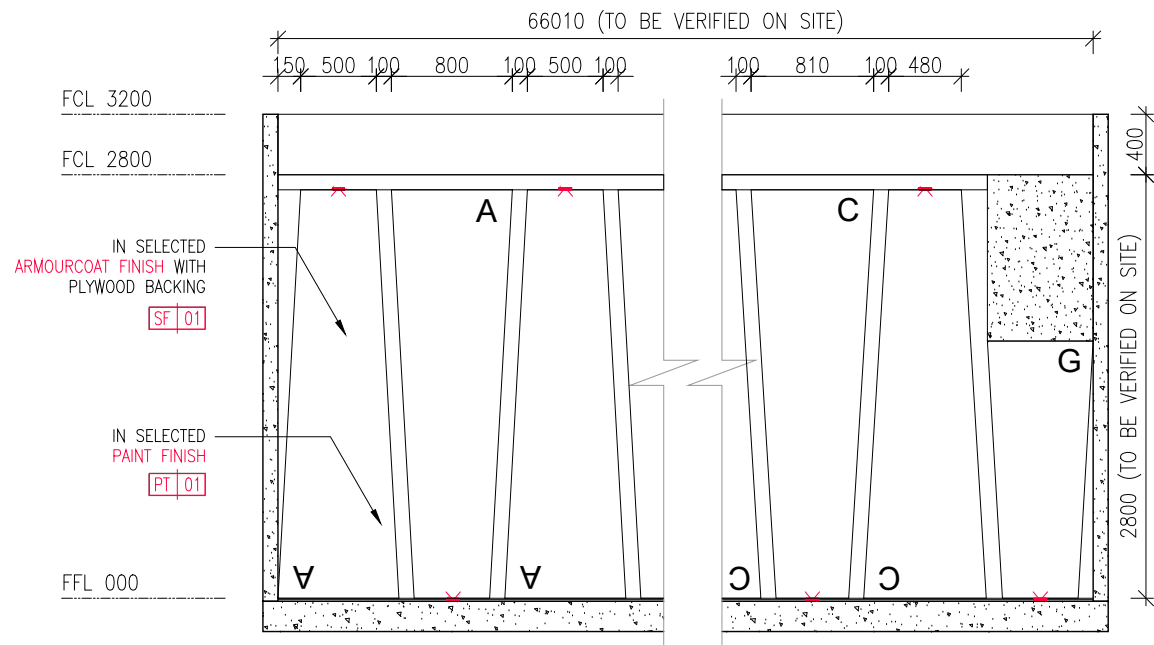


2 ELEVATION DETAIL
802 SCALE 1:50

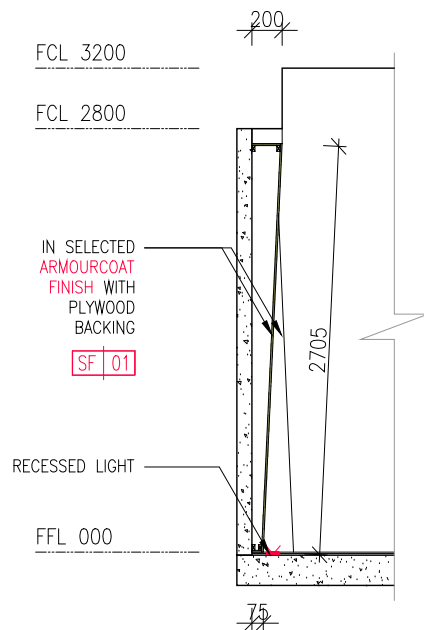


3 SECTION DETAIL
802 SCALE 1:50

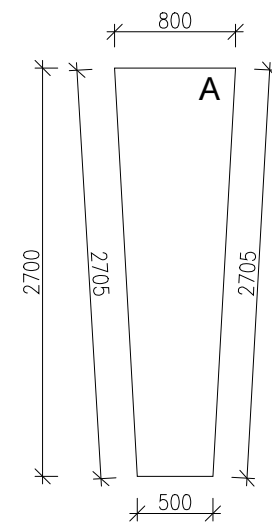


4 PANEL A
802 SCALE 1:50

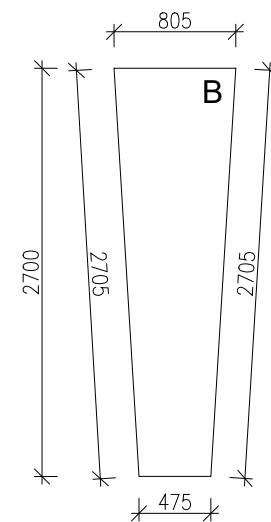



5 PANEL B
802 SCALE 1:50

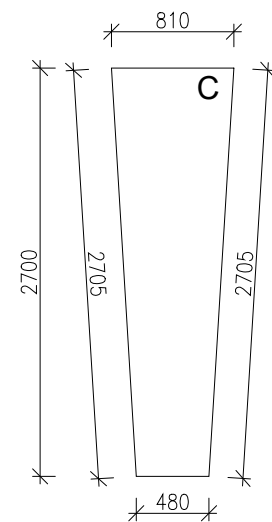


6 PANEL C
802 SCALE 1:50

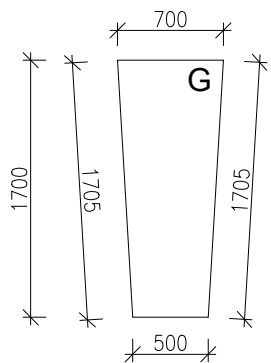

7 PANEL G
802 SCALE 1:50

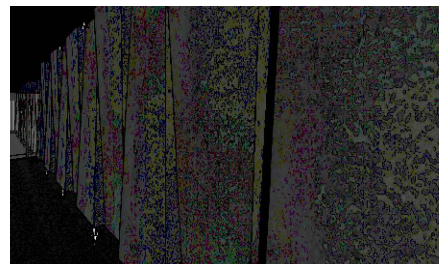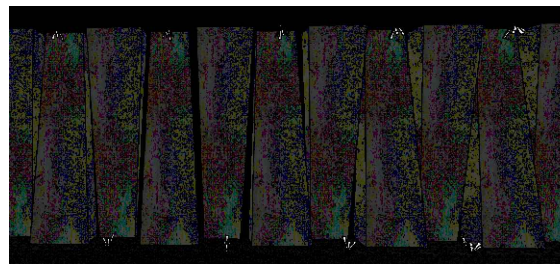

REFERENCE IMAGES
SCALE NTS

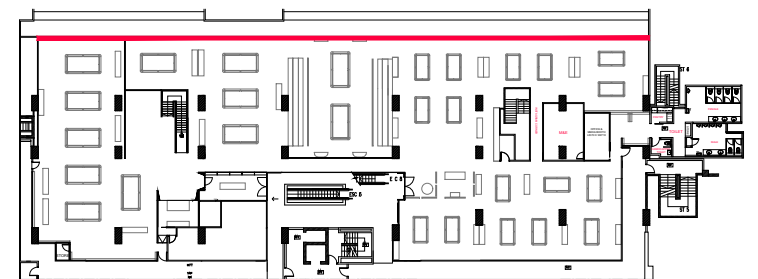

FEATURE WALL POOL ZONE LOCATION
SCALE NTS

GENERAL NOTES

ALL DIMENSIONS SHOWN ARE IN MILLIMETRES & SHALL BE VERIFIED ON SITE BY THE CONTRACTOR OR SUB-CONTRACTOR.
ALL DIMENSIONS SHOULD NOT BE SCALED FROM THE DRAWING UNLESS OTHERWISE INSTRUCTED. ANY DISCREPANCIES SHALL BE MADE KNOWN TO THE DESIGNER FOR DECISION PRIOR TO PROCEEDING OF THE WORK.

PROJECT TITLE

PROPOSED RENOVATION WORKS TO ROSSA

DRAWING TITLE

FEATURE WALL DETAIL - SNOOKER ZONE

SCALE

DATE

DRAWN

FILENAME

VERSION

AS SHOWN (@A3 PRINT)

22 JUL 2021

SY


ROSSA

B

OICHI TOLOGY
(PRIVATE) LIMITED

DRAWING NO.

802

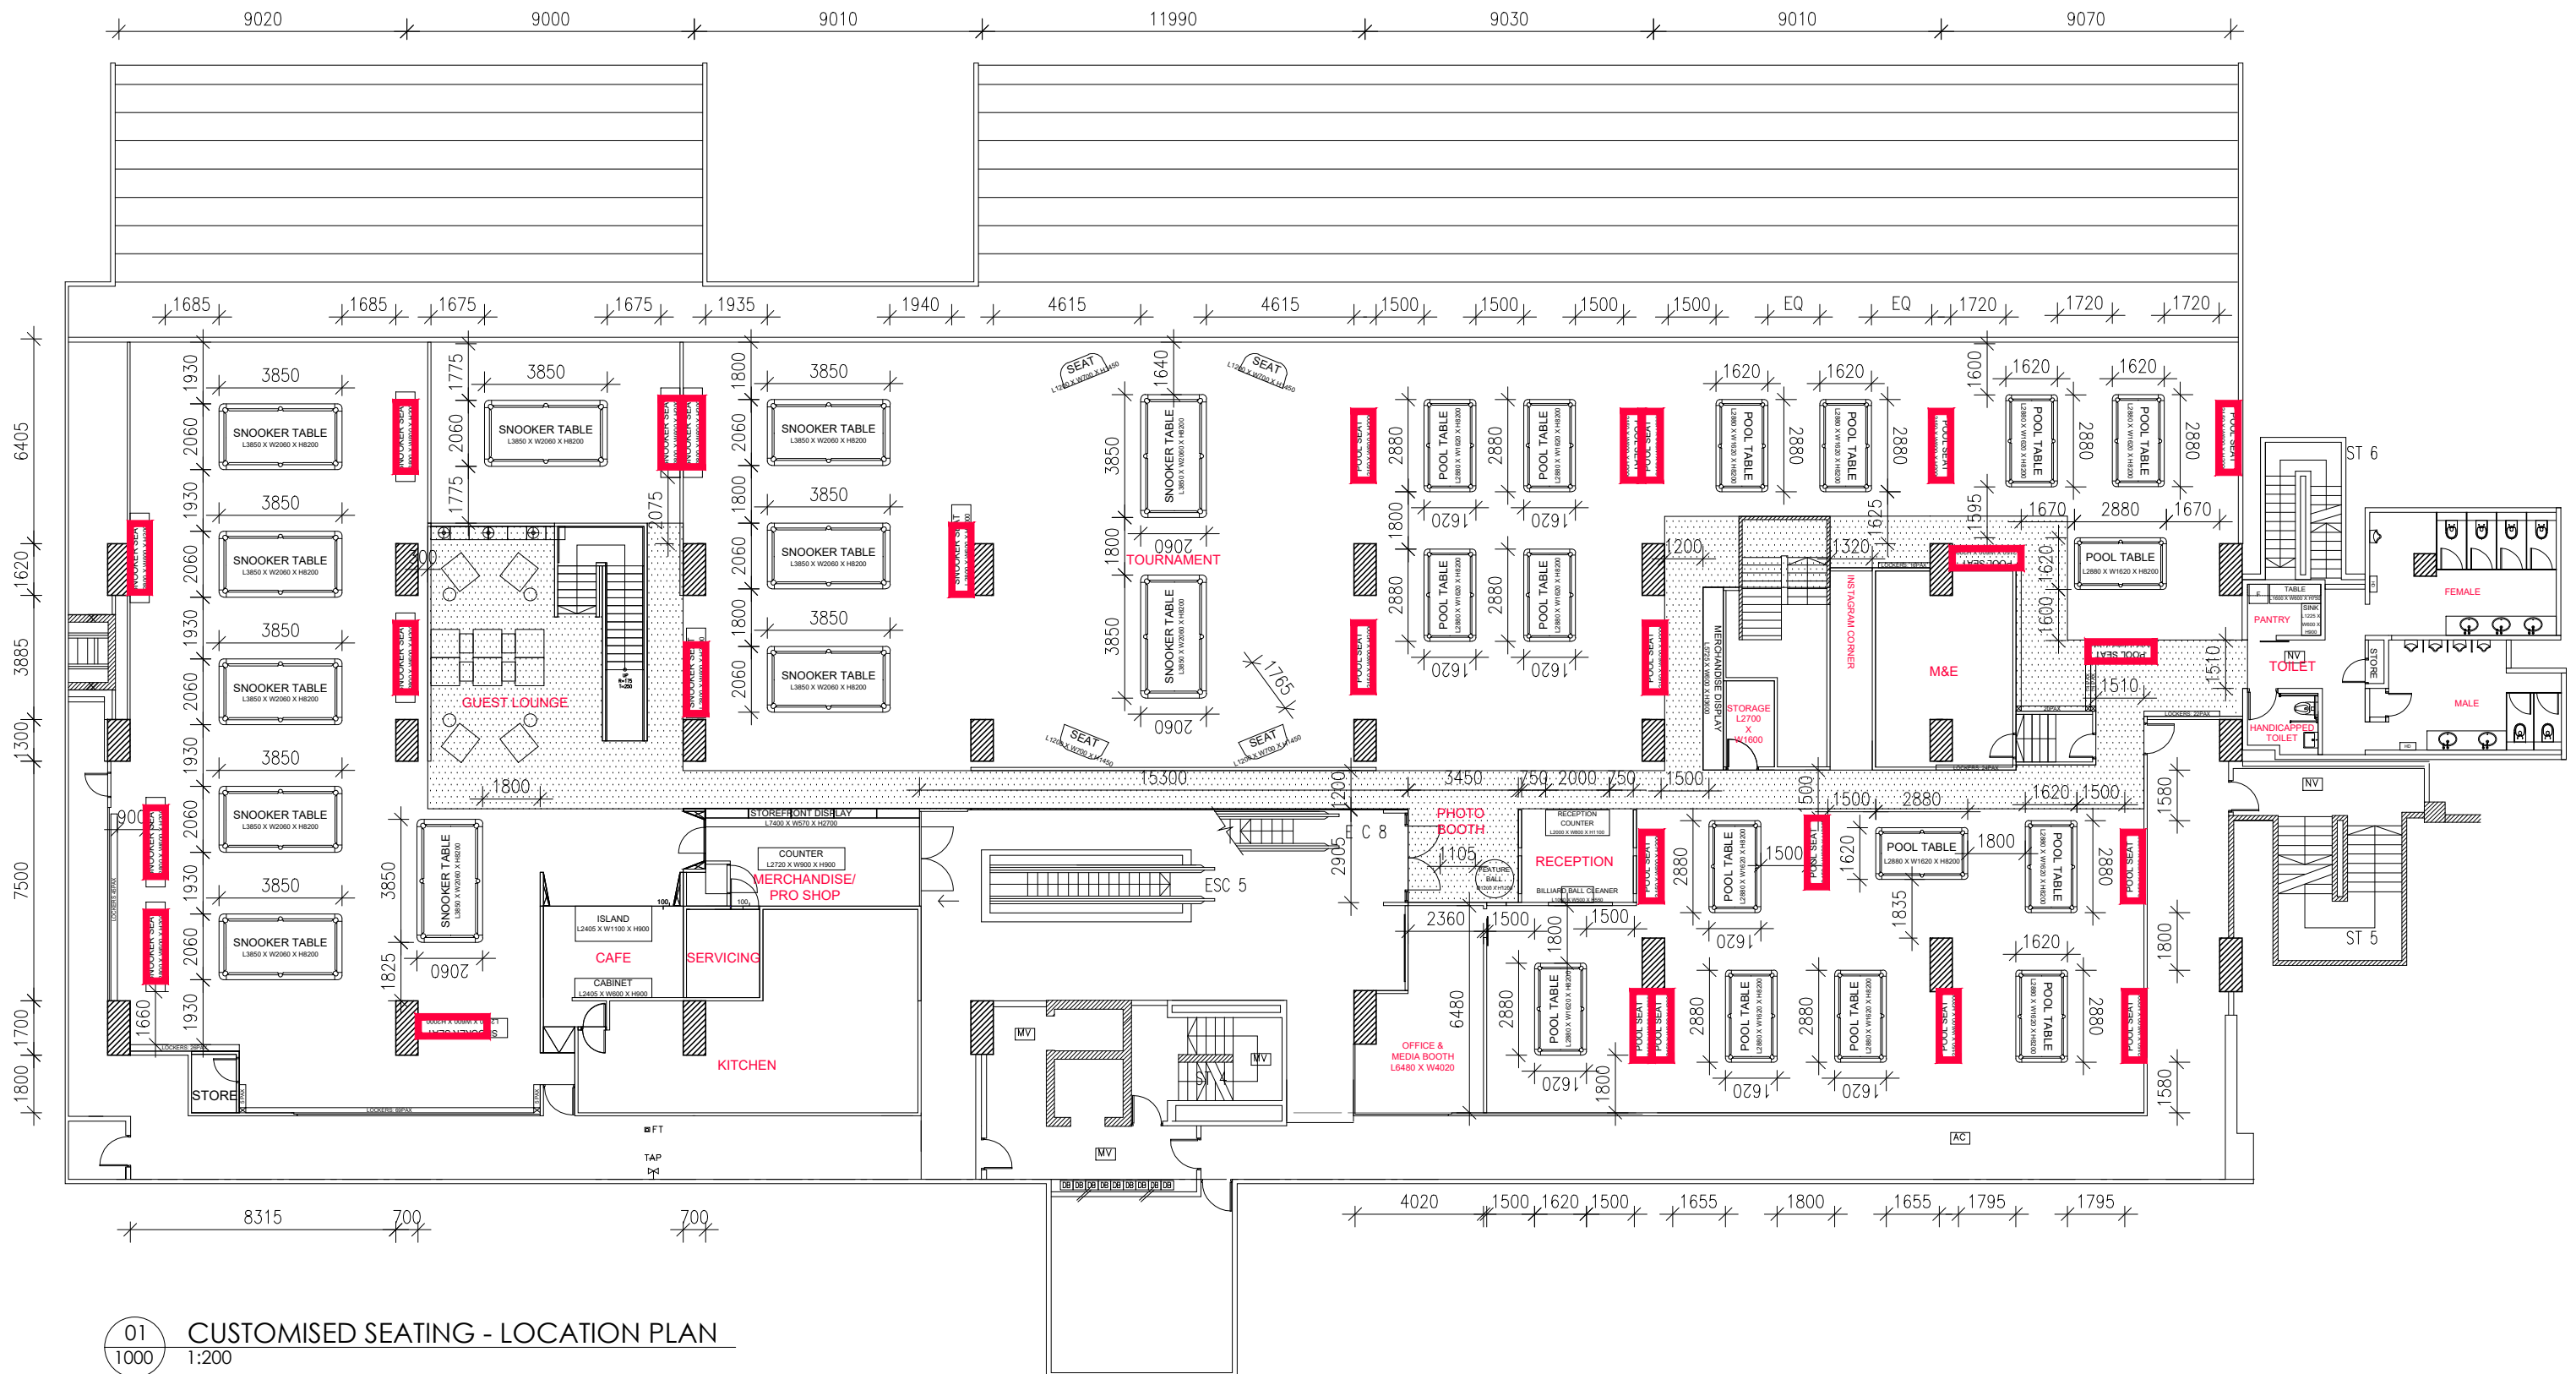

01
1000

CUSTOMISED SEATING - LOCATION PLAN
1:200

GENERAL NOTES

ALL DIMENSIONS SHOWN ARE IN MILLIMETRES & SHALL BE VERIFIED ON SITE BY THE CONTRACTOR OR SUB-CONTRACTOR.
ALL DIMENSIONS SHOULD NOT BE SCALED FROM THE DRAWING UNLESS OTHERWISE INSTRUCTED. ANY DISCREPANCIES SHALL BE MADE KNOWN TO THE DESIGNER FOR DECISION PRIOR TO PROCEEDING OF THE WORK.

PROJECT TITLE

PROPOSED RENOVATION WORKS TO
ROSSA

DRAWING TITLE

KEY PLAN - CUSTOMISED SEATING
LOCATION

SCALE

AS SHOWN (@A3 PRINT)

DATE

31 AUG 2021

DRAWN

SY

FILENAME

ROSSA


VERSION

B

OICHITOLOG
(PRIVATE) LIMITED

DRAWING NO.

900

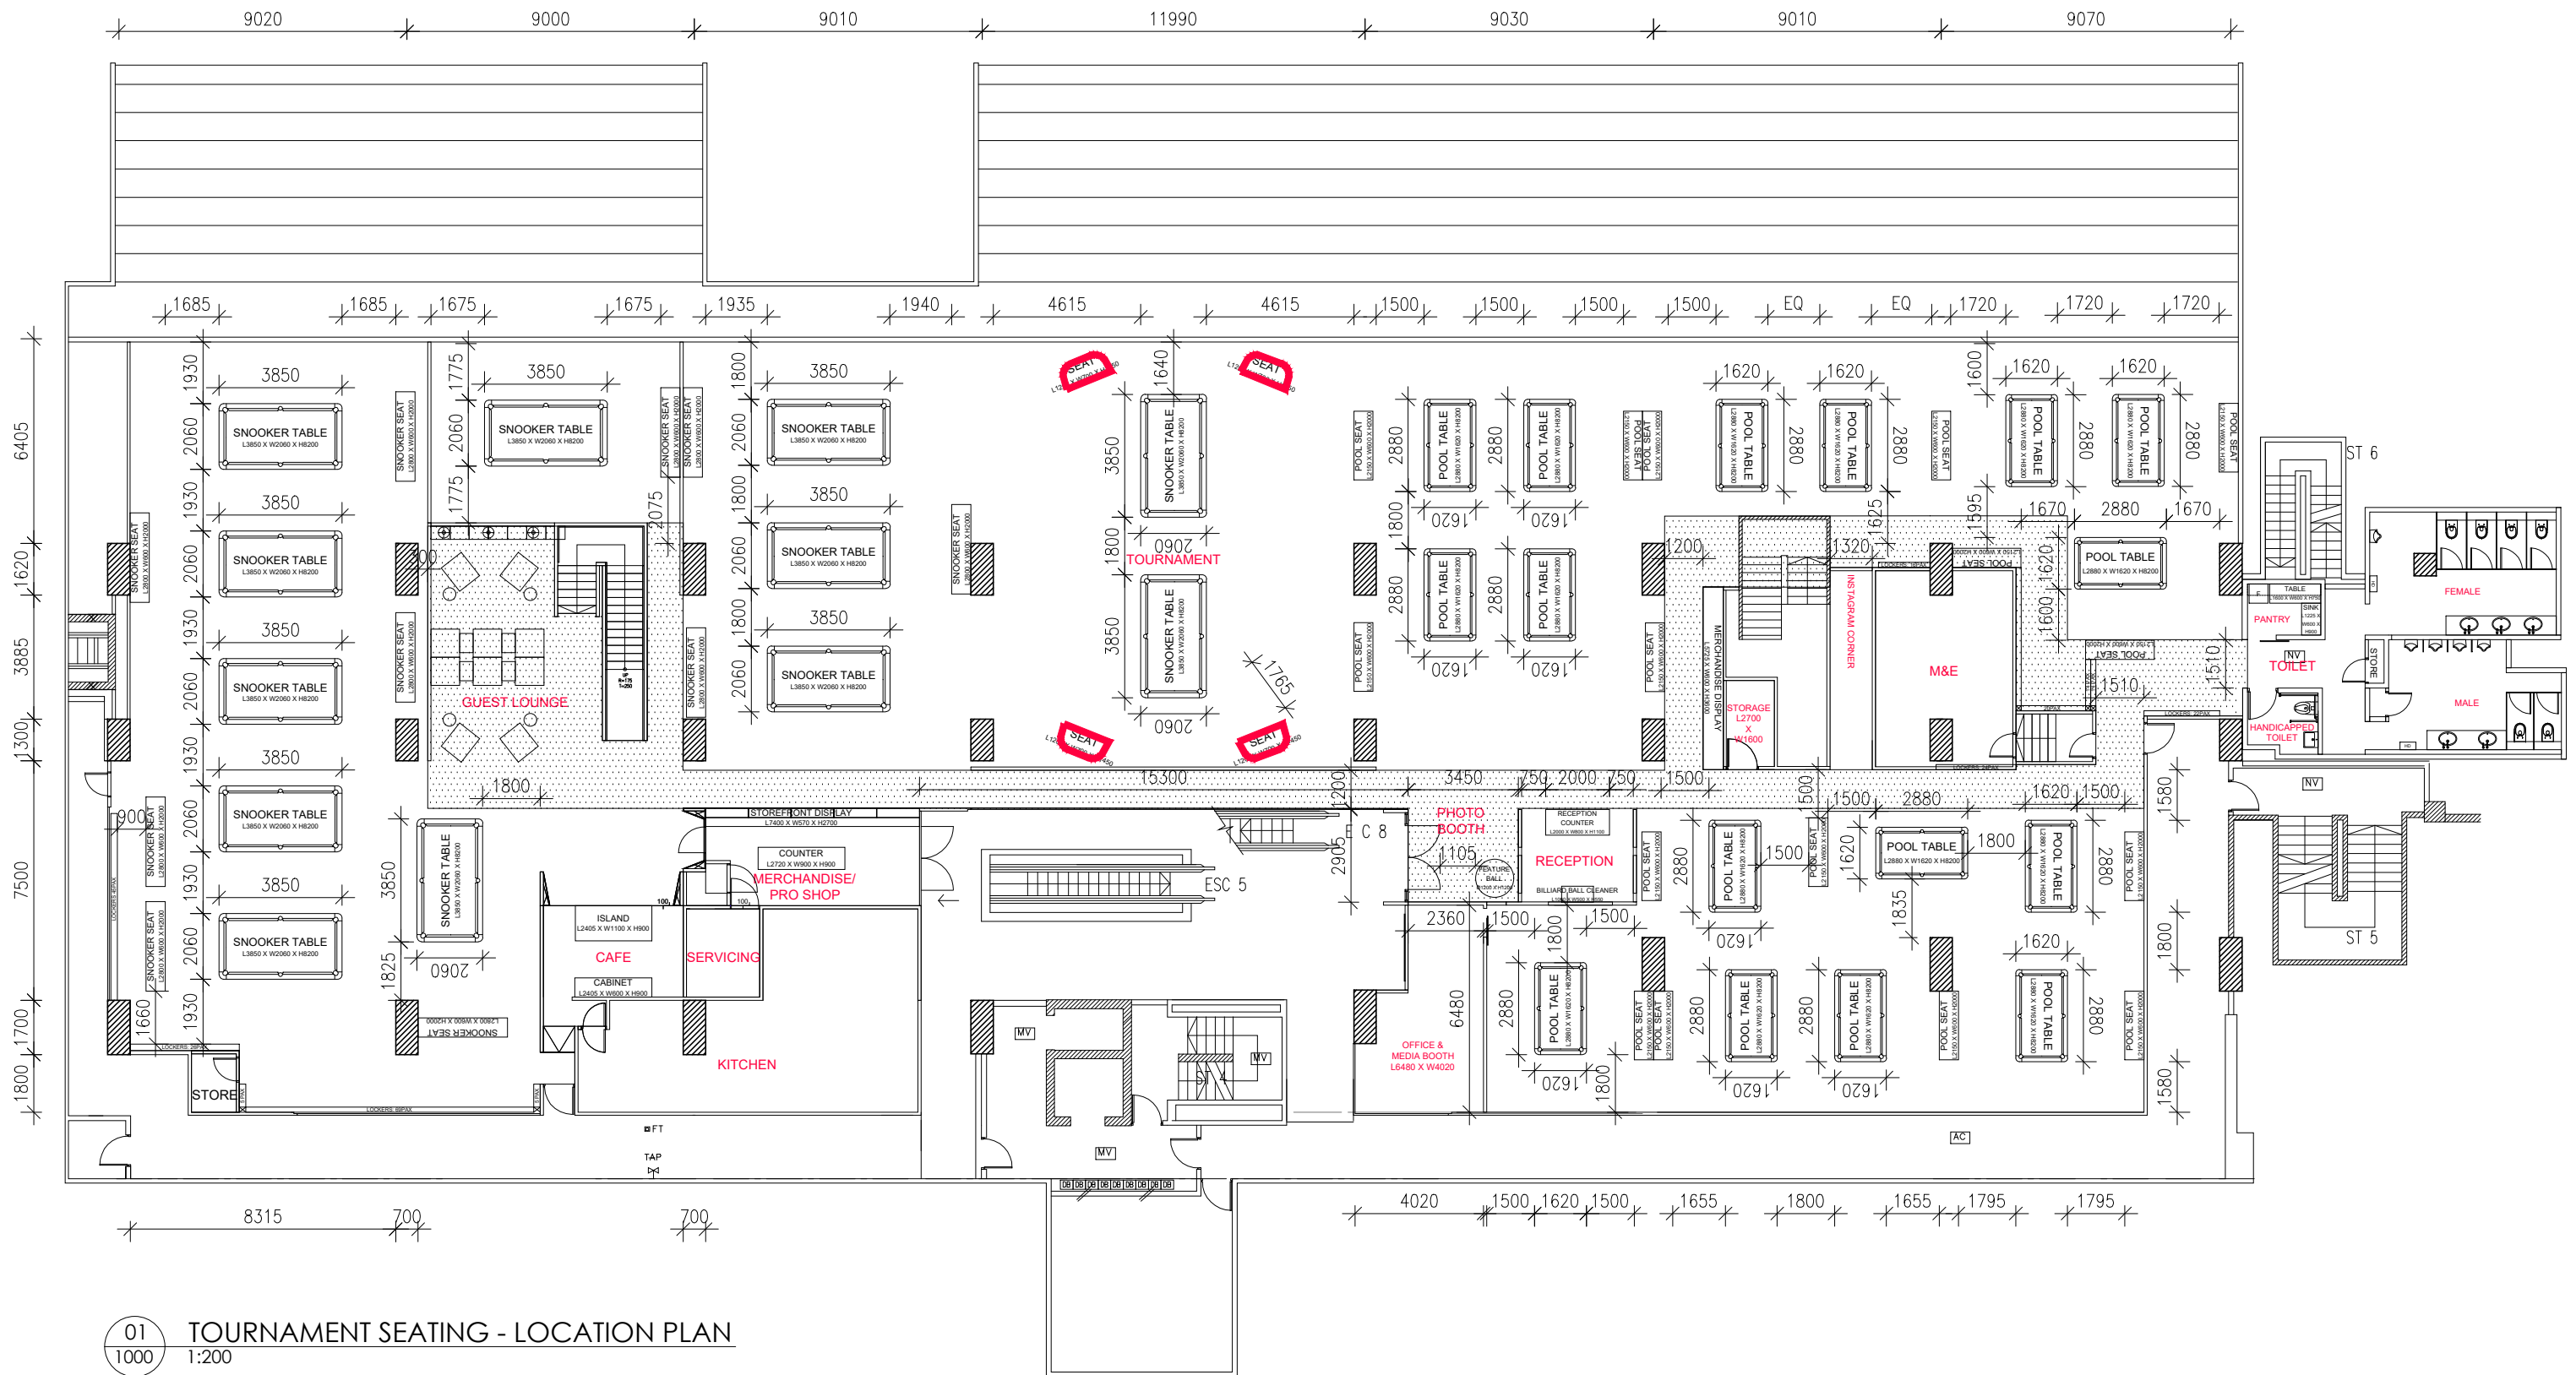

GENERAL NOTES

ALL DIMENSIONS SHOWN ARE IN MILLIMETRES & SHALL BE VERIFIED ON SITE BY THE CONTRACTOR OR SUB-CONTRACTOR.
ALL DIMENSIONS SHOULD NOT BE SCALED FROM THE DRAWING UNLESS OTHERWISE INSTRUCTED. ANY DISCREPANCIES SHALL BE MADE KNOWN TO THE DESIGNER FOR DECISION PRIOR TO PROCEEDING OF THE WORK.

PROJECT TITLE

PROPOSED RENOVATION WORKS TO ROSSA

DRAWING TITLE

KEY PLAN - TOURNAMENT SEATING LOCATION

SCALE

AS SHOWN (@A3 PRINT)

DATE

31 AUG 2021

DRAWN

SY

FILENAME

ROSSA


VERSION

B

OICHI TOLOGY
(PRIVATE) LIMITED

DRAWING NO.

920

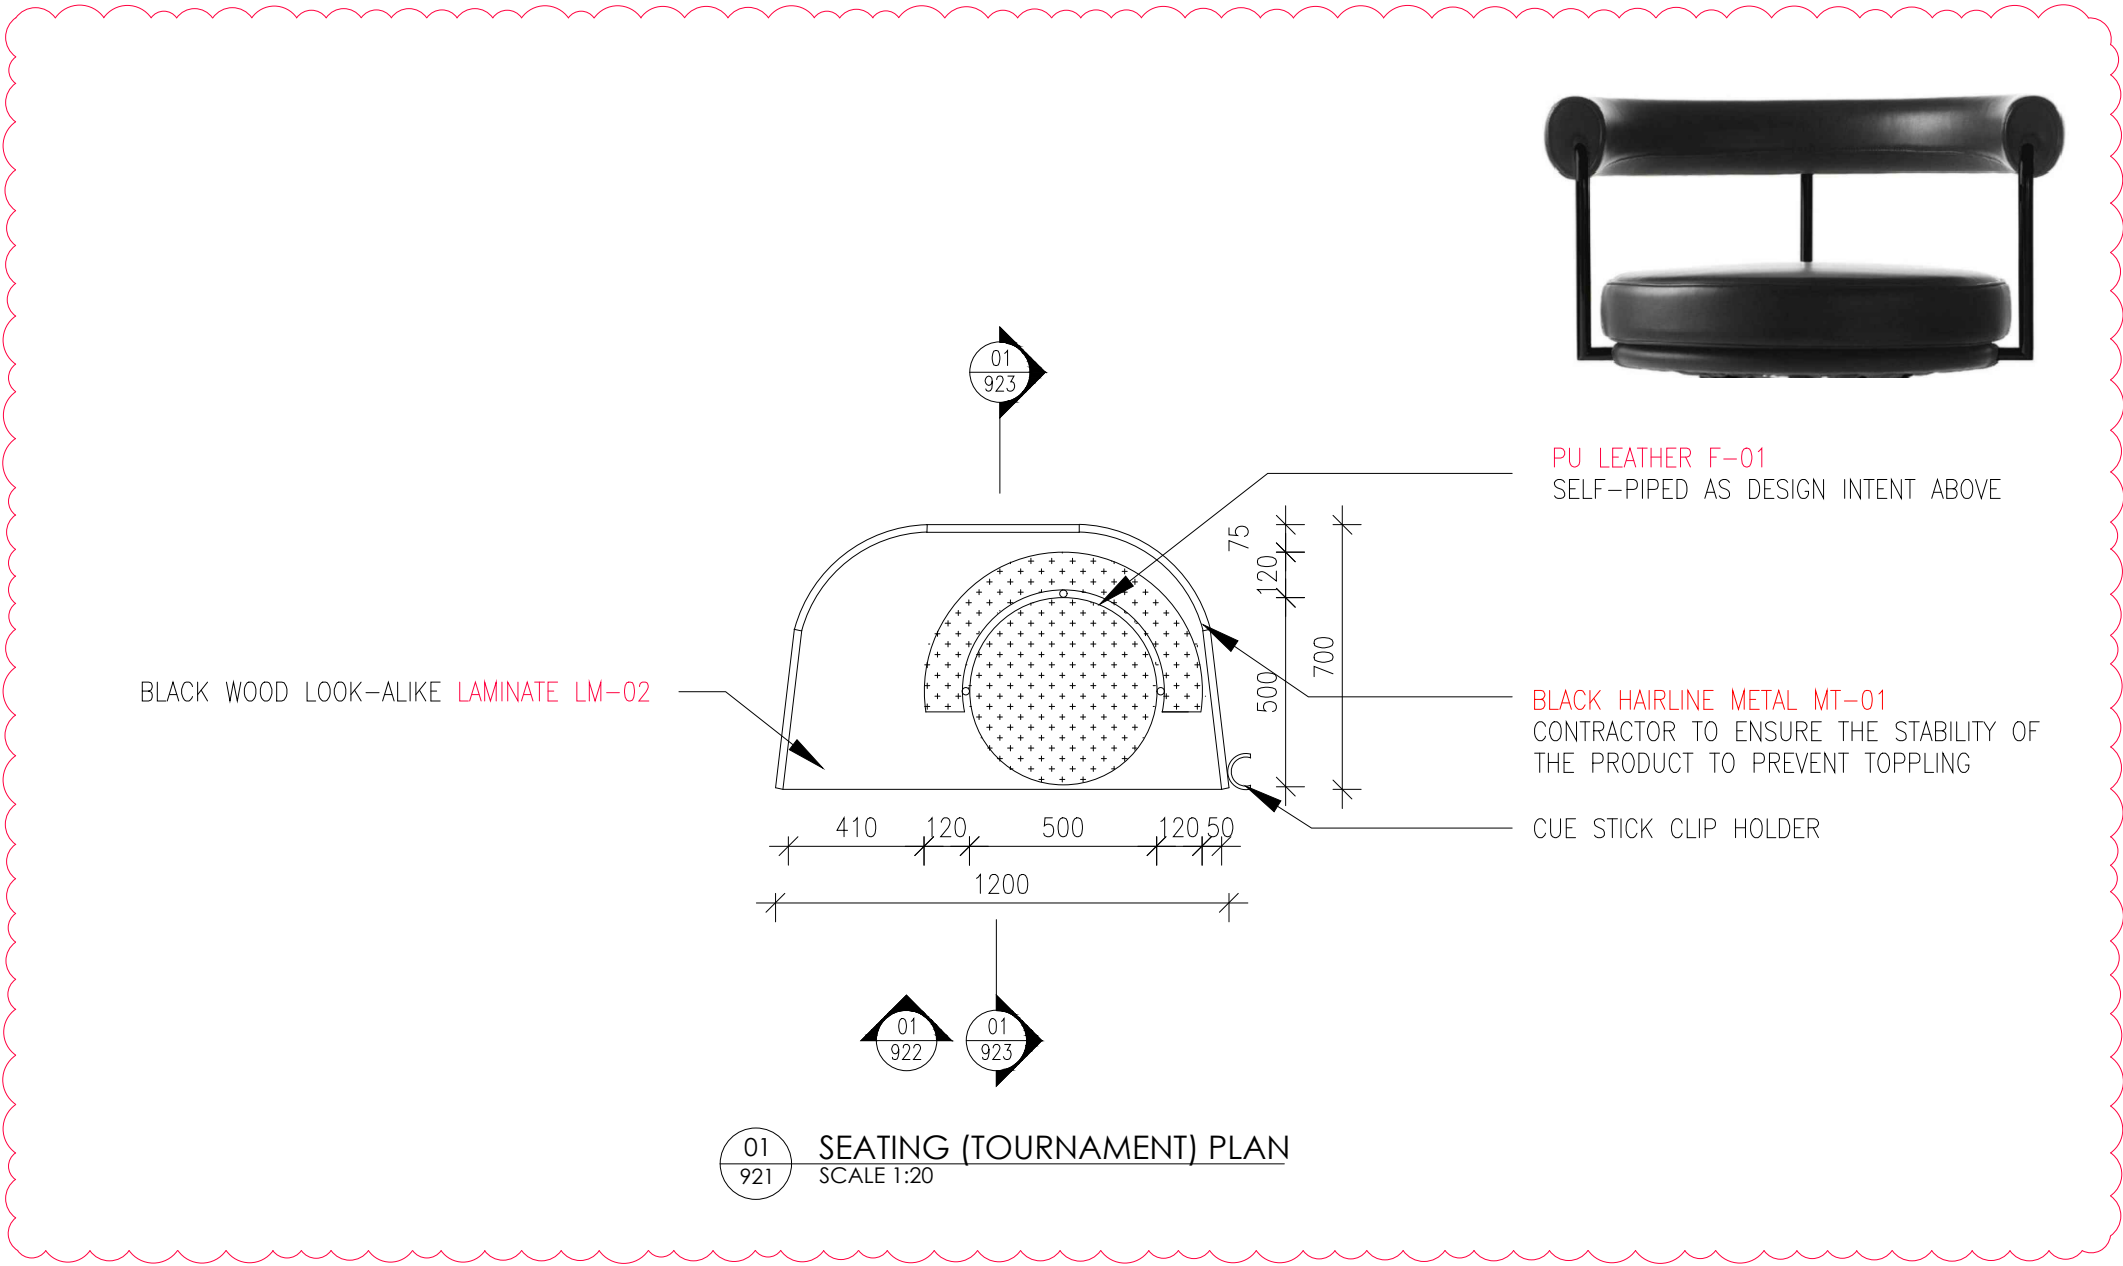

GENERAL NOTES

ALL DIMENSIONS SHOWN ARE IN MILLIMETRES & SHALL BE VERIFIED ON SITE BY THE CONTRACTOR OR SUB-CONTRACTOR.
ALL DIMENSIONS SHOULD NOT BE SCALED FROM THE DRAWING UNLESS OTHERWISE INSTRUCTED, ANY DISCREPANCIES SHALL BE MADE KNOWN TO THE DESIGNER FOR DECISION PRIOR TO PROCEEDING OF THE WORK.

PROJECT TITLE


PROPOSED RENOVATION WORKS TO
ROSSA

DRAWING TITLE

SEATING (TOURNAMENT) DETAIL

SCALE	AS SHOWN (@ A3 PRINT)
DATE	01 SEPT 2021
DRAWN	AK
FILENAME	--
VERSION	D

OICHI TOLOGY
(PRIVATE) LIMITED
DRAWING NO. 921

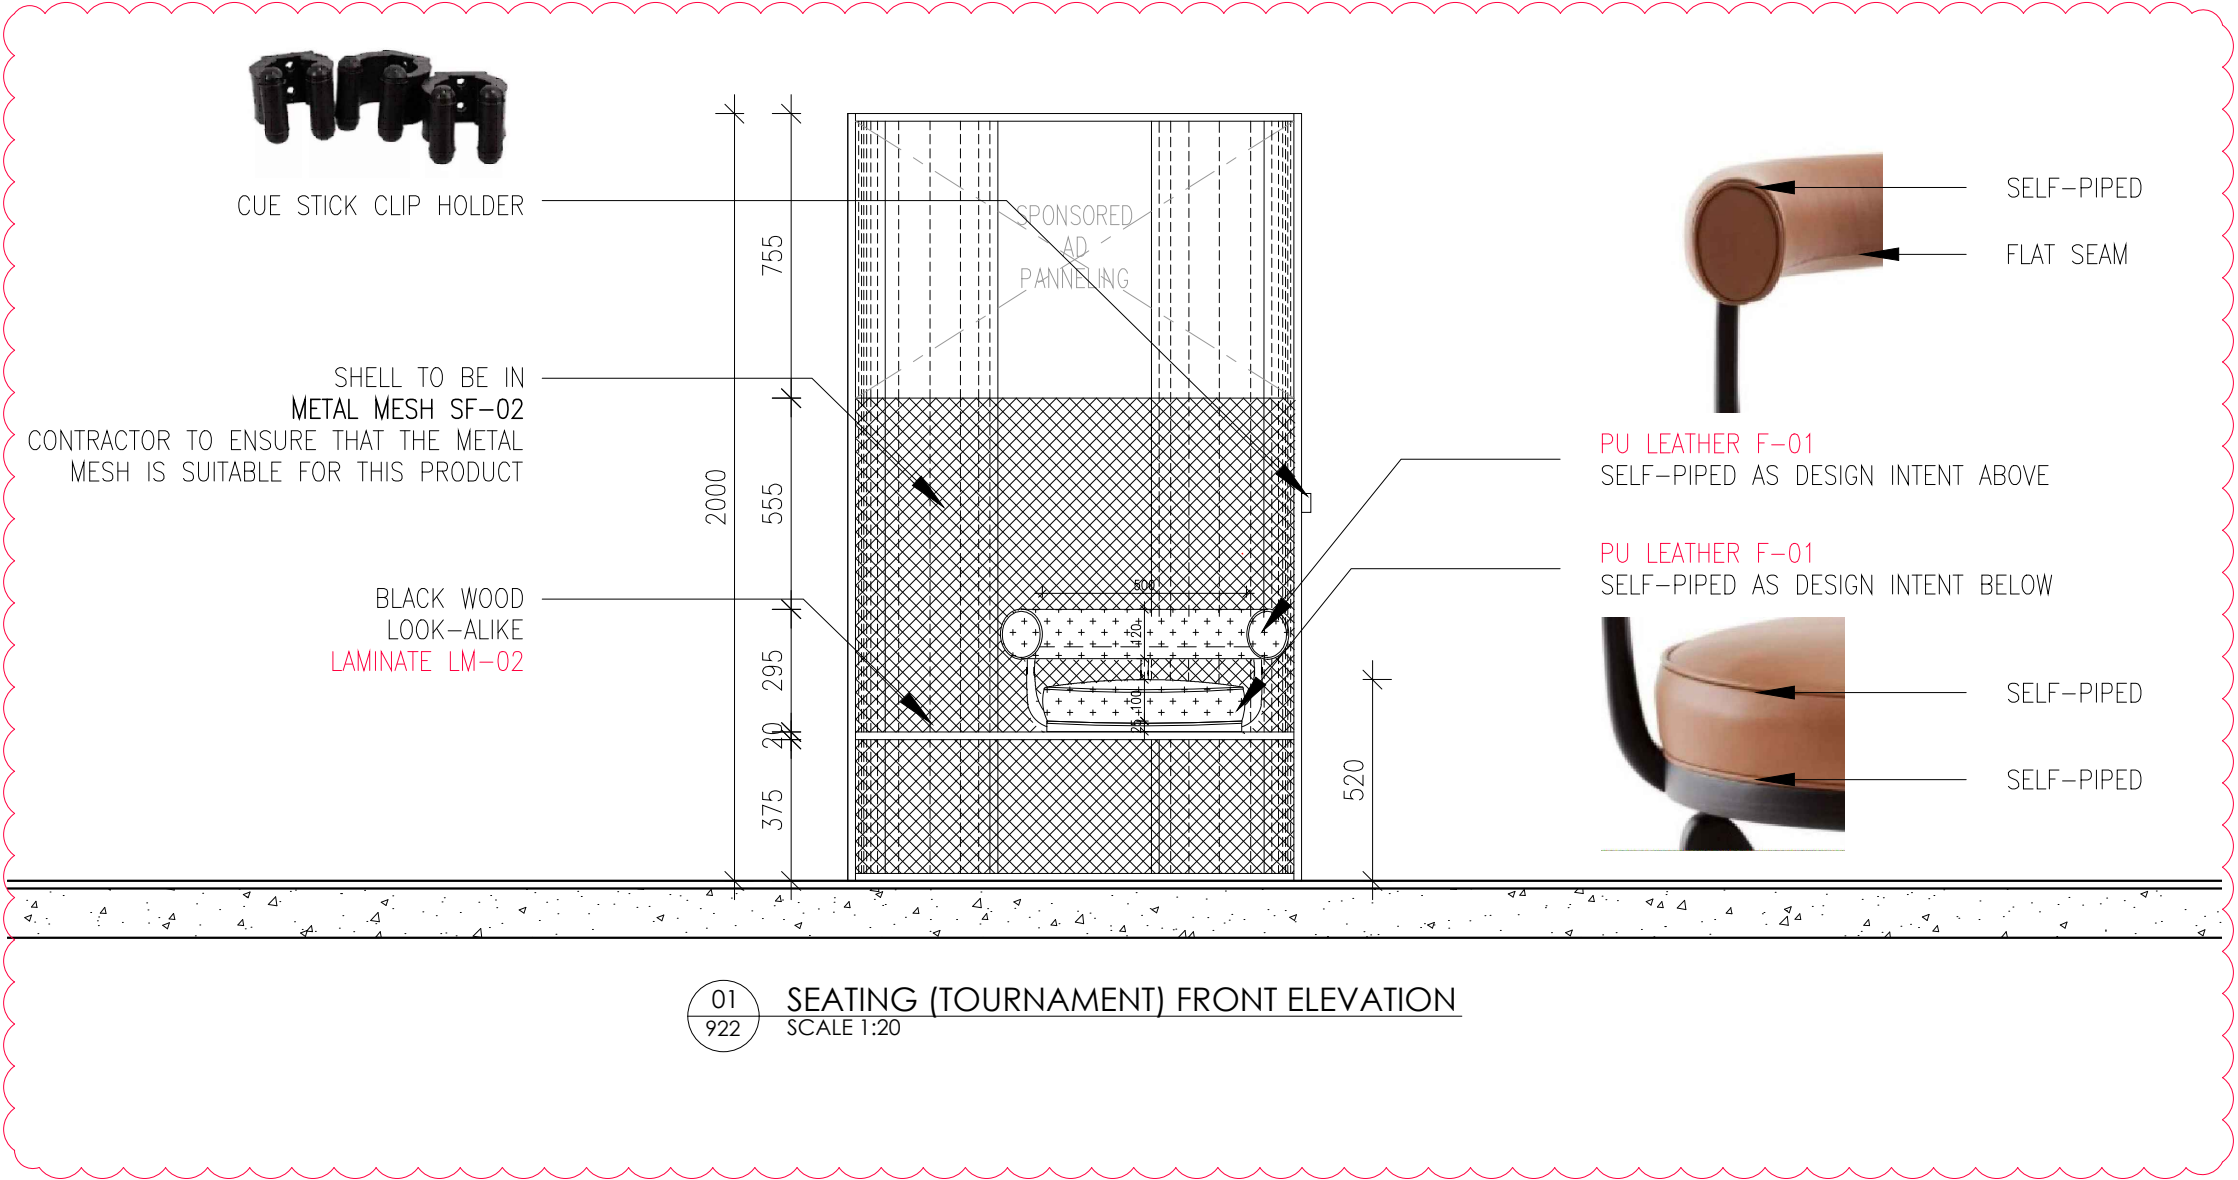

GENERAL NOTES

ALL DIMENSIONS SHOWN ARE IN MILLIMETRES & SHALL BE VERIFIED ON SITE BY THE CONTRACTOR OR SUB-CONTRACTOR.
ALL DIMENSIONS SHOULD NOT BE SCALED FROM THE DRAWING UNLESS OTHERWISE INSTRUCTED. ANY DISCREPANCIES SHALL BE MADE KNOWN TO THE DESIGNER FOR DECISION PRIOR TO PROCEEDING OF THE WORK.

PROJECT TITLE

PROPOSED RENOVATION WORKS TO ROSSA


DRAWING TITLE

SEATING (TOURNAMENT) DETAIL

SCALE	AS SHOWN (@ A3 PRINT)
DATE	01 SEPT 2021
DRAWN	AK
FILENAME	-
VERSION	D

ORCHITOLOGY
(PRIVATE) LIMITED

DRAWING NO. 922

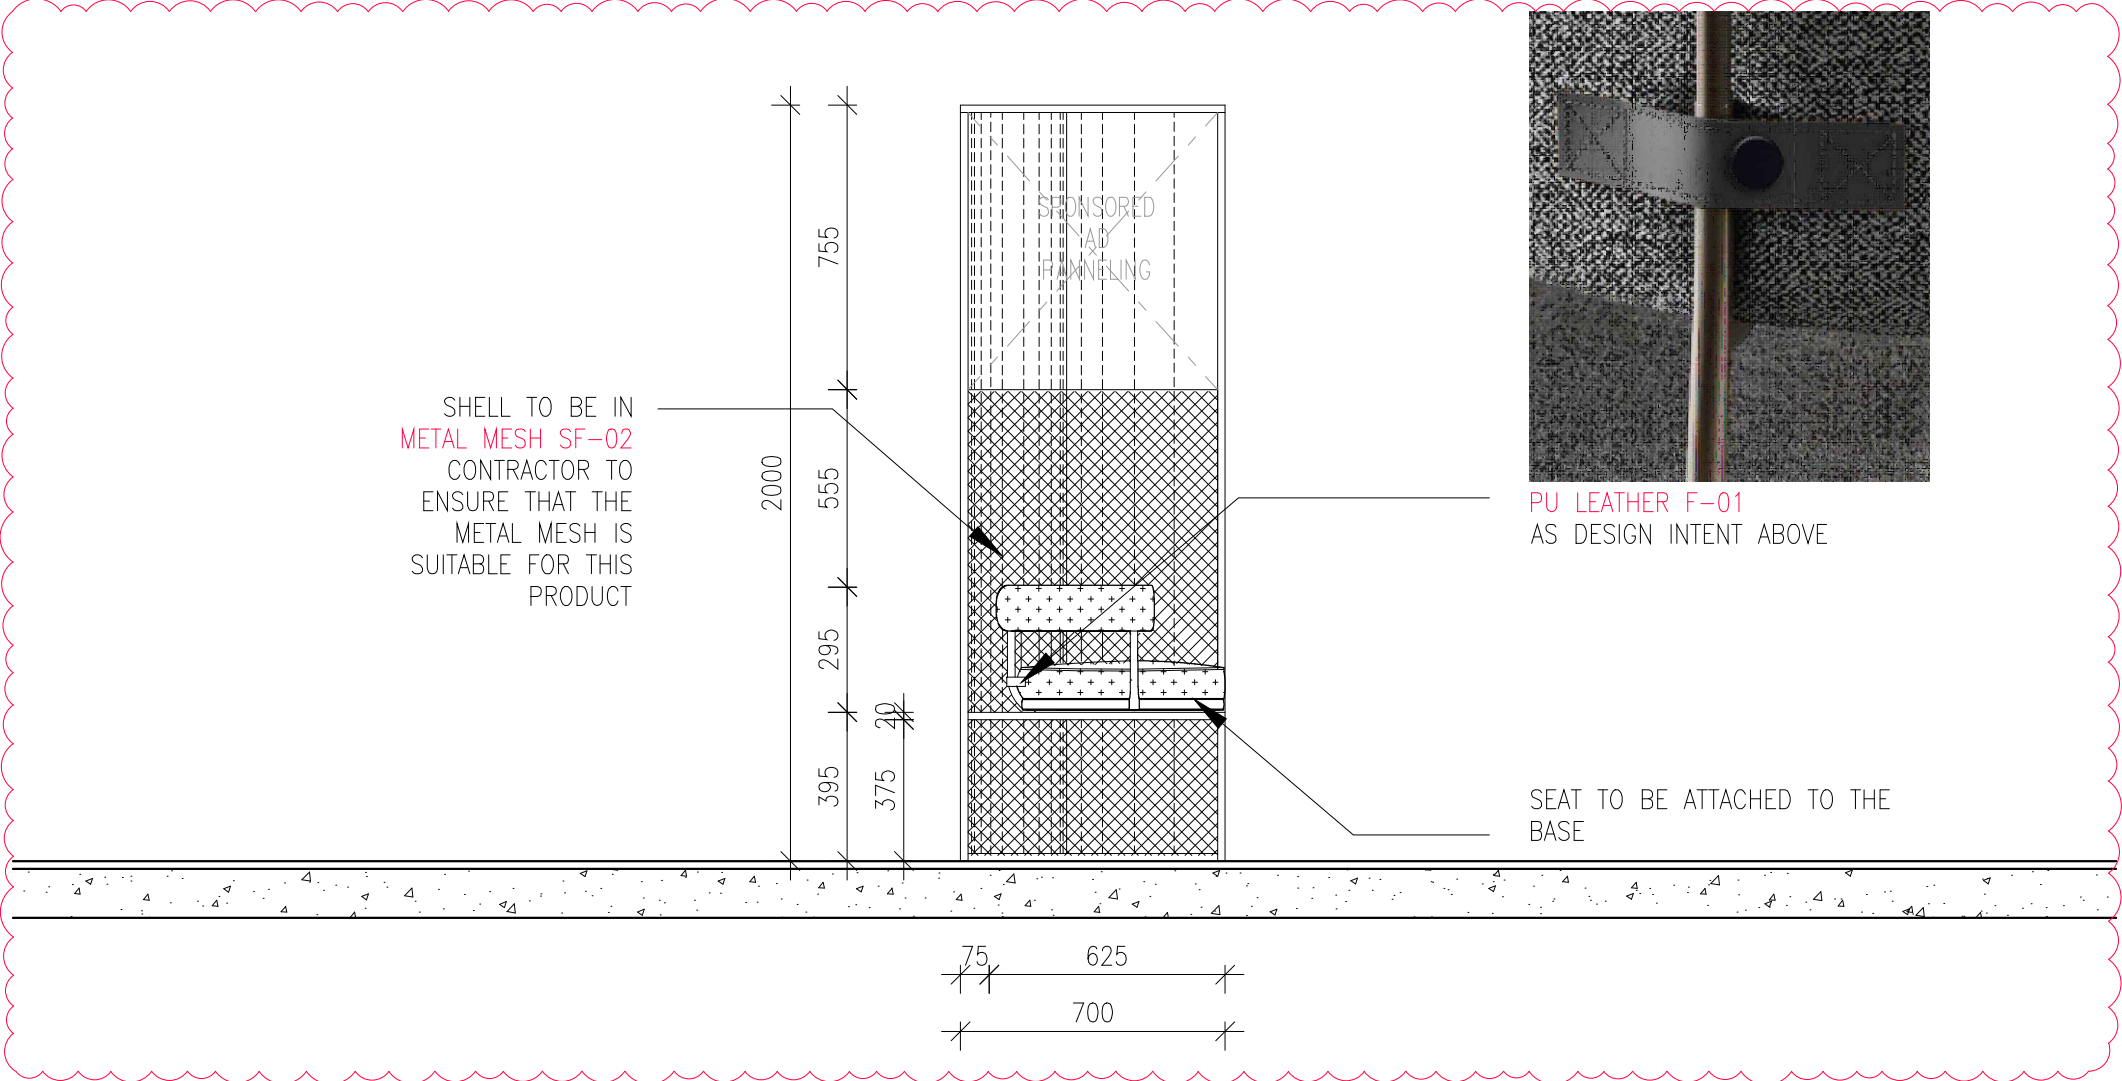

01 SEATING (TOURNAMENT) SECTION
923 SCALE 1:20

GENERAL NOTES

ALL DIMENSIONS SHOWN ARE IN MILLIMETRES & SHALL BE VERIFIED ON SITE BY THE CONTRACTOR OR SUB-CONTRACTOR.
ALL DIMENSIONS SHOULD NOT BE SCALED FROM THE DRAWING UNLESS OTHERWISE INSTRUCTED, ANY DISCREPANCIES SHALL BE MADE KNOWN TO THE DESIGNER FOR DECISION PRIOR TO PROCEEDING OF THE WORK.

PROJECT TITLE

PROPOSED RENOVATION WORKS TO ROSSA


DRAWING TITLE

SEATING (TOURNAMENT) DETAIL

SCALE	AS SHOWN (@ A3 PRINT)
DATE	01 SEPT 2021
DRAWN	AK
FILENAME	--
VERSION	D

ORCHITOLOGY
(PRIVATE) LIMITED

DRAWING NO. 923

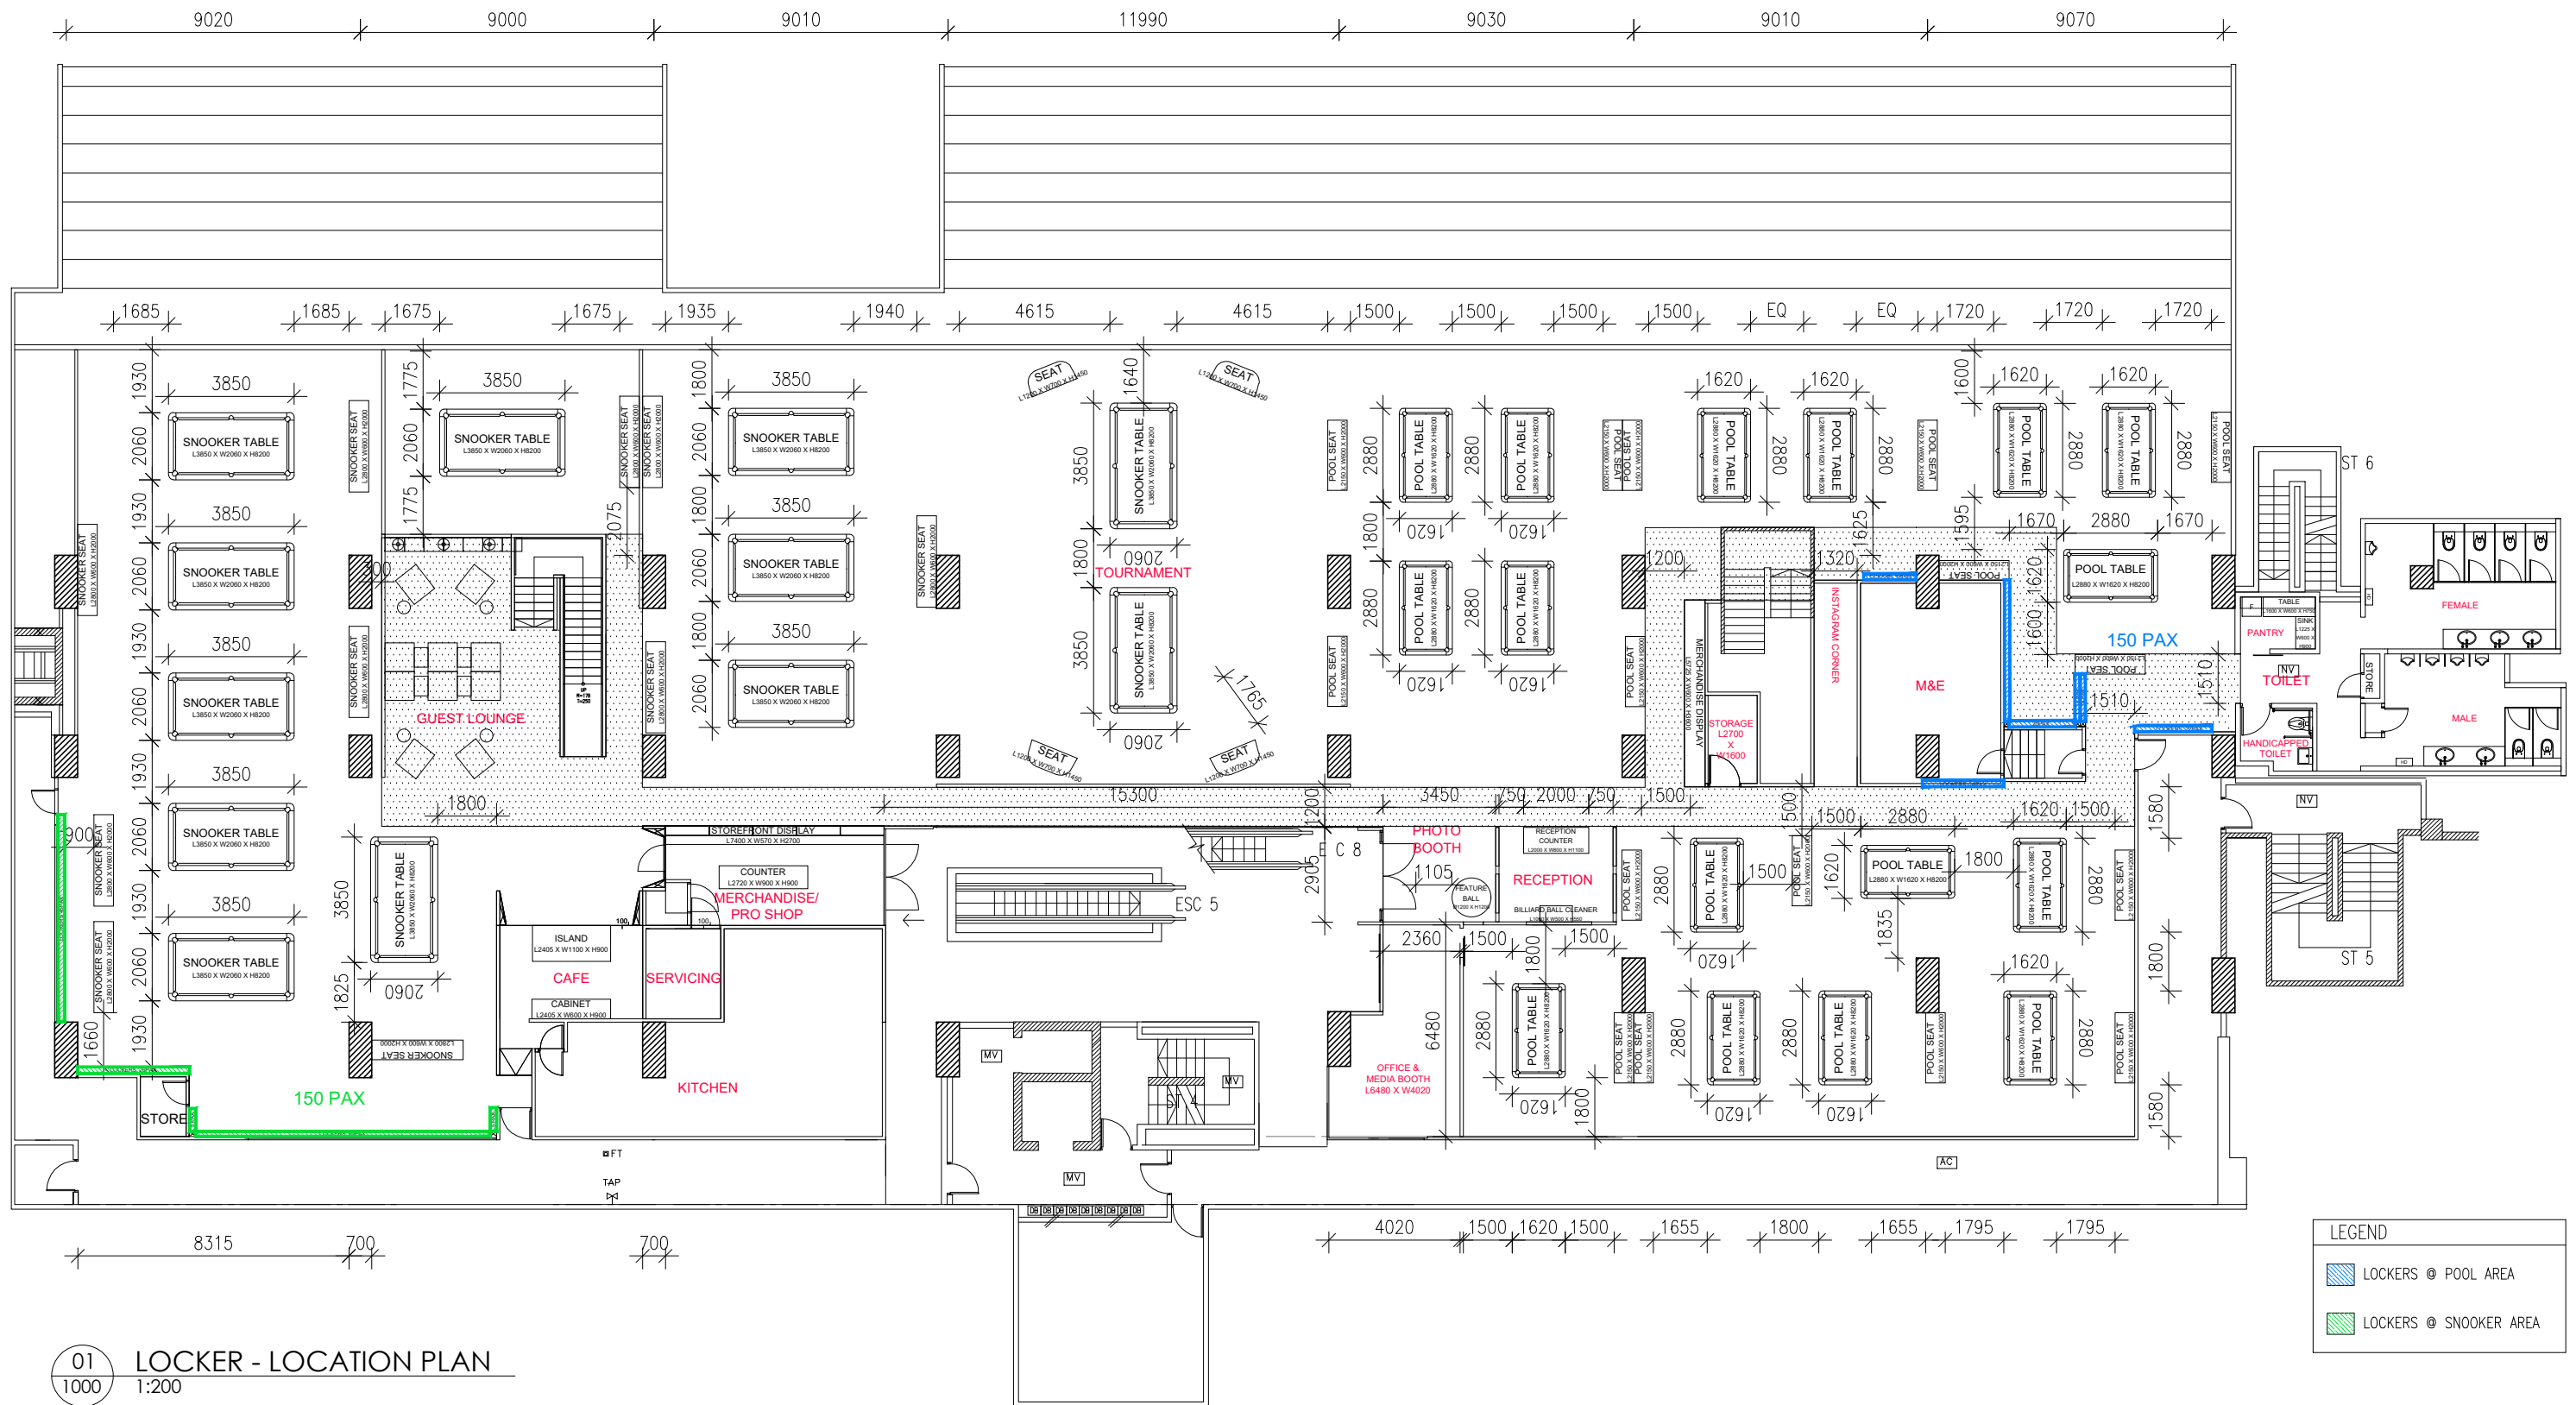

GENERAL NOTES

ALL DIMENSIONS SHOWN ARE IN MILLIMETRES & SHALL BE VERIFIED ON SITE BY THE CONTRACTOR OR SUB-CONTRACTOR.
ALL DIMENSIONS SHOULD NOT BE SCALED FROM THE DRAWING UNLESS OTHERWISE INSTRUCTED. ANY DISCREPANCIES SHALL BE MADE KNOWN TO THE DESIGNER FOR DECISION PRIOR TO PROCEEDING OF THE WORK.

PROJECT TITLE

PROPOSED RENOVATION WORKS TO
ROSSA

DRAWING TITLE

KEY PLAN - LOCKERS LOCATION

SCALE

AS SHOWN (@A3 PRINT)

DATE

31 AUG 2021

DRAWN

SY

FILENAME

ROSSA


VERSION

B


OICHI TOLOGY
(PRIVATE) LIMITED

DRAWING NO.


1000

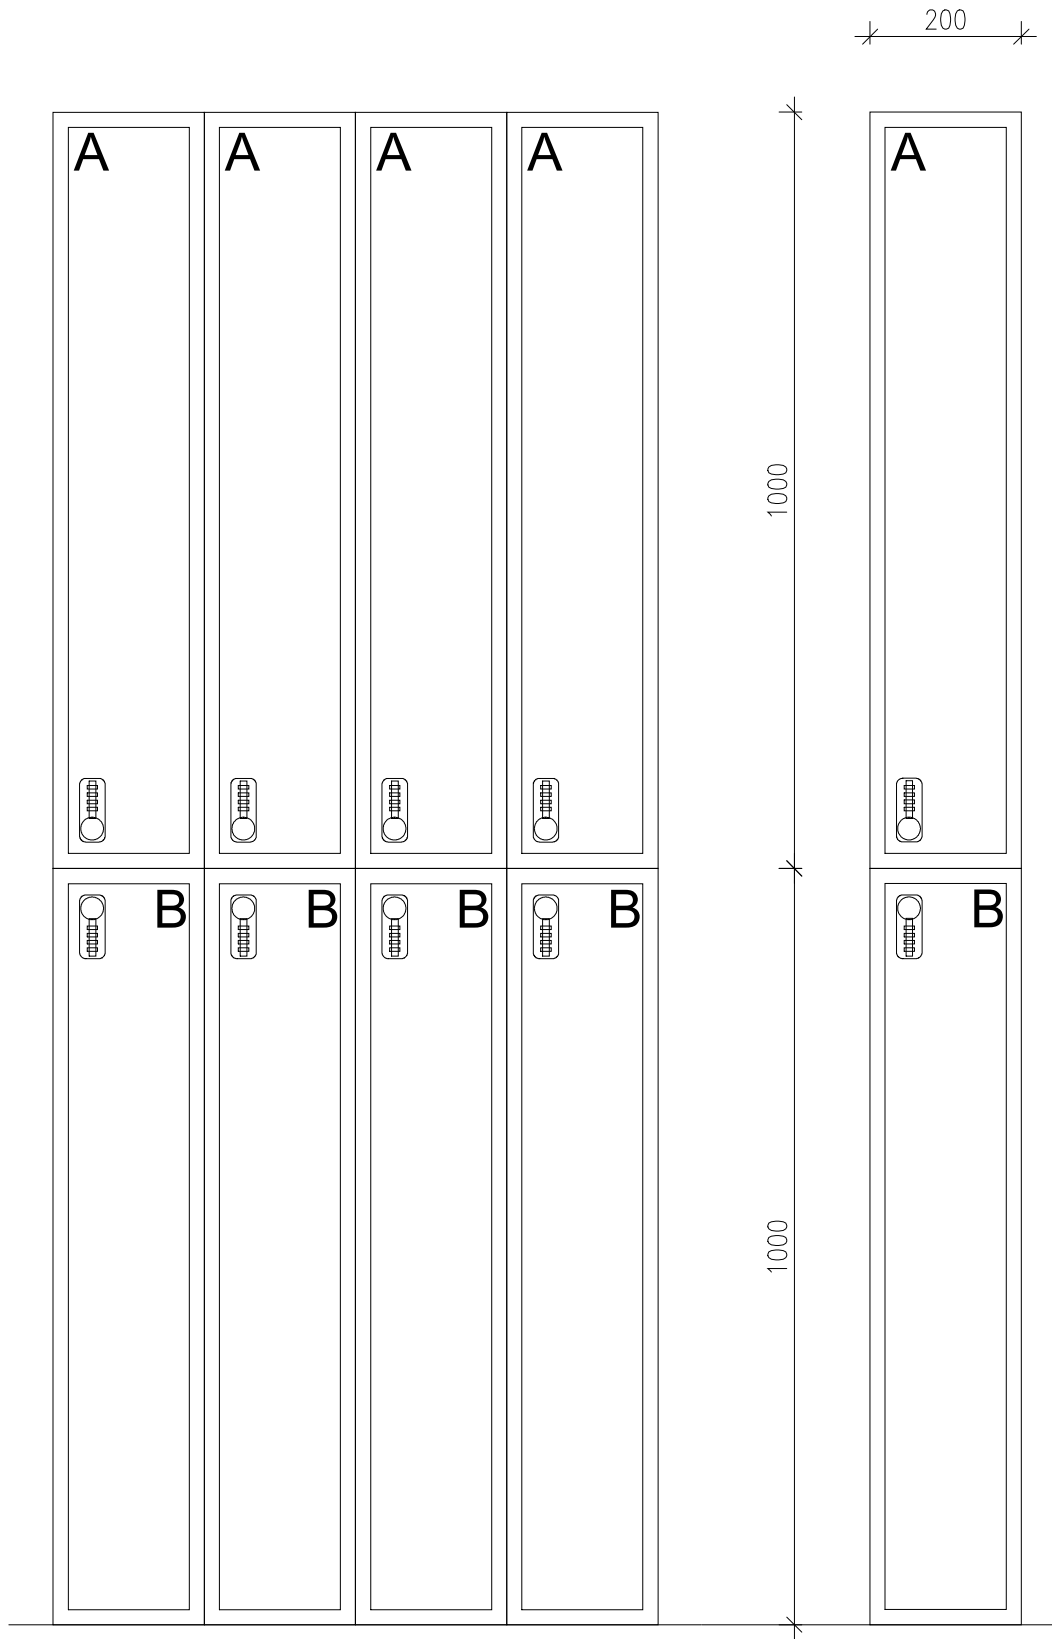


1 FRONT ELEVATION
1001 SCALE 1:10

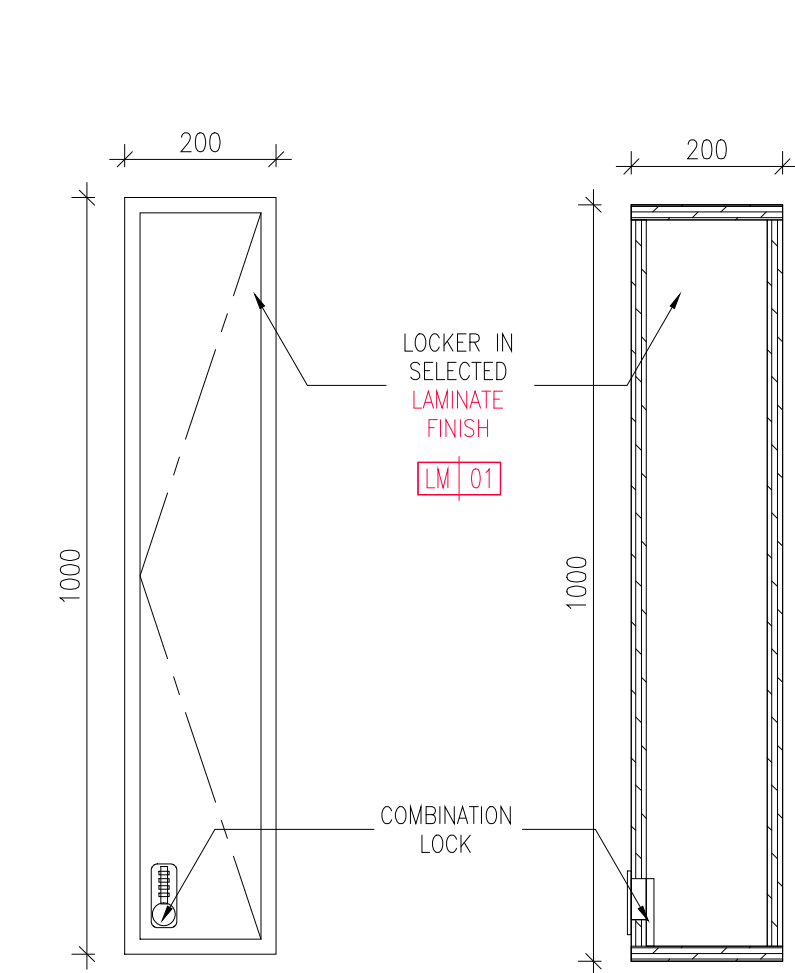


2 LOCKER A FRONT
1001 SCALE 1:10

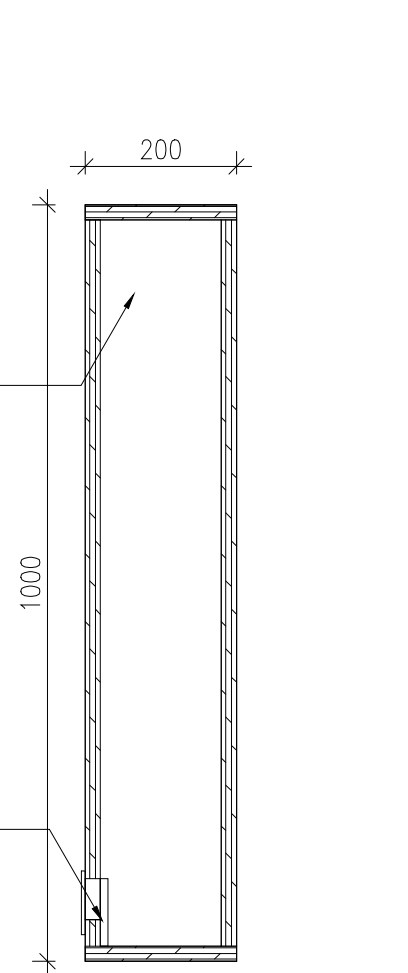


3 LOCKER A SIDE
1001 SCALE 1:10

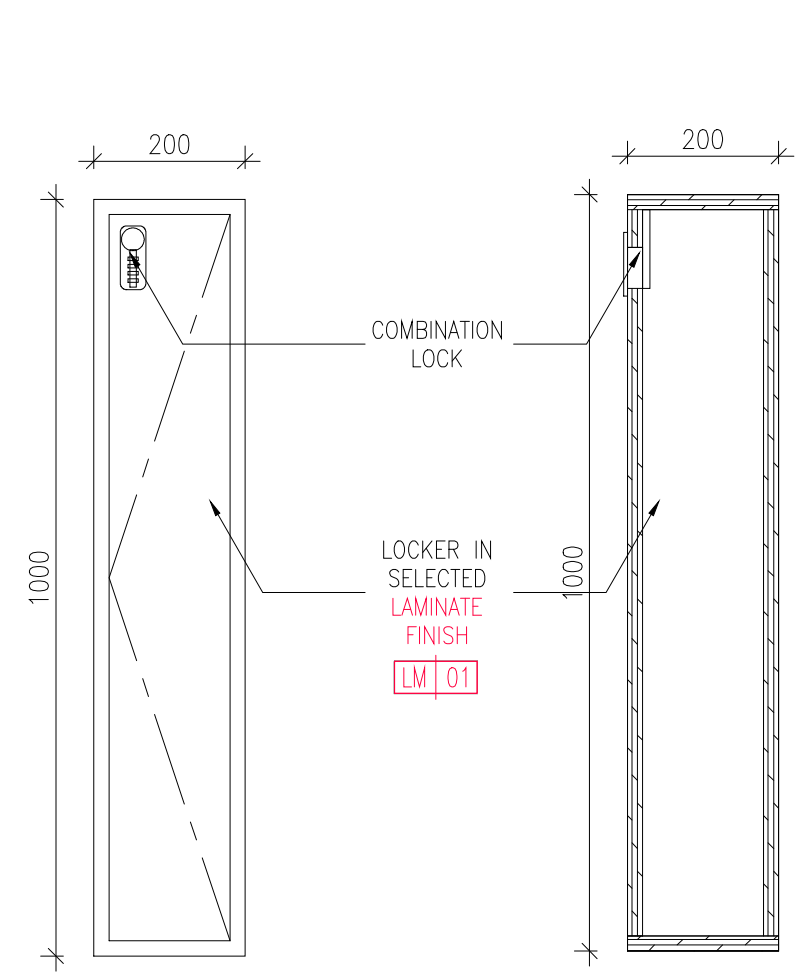


4 LOCKER B FRONT
1001 SCALE 1:10

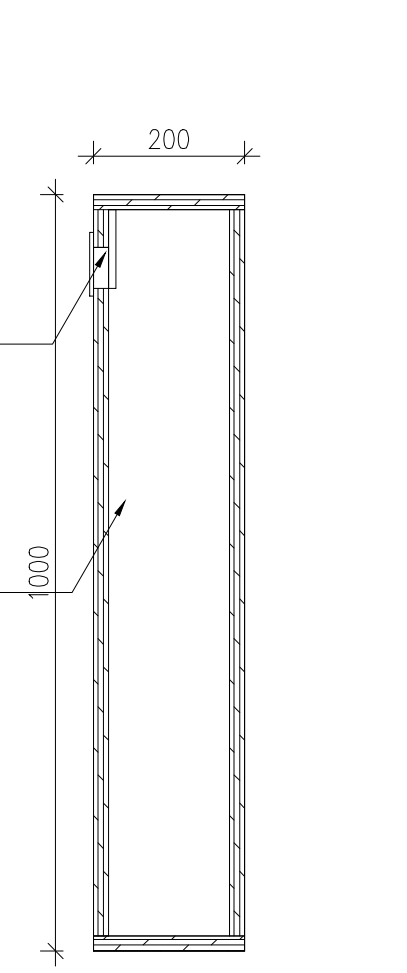

5 LOCKER B SIDE
1001 SCALE 1:10

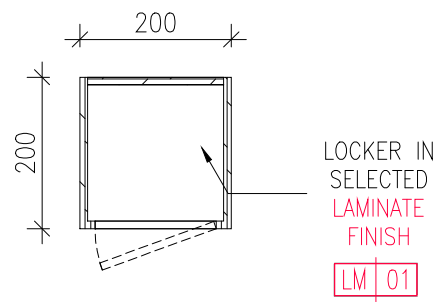

6 LOCKER A & B PLAN
1001 SCALE 1:10

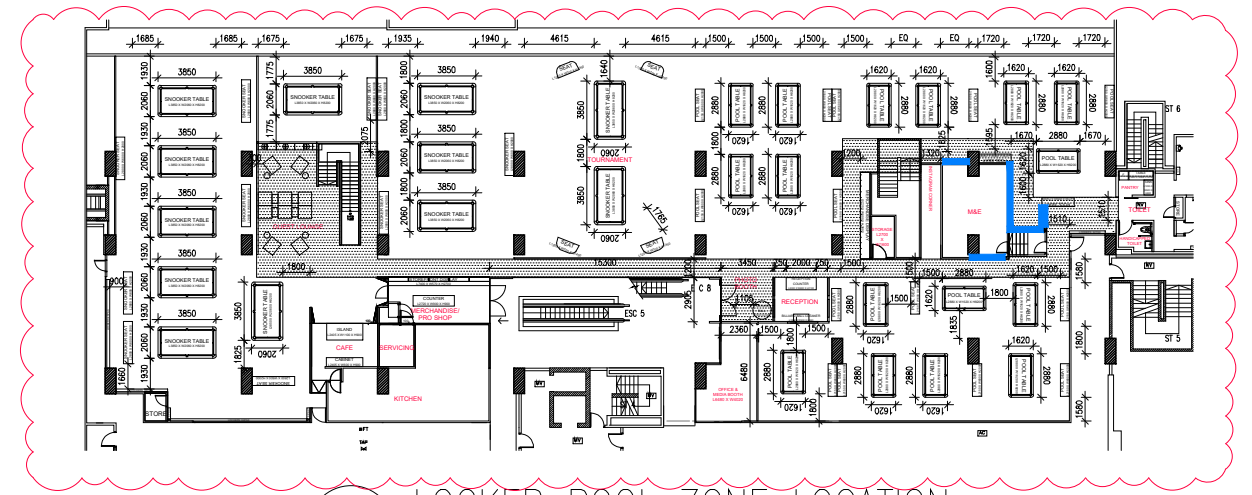

LOCKER POOL ZONE LOCATION
SCALE NTS

GENERAL NOTES

ALL DIMENSIONS SHOWN ARE IN MILLIMETRES & SHALL BE VERIFIED ON SITE BY THE CONTRACTOR OR SUB-CONTRACTOR.
ALL DIMENSIONS SHOULD NOT BE SCALED FROM THE DRAWING UNLESS OTHERWISE INSTRUCTED. ANY DISCREPANCIES SHALL BE MADE KNOWN TO THE DESIGNER FOR DECISION PRIOR TO PROCEEDING OF THE WORK.

PROJECT TITLE

PROPOSED RENOVATION WORKS TO ROSSA

DRAWING TITLE

LOCKERS DETAIL - POOL ZONE

SCALE

AS SHOWN (@ A3 PRINT)

DATE

01 SEPT 2021

DRAWN

SY

FILENAME

ROSSA


VERSION

D


OICHI TOLOGY
(PRIVATE) LIMITED

DRAWING NO.


1001

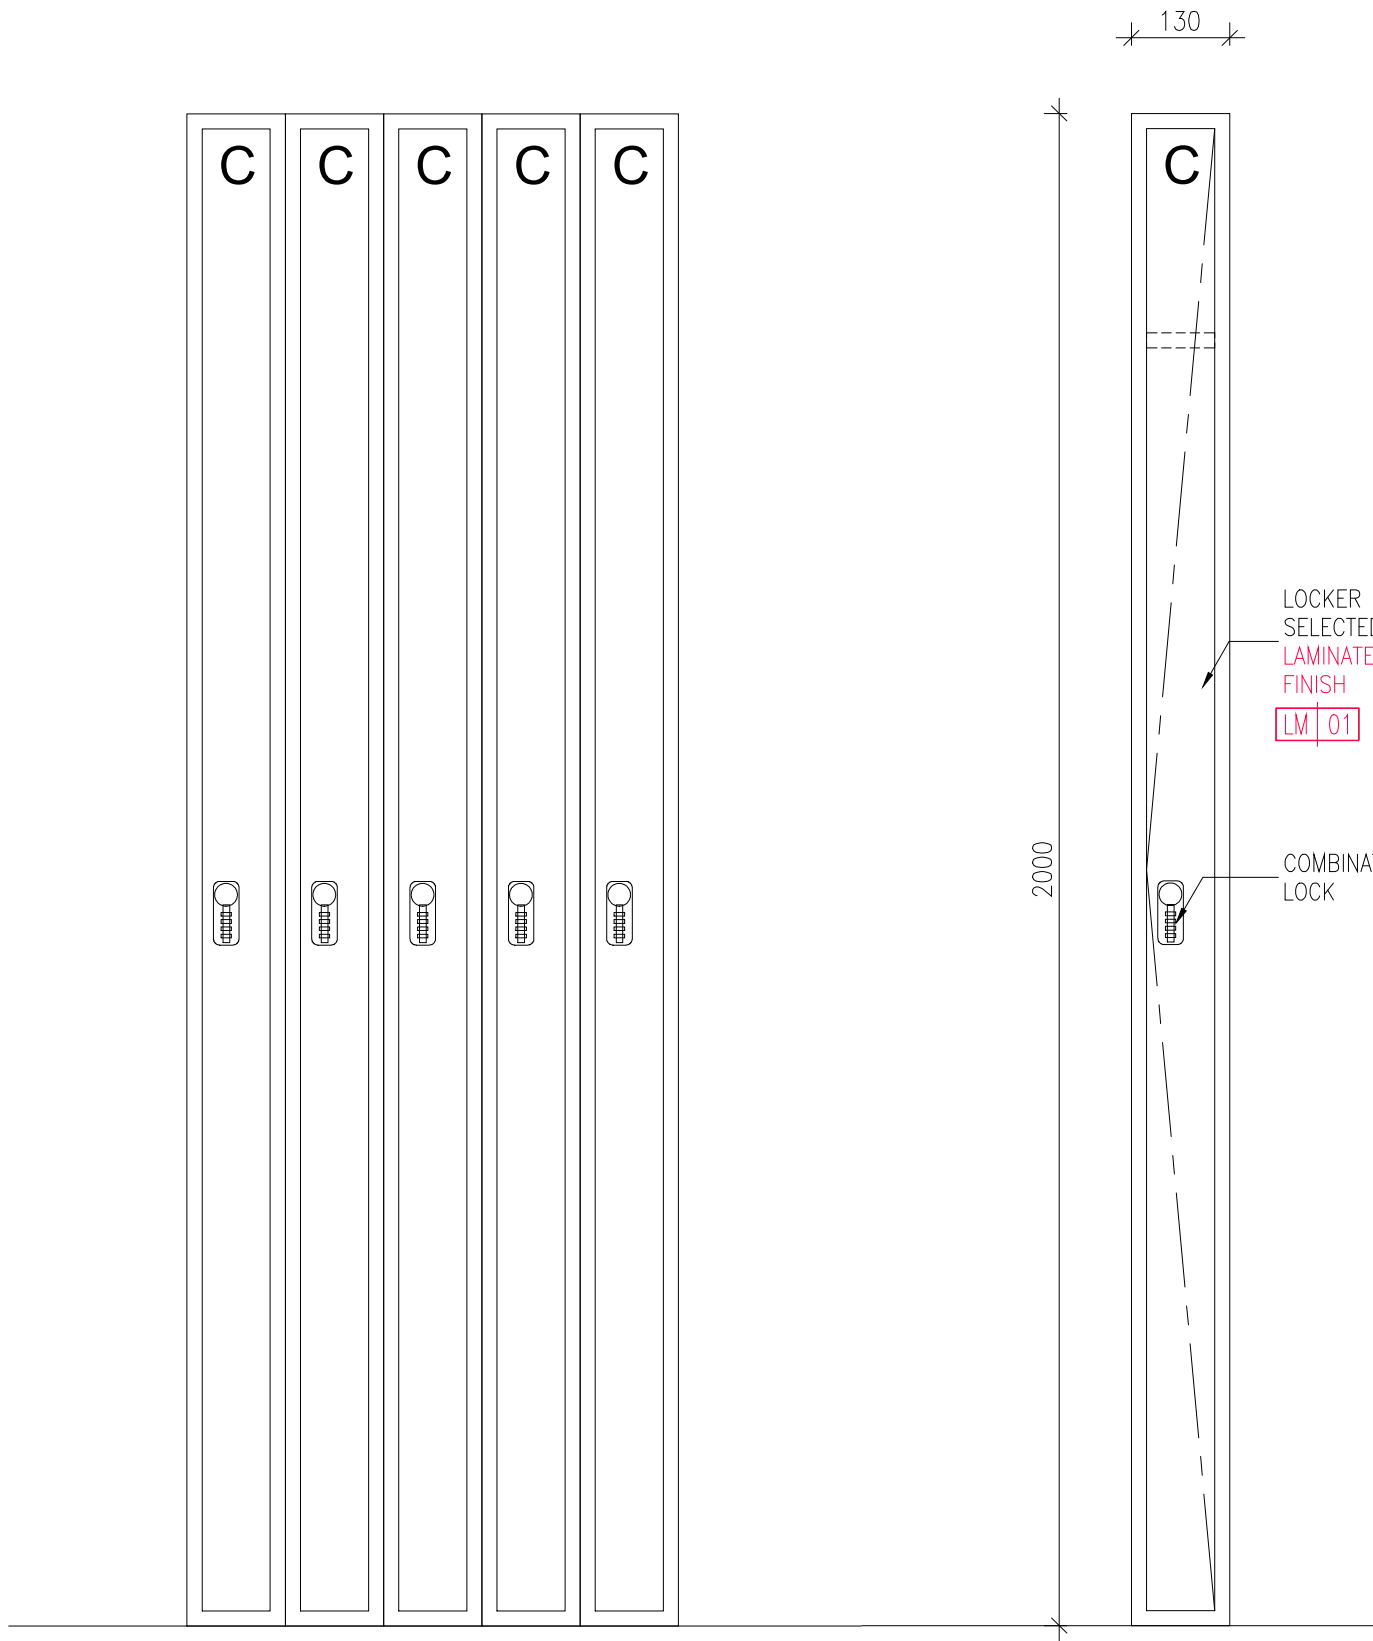


1 FRONT ELEVATION
1002 SCALE 1:10

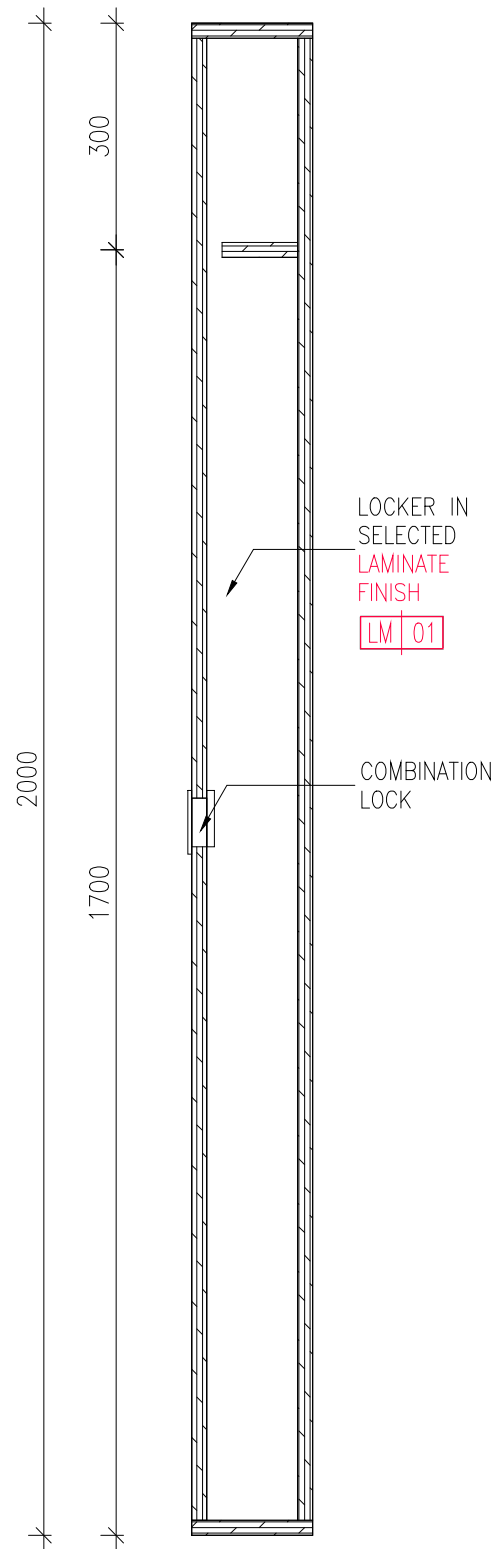

2 LOCKER C SIDE
1002 SCALE 1:10

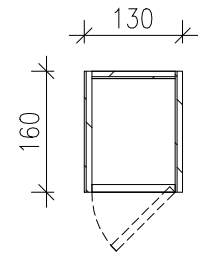

3 LOCKER C PLAN
1002 SCALE 1:10

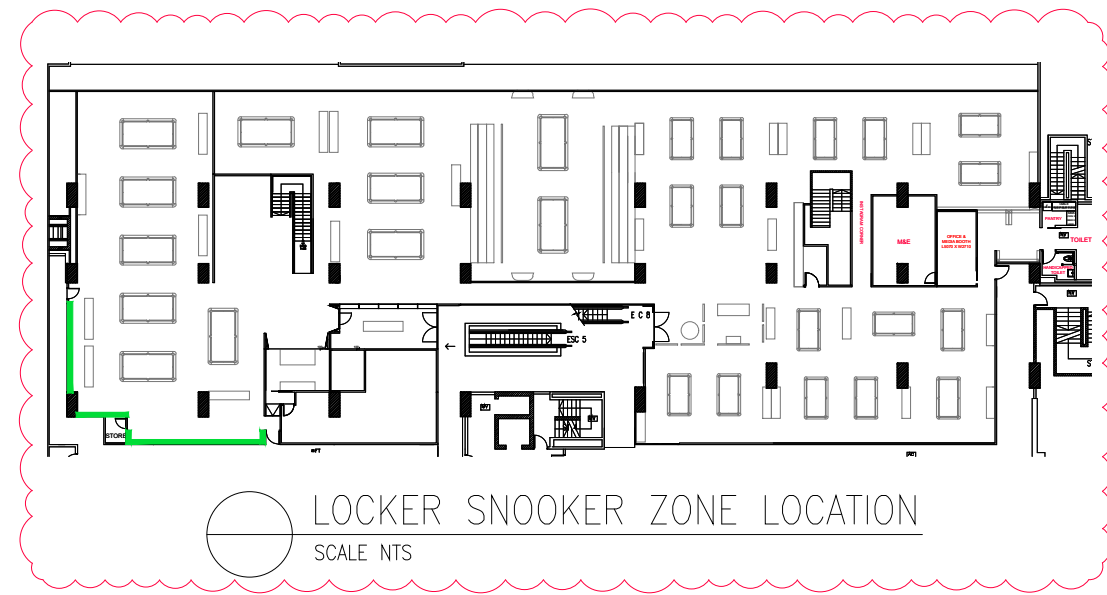

LOCKER SNOOKER ZONE LOCATION
SCALE NTS

GENERAL NOTES

ALL DIMENSIONS SHOWN ARE IN MILLIMETRES & SHALL BE VERIFIED ON SITE BY THE CONTRACTOR OR SUB-CONTRACTOR.
ALL DIMENSIONS SHOULD NOT BE SCALED FROM THE DRAWING UNLESS OTHERWISE INSTRUCTED. ANY DISCREPANCIES SHALL BE MADE KNOWN TO THE DESIGNER FOR DECISION PRIOR TO PROCEEDING OF THE WORK.

PROJECT TITLE

PROPOSED RENOVATION WORKS TO
ROSSA

DRAWING TITLE

LOCKERS DETAIL - SNOOKER ZONE

SCALE

DATE

DRAWN

FILENAME

VERSION

AS SHOWN (@ A3 PRINT)

01 SEPT 2021

SY


ROSSA

D

OICHI TOLOGY
(PRIVATE) LIMITED

DRAWING NO.

1002

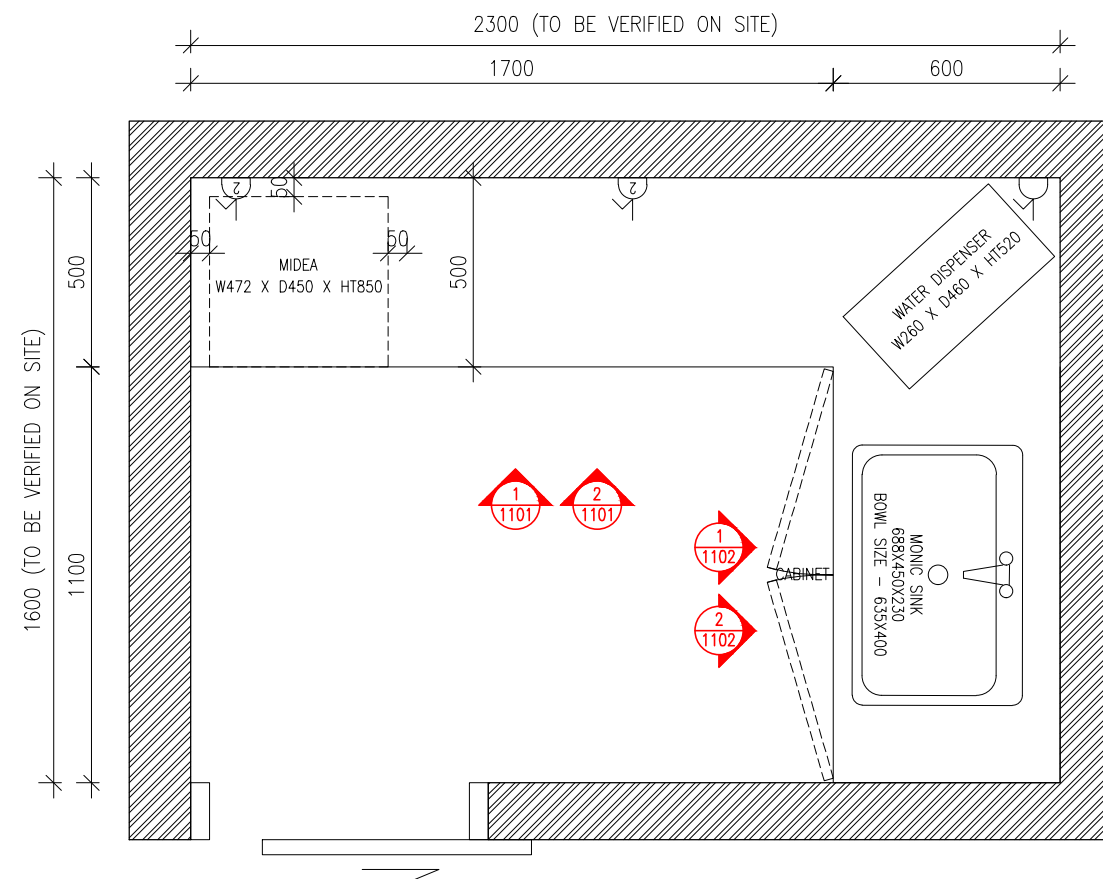

01
1100

PANTRY PART PLAN
SCALE 1:20

GENERAL NOTES

ALL DIMENSIONS SHOWN ARE IN MILLIMETRES & SHALL BE VERIFIED ON SITE BY THE CONTRACTOR OR SUB-CONTRACTOR.
ALL DIMENSIONS SHOULD NOT BE SCALED FROM THE DRAWING UNLESS OTHERWISE INSTRUCTED, ANY DISCREPANCIES SHALL BE MADE KNOWN TO THE DESIGNER FOR DECISION PRIOR TO PROCEEDING OF THE WORK.

PROJECT TITLE

PROPOSED RENOVATION WORKS TO
ROSSA

DRAWING TITLE


PANTRY DETAIL

SCALE	AS SHOWN (@ A3 PRINT)
DATE	31 AUGUST 2021
DRAWN	HH
FILENAME	--
VERSION	D


OICHI TOLOGY
(PRIVATE) LIMITED

DRAWING NO.

1100

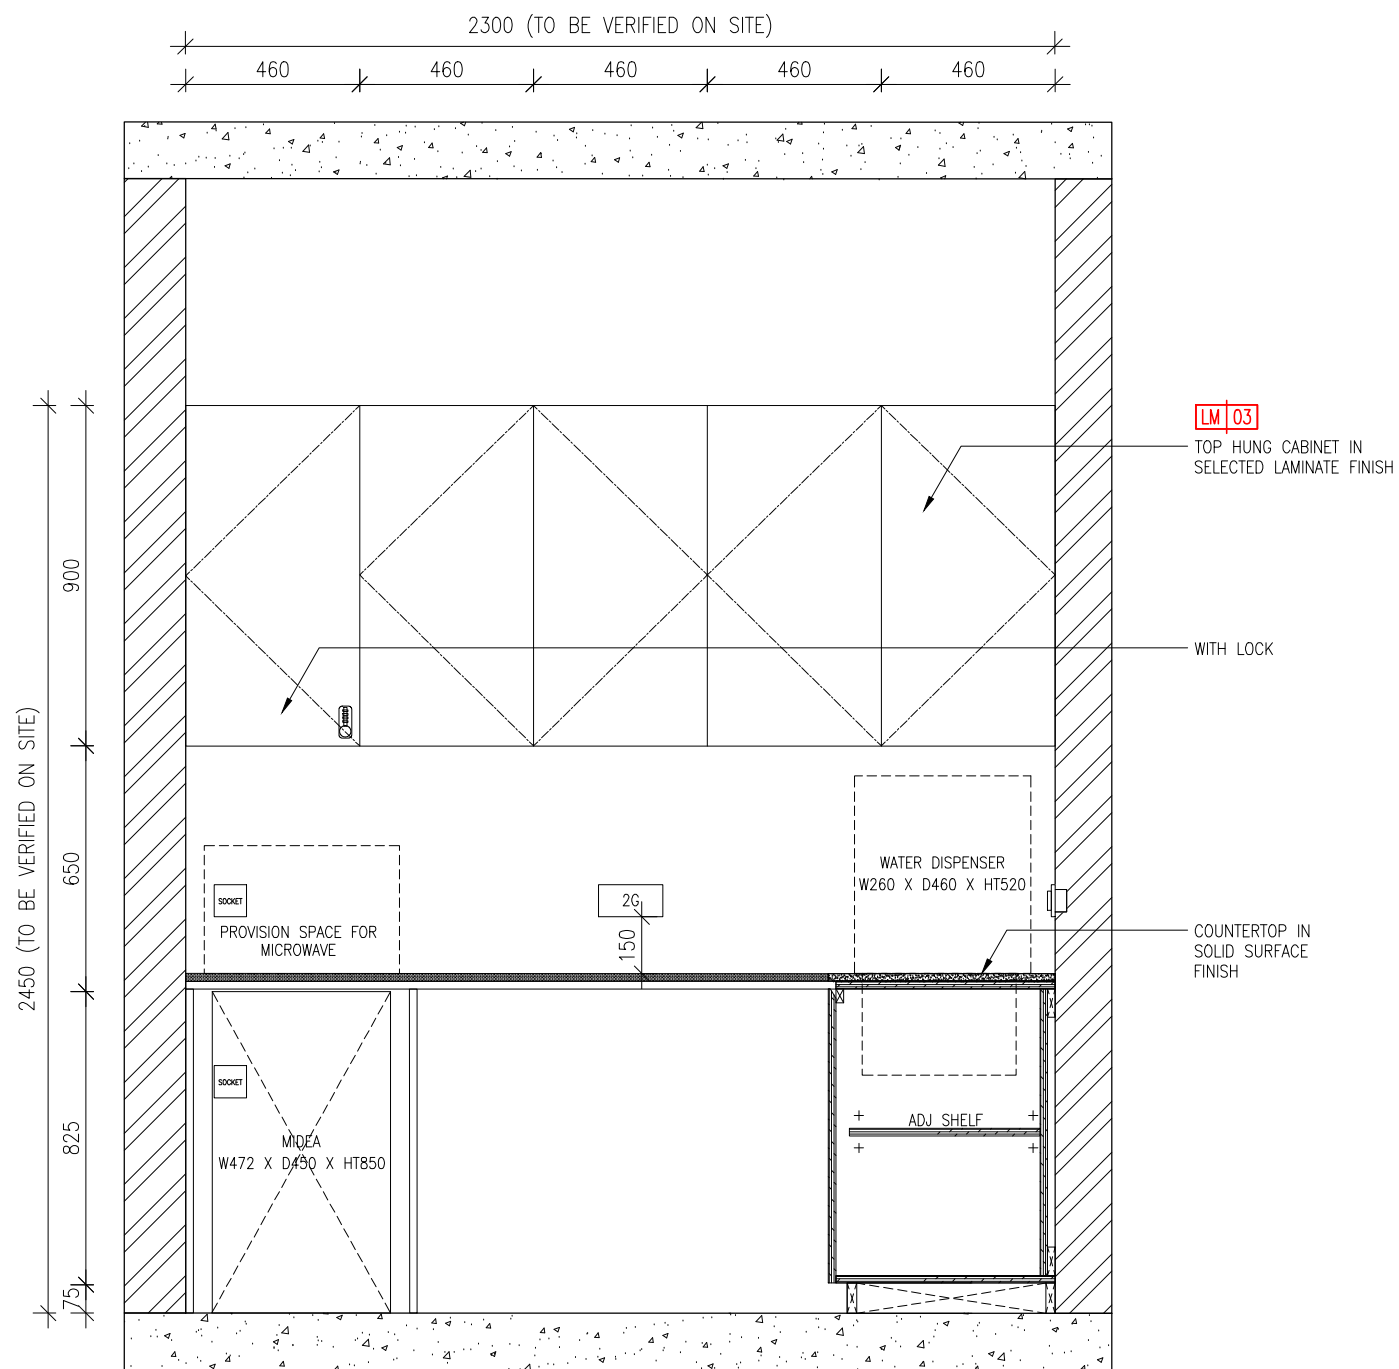

01 PANTRY ELEVATION 1 (EXTERNAL)
1101 SCALE 1:20

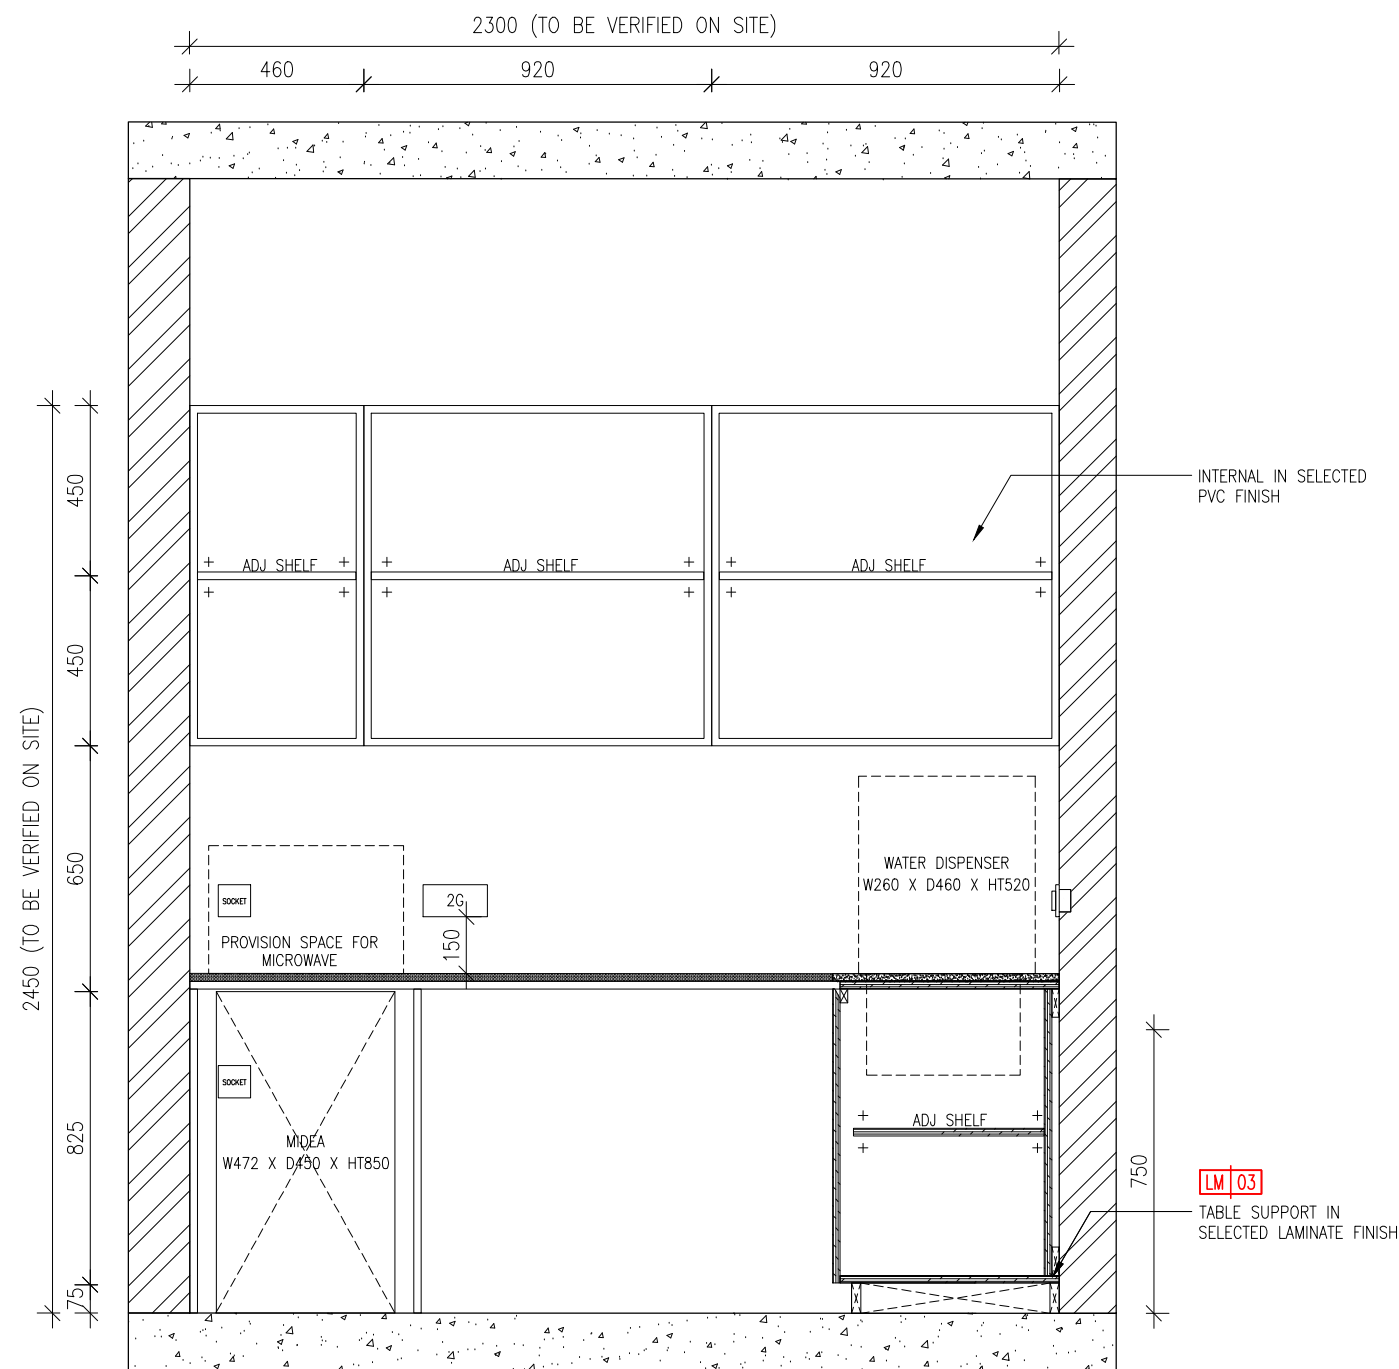

02 PANTRY ELEVATION 1 (INTERNAL)
1101 SCALE 1:20

GENERAL NOTES

ALL DIMENSIONS SHOWN ARE IN MILLIMETRES & SHALL BE VERIFIED ON SITE BY THE CONTRACTOR OR SUB-CONTRACTOR. ALL DIMENSIONS SHOULD NOT BE SCALED FROM THE DRAWING UNLESS OTHERWISE INSTRUCTED. ANY DISCREPANCIES SHALL BE MADE KNOWN TO THE DESIGNER FOR DECISION PRIOR TO PROCEEDING OF THE WORK.

PROJECT TITLE

PROPOSED RENOVATION WORKS TO ROSSA

DRAWING TITLE

PANTRY DETAIL

SCALE AS SHOWN (@ A3 PRINT)

DATE 31 AUGUST 2021


DRAWN HH

FILENAME --


VERSION D

OFCHITOLGY
(PRIVATE) LIMITED

DRAWING NO. 1101

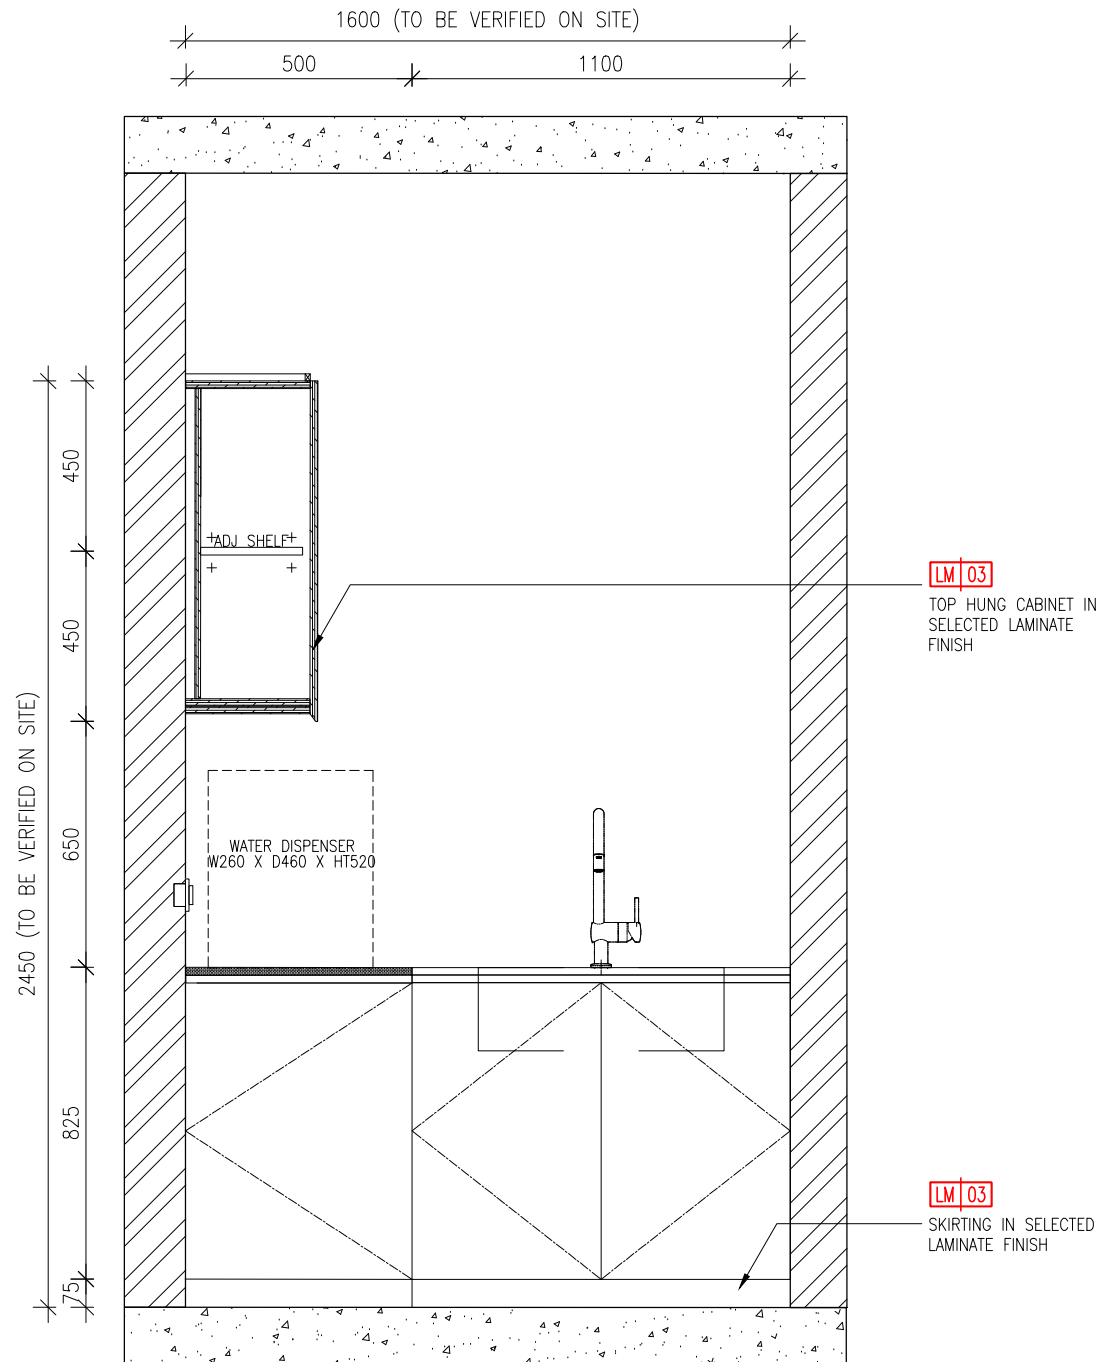

01 PANTRY ELEVATION 2 (EXTERNAL)
1102 SCALE 1:20

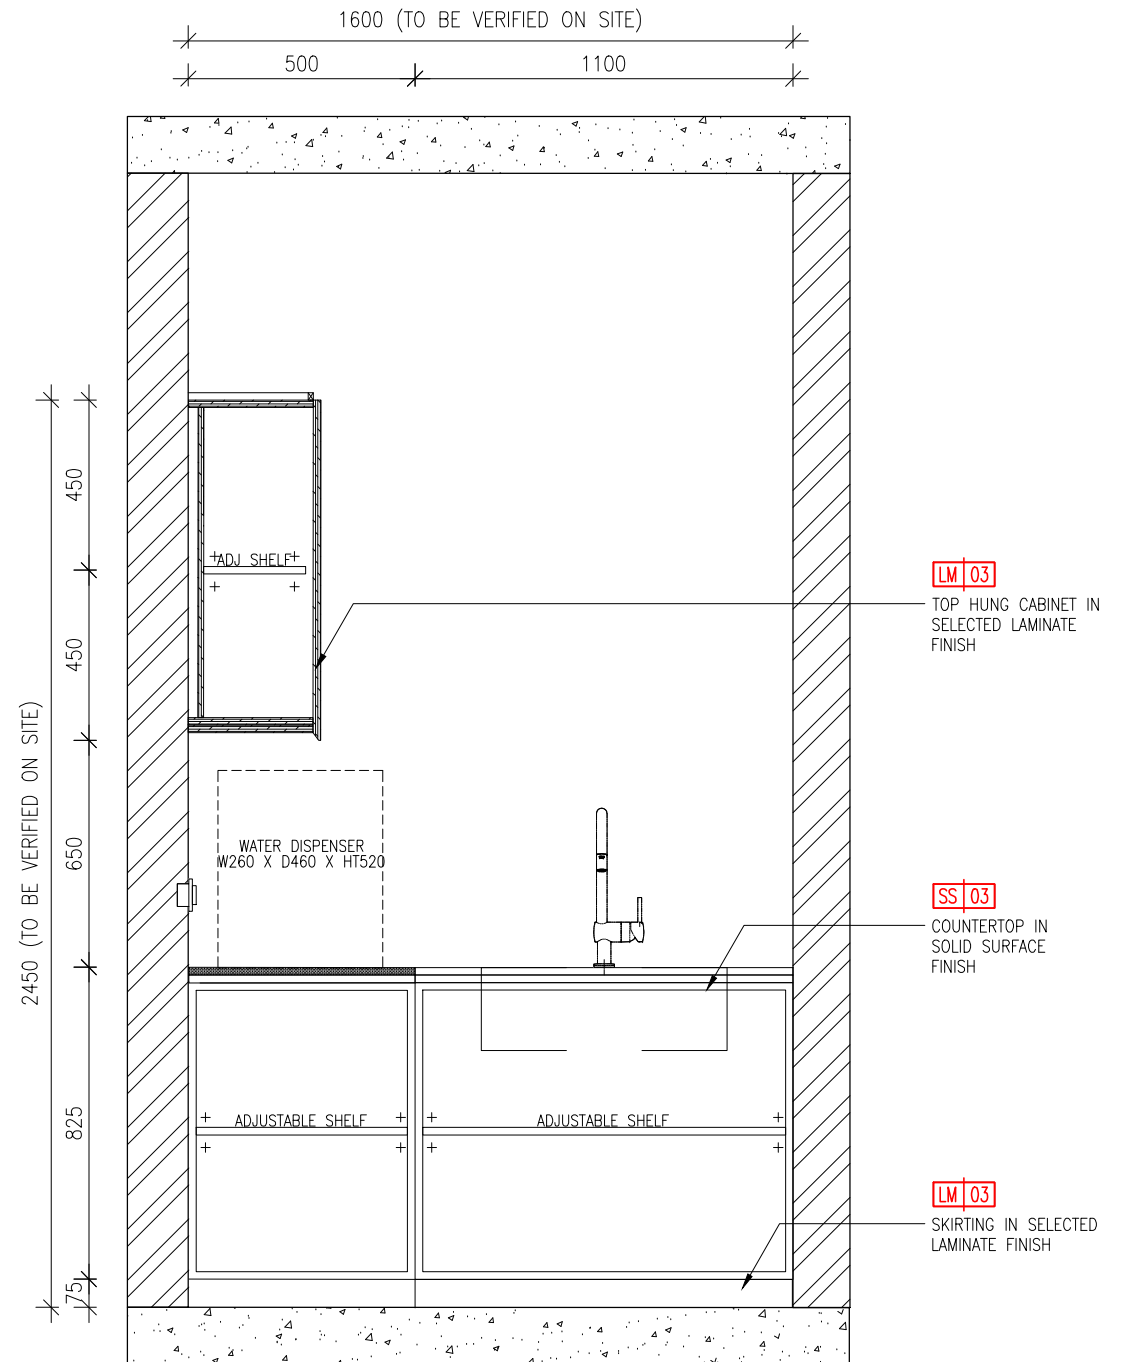

02 PANTRY ELEVATION 2 (INTERNAL)
1102 SCALE 1:20

GENERAL NOTES

ALL DIMENSIONS SHOWN ARE IN MILLIMETRES & SHALL BE VERIFIED ON SITE BY THE CONTRACTOR OR SUB-CONTRACTOR.
ALL DIMENSIONS SHOULD NOT BE SCALED FROM THE DRAWING UNLESS OTHERWISE INSTRUCTED. ANY DISCREPANCIES SHALL BE MADE KNOWN TO THE DESIGNER FOR DECISION PRIOR TO PROCEEDING OF THE WORK.

PROJECT TITLE

PROPOSED RENOVATION WORKS TO
ROSSA

DRAWING TITLE


PANTRY DETAIL

SCALE	AS SHOWN (@ A3 PRINT)
DATE	31 AUGUST 2021
DRAWN	HH
FILENAME	--
VERSION	D

OFCHITOL
(PRIVATE) LIMITED

DRAWING NO.

1102

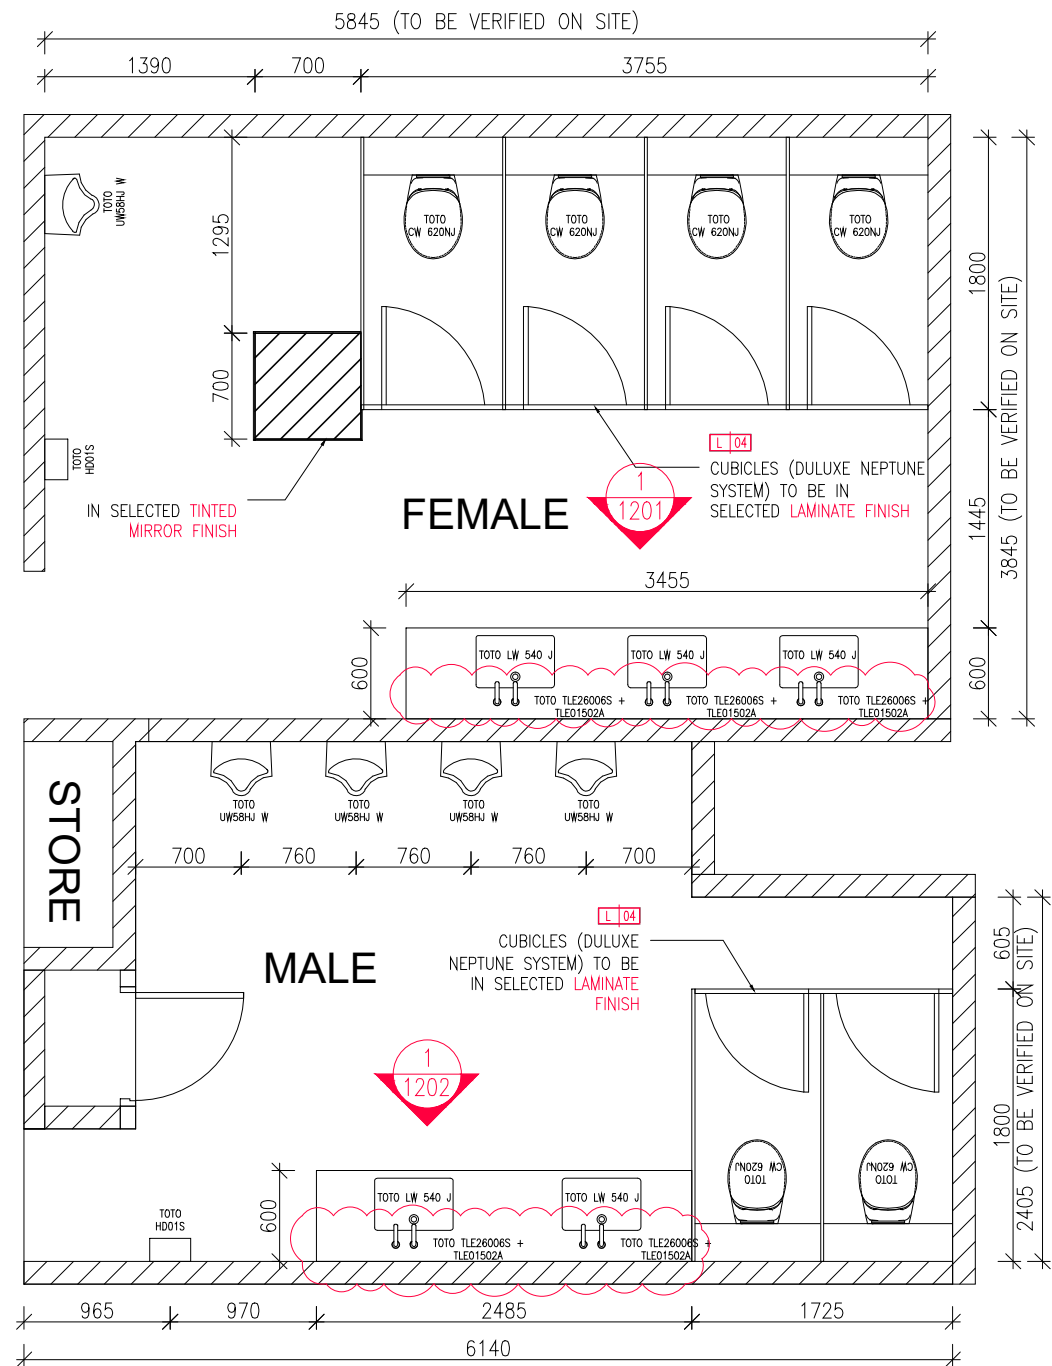

01
1200
TOILET PART PLAN
SCALE 1:50

TO NOTE
ALL WALLS TO BE IN TL-03

GENERAL NOTES

ALL DIMENSIONS SHOWN ARE IN MILLIMETRES & SHALL BE VERIFIED ON SITE BY THE CONTRACTOR OR SUB-CONTRACTOR.
ALL DIMENSIONS SHOULD NOT BE SCALED FROM THE DRAWING UNLESS OTHERWISE INSTRUCTED. ANY DISCREPANCIES SHALL BE MADE KNOWN TO THE DESIGNER FOR DECISION PRIOR TO PROCEEDING OF THE WORK.

PROJECT TITLE

PROPOSED RENOVATION WORKS TO
ROSSA

DRAWING TITLE

TOILET PART PLAN

SCALE

AS SHOWN (@ A3 PRINT)

DATE

08 SEPT 2021

DRAWN

SY


FILENAME

ROSSA

VERSION

D

ORCHITOL
(PRIVATE) LIMITED
DRAWING NO. 1200

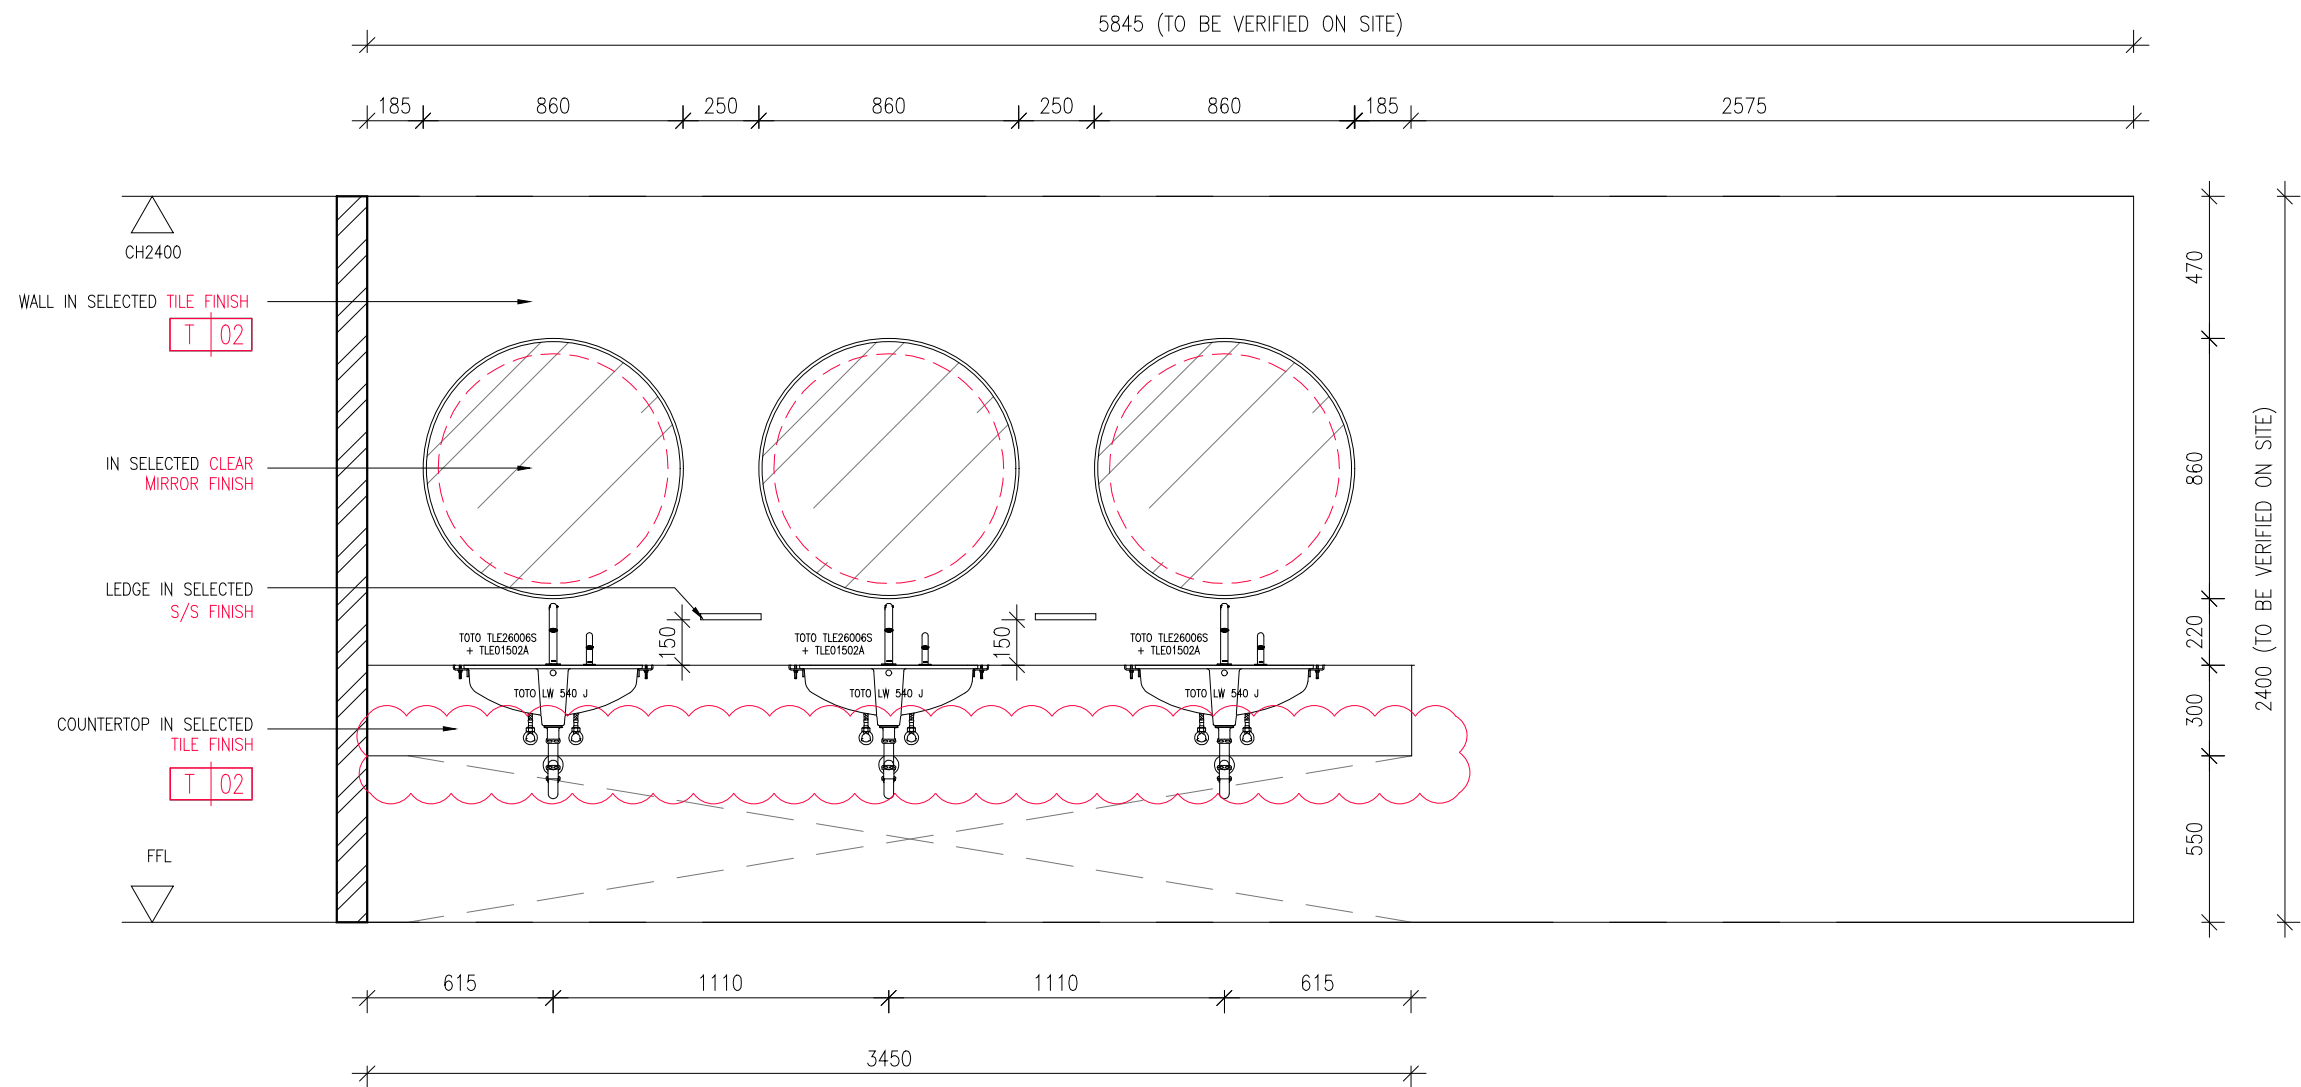

01
1201 FEMALE TOILET ELEVATION 1
1:25

PROJECT TITLE

GENERAL NOTES

ALL DIMENSIONS SHOWN ARE IN MILLIMETRES & SHALL BE VERIFIED ON SITE BY THE CONTRACTOR OR SUB-CONTRACTOR.
ALL DIMENSIONS SHOULD NOT BE SCALED FROM THE DRAWING UNLESS OTHERWISE INSTRUCTED. ANY DISCREPANCIES SHALL BE MADE KNOWN TO THE DESIGNER FOR DECISION PRIOR TO PROCEEDING OF THE WORK.

PROPOSED RENOVATION WORKS TO
ROSSA

DRAWING TITLE

FEMALE TOILET ELEVATION 1

SCALE

DATE

DRAWN

FILENAME

VERSION

AS SHOWN (@ A3 PRINT)

08 SEPT 2021

SY


ROSSA

E

OICHI TOLOGY
(PRIVATE) LIMITED

DRAWING NO.

1201

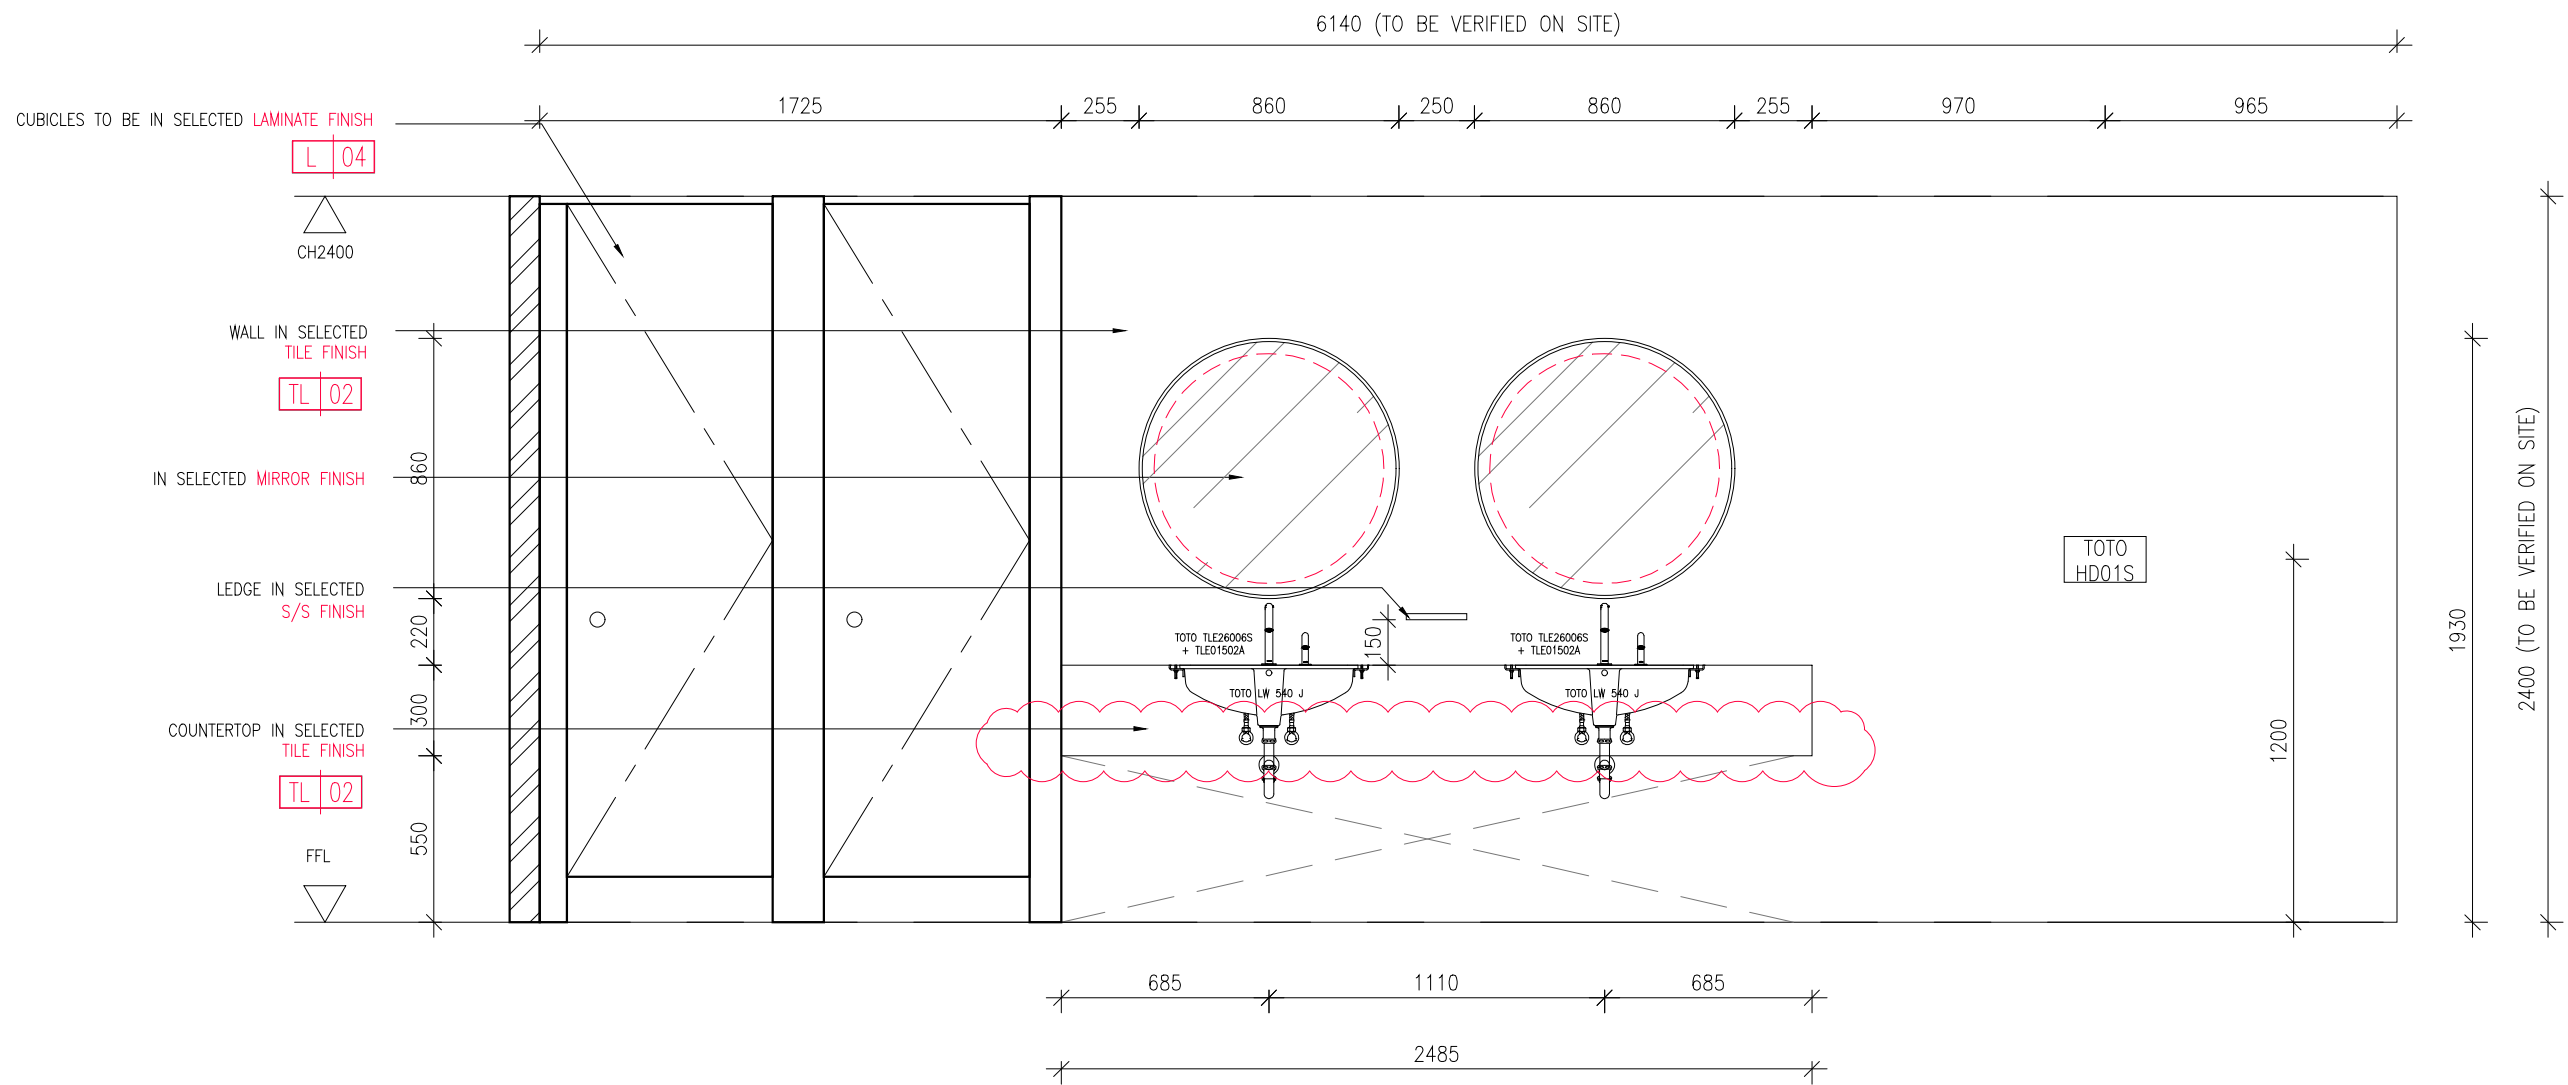

01
1202

MALE TOILET ELEVATION 1
1:25

GENERAL NOTES

ALL DIMENSIONS SHOWN ARE IN MILLIMETRES & SHALL BE VERIFIED ON SITE BY THE CONTRACTOR OR SUB-CONTRACTOR.
ALL DIMENSIONS SHOULD NOT BE SCALED FROM THE DRAWING UNLESS OTHERWISE INSTRUCTED. ANY DISCREPANCIES SHALL BE MADE KNOWN TO THE DESIGNER FOR DECISION PRIOR TO PROCEEDING OF THE WORK.

PROJECT TITLE

PROPOSED RENOVATION WORKS TO
ROSSA

DRAWING TITLE

MALE TOILET ELEVATION 1

SCALE

1 :25

DATE

08 SEPT 2021

DRAWN

SY

FILENAME

ROSSA

VERSION

E

OICHITOLOGY
(PRIVATE) LIMITED

DRAWING NO.

1202



ALL DIMENSIONS SHOWN ARE IN MILLIMETRES & SHALL BE VERIFIED ON SITE BY THE CONTRACTOR OR SUB-CONTRACTOR.
ALL DIMENSIONS SHOULD NOT BE SCALED FROM THE DRAWING UNLESS OTHERWISE INSTRUCTED. ANY DISCREPANCIES SHALL BE MADE KNOWN TO THE DESIGNER FOR DECISION PRIOR TO PROCEEDING OF THE WORK.

PROJECT TITLE

PROPOSED RENOVATION WORKS TO ROSSA

DRAWING TITLE

STAIRCASE PLAN & ELEVATION 1


SCALE	AS SHOWN (@A3 PRINT)
DATE	16 AUG 2021
DRAWN	SY
FILENAME	ROSSA
VERSION	B



ORCHITOL
(PRIVATE) LIMITED

DRAWING NO.

1300

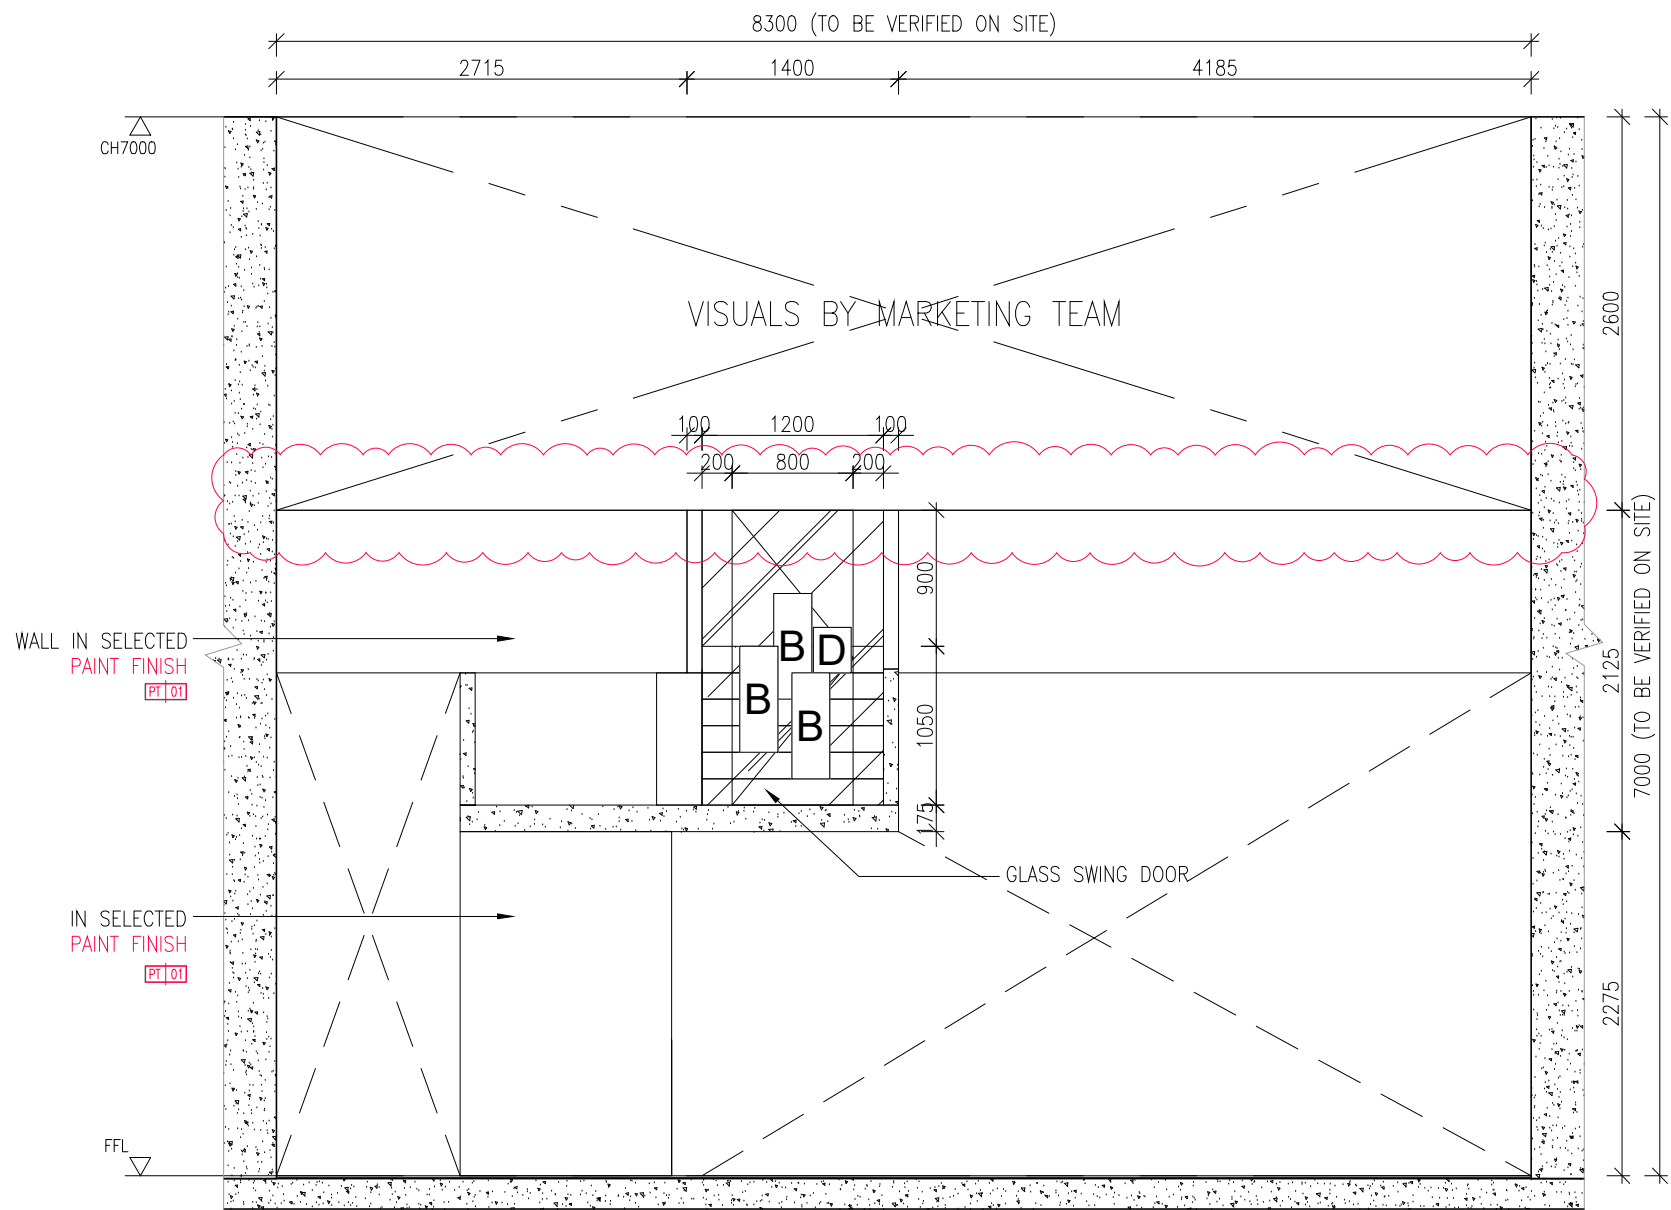

01
1301

STAIRCASE SECTION 1
SCALE 1:50

GENERAL NOTES

ALL DIMENSIONS SHOWN ARE IN MILLIMETRES & SHALL BE VERIFIED ON SITE BY THE CONTRACTOR OR SUB-CONTRACTOR.
ALL DIMENSIONS SHOULD NOT BE SCALED FROM THE DRAWING UNLESS OTHERWISE INSTRUCTED. ANY DISCREPANCIES SHALL BE MADE KNOWN TO THE DESIGNER FOR DECISION PRIOR TO PROCEEDING OF THE WORK.

PROJECT TITLE

PROPOSED RENOVATION WORKS TO
ROSSA

DRAWING TITLE

STAIRCASE SECTION 1

SCALE	AS SHOWN (@A3 PRINT)
DATE	01 SEPT 2021
DRAWN	SY
FILENAME	ROSSA
VERSION	B

OIC


HIT

OLOG

(PRIVATE) LIMITED

DRAWING NO.

1301

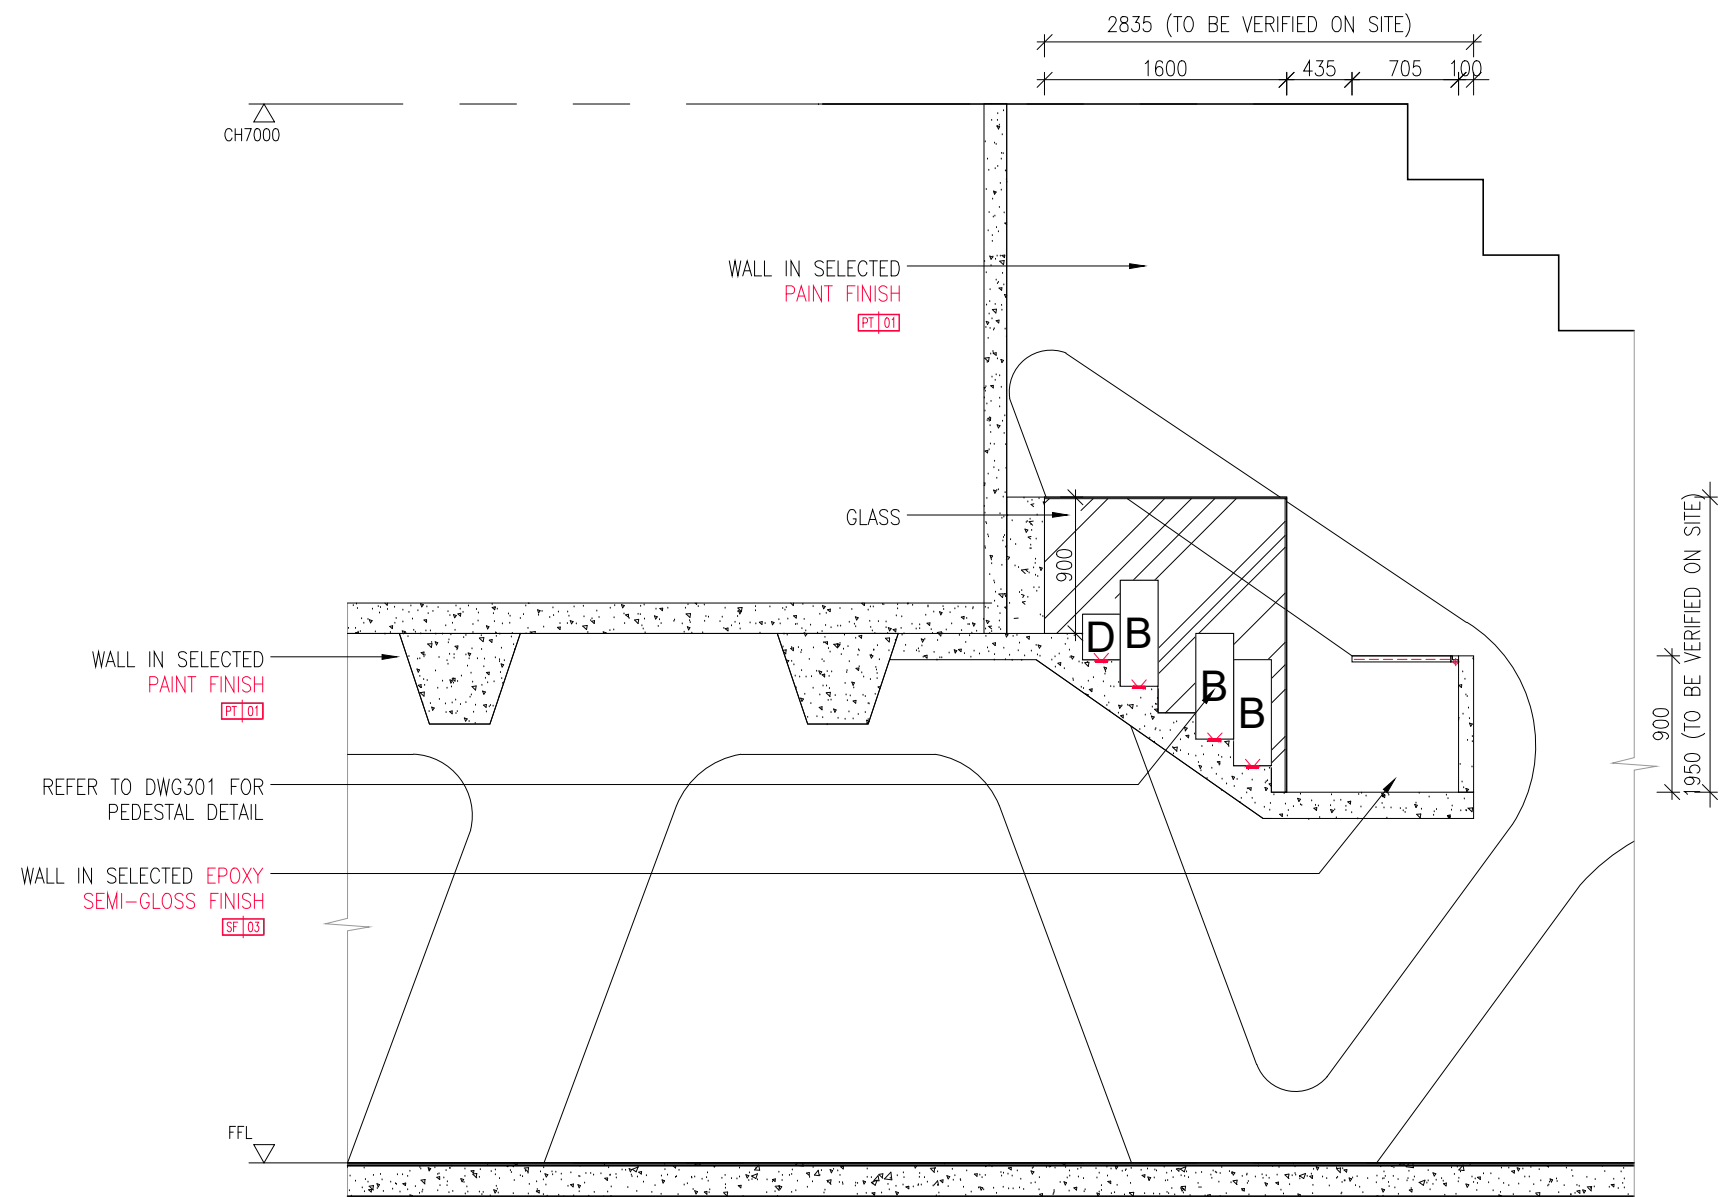

01
1303

STAIRCASE SECTION 3
SCALE 1:50

GENERAL NOTES

ALL DIMENSIONS SHOWN ARE IN MILLIMETRES & SHALL BE VERIFIED ON SITE BY THE CONTRACTOR OR SUB-CONTRACTOR.
ALL DIMENSIONS SHOULD NOT BE SCALED FROM THE DRAWING UNLESS OTHERWISE INSTRUCTED. ANY DISCREPANCIES SHALL BE MADE KNOWN TO THE DESIGNER FOR DECISION PRIOR TO PROCEEDING OF THE WORK.

PROJECT TITLE

PROPOSED RENOVATION WORKS TO
ROSSA

DRAWING TITLE

STAIRCASE SECTION 3

SCALE

AS SHOWN (@A3 PRINT)

DATE

22 JUL 2021

DRAWN

SY

FILENAME

ROSSA


VERSION

A

OICHI TOLOGY
(PRIVATE) LIMITED

DRAWING NO.

1303

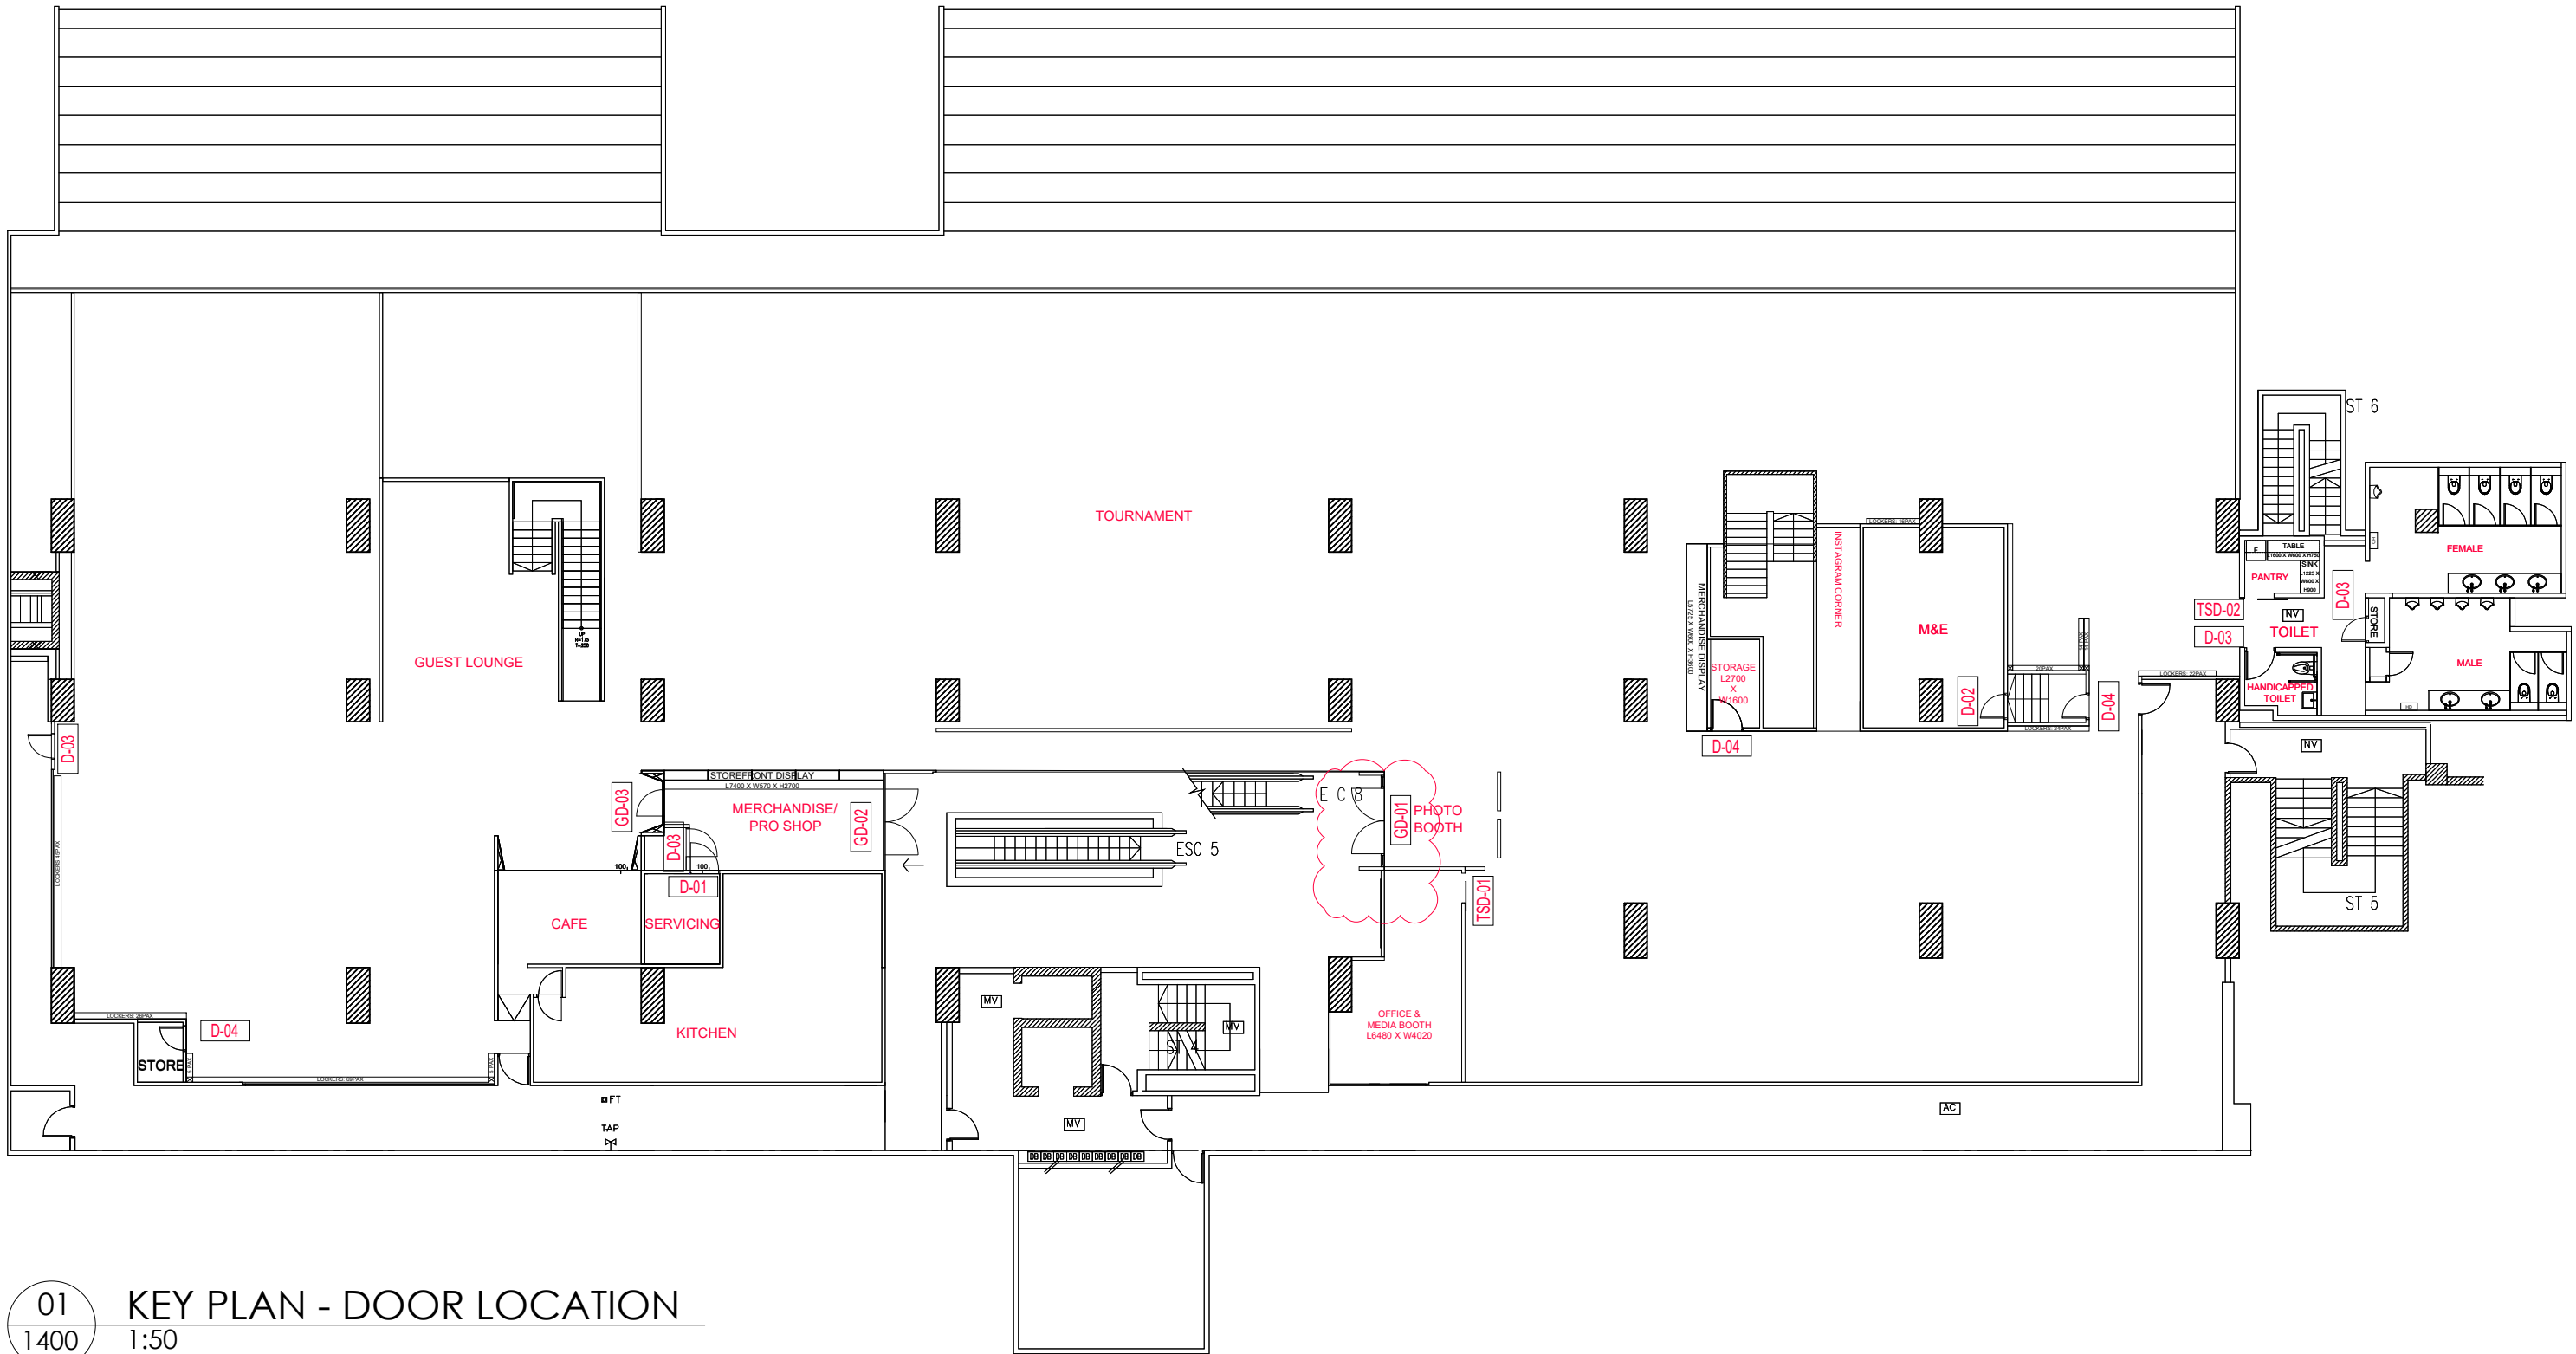

GENERAL NOTES

ALL DIMENSIONS SHOWN ARE IN MILLIMETRES & SHALL BE VERIFIED ON SITE BY THE CONTRACTOR OR SUB-CONTRACTOR. ALL DIMENSIONS SHOULD NOT BE SCALED FROM THE DRAWING UNLESS OTHERWISE INSTRUCTED. ANY DISCREPANCIES SHALL BE MADE KNOWN TO THE DESIGNER FOR DECISION PRIOR TO PROCEEDING OF THE WORK.

PROJECT TITLE

PROPOSED RENOVATION WORKS TO ROSSA

DRAWING TITLE

KEY PLAN - DOOR LOCATION

SCALE	AS SHOWN (@ A3 PRINT)
DATE	08 SEPT 2021
DRAWN	KB
FILENAME	-
VERSION	D

ORCHITOLGY
(PRIVATE) LIMITED
DRAWING NO. 1400

D-01 CONCEALED TIMBER DOOR WITH FLUTED PANEL	D-02 SOLID TIMBER DOOR	D-03 SOLID TIMBER DOOR	D-04 SOLID TIMBER DOOR	TSD-01 MANUAL SLIDING POCKET SOLID TIMBER DOOR
QUANTITY1	QUANTITY1	QUANTITY4	QUANTITY3	QUANTITY1
FRAMETIMBER IN PAINT FINISH	FRAMETIMBER IN PAINT FINISH	FRAMETIMBER IN PAINT FINISH	FRAMETIMBER IN PAINT FINISH	FRAME-
LEAFTO SPECIALIST'S DTL	LEAFTO SPECIALIST'S DTL	LEAFTO SPECIALIST'S DTL	LEAFTO SPECIALIST'S DTL	LEAF-
LOCATIONTO EQUIPMENT SERVICE ROOM @ PRO SHOP	LOCATIONDOOR TO ATTIC'S STOREROOM	LOCATIONHANDICAPPED TOILET, MERCHANDISE/PRO SHOP, SNOOKER EXIT DOOR, STOREROOM @ TOILET	LOCATIONACCESS TO M&E, STOREROOM @ POOL PLAYING AREA, STOREROOM @ SNOOKER PLAYING AREA	LOCATIONOFFICE AND MEDIA BOOTH
GLASS-	GLASS-	GLASS-	GLASS-	GLASS-
FINISHPAINT FINISH TO ARCHITECT'S SELECTION	FINISHPAINT FINISH TO ARCHITECT'S SELECTION	FINISHPAINT FINISH TO ARCHITECT'S SELECTION	FINISHPAINT FINISH TO ARCHITECT'S SELECTION	FINISHREFER TO DRAWING
REMARKSTIP ON HINGE	REMARKSLEVER HANDLE WITH LOCKSET TO SELECTION	REMARKSLEVER HANDLE WITH LOCKSET TO SELECTION	REMARKSLEVER HANDLE WITH LOCKSET TO SELECTION	REMARKS-
TSD-02 EXPOSED MANUAL SLIDING SOLID TIMBER DOOR	GD-01 DOUBLE SWING GLASS DOOR	GD-02 DOUBLE SWING GLASS DOOR	GD-03 SINGLE SWING GLASS DOOR	
QUANTITY1	QUANTITY1	QUANTITY1	QUANTITY1	
FRAME-	FRAMETIMBER IN PAINT FINISH	FRAMETIMBER IN PAINT FINISH	FRAMETIMBER IN PAINT FINISH	
LEAF-	LEAF-	LEAFTO SPECIALIST'S DTL	LEAFTO SPECIALIST'S DTL	
LOCATIONPANTRY	LOCATIONENTRANCE @ PHOTO BOOTH	LOCATIONENTRANCE @ MERCHANDISE/PRO SHOP	LOCATIONMERCHANDISE/PRO SHOP	
GLASS-	GLASS12MM THK TEMPERED LAMINATED CLEAR GLASS	GLASS12MM THK TEMPERED LAMINATED CLEAR GLASS	GLASS12MM THK TEMPERED LAMINATED CLEAR GLASS	
FINISHREFER TO DRAWING	FINISHREFER TO DRAWING	FINISHREFER TO DRAWING	FINISHREFER TO DRAWING	
REMARKS-	REMARKSLEVER HANDLE WITH LOCKSET TO SELECTION	REMARKSLEVER HANDLE WITH LOCKSET TO SELECTION	REMARKSLEVER HANDLE WITH LOCKSET TO SELECTION	

TO NOTE:
ALL EXISTING EXIT
DOOR TO BE IN
PAINTED FINISH

01
1401

DOOR SCHEDULE
1:60

GENERAL NOTES

ALL DIMENSIONS SHOWN ARE IN MILLIMETRES & SHALL BE VERIFIED ON SITE BY THE CONTRACTOR OR SUB-CONTRACTOR.

ALL DIMENSIONS SHOULD NOT BE SCALED FROM THE DRAWING UNLESS OTHERWISE INSTRUCTED. ANY DISCREPANCIES SHALL BE MADE KNOWN TO THE DESIGNER FOR DECISION PRIOR TO PROCEEDING OF THE WORK.

PROJECT TITLE

PROPOSED RENOVATION WORKS TO ROSSA

DRAWING TITLE

DOOR SCHEDULE

SCALE AS SHOWN (@ A3 PRINT)

DATE 01 SEPT 2021

DRAWN KB

FILENAME -

VERSION B

ORCHITOLGY
(PRIVATE) LIMITED

DRAWING NO. 1401