

SPATIAL EXPERIENCE

MAT3 T3b Construction Sets

HONG SI YU

P1740396

CONTENT PAGE

ID 001: SITE PLAN

ID 101: FURNITURE LAYOUT PLAN LEVEL 1

ID 102: FURNITURE LAYOUT PLAN LEVEL 2

ID 103: ROOF PLAN

ID 201: REFLECTED CEILING PLAN LEVEL 1

ID 202: REFLECTED CEILING PLAN LEVEL 2

ID 301: FLOOR FINISHES PLAN LEVEL 1

ID 302: FLOOR FINISHES PLAN LEVEL 2

ID 303: WALL FINISHES PLAN LEVEL 1

ID 304: WALL FINISHES PLAN LEVEL 2

ID 401: ELECTRICAL AND DATA PLAN LEVEL 1


ID 402: ELECTRICAL AND DATA PLAN LEVEL 2

ID 501: SECTION A-A

ID 502: SECTION B-B

ID 601: DETAIL 1

ID 602: DETAIL 2

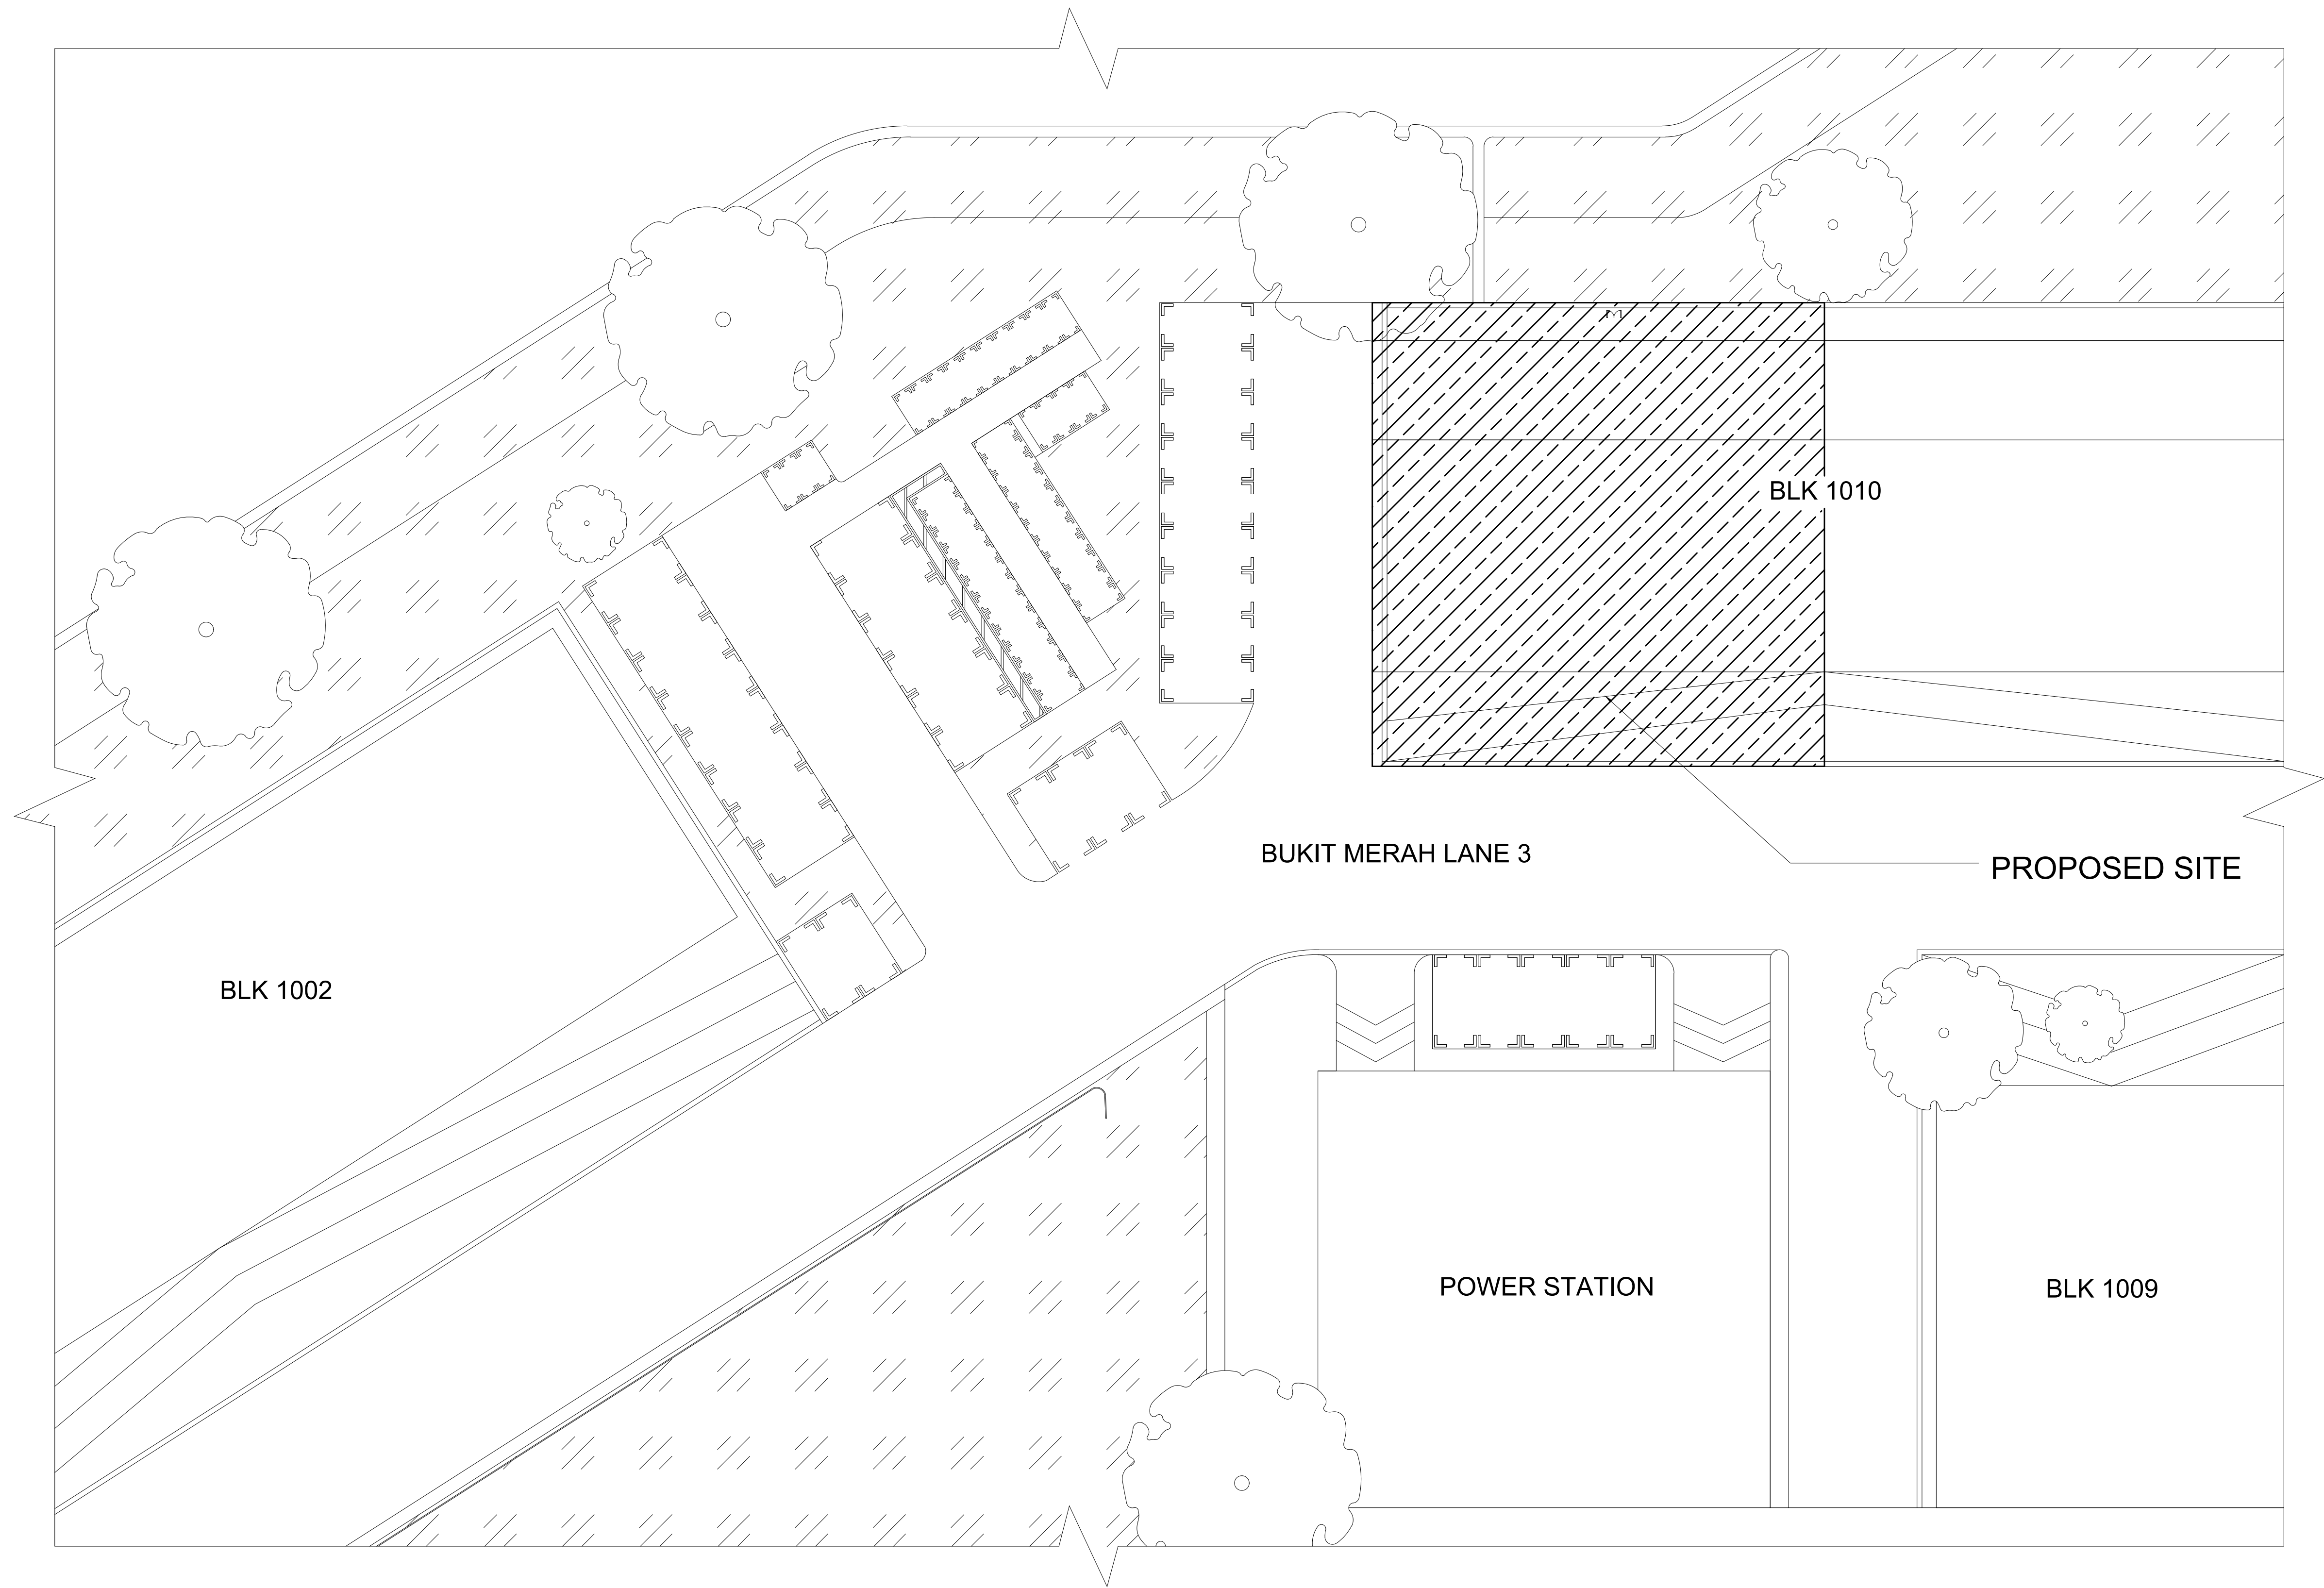

1

001

SITE PLAN

SCALE : 1 : 200



AUTHORITY ENDORSEMENT

OFFICIAL STAMP

Project Ref No: 2013-0001

Qualified Person [QP] Declaration

Rev.	Date	Remarks

SP

DESIGN
SCHOOL

Land Owner / Developer:

SP Design School

Author: Architect/Designer

Project Description:
Proposed Avery Dennison Automotive Studio at
1010 Bukit Merah Lane 3, #01-105
Alexandra Village Industrial Estate
Singapore 159724

Drawing Title:

SITE PLAN

Project No.: 2020-0001		Drawing No.: ID-001	
Project Code: 2020-0001		Rev.: 	
Scale: 1 : 200	Date: 31/01/20	Drawn: Hong Si Yu	Checked: MAT3 Tutor

AUTHORITY ENDORSEMENT

OFFICIAL STAMP

Project Ref No: 2013-0001

Qualified Person [QP] Declaration

Rev.	Date	Remarks

SP DESIGN SCHOOL

Land Owner / Developer:

SP Design School

Author: Architect/Designer


Project Description:


Proposed Avery Dennison Automotive Studio at
1010 Bukit Merah Lane 3, #01-105
Alexandra Village Industrial Estate
Singapore 159724

Drawing Title:

**FURNITURE
LAYOUT PLAN -
LEVEL 1**

Project No.: 2020-0001	Drawing No.: ID-101
Project Code: 2020-0001	Rev.:
Scale: 1 : 50	Date: 31/01/20
Drawn: Hong Si Yu	Checked: MAT3 Tutor

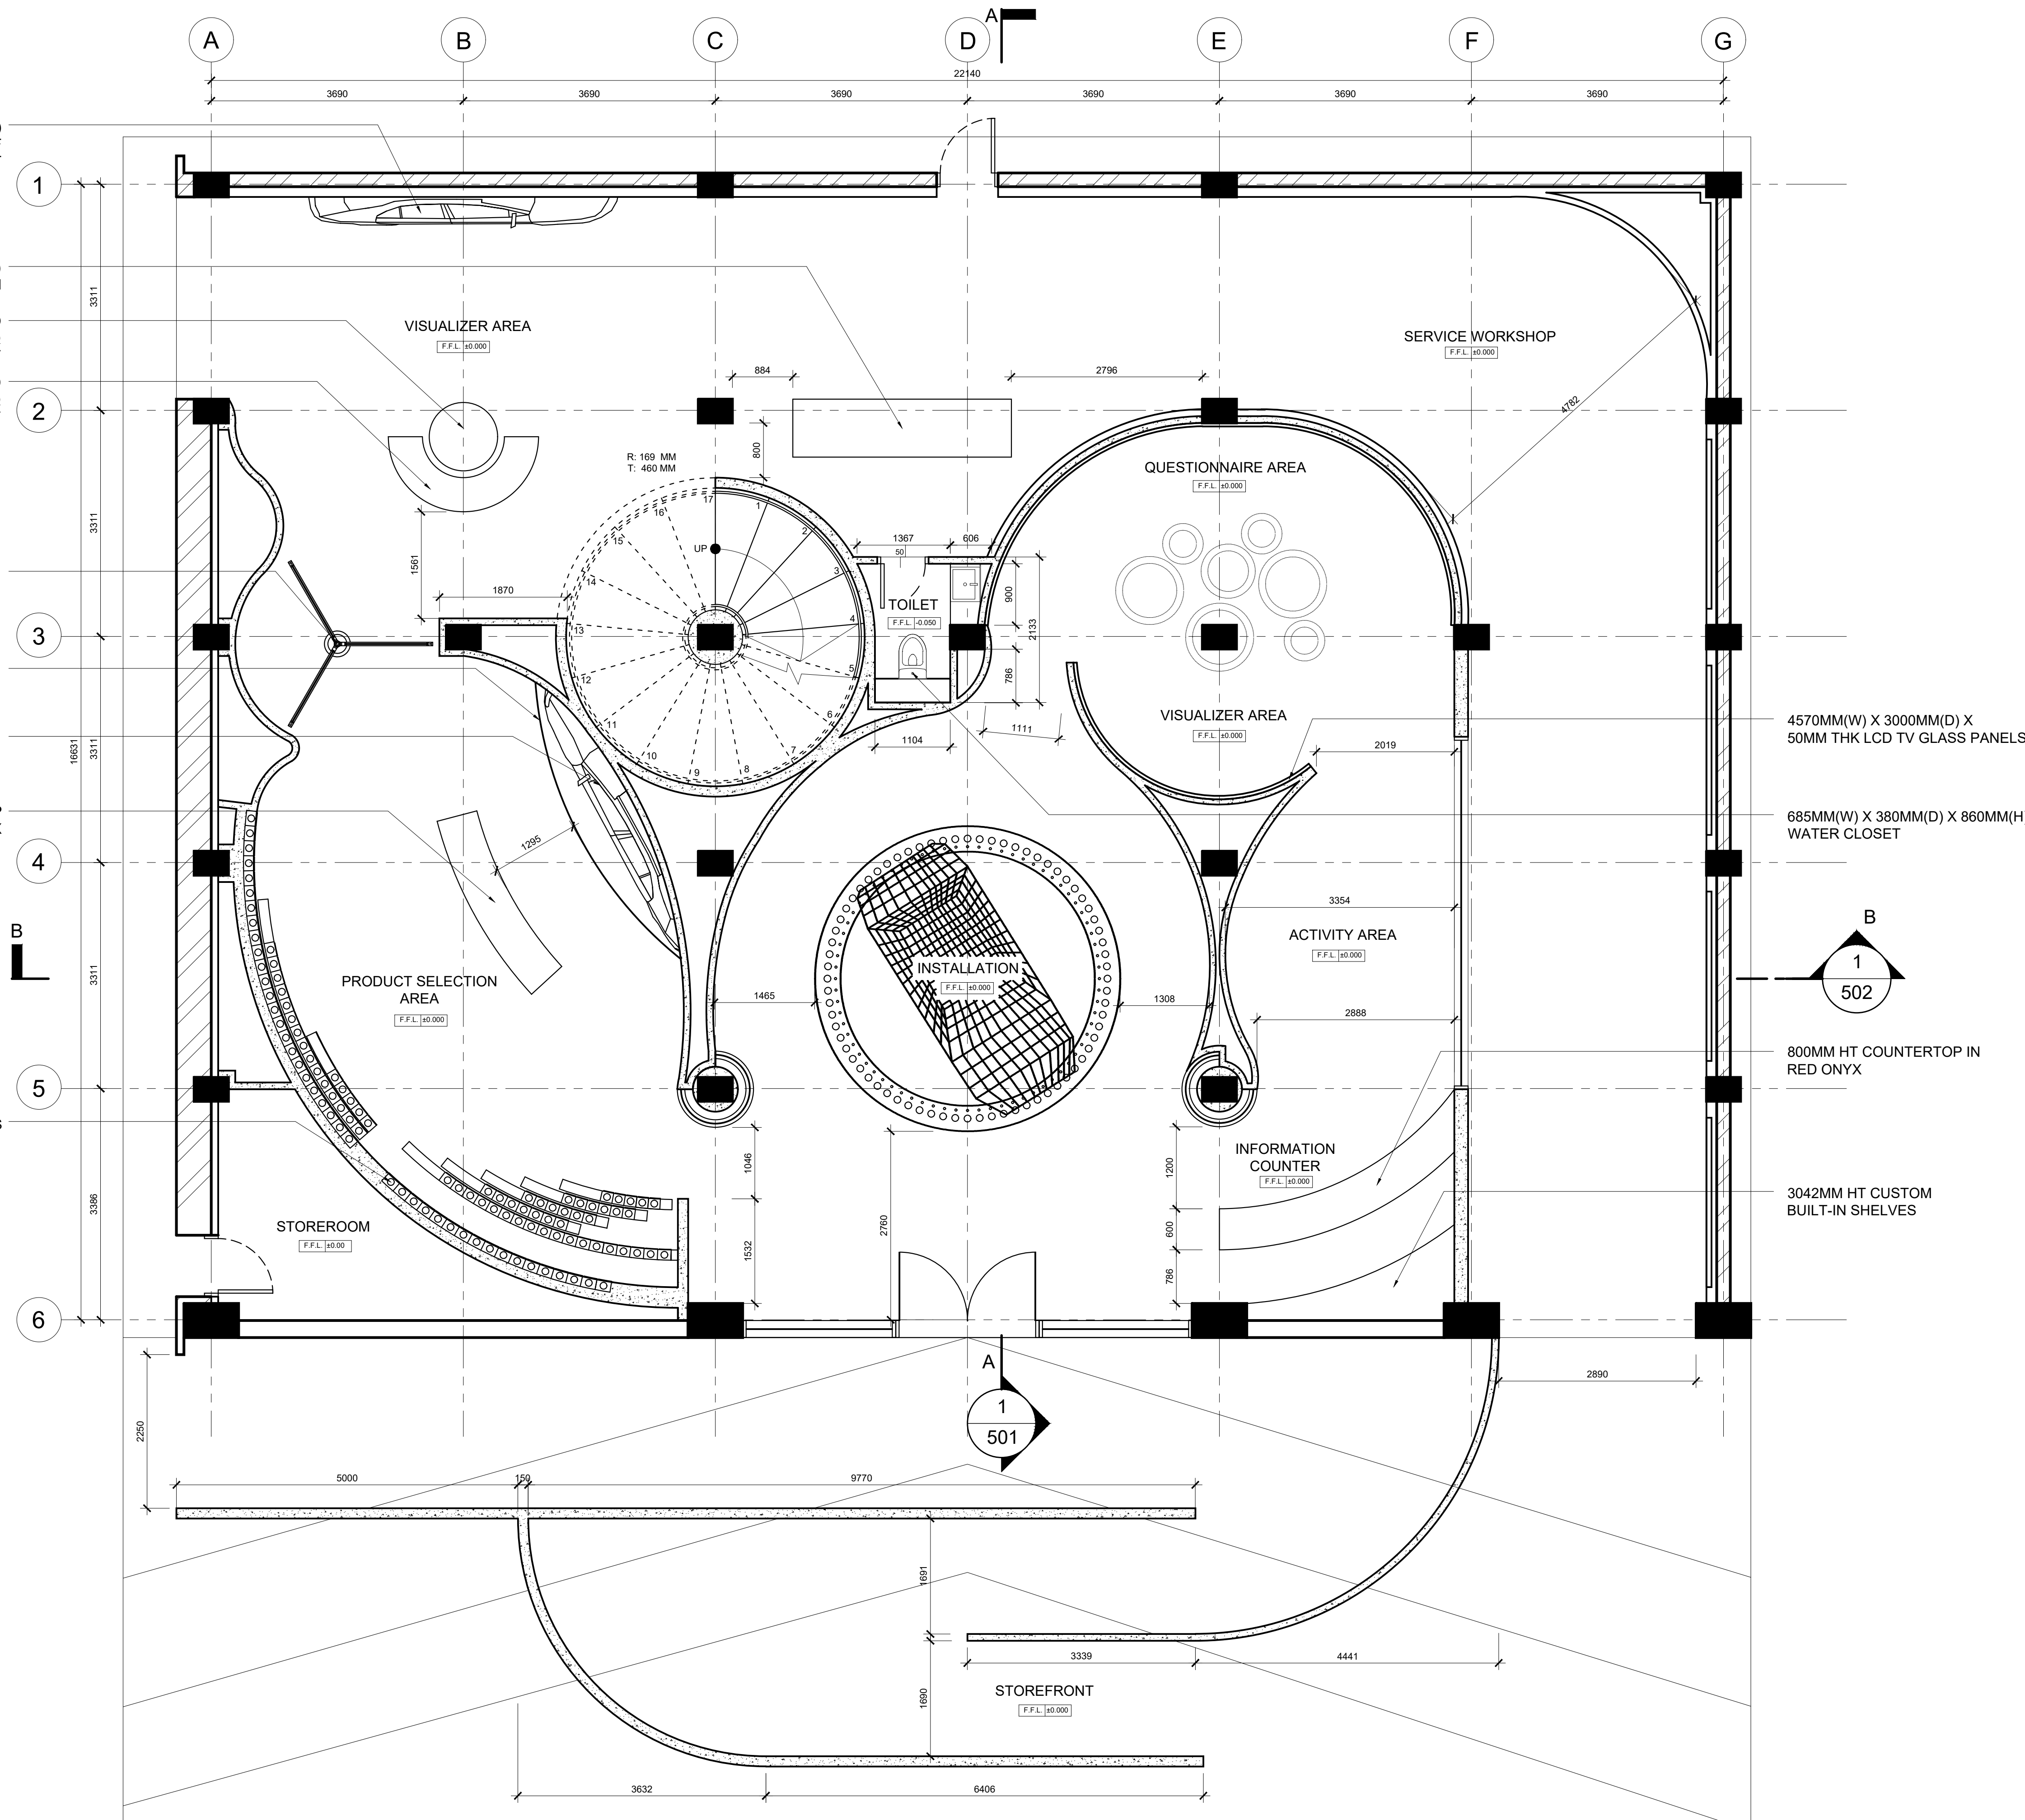

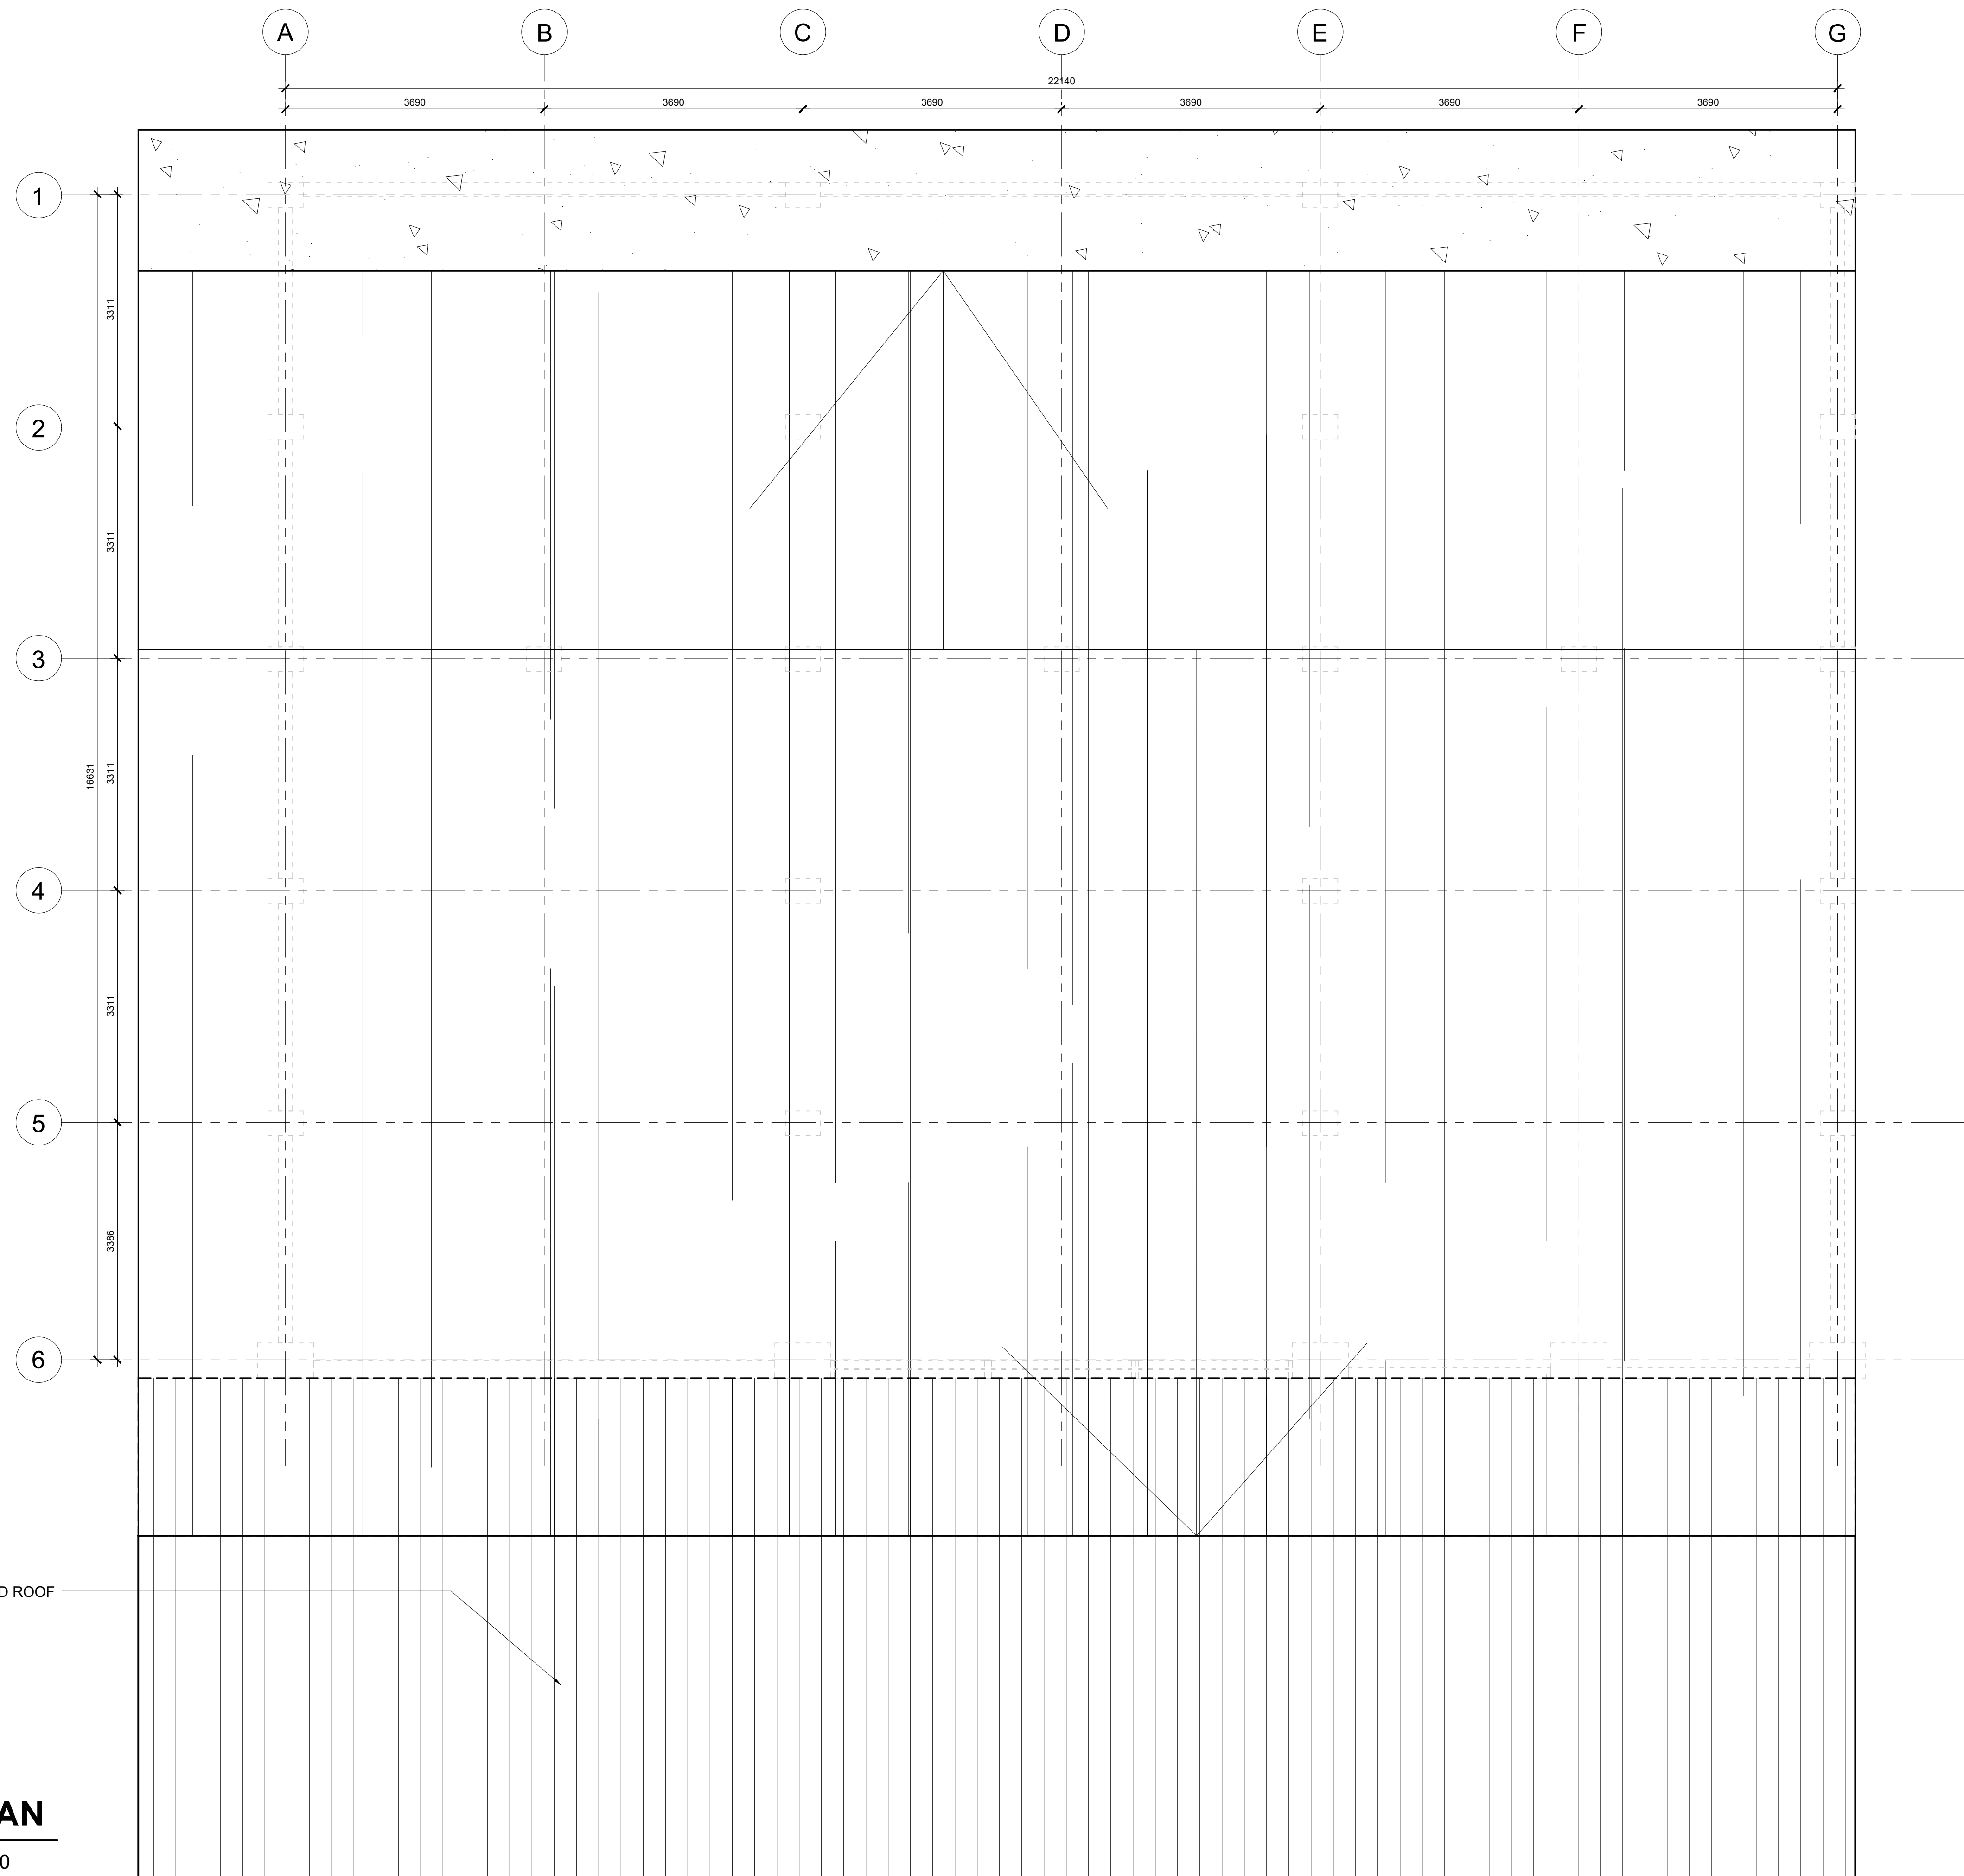

1
103

ROOF PLAN

SCALE : 1 : 50

_____sheet of _____

AUTHORITY ENDORSEMENT

OFFICIAL STAMP

Project Ref No: 2013-0001

Qualified Person [QP] Declaration

Rev.	Date	Remarks

SP

DESIGN
SCHOOL

Land Owner / Developer:

SP Design School


Author: Architect/Designer

Project Description:
Proposed Avery Dennison Automotive Studio at
1010 Bukit Merah Lane 3, #01-105
Alexandra Village Industrial Estate
Singapore 159724

Drawing Title:

ROOF PLAN

Project No.: 2020-0001		Drawing No.: ID-103					
Project Code: 2020-0001		Rev.: <table><tr><td></td><td></td><td></td><td></td></tr></table>					
Scale: 1 : 50	Date: 31/01/20	Drawn: Hong Si Yu	Checked: MAT3 Tutor				

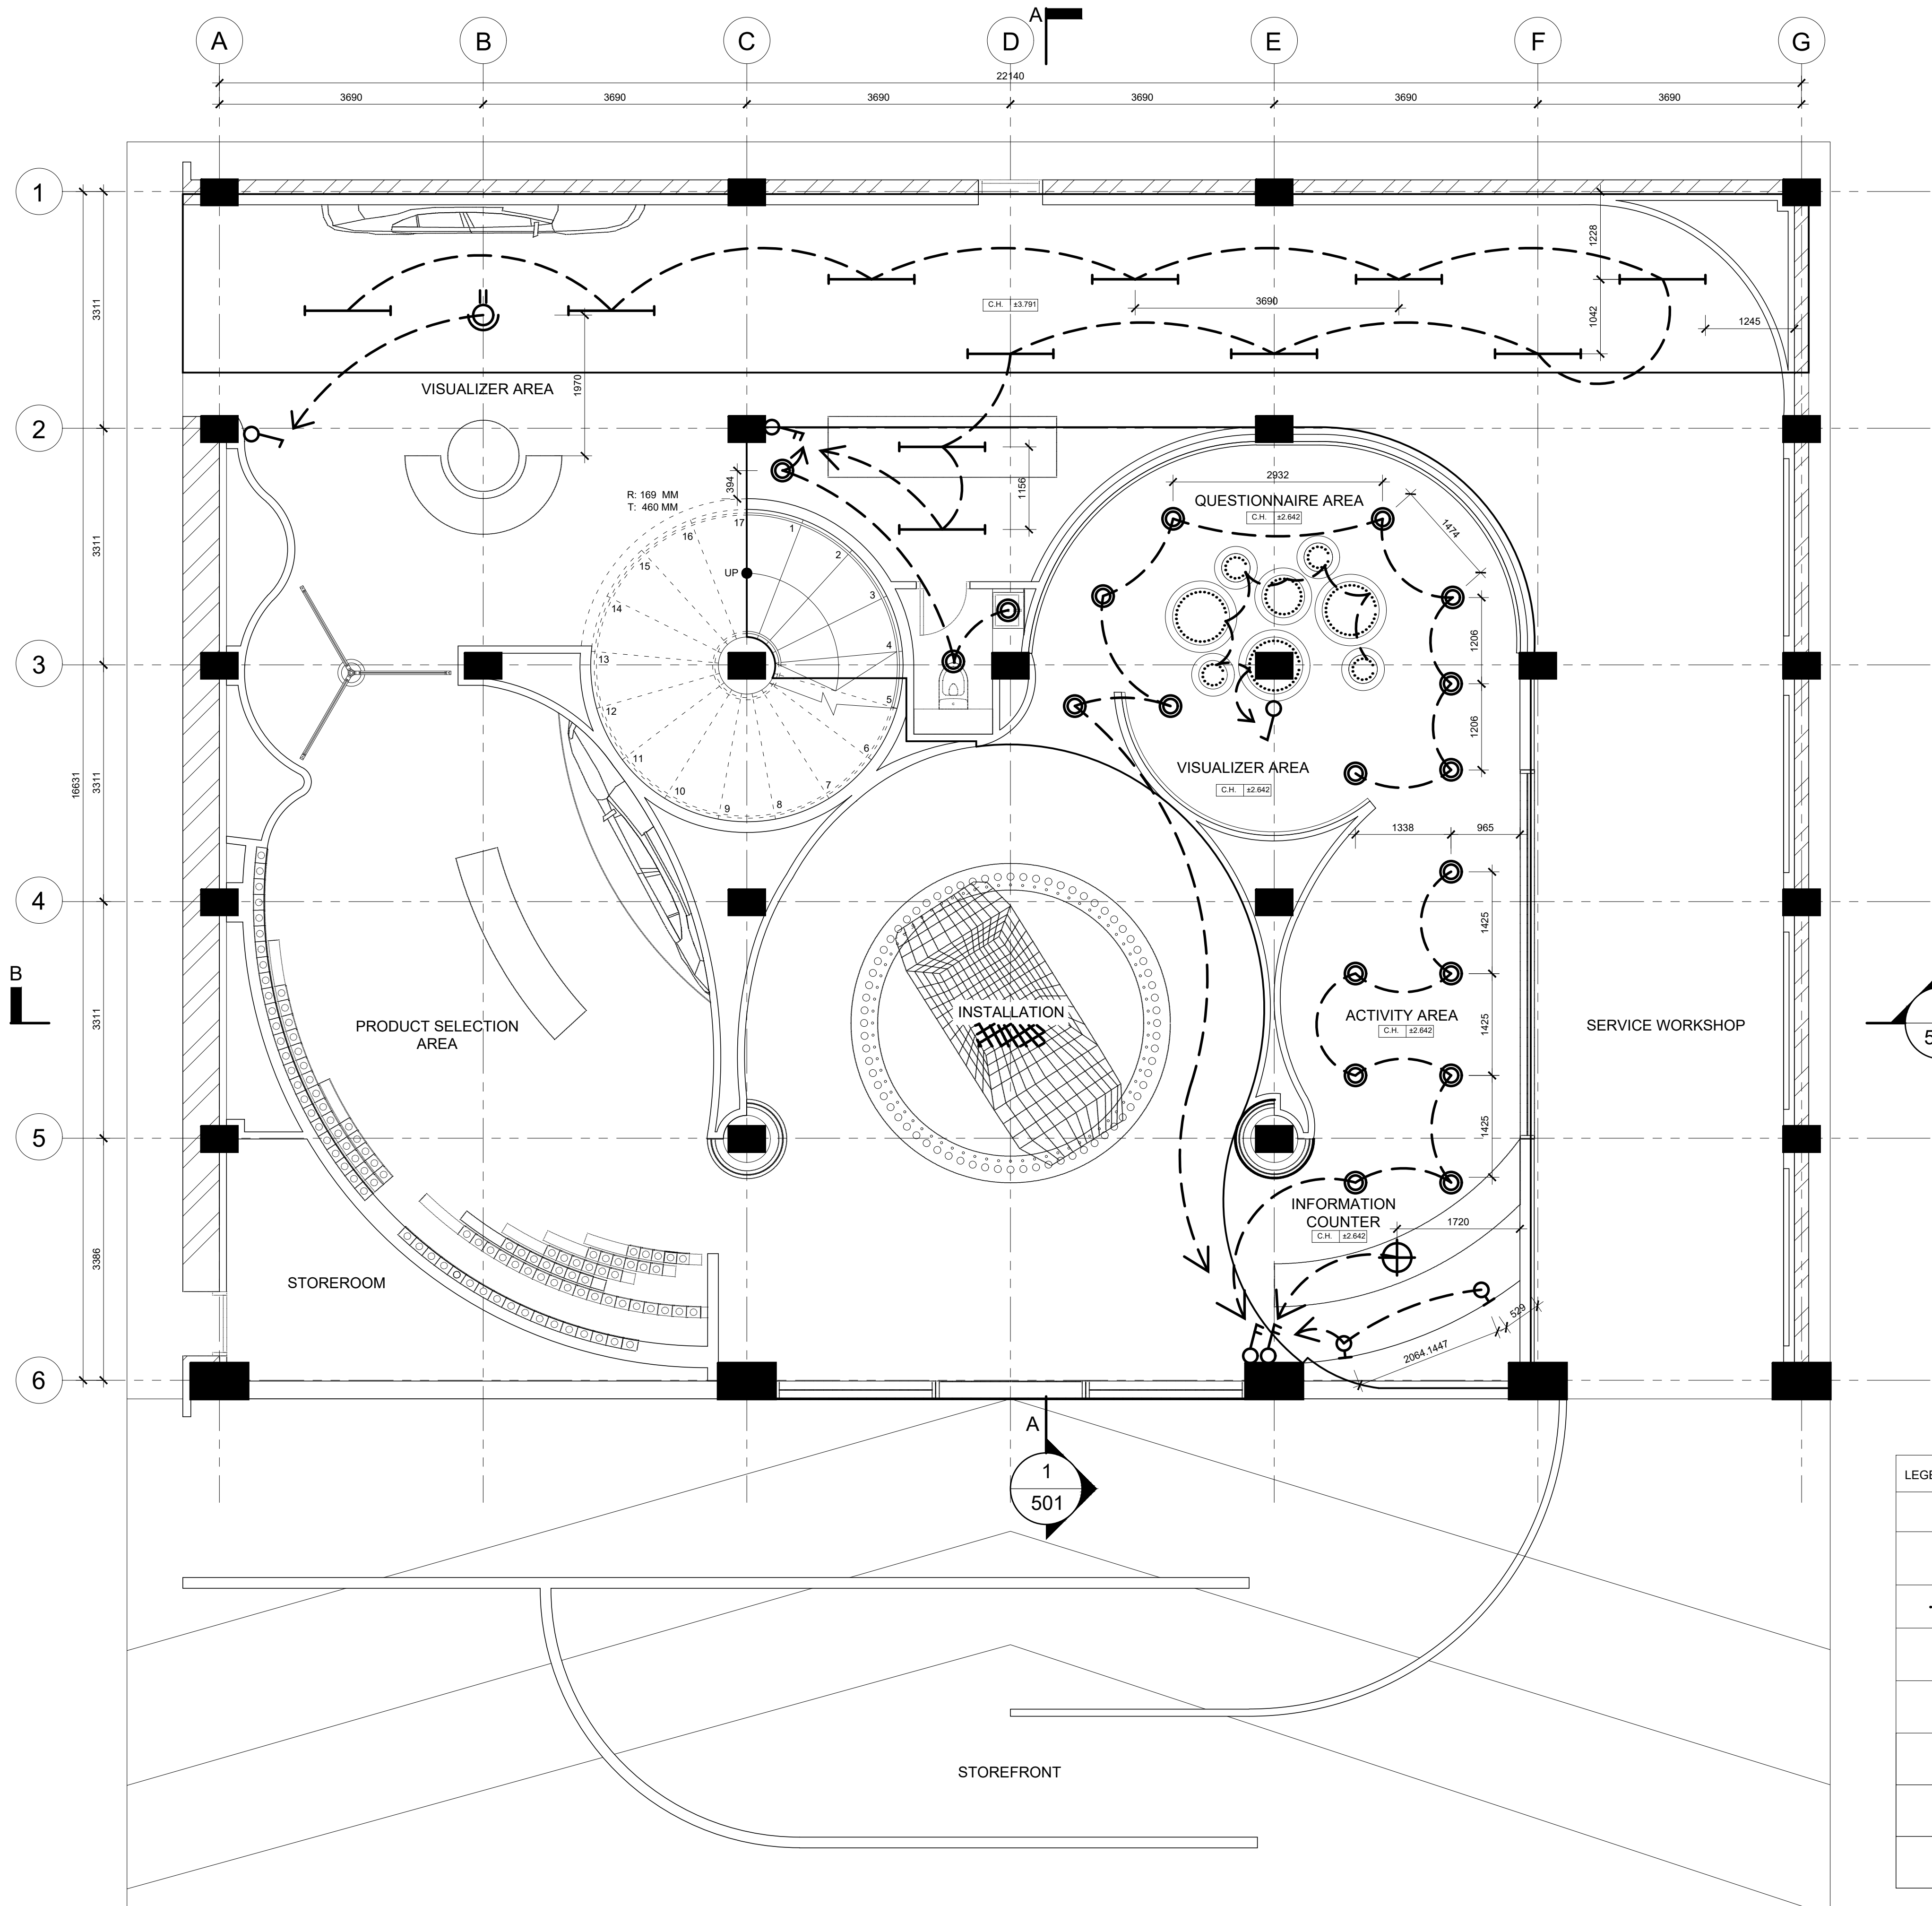

RCP - LEVEL 1
SCALE : 1 : 50

LEGEND	
	L01 RECESSED LIGHT
	L02 SPOTLIGHT (FLOOD)
	L04 LED STRIP
	L05 PENDANT LIGHT
	L06 FLUORESCENT FITTING (20 W - BATTEN)
	L07 WALL MOUNTED LIGHT @ 2000MM HEIGHT
	ONE GANG DOUBLE - POLE LIGHTING SWITCH @ 1200MM HEIGHT FROM LEVEL 1 FFL
	ONE GANG SINGLE-POLE LIGHTING SWITCH @ 1200MM HEIGHT FROM LEVEL 1 FFL

_____sheet of _____

AUTHORITY ENDORSEMENT

OFFICIAL STAMP

Project Ref No: 2013-0001

Qualified Person [QP] Declaration

Rev.	Date	Remarks

SP DESIGN SCHOOL

Land Owner / Developer:

SP Design School

Author: Architect/Designer

Project Description:

Proposed Avery Dennison Automotive Studio at
1010 Bukit Merah Lane 3, #01-105
Alexandra Village Industrial Estate
Singapore 159724

Drawing Title:

**REFLECTED
CEILING PLAN -
LEVEL 1**


Project No.:
2020-0001

Drawing No.:
ID-201

Project Code:
2020-0001

Rev.:

Scale: 1 : 50	Date: 31/01/20	Drawn: Hong Si Yu	Checked: MAT3 Tutor
------------------	-------------------	----------------------	------------------------

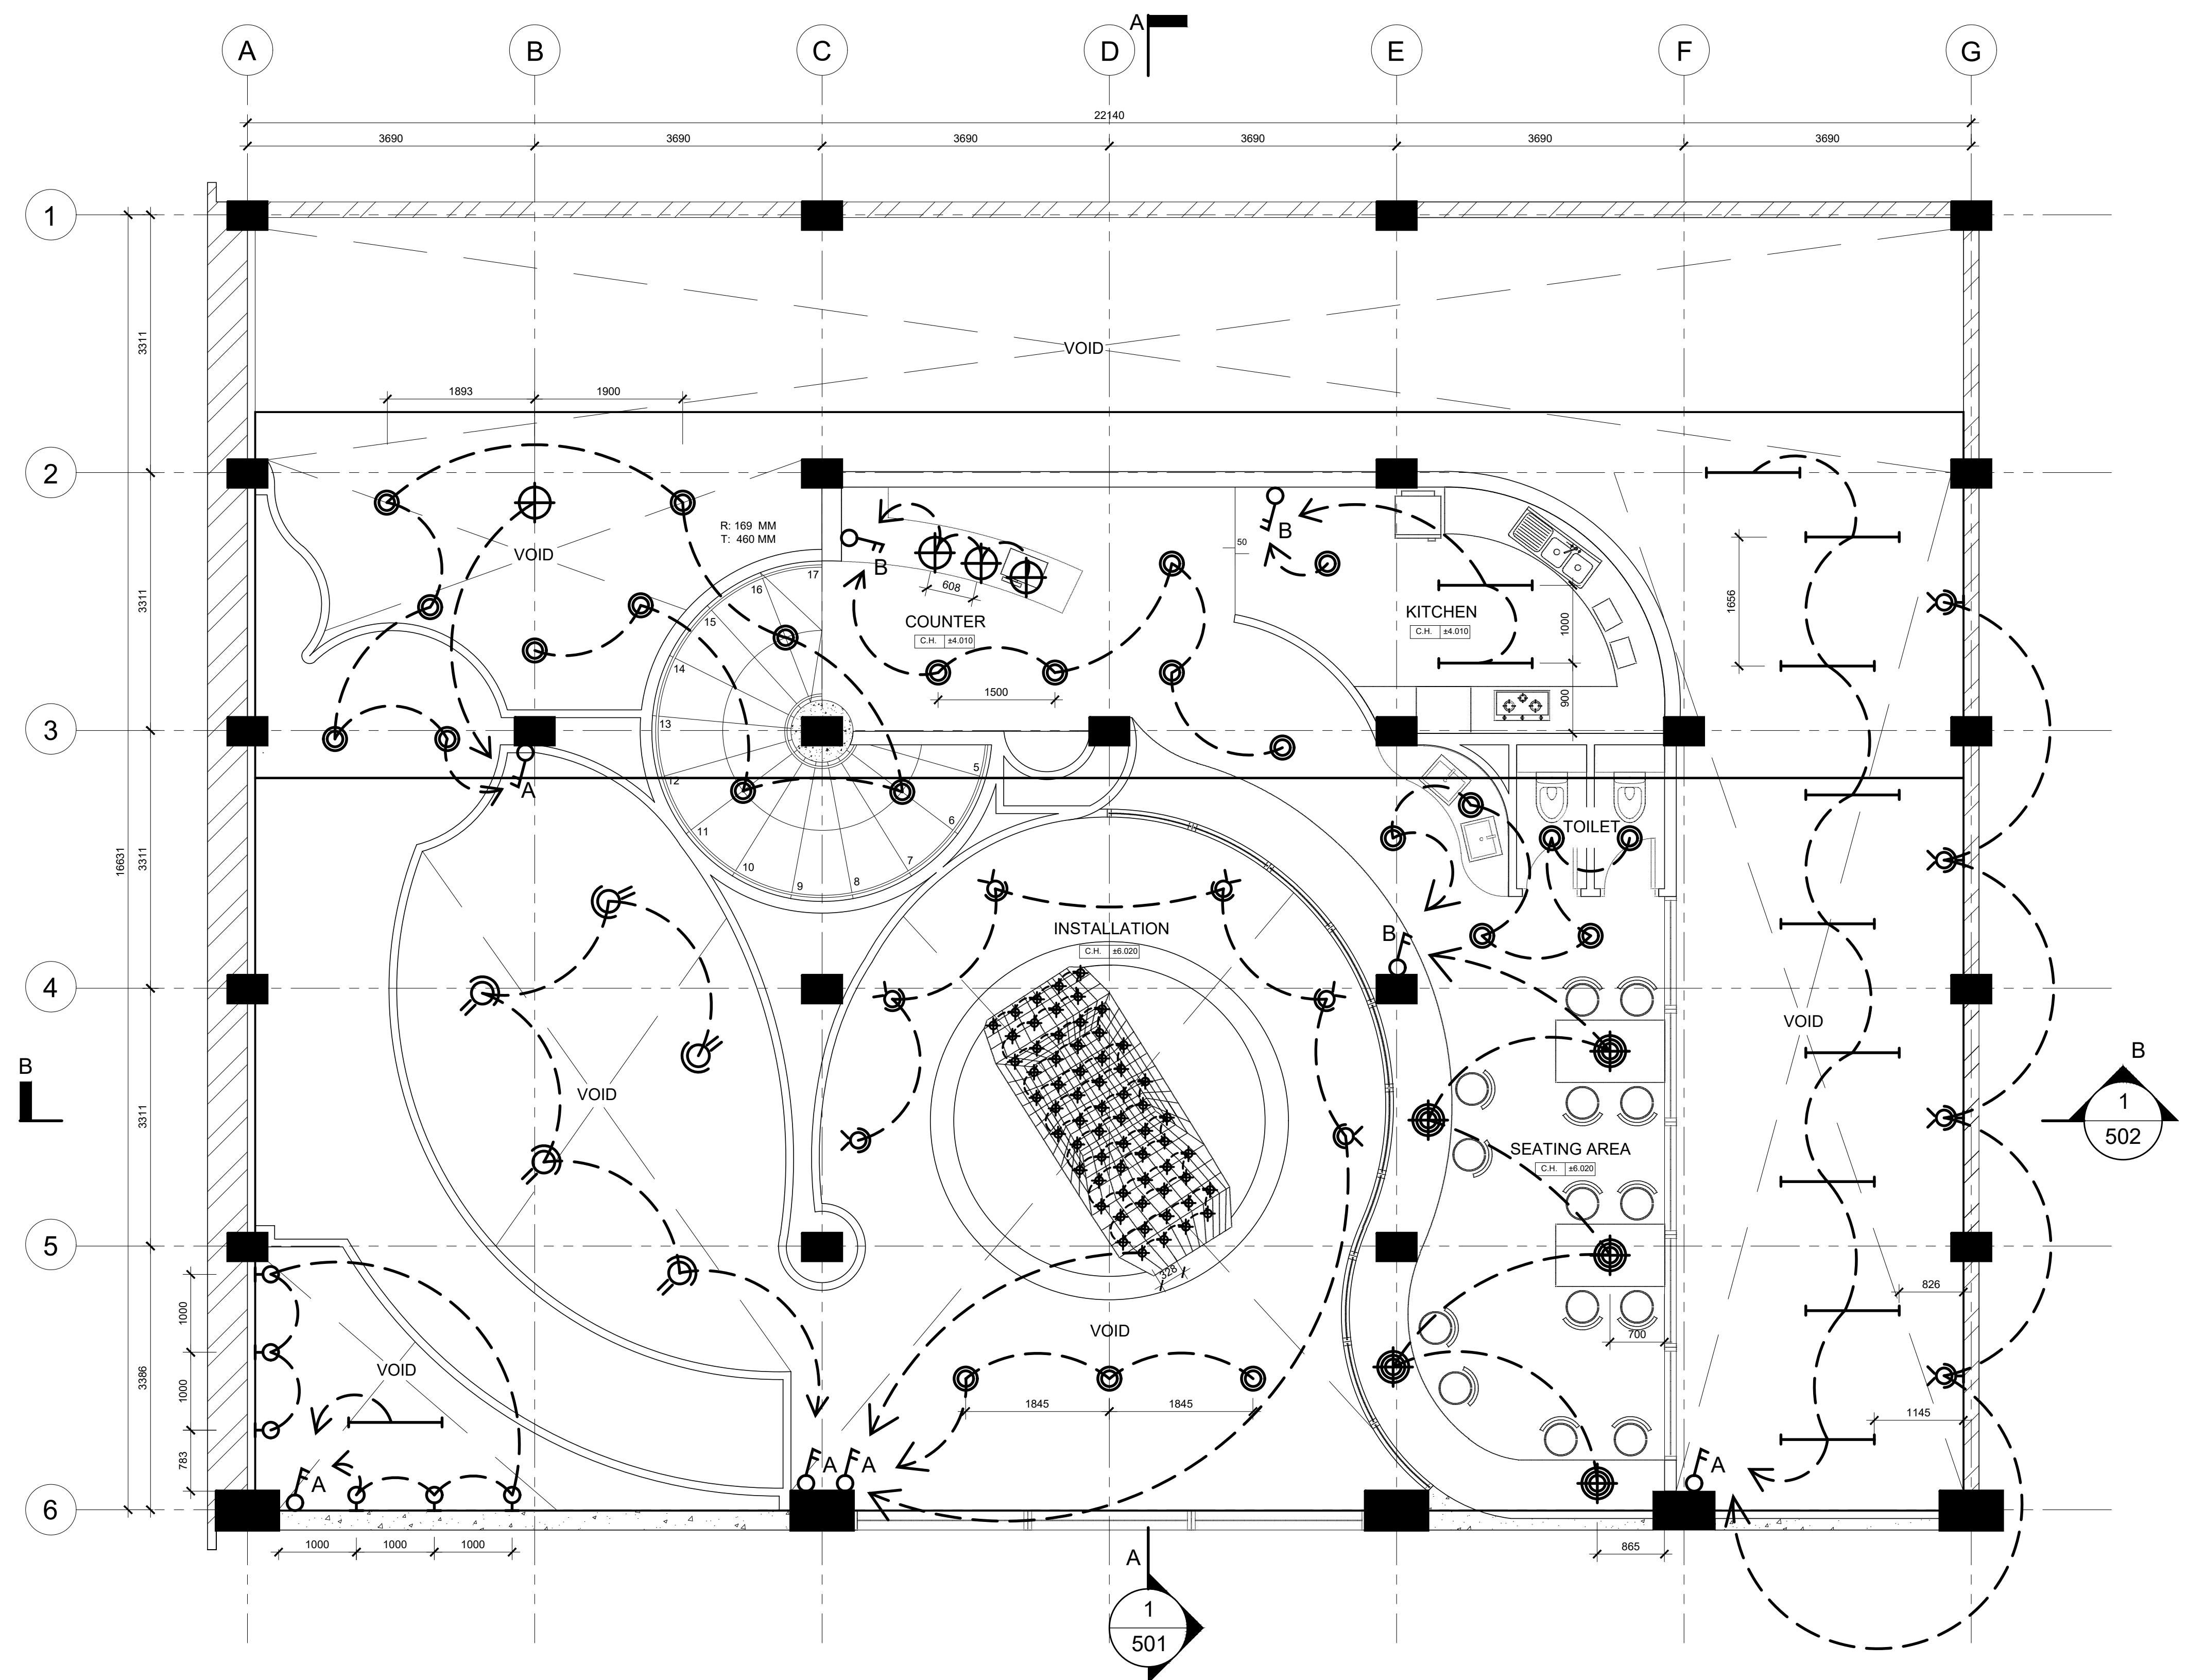

1
202

RCP - LEVEL 2

SCALE : 1 : 50

_____ sheet of _____

AUTHORITY ENDORSEMENT

OFFICIAL STAMP

Project Ref No: 2013-0001

Qualified Person [QP] Declaration

Rev.	Date	Remarks

SP DESIGN SCHOOL

Land Owner / Developer:

SP Design School

Author: Architect/Designer


Project Description:

Proposed Avery Dennison Automotive Studio at
1010 Bukit Merah Lane 3, #01-105
Alexandra Village Industrial Estate
Singapore 159724

Drawing Title:

**REFLECTED
CEILING PLAN -
LEVEL 2**

Project No.: 2020-0001	Drawing No.: ID-202
Project Code: 2020-0001	Rev.:
Scale: 1 : 50	Date: 31/01/20
Drawn: Hong Si Yu	Checked: MAT3 Tutor

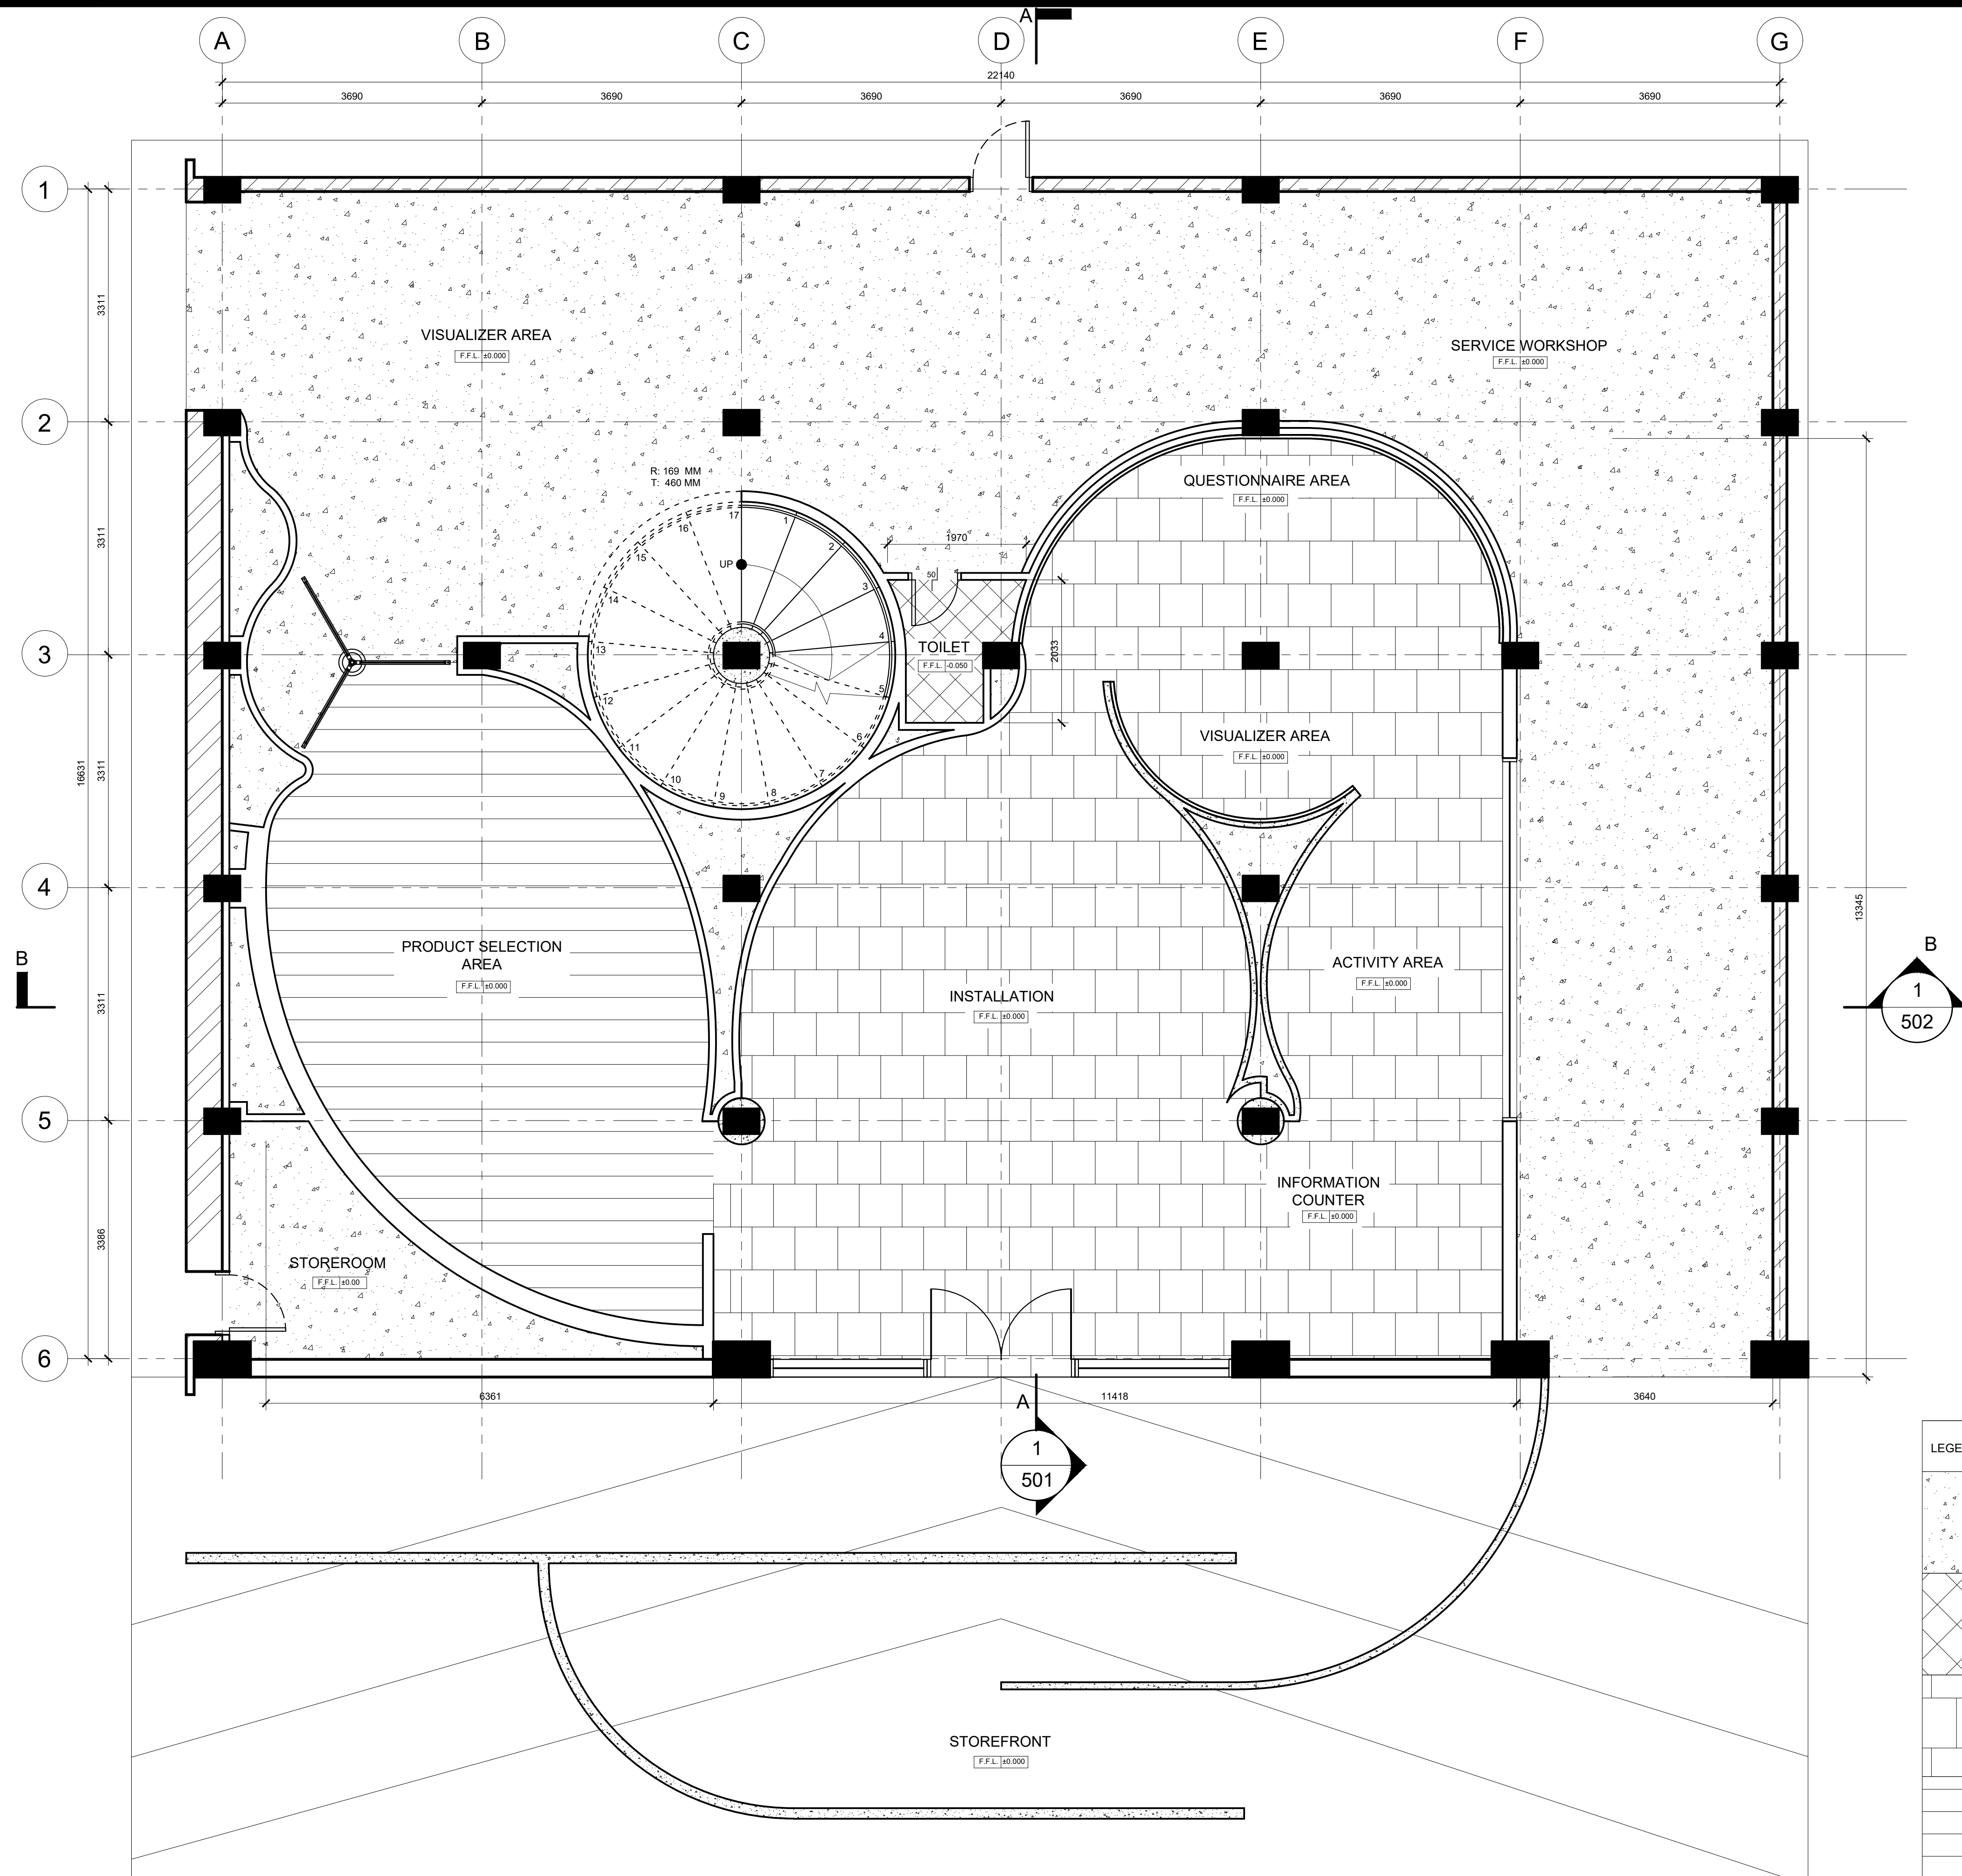

1
301

FLOOR FINISHES PLAN - LEVEL 1

SCALE : 1 : 50

LEGEND	
	M02 HIGH STRENGTH CONCRETE WITH EPOXY FINISH
	M03 600MM(W) X 600MM(D) X 20MM THK HAFARY ST6651CN GLAZED PORCELAIN TILE
	M04 1000MM(W) X 1000MM(D) X 20MM THK POLYBUILDING GRIGIO CARNICO MARBLE
	M06 1220MM(W) X 228MM(D) X 5MM THK FLOORRICH H1053 CORTINA OAK WHITE VINYL TILE

sheet of _____

AUTHORITY ENDORSEMENT

OFFICIAL STAMP

Project Ref No: 2013-0001

Qualified Person [QP] Declaration

Rev.	Date	Remarks

SP DESIGN SCHOOL

Land Owner / Developer:

SP Design School

Author: Architect/Designer

Project Description:

Proposed Avery Dennison Automotive Studio at
1010 Bukit Merah Lane 3, #01-105
Alexandra Village Industrial Estate
Singapore 159724

Drawing Title:

FLOOR FINISHES PLAN - LEVEL 1

Project No.:
2020-0001

Project Code:
2020-0001


Scale:
1 : 50

Date:
31/01/20

Drawing No.:
ID-301

Rev.:

Drawn: Hong Si Yu
Checked: MAT3 Tutor

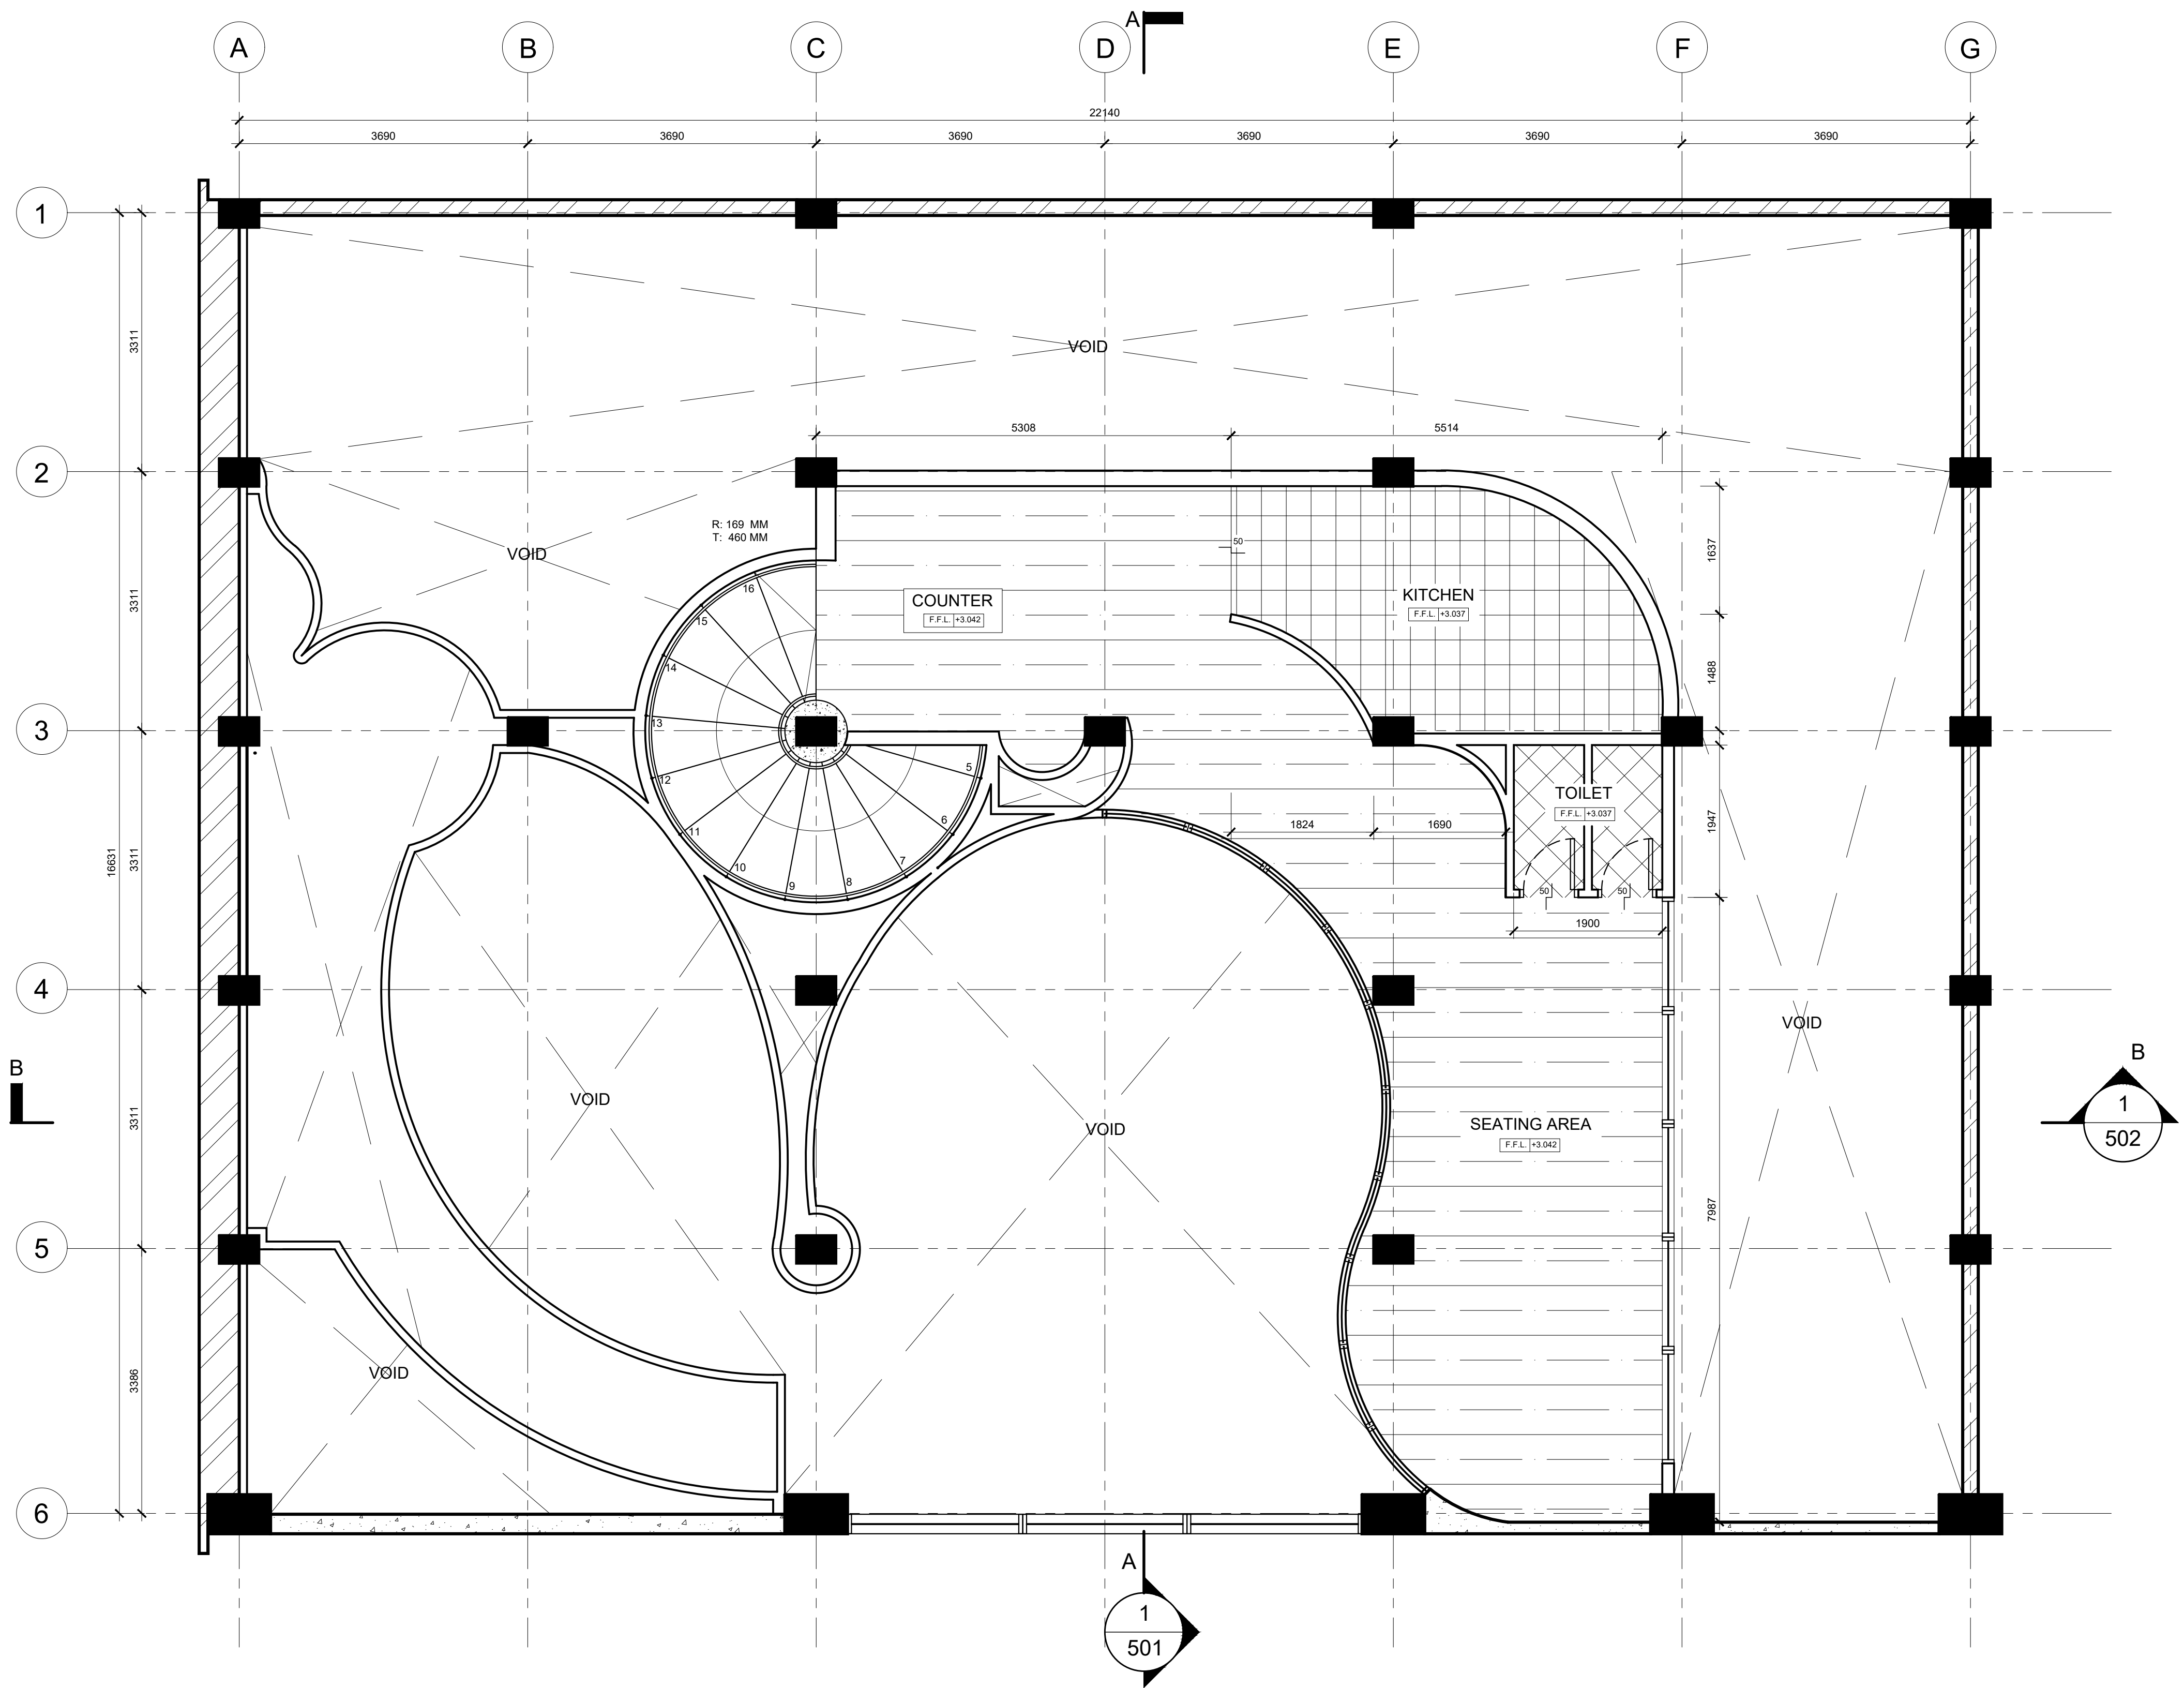

1
302

FLOOR FINISHES PLAN - LEVEL 2

SCALE : 1 : 50

LEGEND	
	M01 187MM(W) X 1251MM(D) X 4.5MM THK HAFARY CLICKPC0016V TAUPE MANSION VINYL TILE
	M03 600MM(W) X 600MM(D) X 20MM THK HAFARY ST6651CN GLAZED PORCELAIN TILE
	M05 600MM(W) X 600MM(D) X 20MM THK HAFARY ST6651CN GLAZED PORCELAIN TILE

_____ sheet of _____

AUTHORITY ENDORSEMENT

OFFICIAL STAMP

Project Ref No: 2013-0001

Qualified Person [QP] Declaration

Rev.	Date	Remarks

SP DESIGN SCHOOL

Land Owner / Developer:

SP Design School

Author: Architect/Designer

Project Description:

Proposed Avery Dennison Automotive Studio at
1010 Bukit Merah Lane 3, #01-105
Alexandra Village Industrial Estate
Singapore 159724

Drawing Title:

FLOOR FINISHES PLAN - LEVEL 2

Project No.:
2020-0001

Drawing No.:
ID-302

Project Code:
2020-0001

Rev.:

Scale:	Date:	Drawn:	Checked:
1 : 50	31/01/20	Hong Si Yu	MAT3 Tutor

AUTHORITY ENDORSEMENT

OFFICIAL STAMP

Project Ref No: 2013-0001

Qualified Person [QP] Declaration

Rev.	Date	Remarks

SP DESIGN SCHOOL

Land Owner / Developer:

SP Design School

Author: Architect/Designer


Project Description:


Proposed Avery Dennison Automotive Studio at
1010 Bukit Merah Lane 3, #01-105
Alexandra Village Industrial Estate
Singapore 159724

Drawing Title:

**WALL FINISHES
PLAN - LEVEL 1**

Project No.: 2020-0001		Drawing No.: ID-303		Rev.: 			
Project Code: 2020-0001							
Scale: 1 : 50	Date: 31/01/20	Drawn: Hong Si Yu	Checked: MAT3 Tutor				

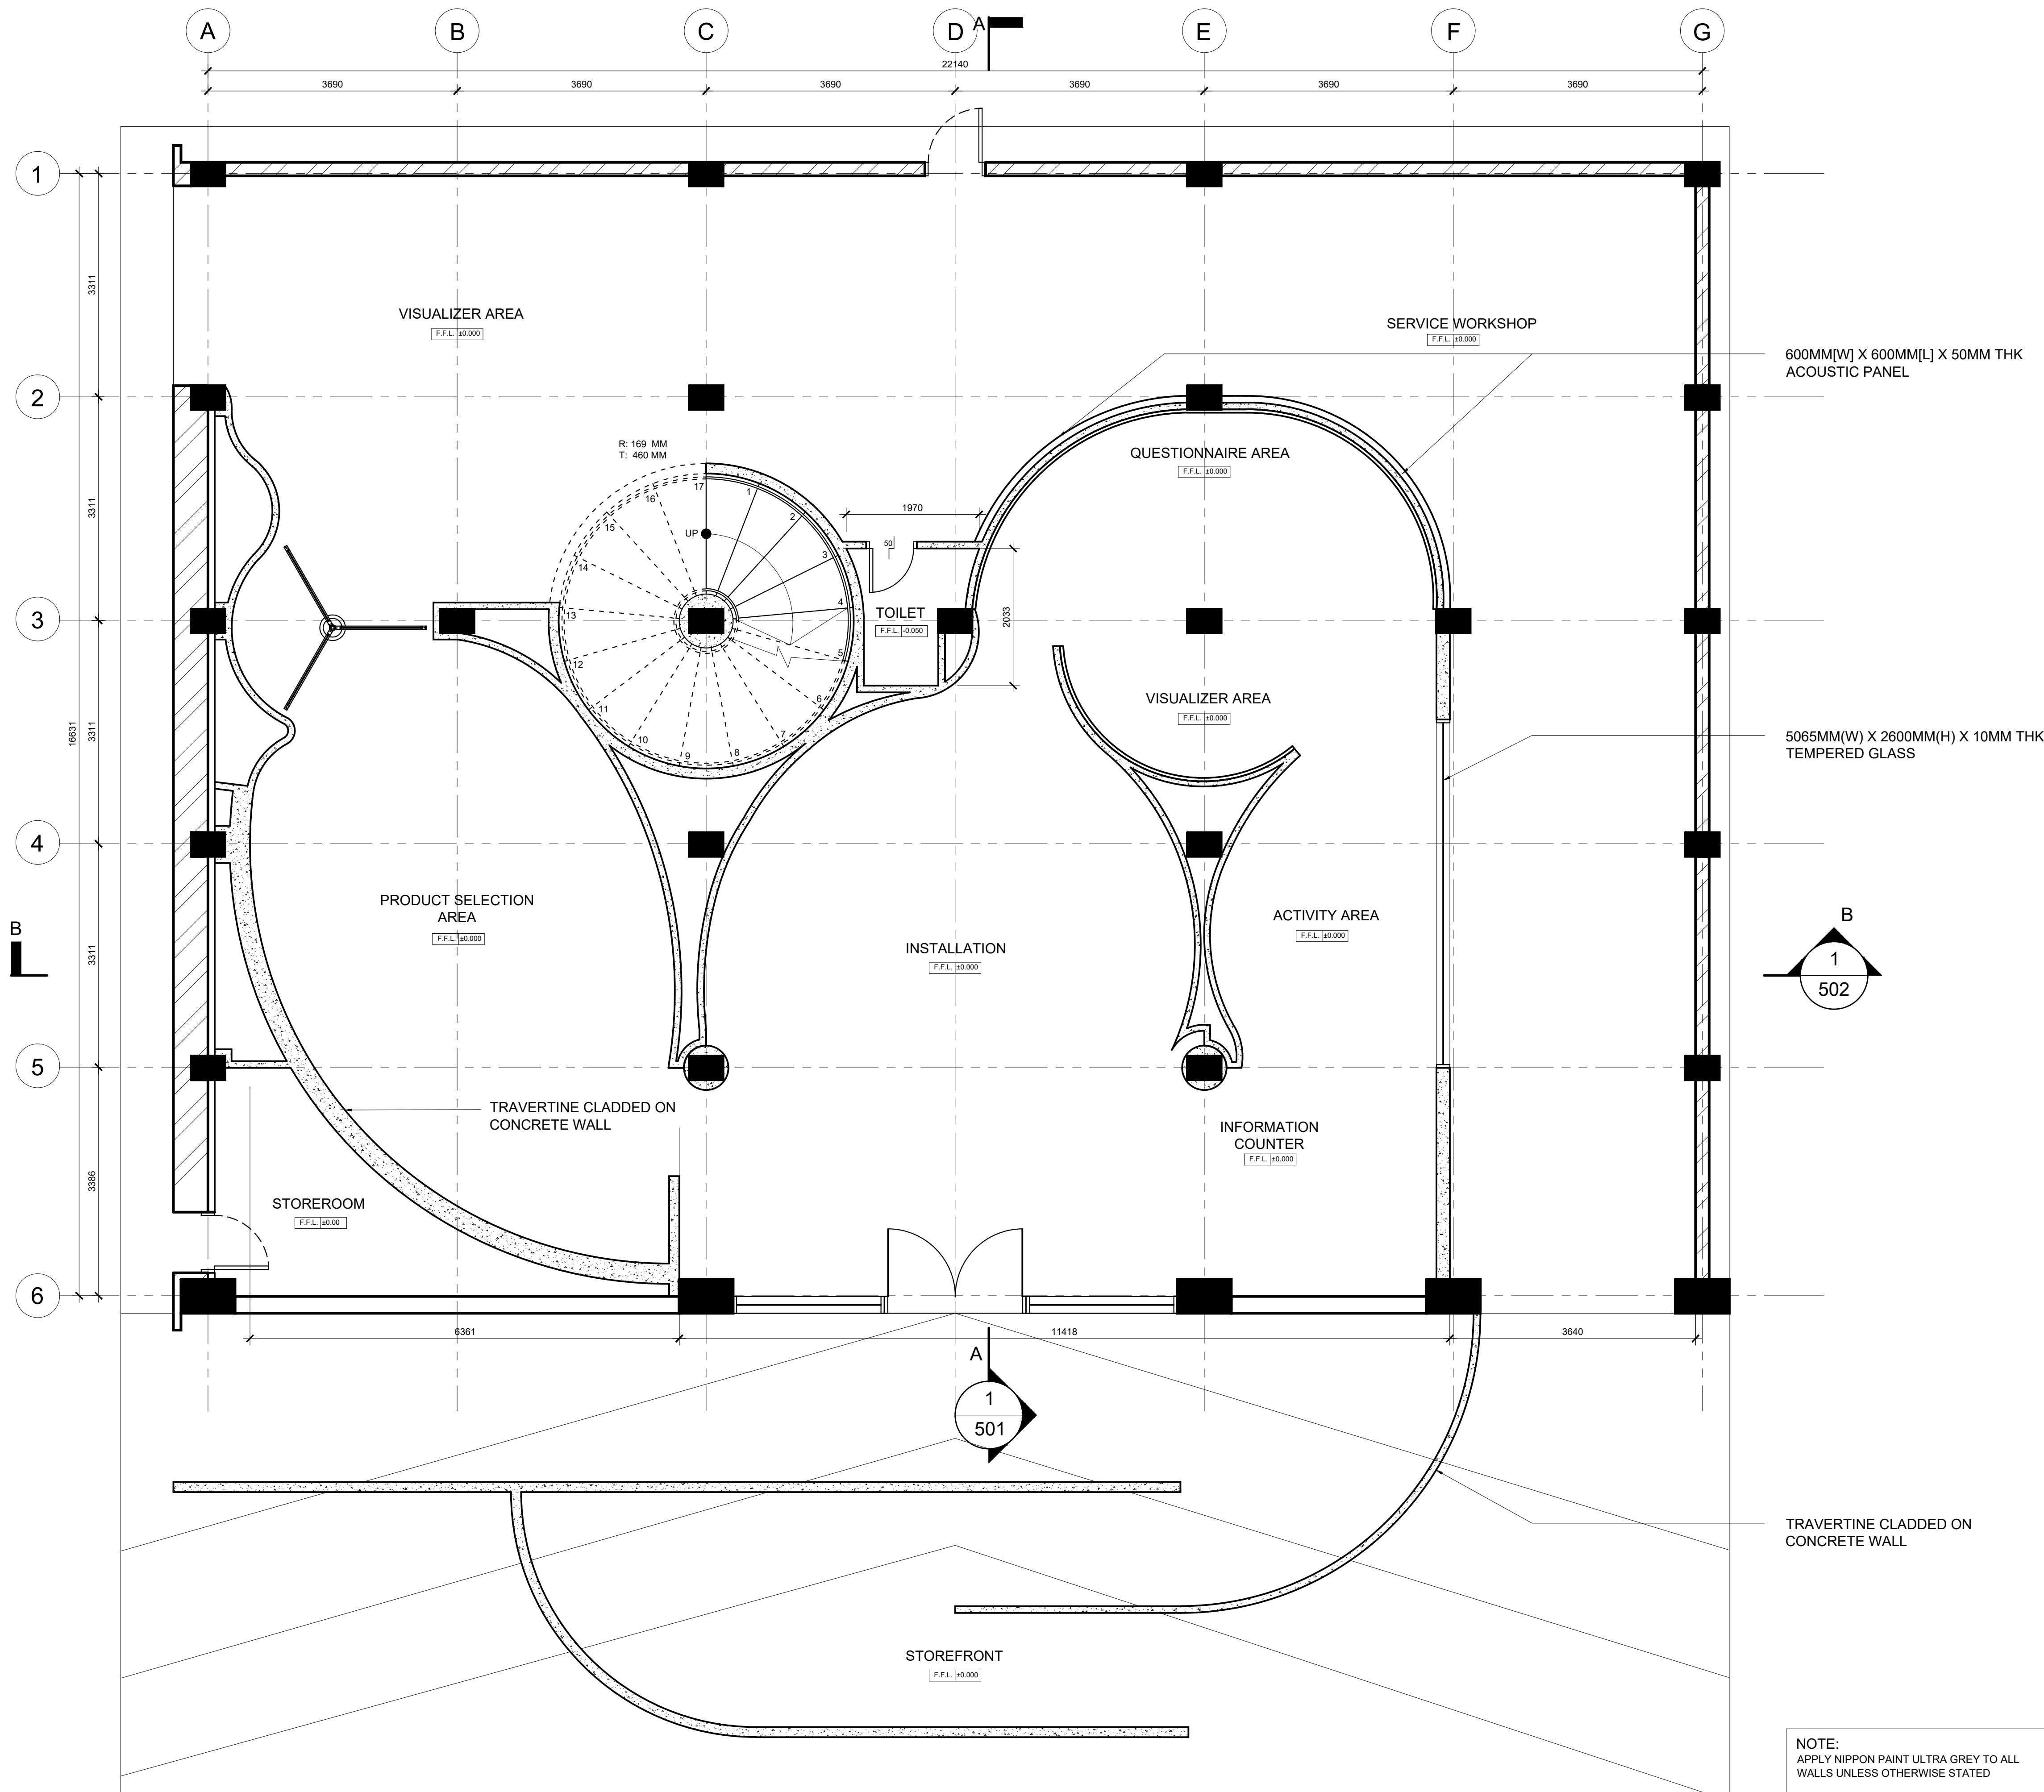

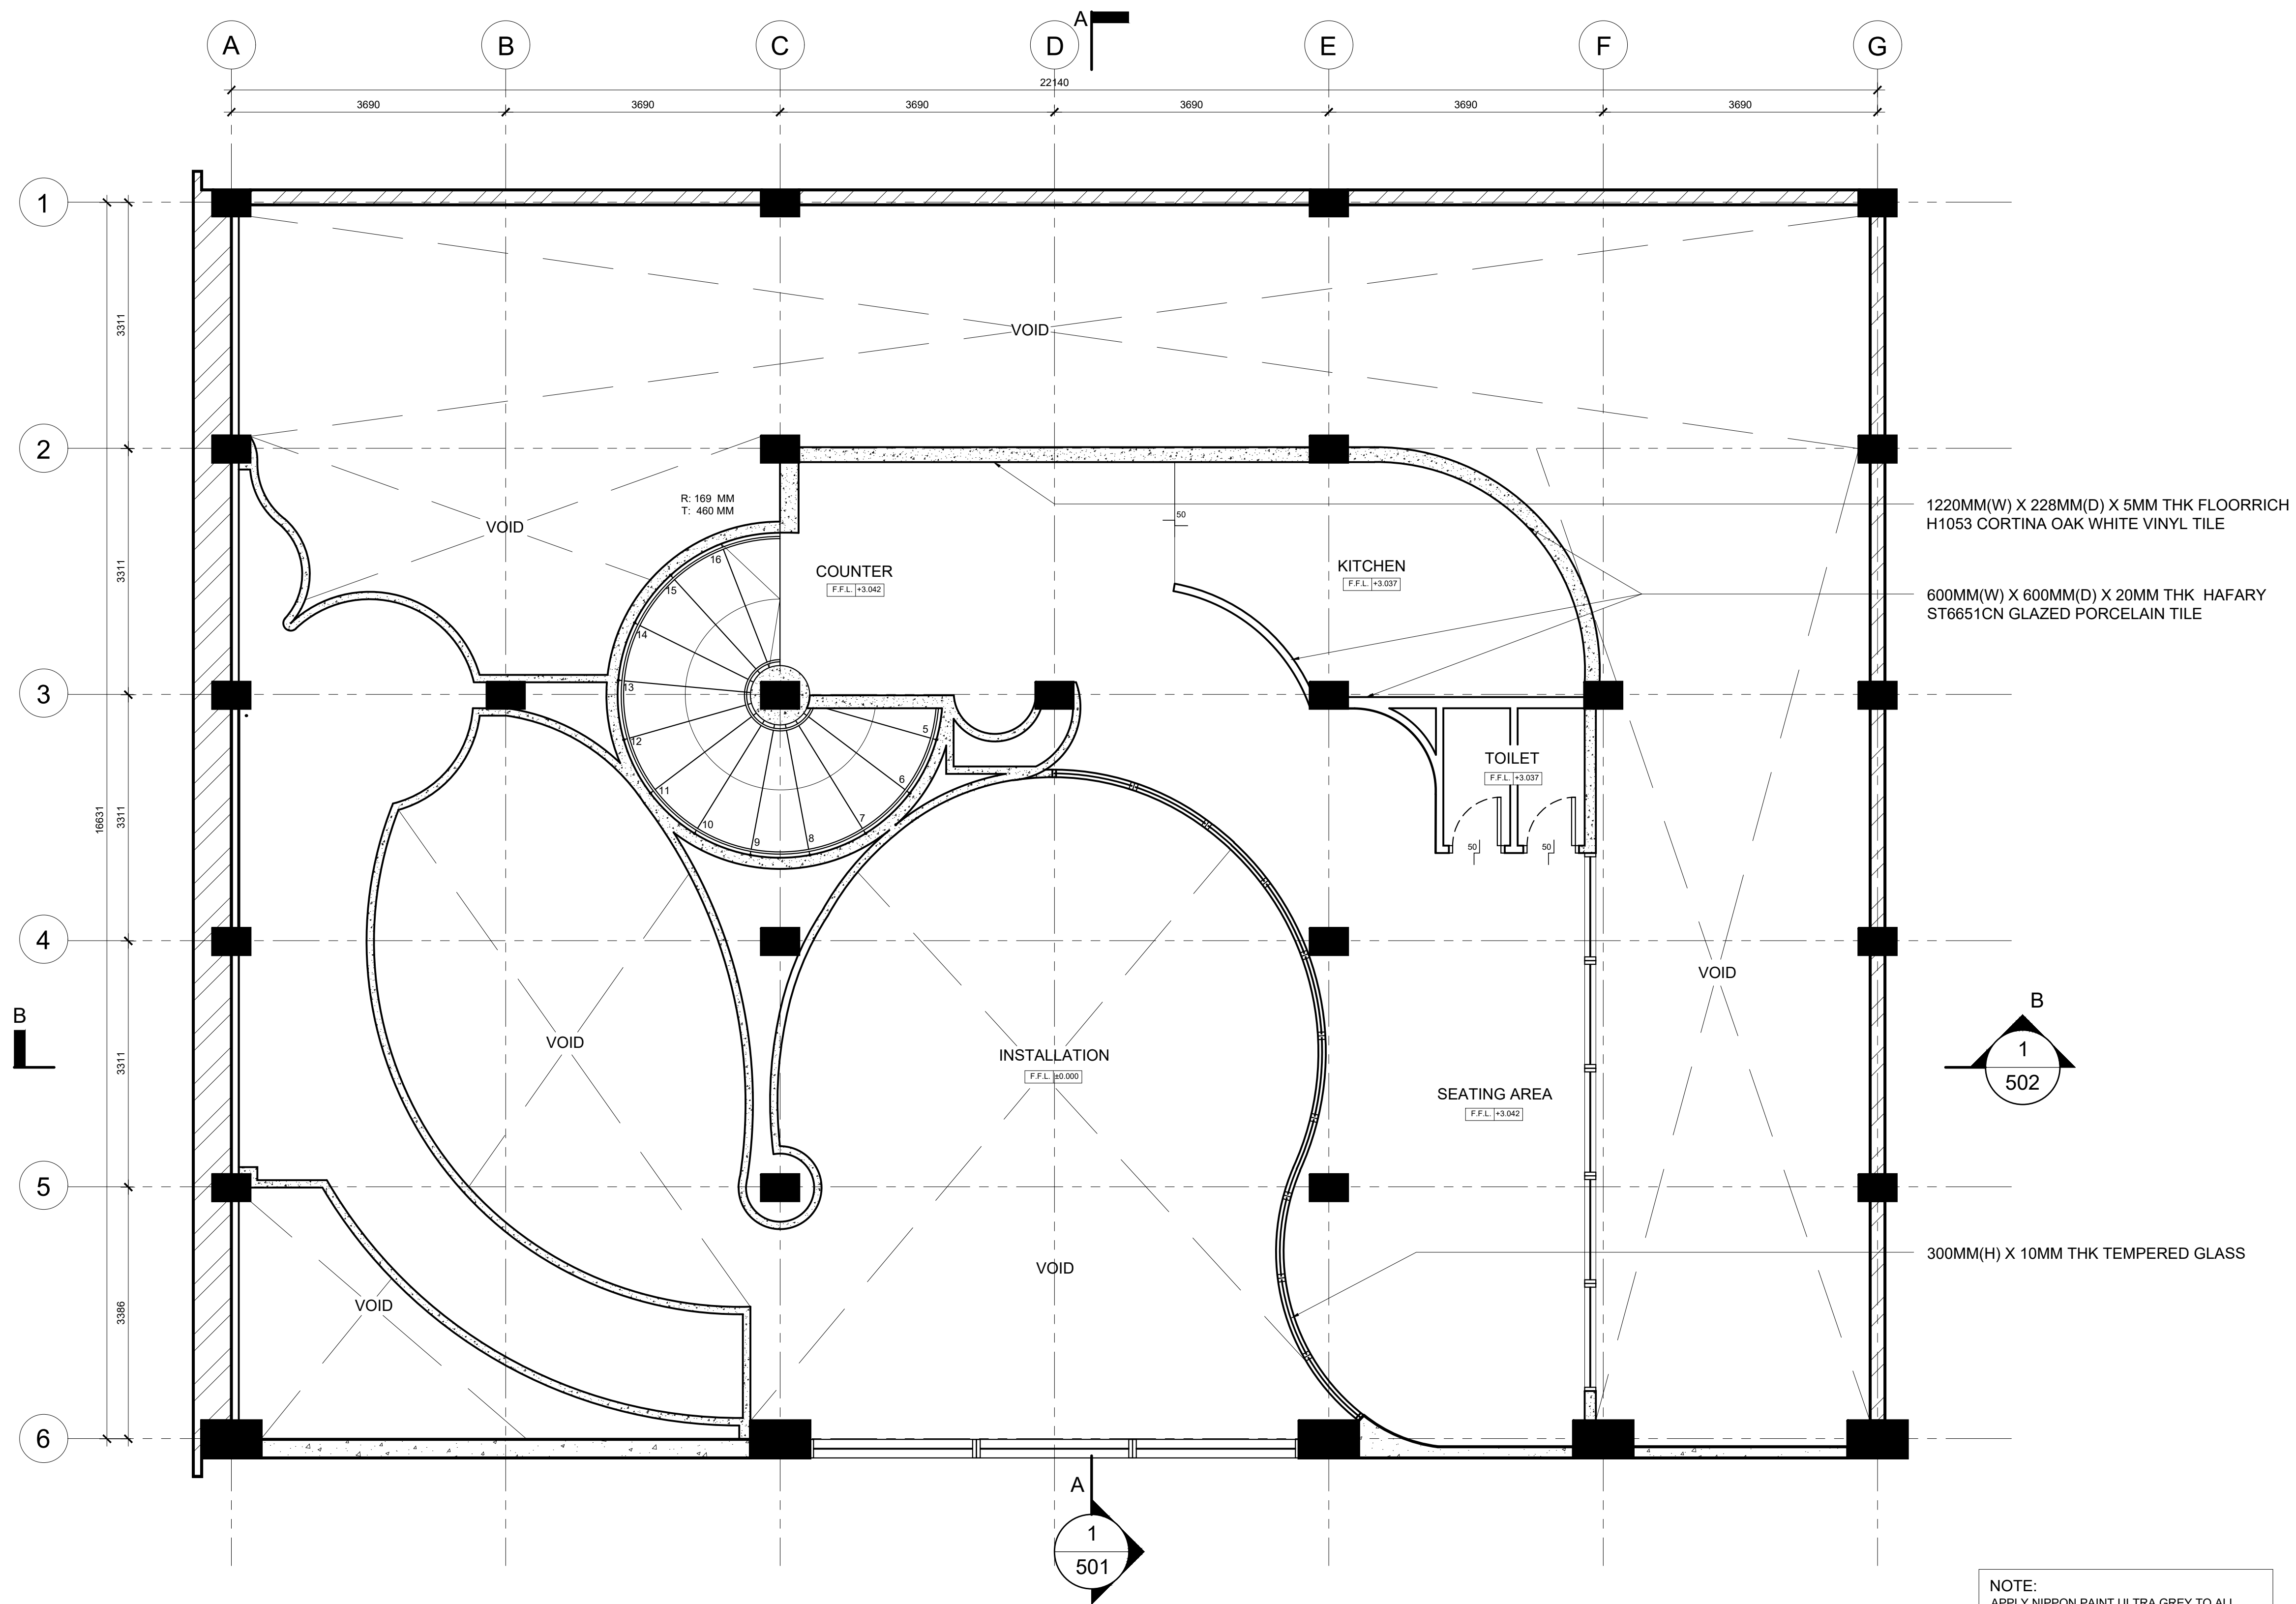

1
304

WALL FINISHES PLAN - LEVEL 2

SCALE : 1 : 50

_____ sheet of _____

AUTHORITY ENDORSEMENT

OFFICIAL STAMP

Project Ref No: 2013-0001

Qualified Person [QP] Declaration

Rev.	Date	Remarks

SP DESIGN SCHOOL

Land Owner / Developer:

SP Design School

Author: Architect/Designer


Project Description:

Proposed Avery Dennison Automotive Studio at
1010 Bukit Merah Lane 3, #01-105
Alexandra Village Industrial Estate
Singapore 159724

Drawing Title:

**WALL FINISHES
PLAN - LEVEL 2**

Project No.: 2020-0001	Drawing No.: ID-304	Rev.:
Project Code: 2020-0001		
Scale: 1 : 50	Date: 31/01/20	Drawn: Hong Si Yu
		Checked: MAT3 Tutor

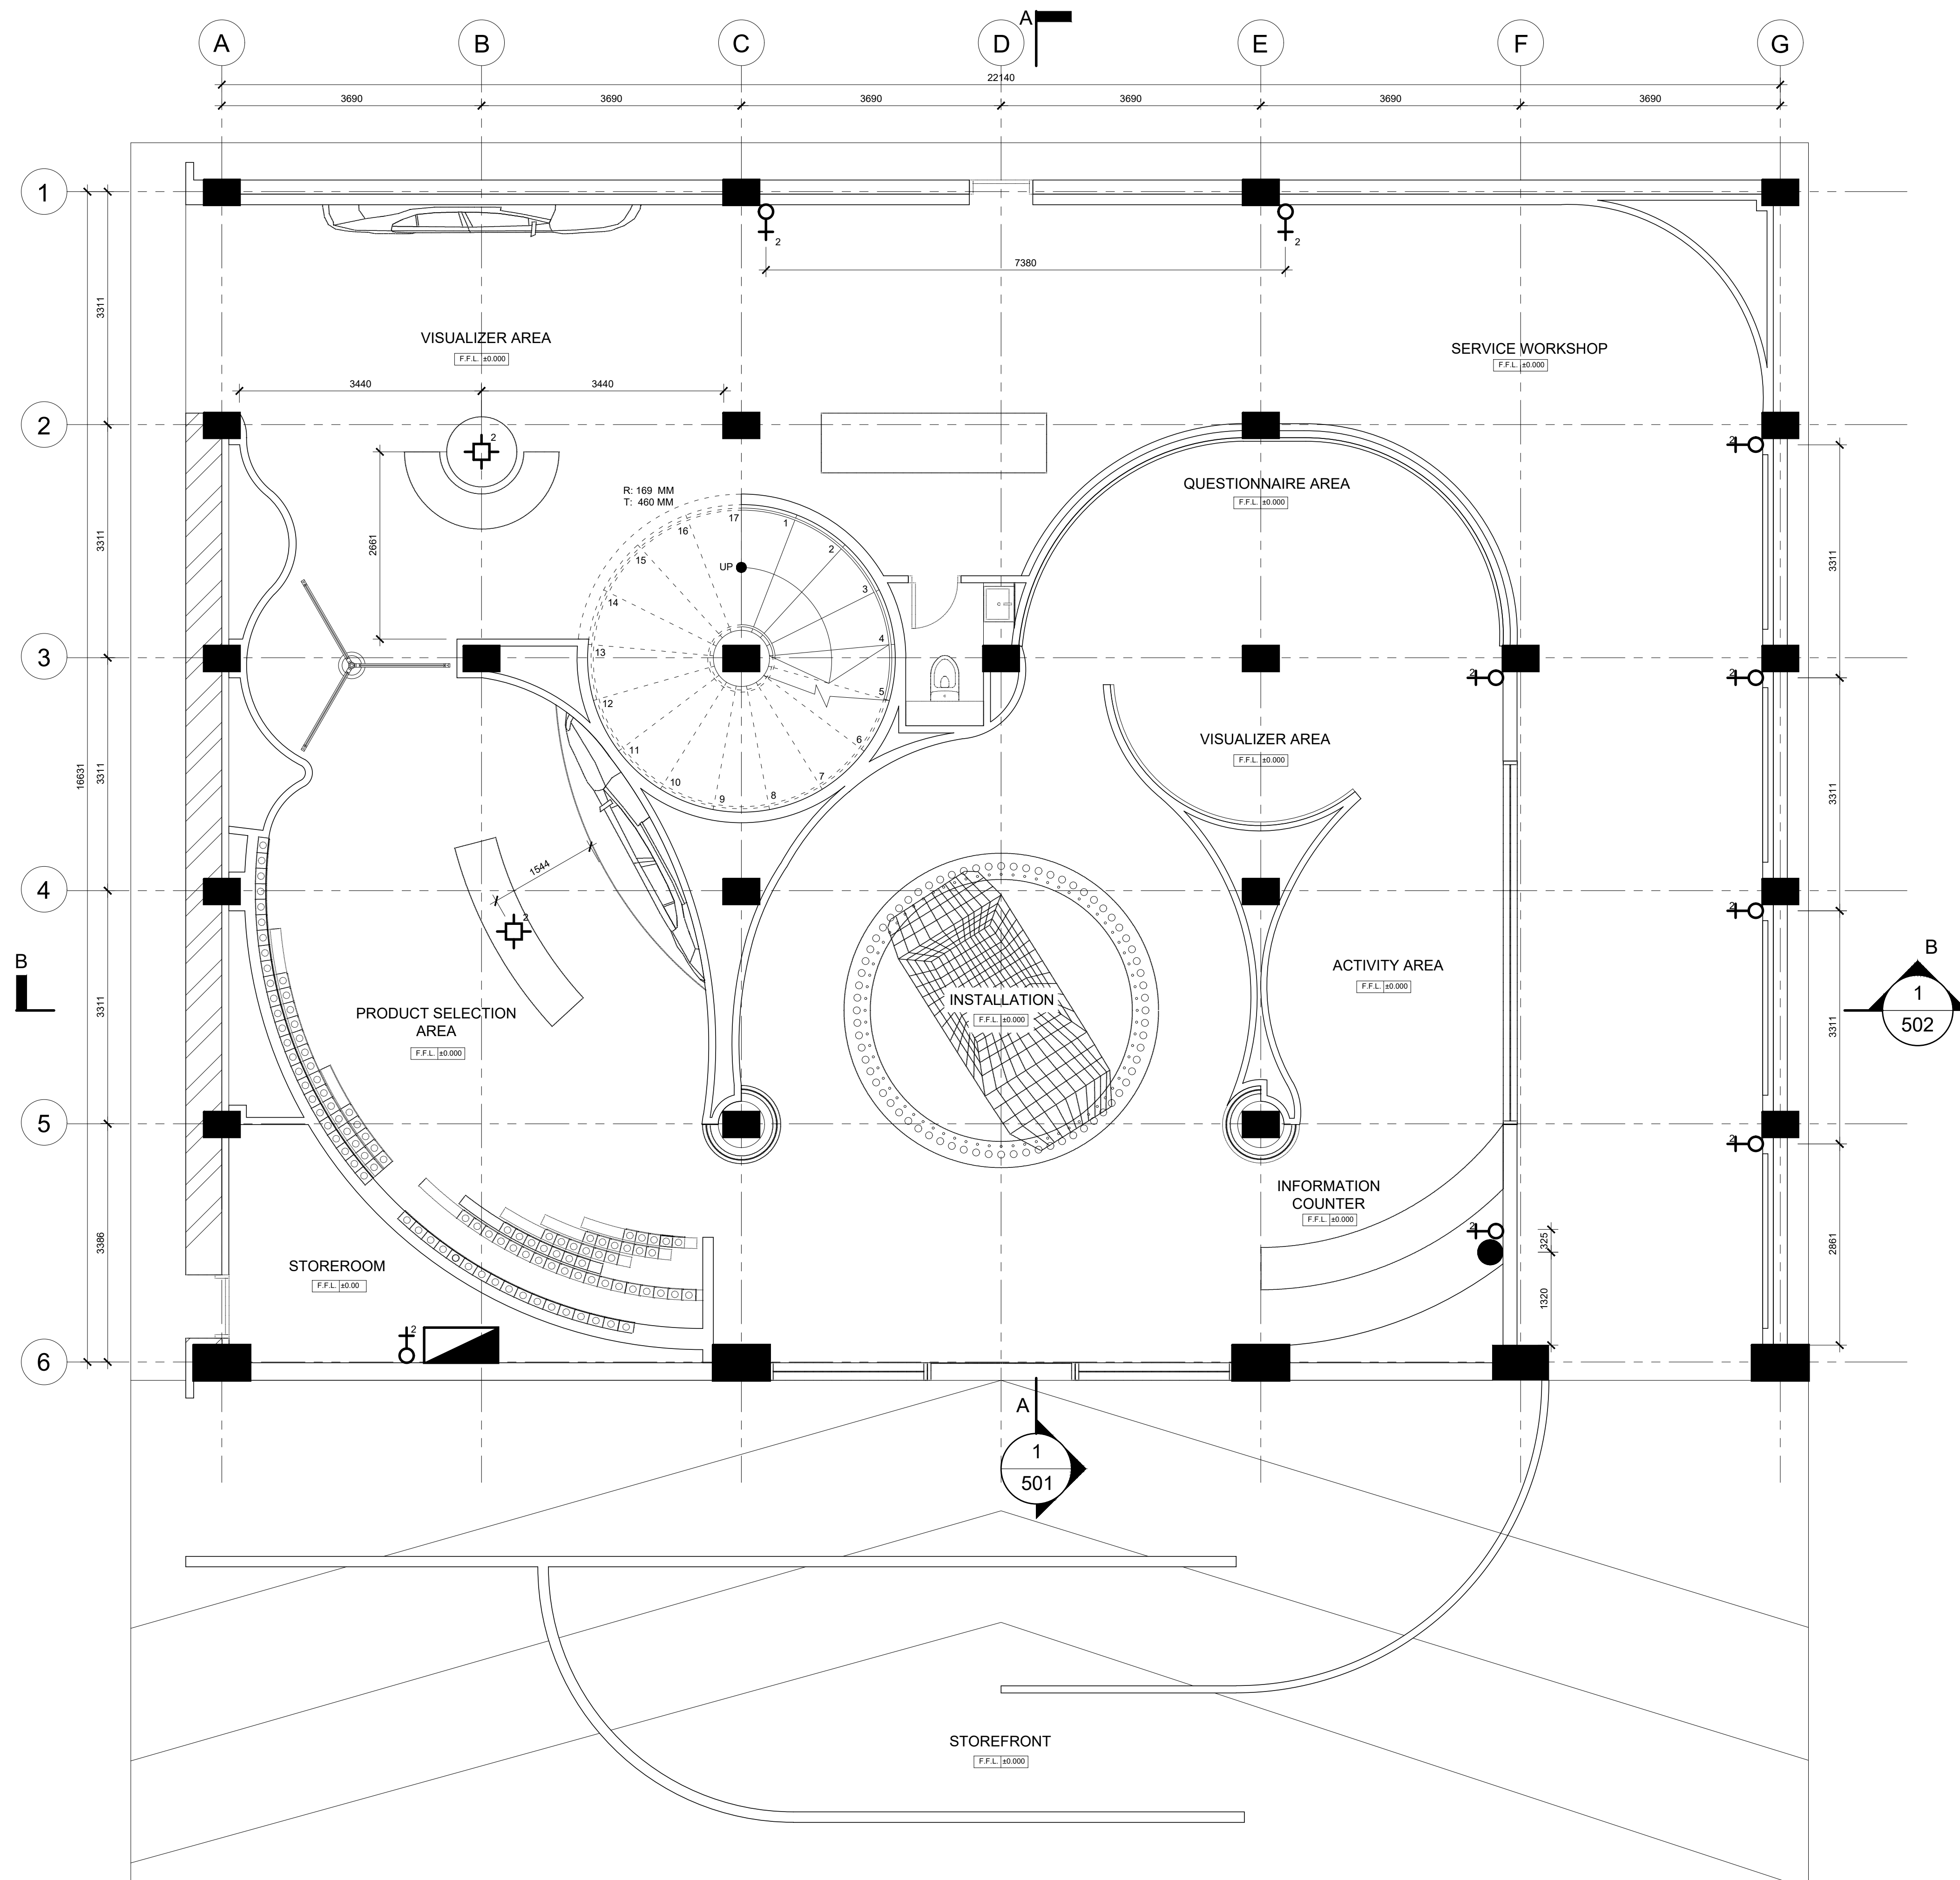

ELECTRICAL & DATA PLAN - LEVEL 1
SCALE : 1 : 50

LEGEND	
	13A DOUBLE SOCKET OUTLET @ 300MM HEIGHT FROM LEVEL 1 FFL
	13A DOUBLE SOCKET OUTLET EMBADDED TO FLOOR
	DATA POINT
	DISTRIBUTION BOARD (DB/OBE)

_____ sheet of _____

AUTHORITY ENDORSEMENT

OFFICIAL STAMP

Project Ref No: 2013-0001

Qualified Person [QP] Declaration

Rev.	Date	Remarks

SP DESIGN SCHOOL

Land Owner / Developer:

SP Design School

Author: Architect/Designer

Project Description:

Proposed Avery Dennison Automotive Studio at
1010 Bukit Merah Lane 3, #01-105
Alexandra Village Industrial Estate
Singapore 159724

Drawing Title:

**ELECTRICAL AND
DATA PLAN -
LEVEL 1**

Project No.:
2020-0001


Drawing No.:

ID-401

Project Code:
2020-0001

Rev.:

Scale:	Date:	Drawn:	Checked:
1 : 50	31/01/20	Hong Si Yu	MAT3 Tutor

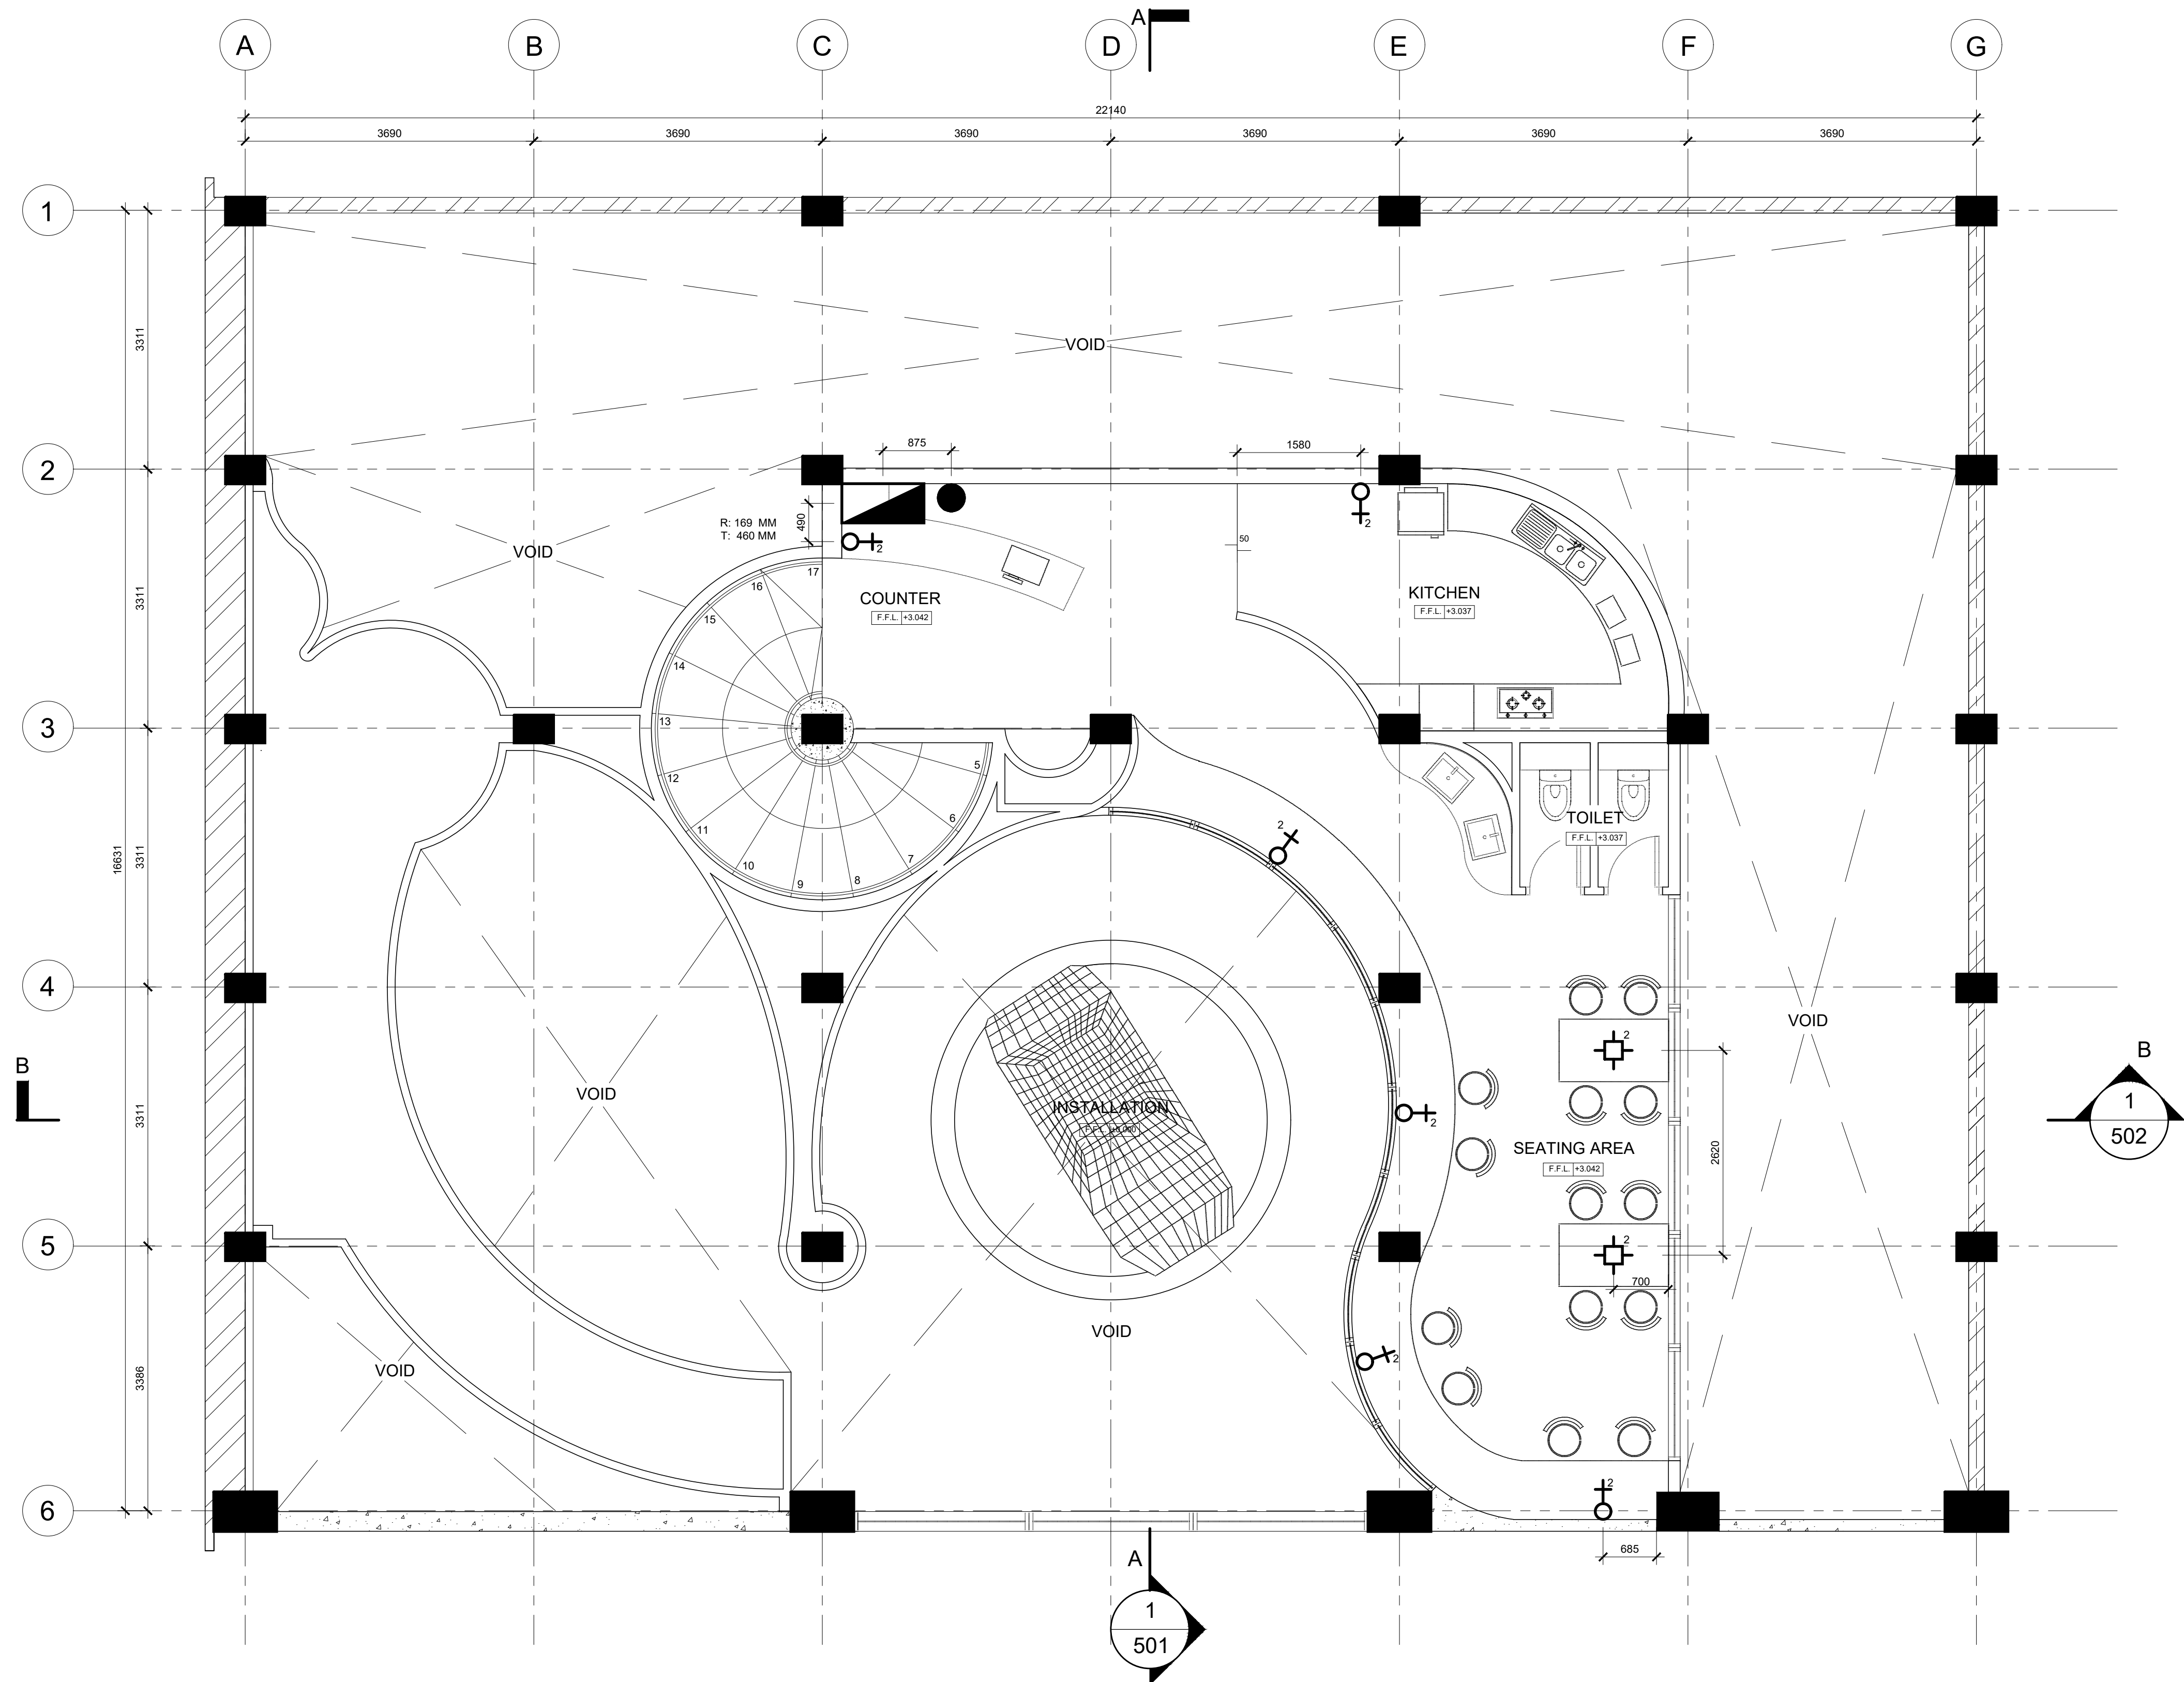

1
402

ELECTRICAL & DATA PLAN - LEVEL 2

SCALE : 1 : 50

_____ sheet of _____

AUTHORITY ENDORSEMENT

OFFICIAL STAMP

Project Ref No: 2013-001

Qualified Person [QP] Declaration

Rev.	Date	Remarks

SP DESIGN SCHOOL

Land Owner / Developer:

SP Design School

Author: Architect/Designer

Project Description:

Proposed Avery Dennison Automotive Studio at
1010 Bukit Merah Lane 3, #01-105
Alexandra Village Industrial Estate
Singapore 159724

Drawing Title:

ELECTRICAL AND DATA PLAN - LEVEL 2

Project No.: 2020-0001	Drawing No.: ID-402	Rev.:
Project Code: 2020-0001		
Scale: 1 : 50	Date: 31/01/20	Drawn: Hong Si Yu
		Checked: MAT3 Tutor

AUTHORITY ENDORSEMENT

OFFICIAL STAMP

Project Ref No: 2013-0001

Qualified Person [QP] Declaration

Rev.	Date	Remarks

SP DESIGN SCHOOL

Land Owner / Developer:

SP Design School

Author: Architect/Designer


Project Description:

Proposed Avery Dennison Automotive Studio at
1010 Bukit Merah Lane 3, #01-105
Alexandra Village Industrial Estate
Singapore 159724

Drawing Title:

SECTION A-A

Project No.: 2020-0001		Drawing No.: ID-501	
Project Code: 2020-0001		Rev.: 	
Scale: 1 : 50	Date: 31/01/20	Drawn: Hong Si Yu	Checked: MAT3 Tutor

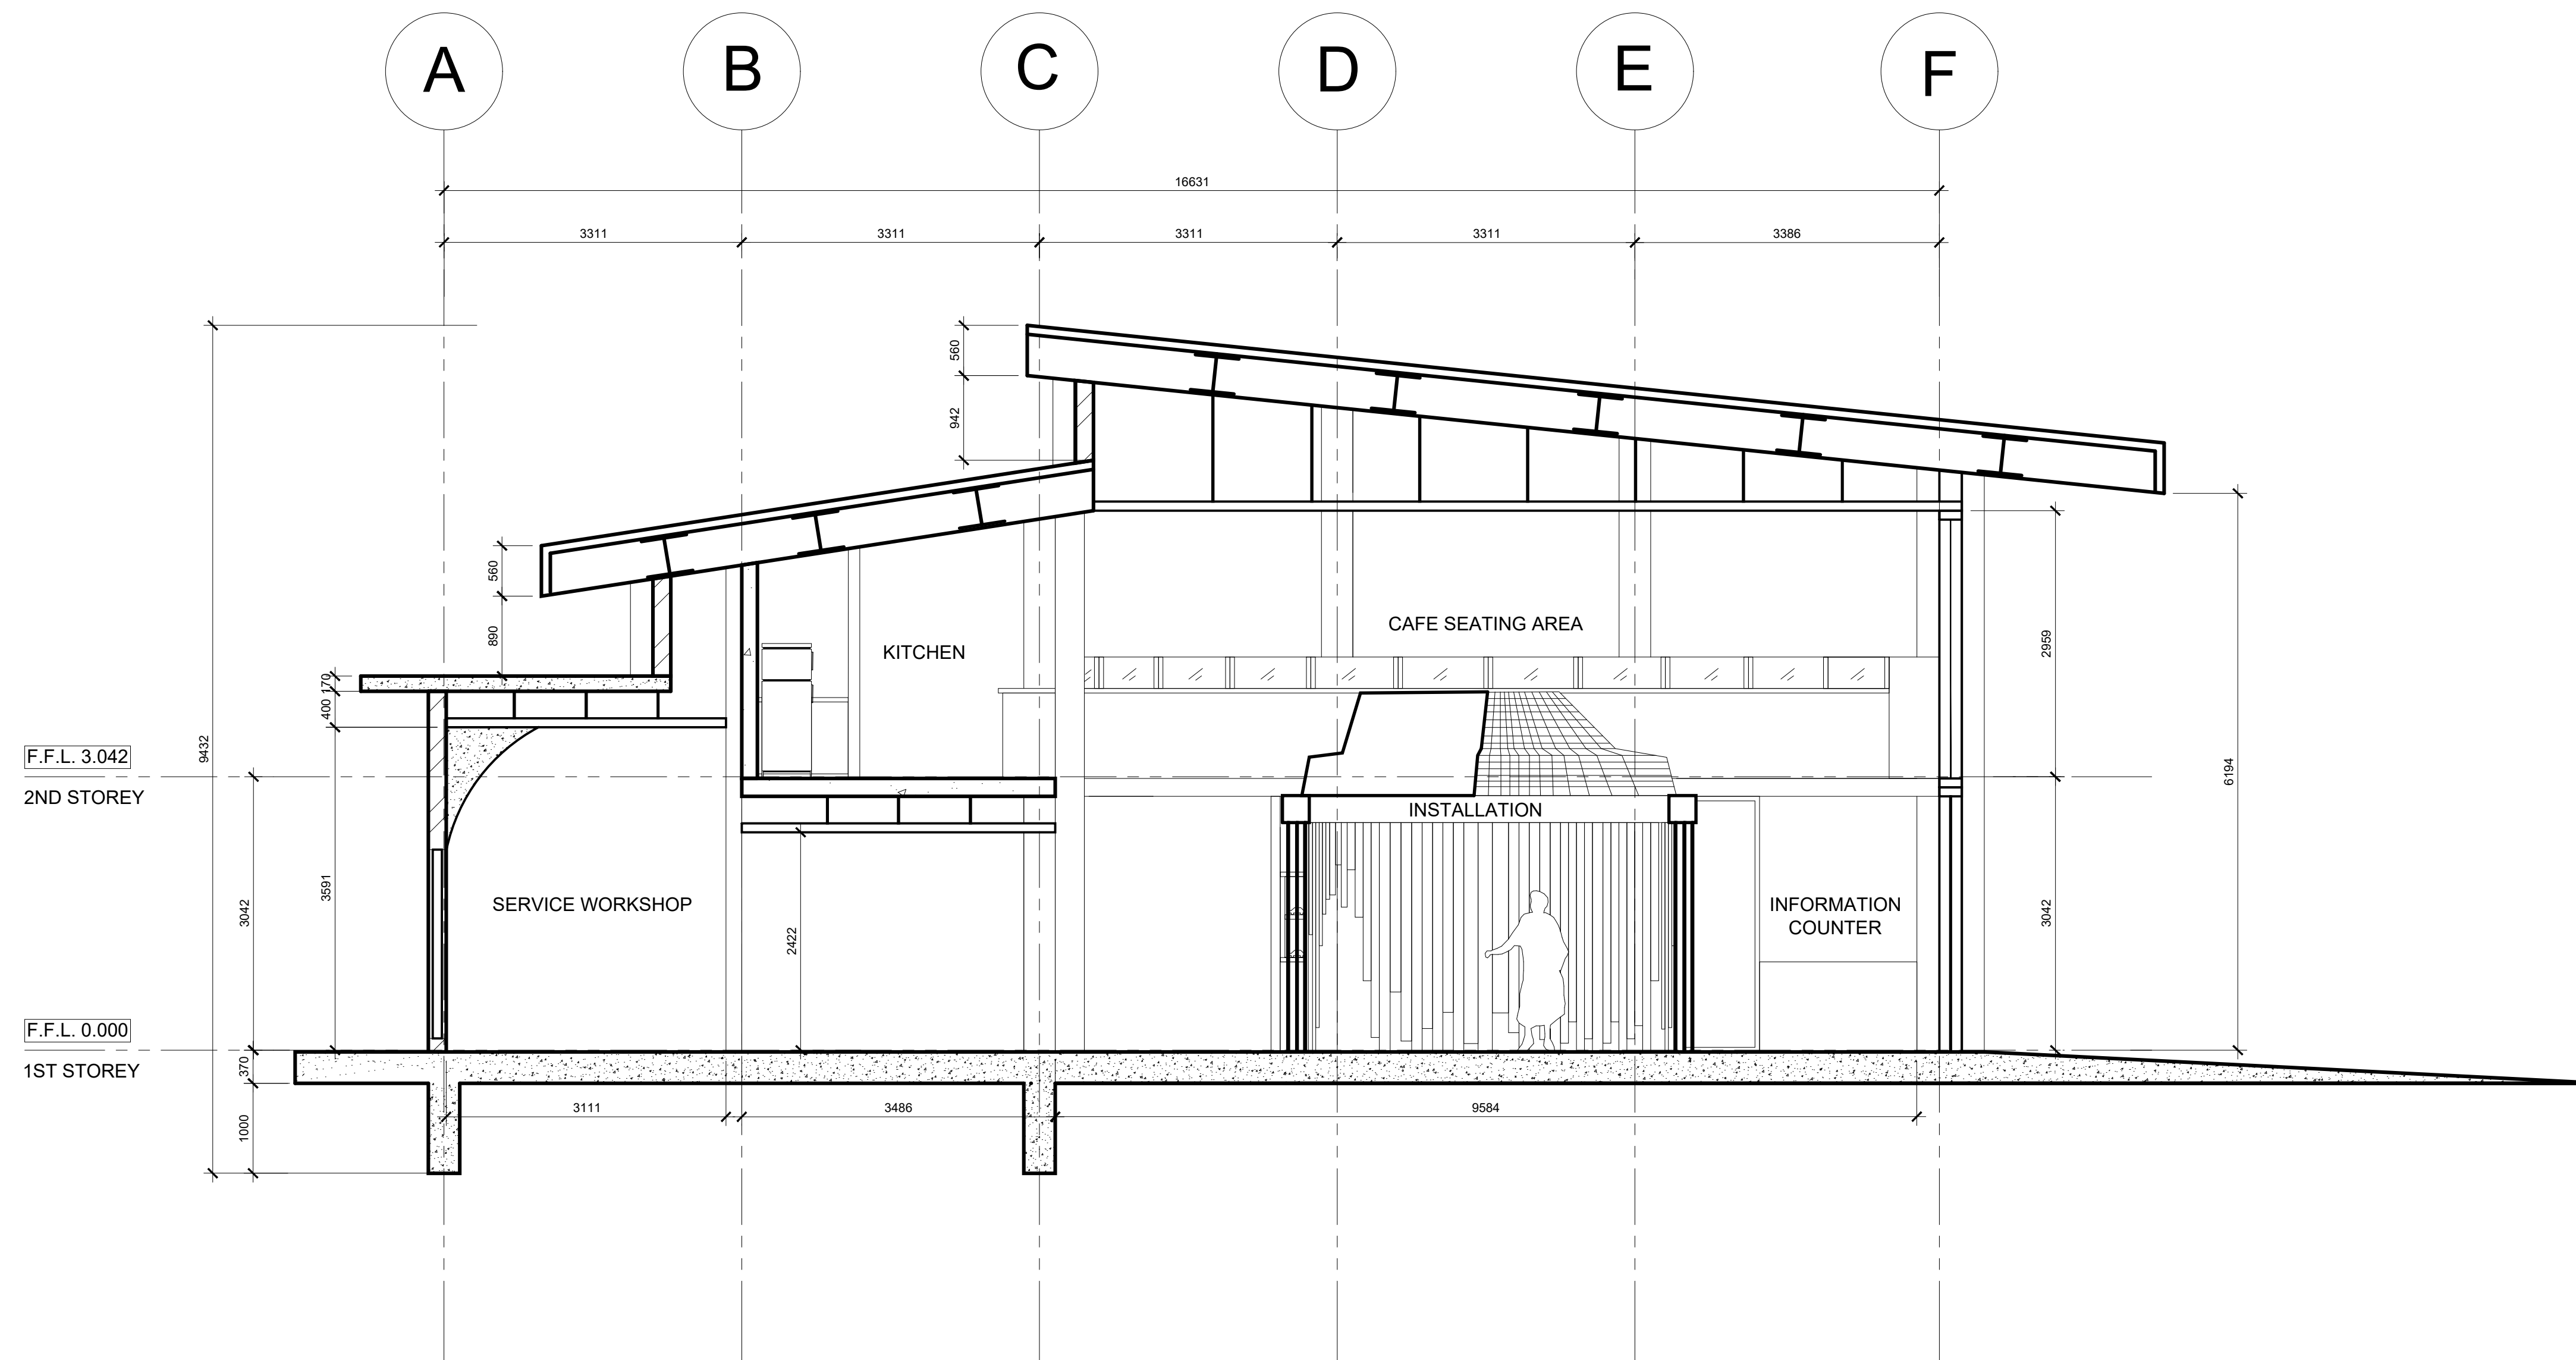

SECTION A-A
SCALE : 1 : 50

AUTHORITY ENDORSEMENT

OFFICIAL STAMP

Project Ref No: 2013-0001

Qualified Person [QP] Declaration

Rev.	Date	Remarks

SP | DESIGN SCHOOL

Land Owner / Developer:

SP Design School

Author: Architect/Designer


Project Description:

Proposed Avery Dennison Automotive Studio at
1010 Bukit Merah Lane 3, #01-105
Alexandra Village Industrial Estate
Singapore 159724


Drawing Title:

SECTIONAL
PERSPECTIVE B-B

Project No.: 2020-0001	Drawing No.: ID-502
Project Code: 2020-0001	Rev.:
Scale: 1 : 50	Date: 31/01/20
Drawn: Hong Si Yu	Checked: MAT3 Tutor

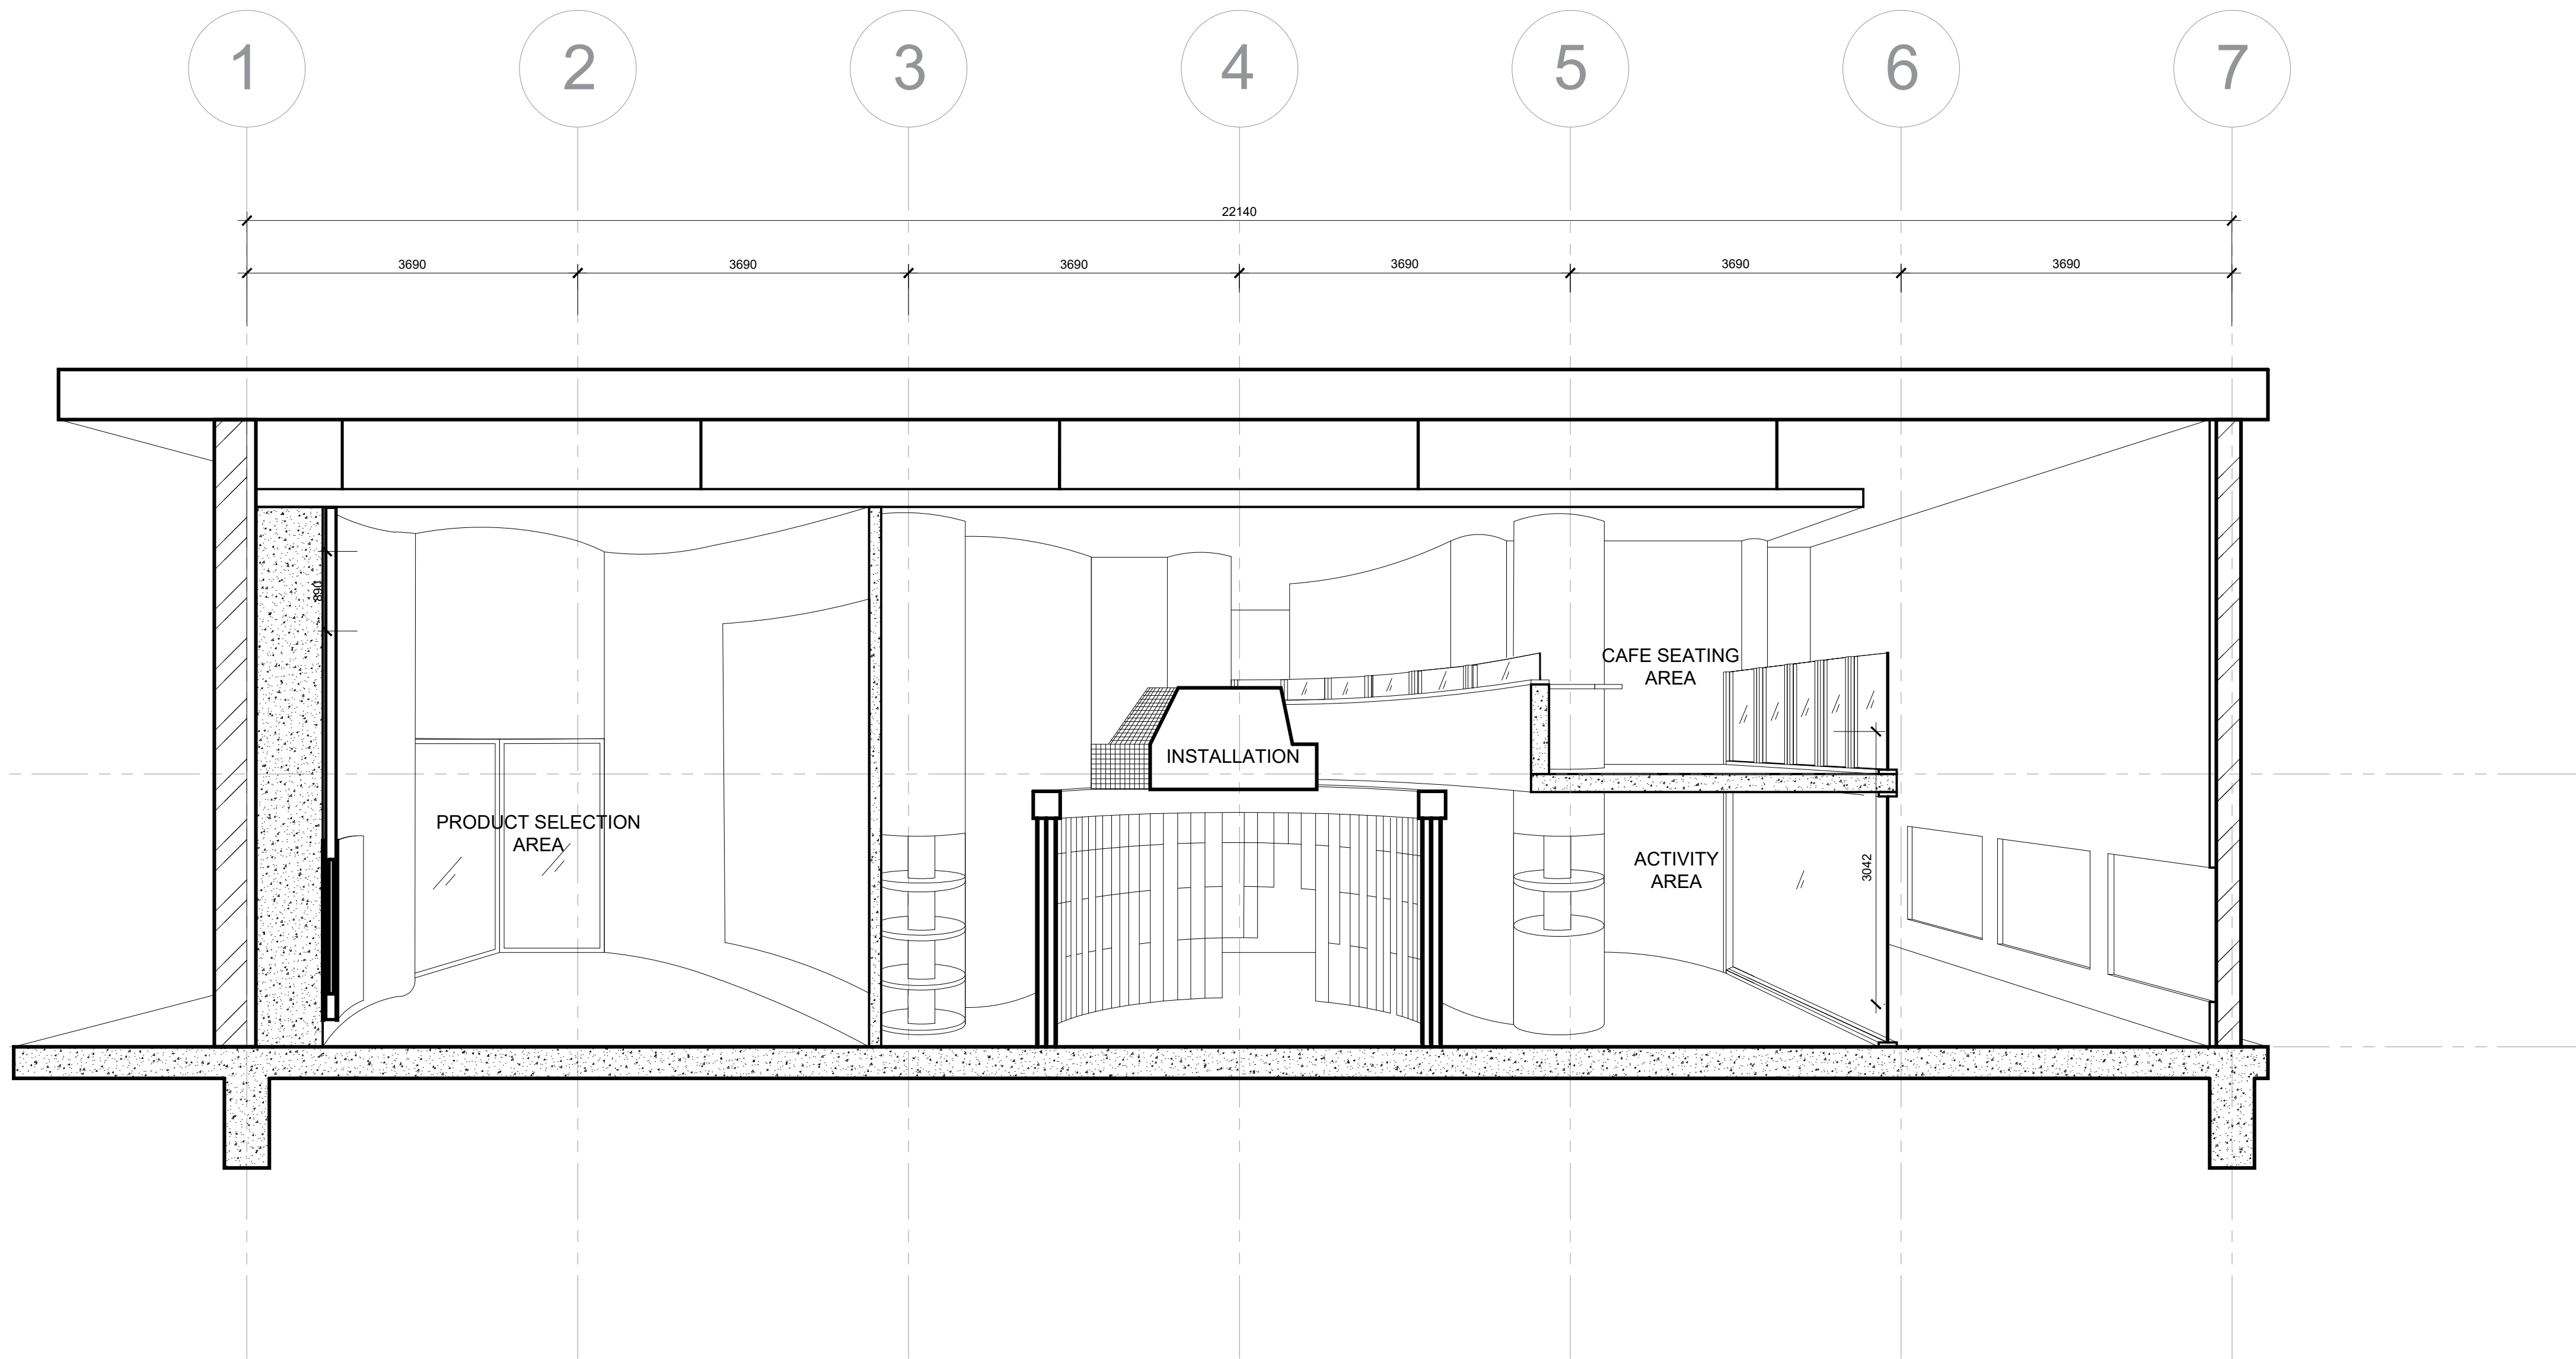


SECTIONAL PERSPECTIVE B-B
SCALE : 1 : 50

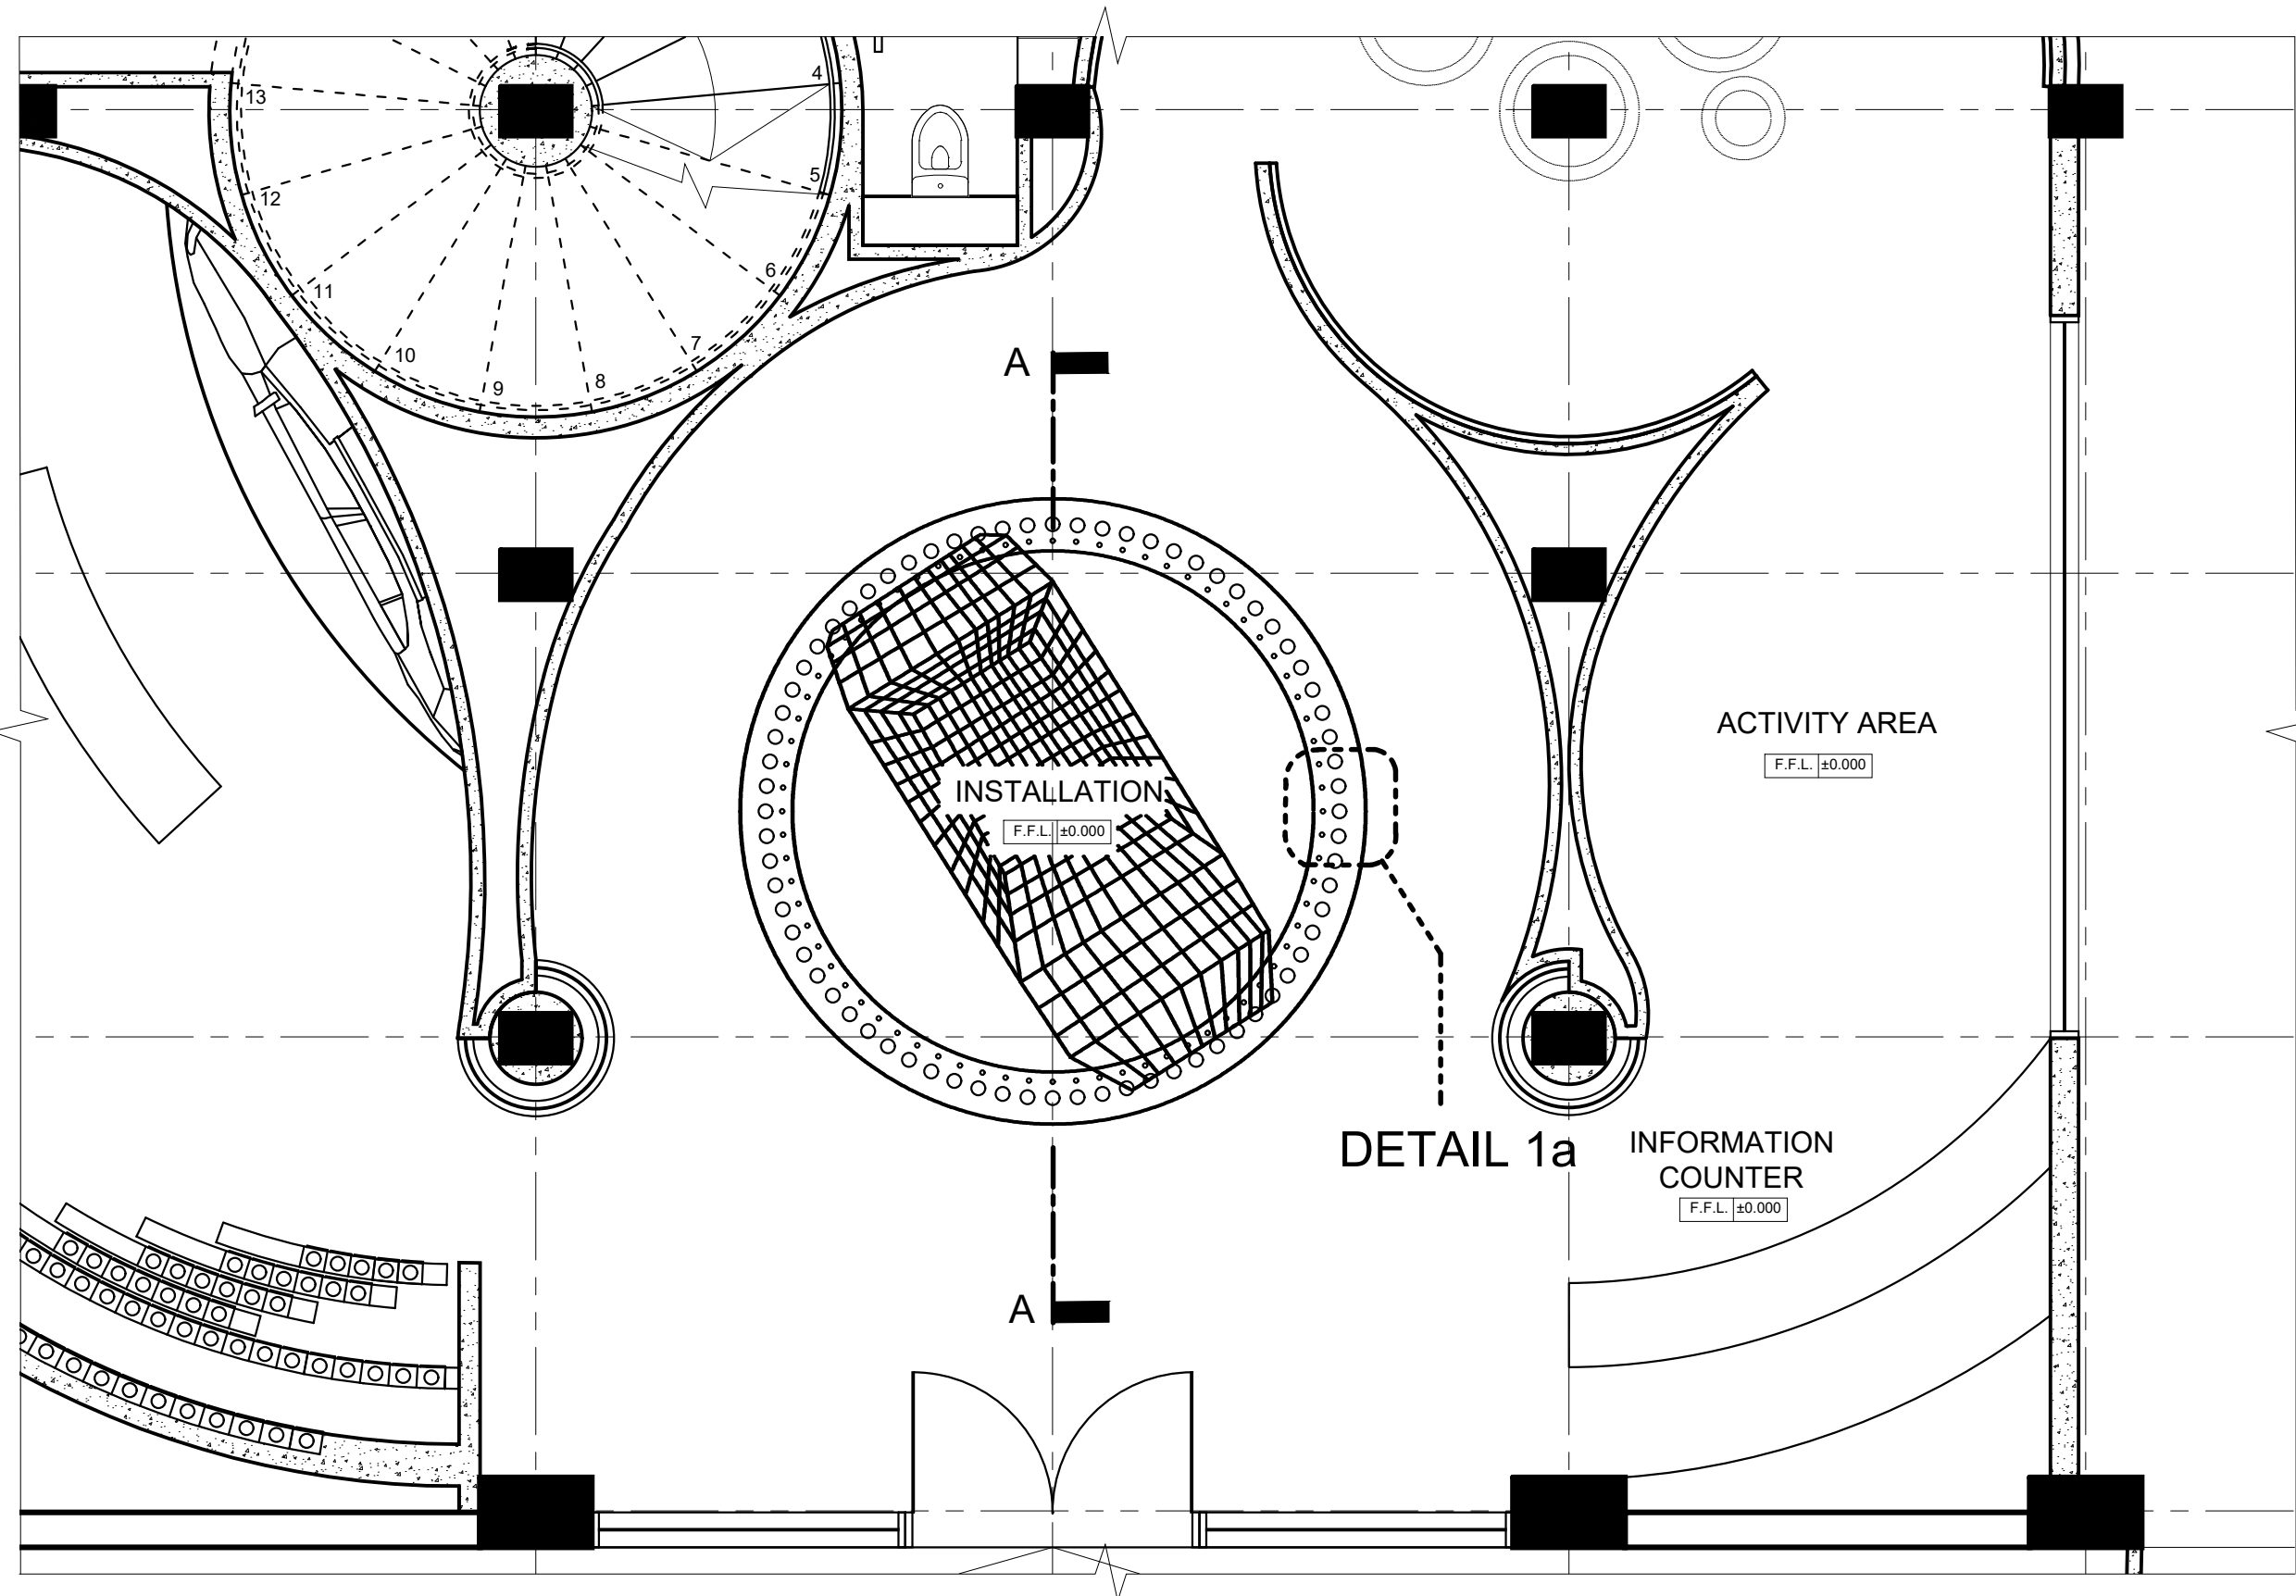

1
601

KEY PLAN


SCALE : 1 : 50

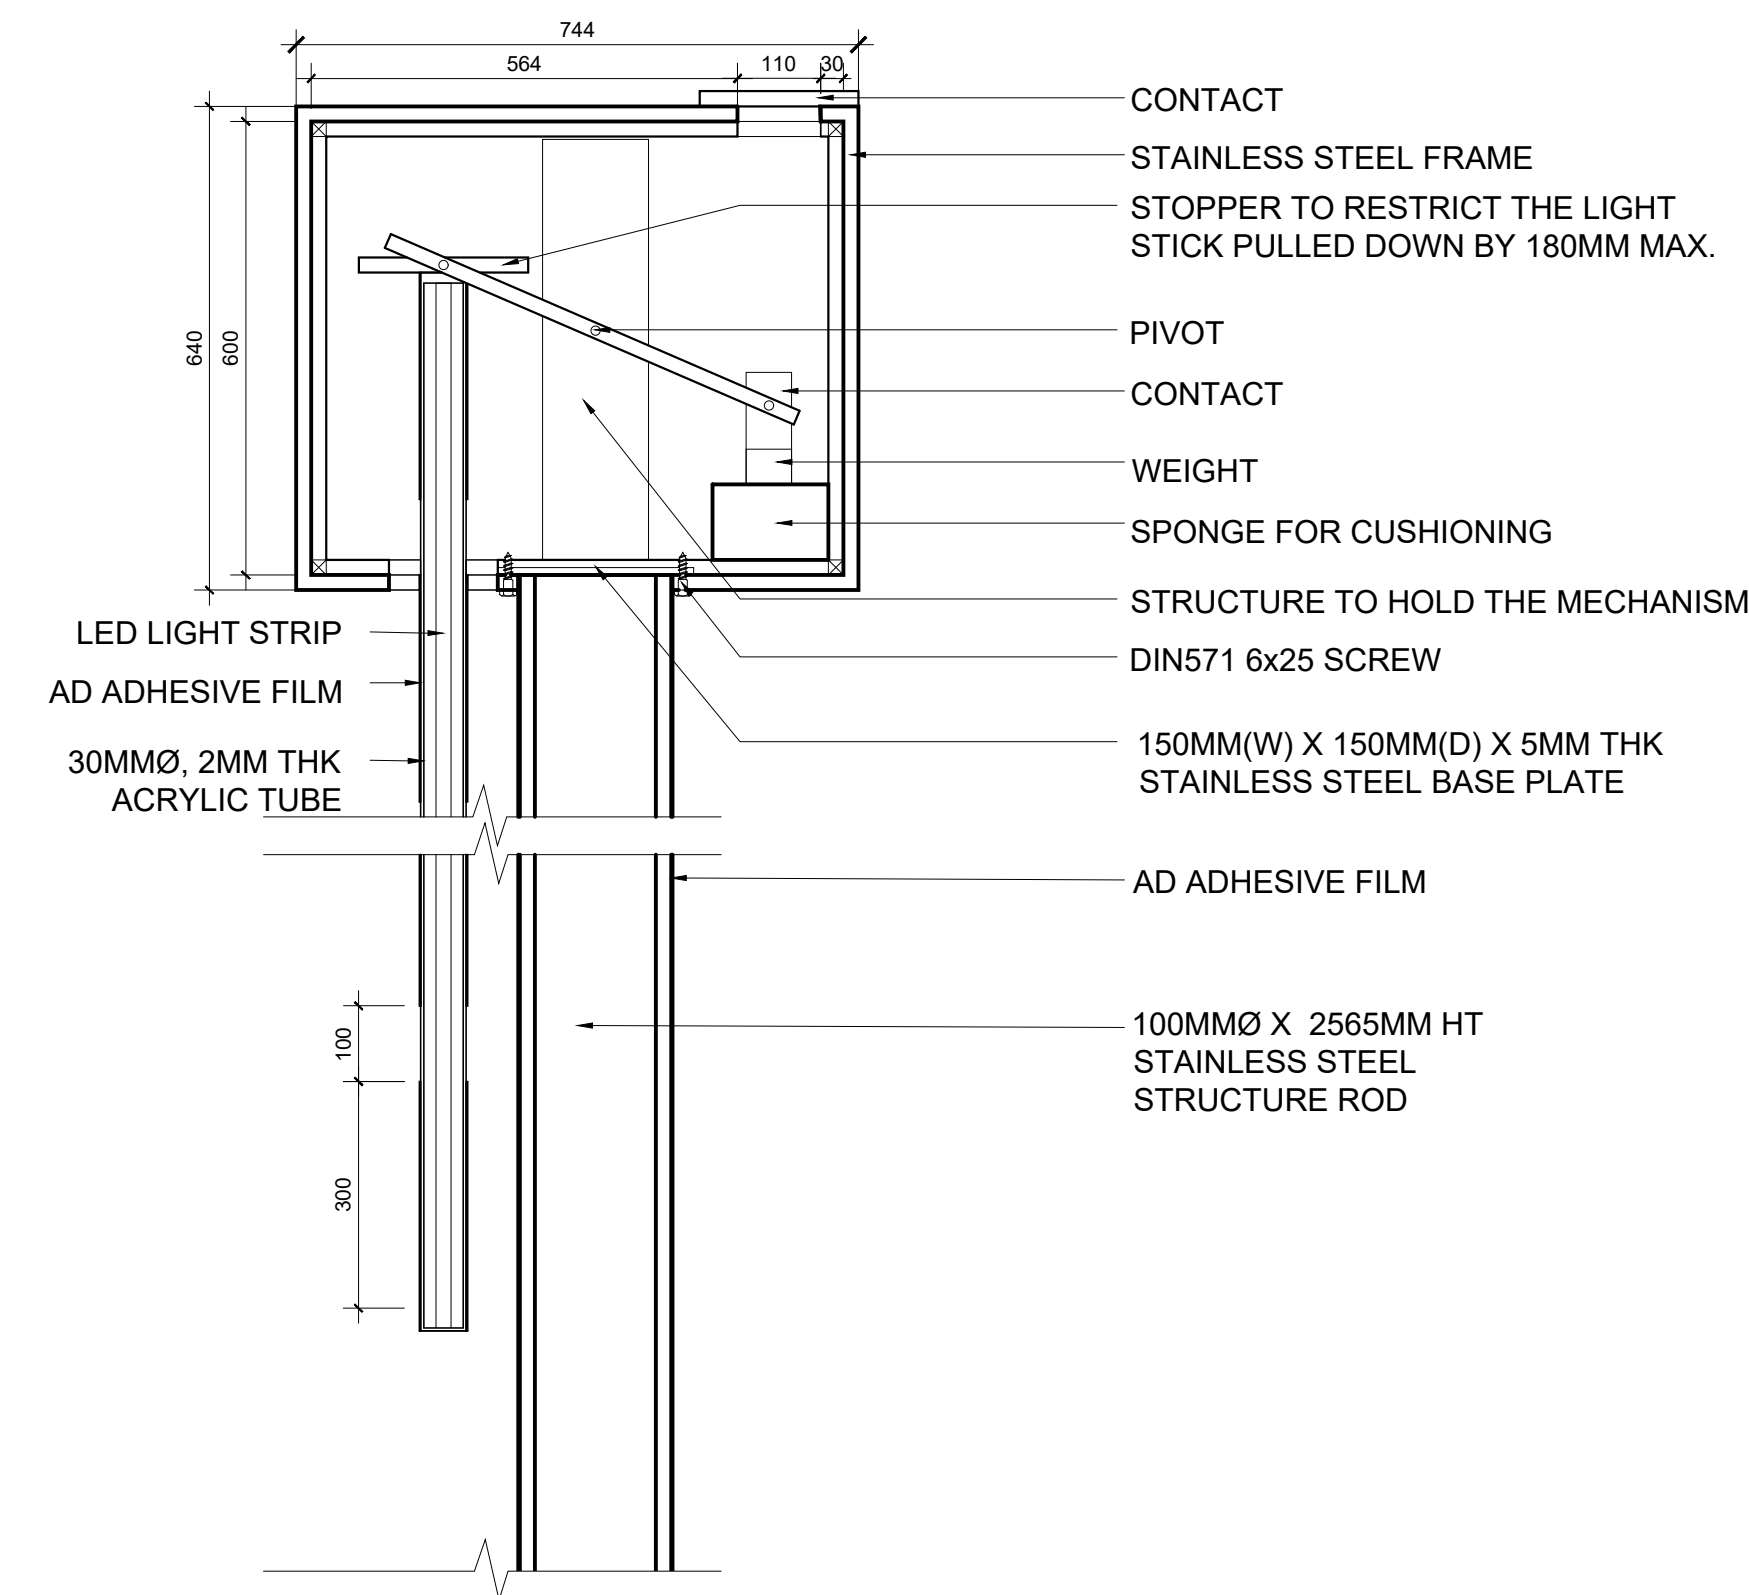

3
601

DETAIL 1a: SECTION B-B


SCALE : 1 : 5

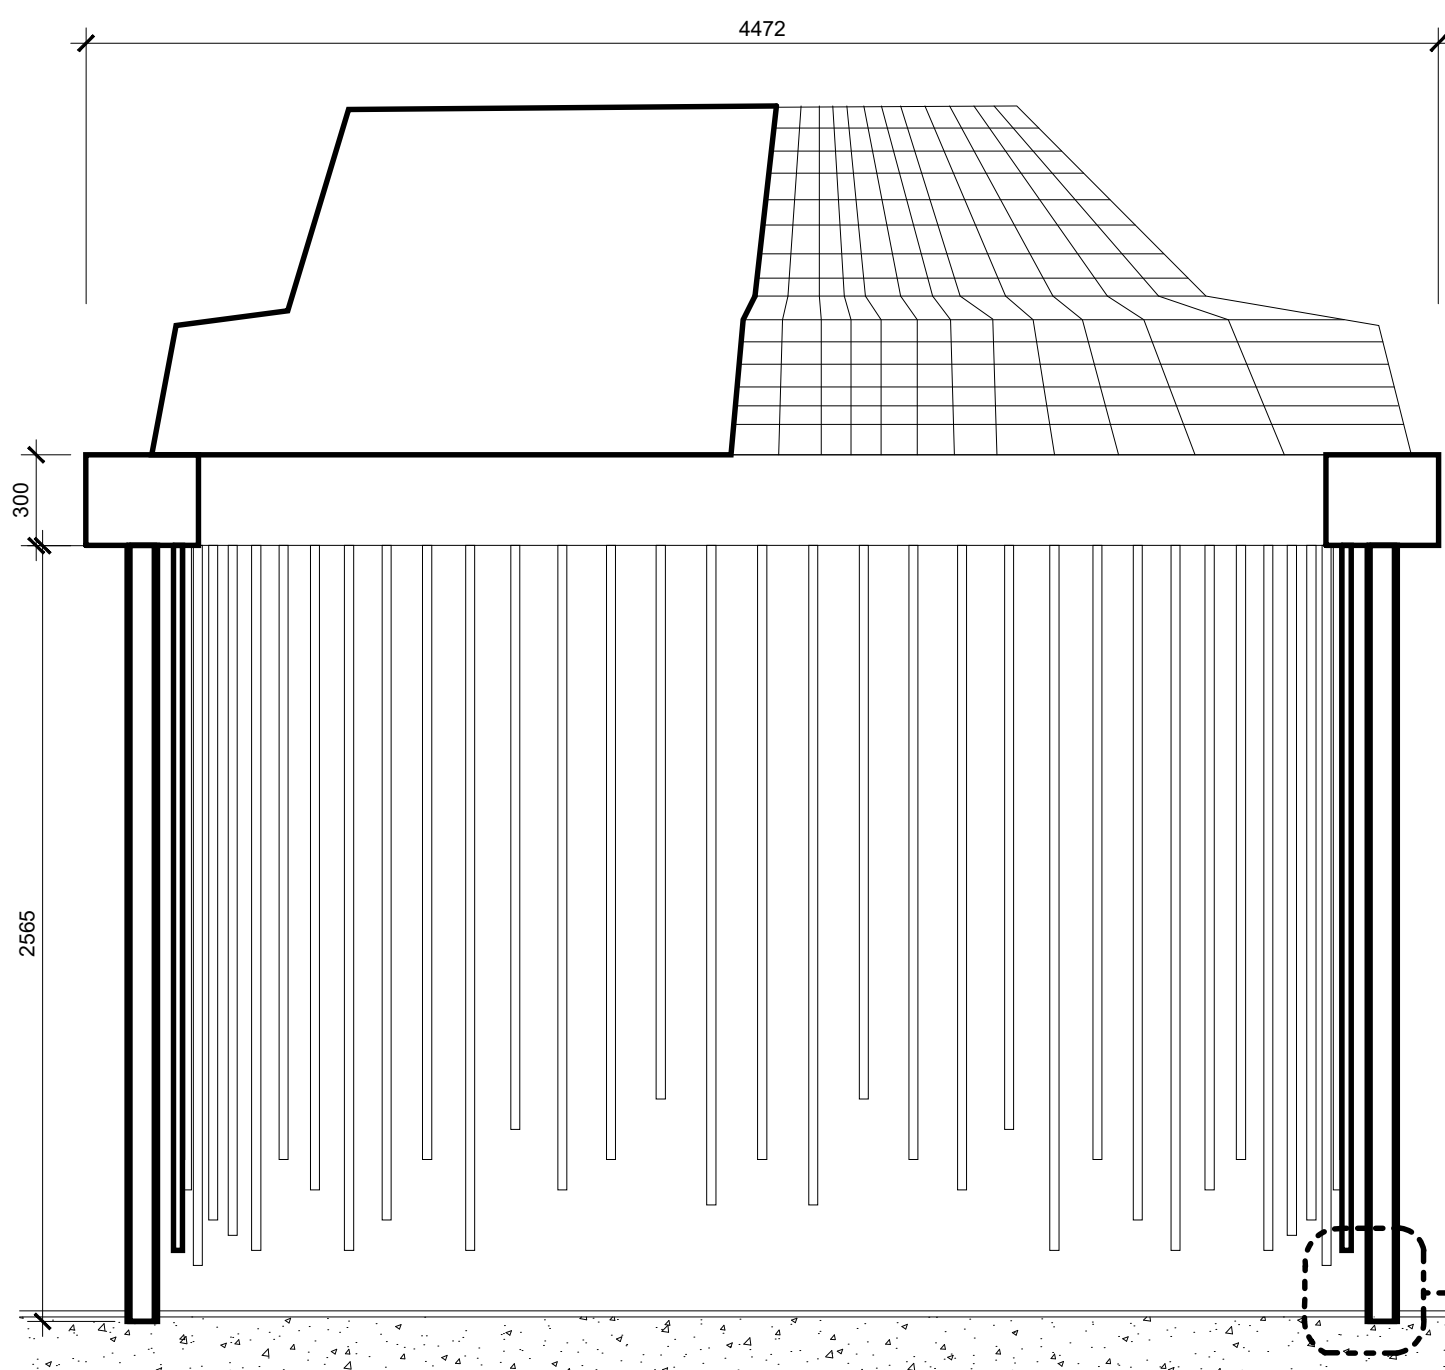

4
601

SECTION A-A


SCALE : 1 : 50

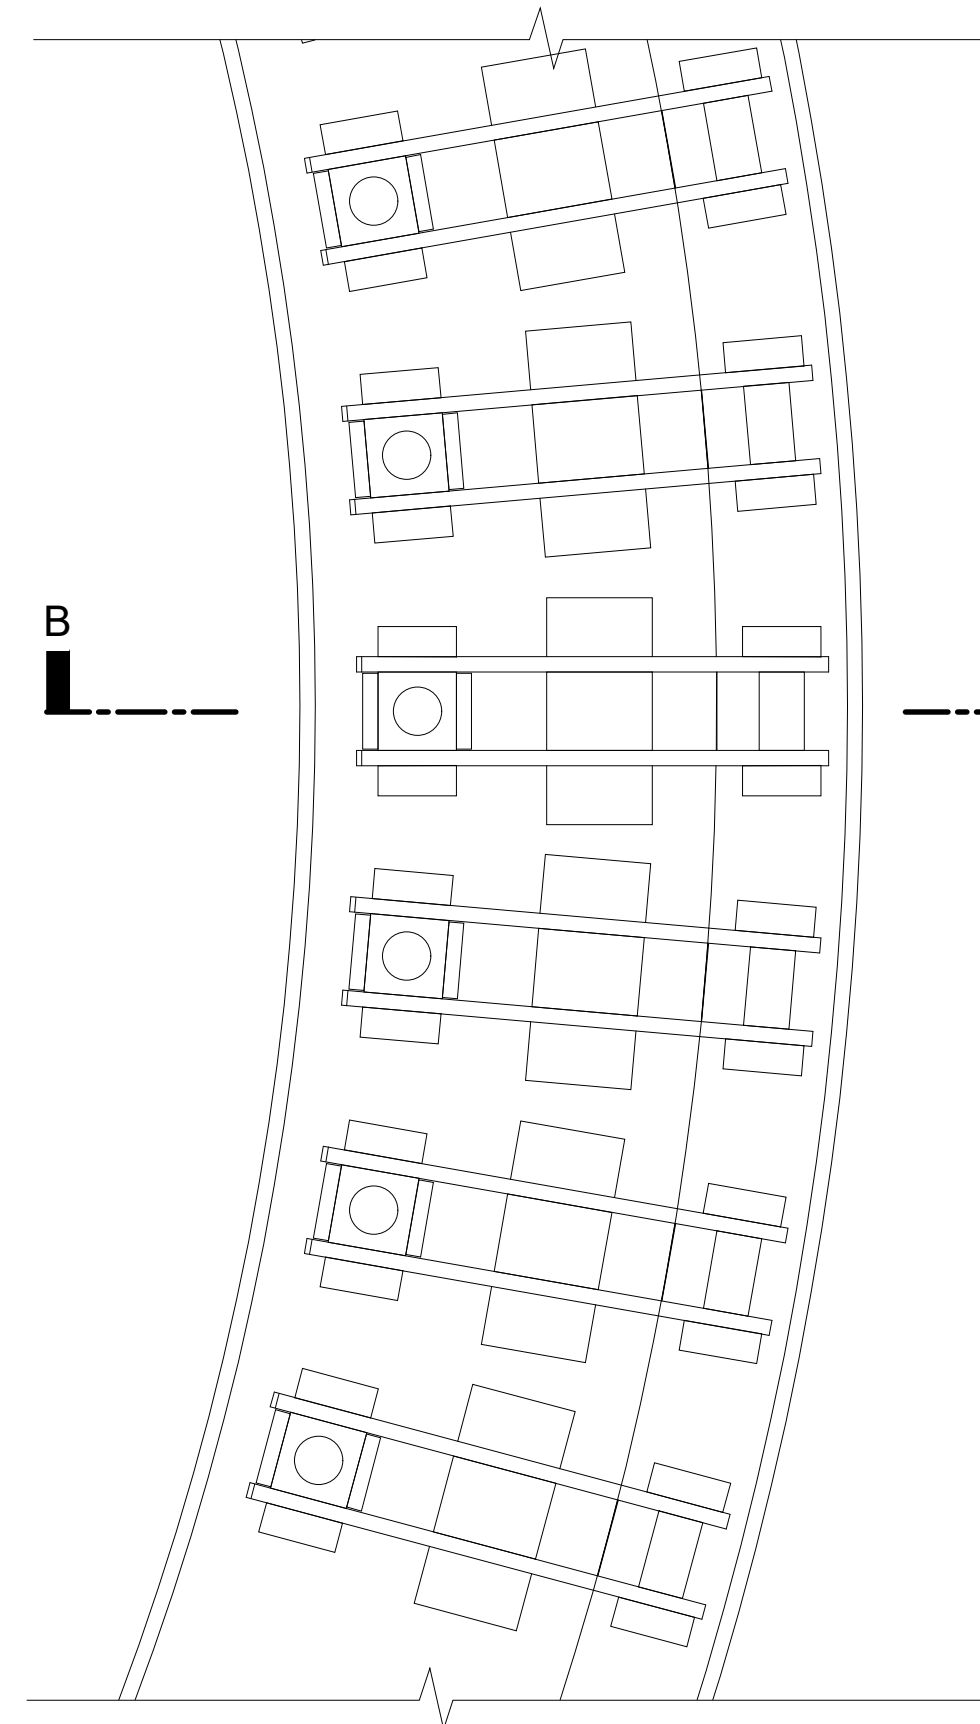

2
601

DETAIL 1a: PLAN

SCALE : 1 : 5

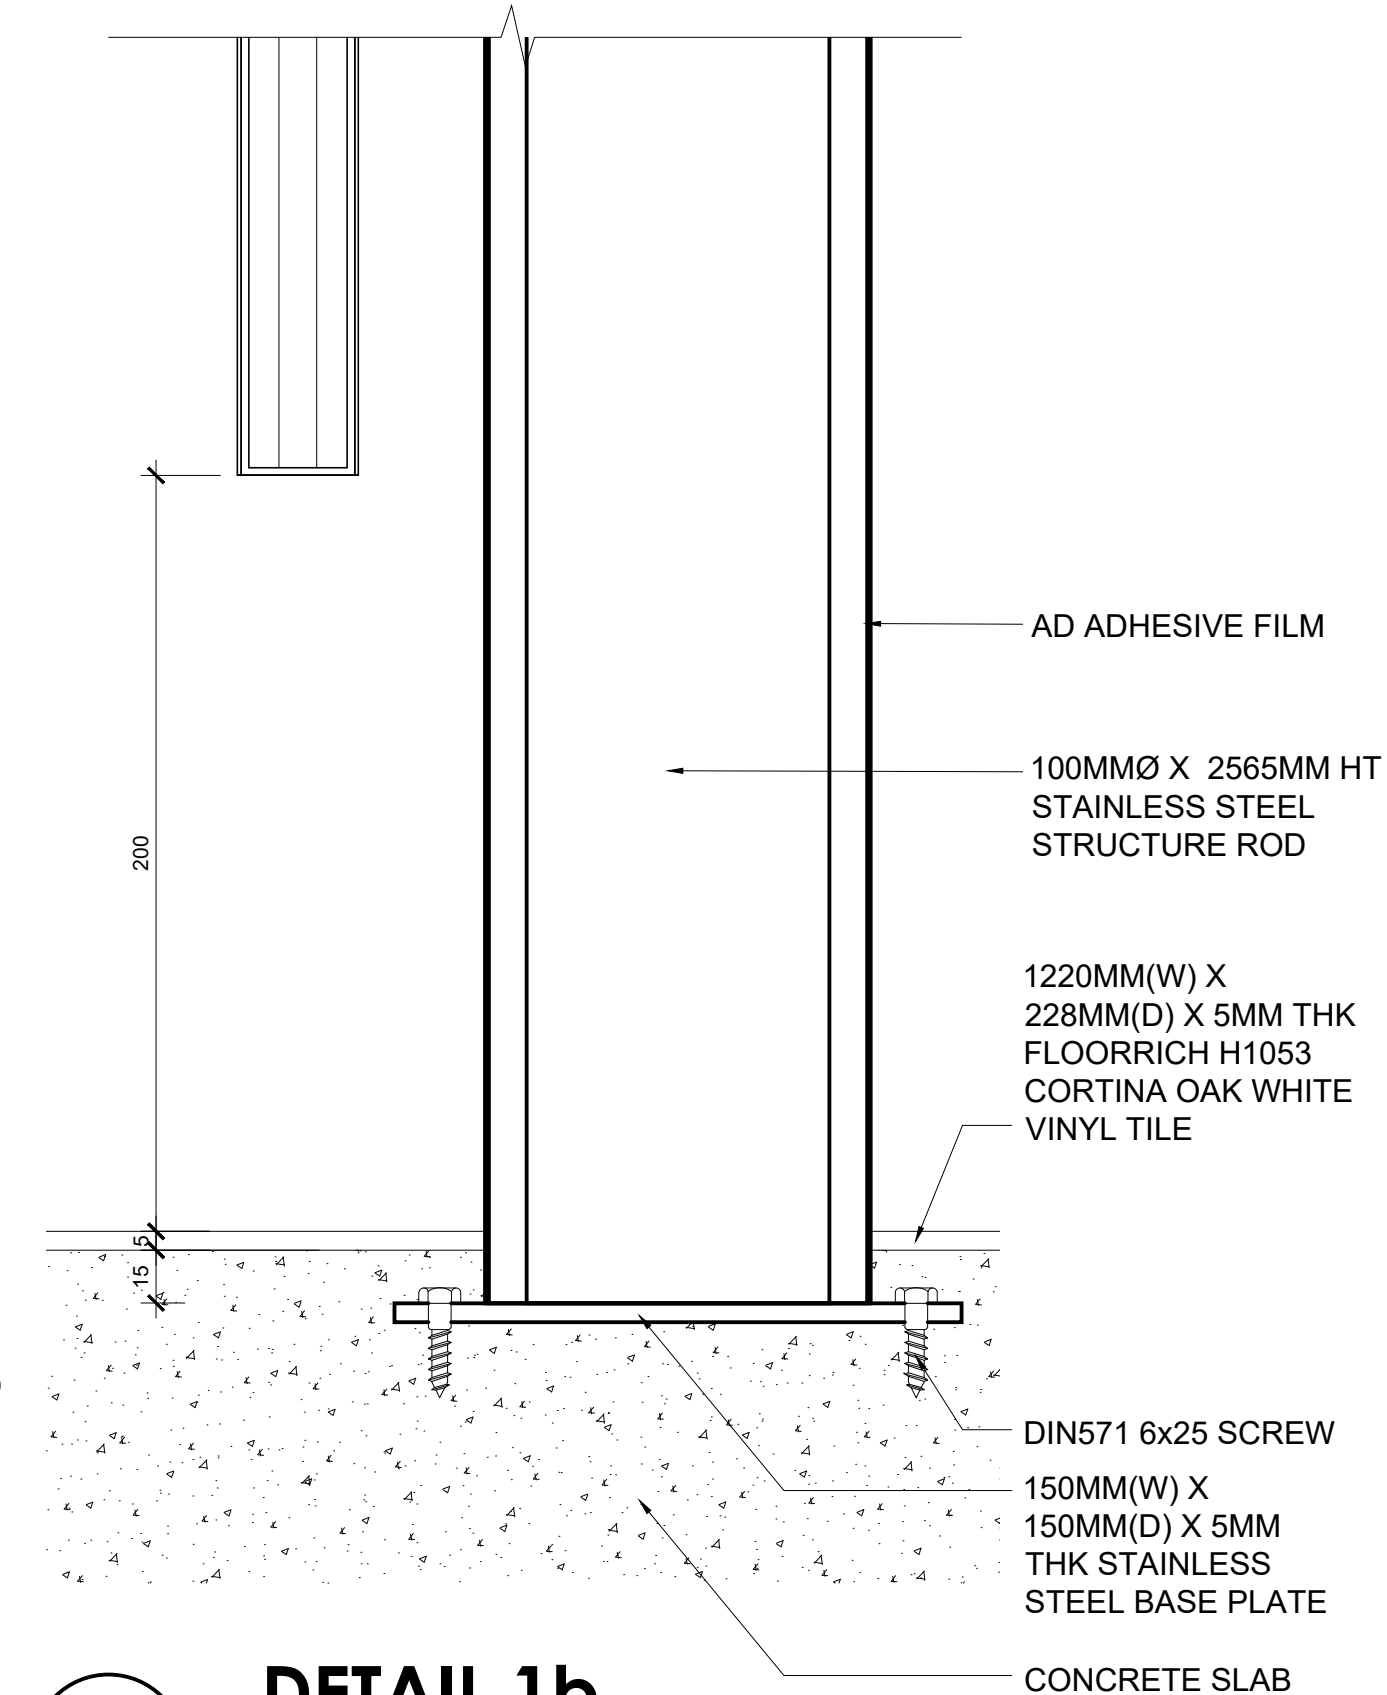

5
601

DETAIL 1b

SCALE : 1 : 2

_____ sheet of _____

AUTHORITY ENDORSEMENT

OFFICIAL STAMP

Project Ref No: 2013-0001

Qualified Person [QP] Declaration

Rev.	Date	Remarks

SP DESIGN SCHOOL

Land Owner / Developer:

SP Design School

Author: Architect/Designer


Project Description:

Proposed Avery Dennison Automotive Studio at
1010 Bukit Merah Lane 3, #01-105
Alexandra Village Industrial Estate
Singapore 159724


Drawing Title:

DETAIL 1


Project No.: 2020-0001	Drawing No.: ID-601	Rev.:
Project Code: 2020-0001		
Scale: Varies	Date: 31/01/20	Drawn: Hong Si Yu
		Checked: MAT3 Tutor

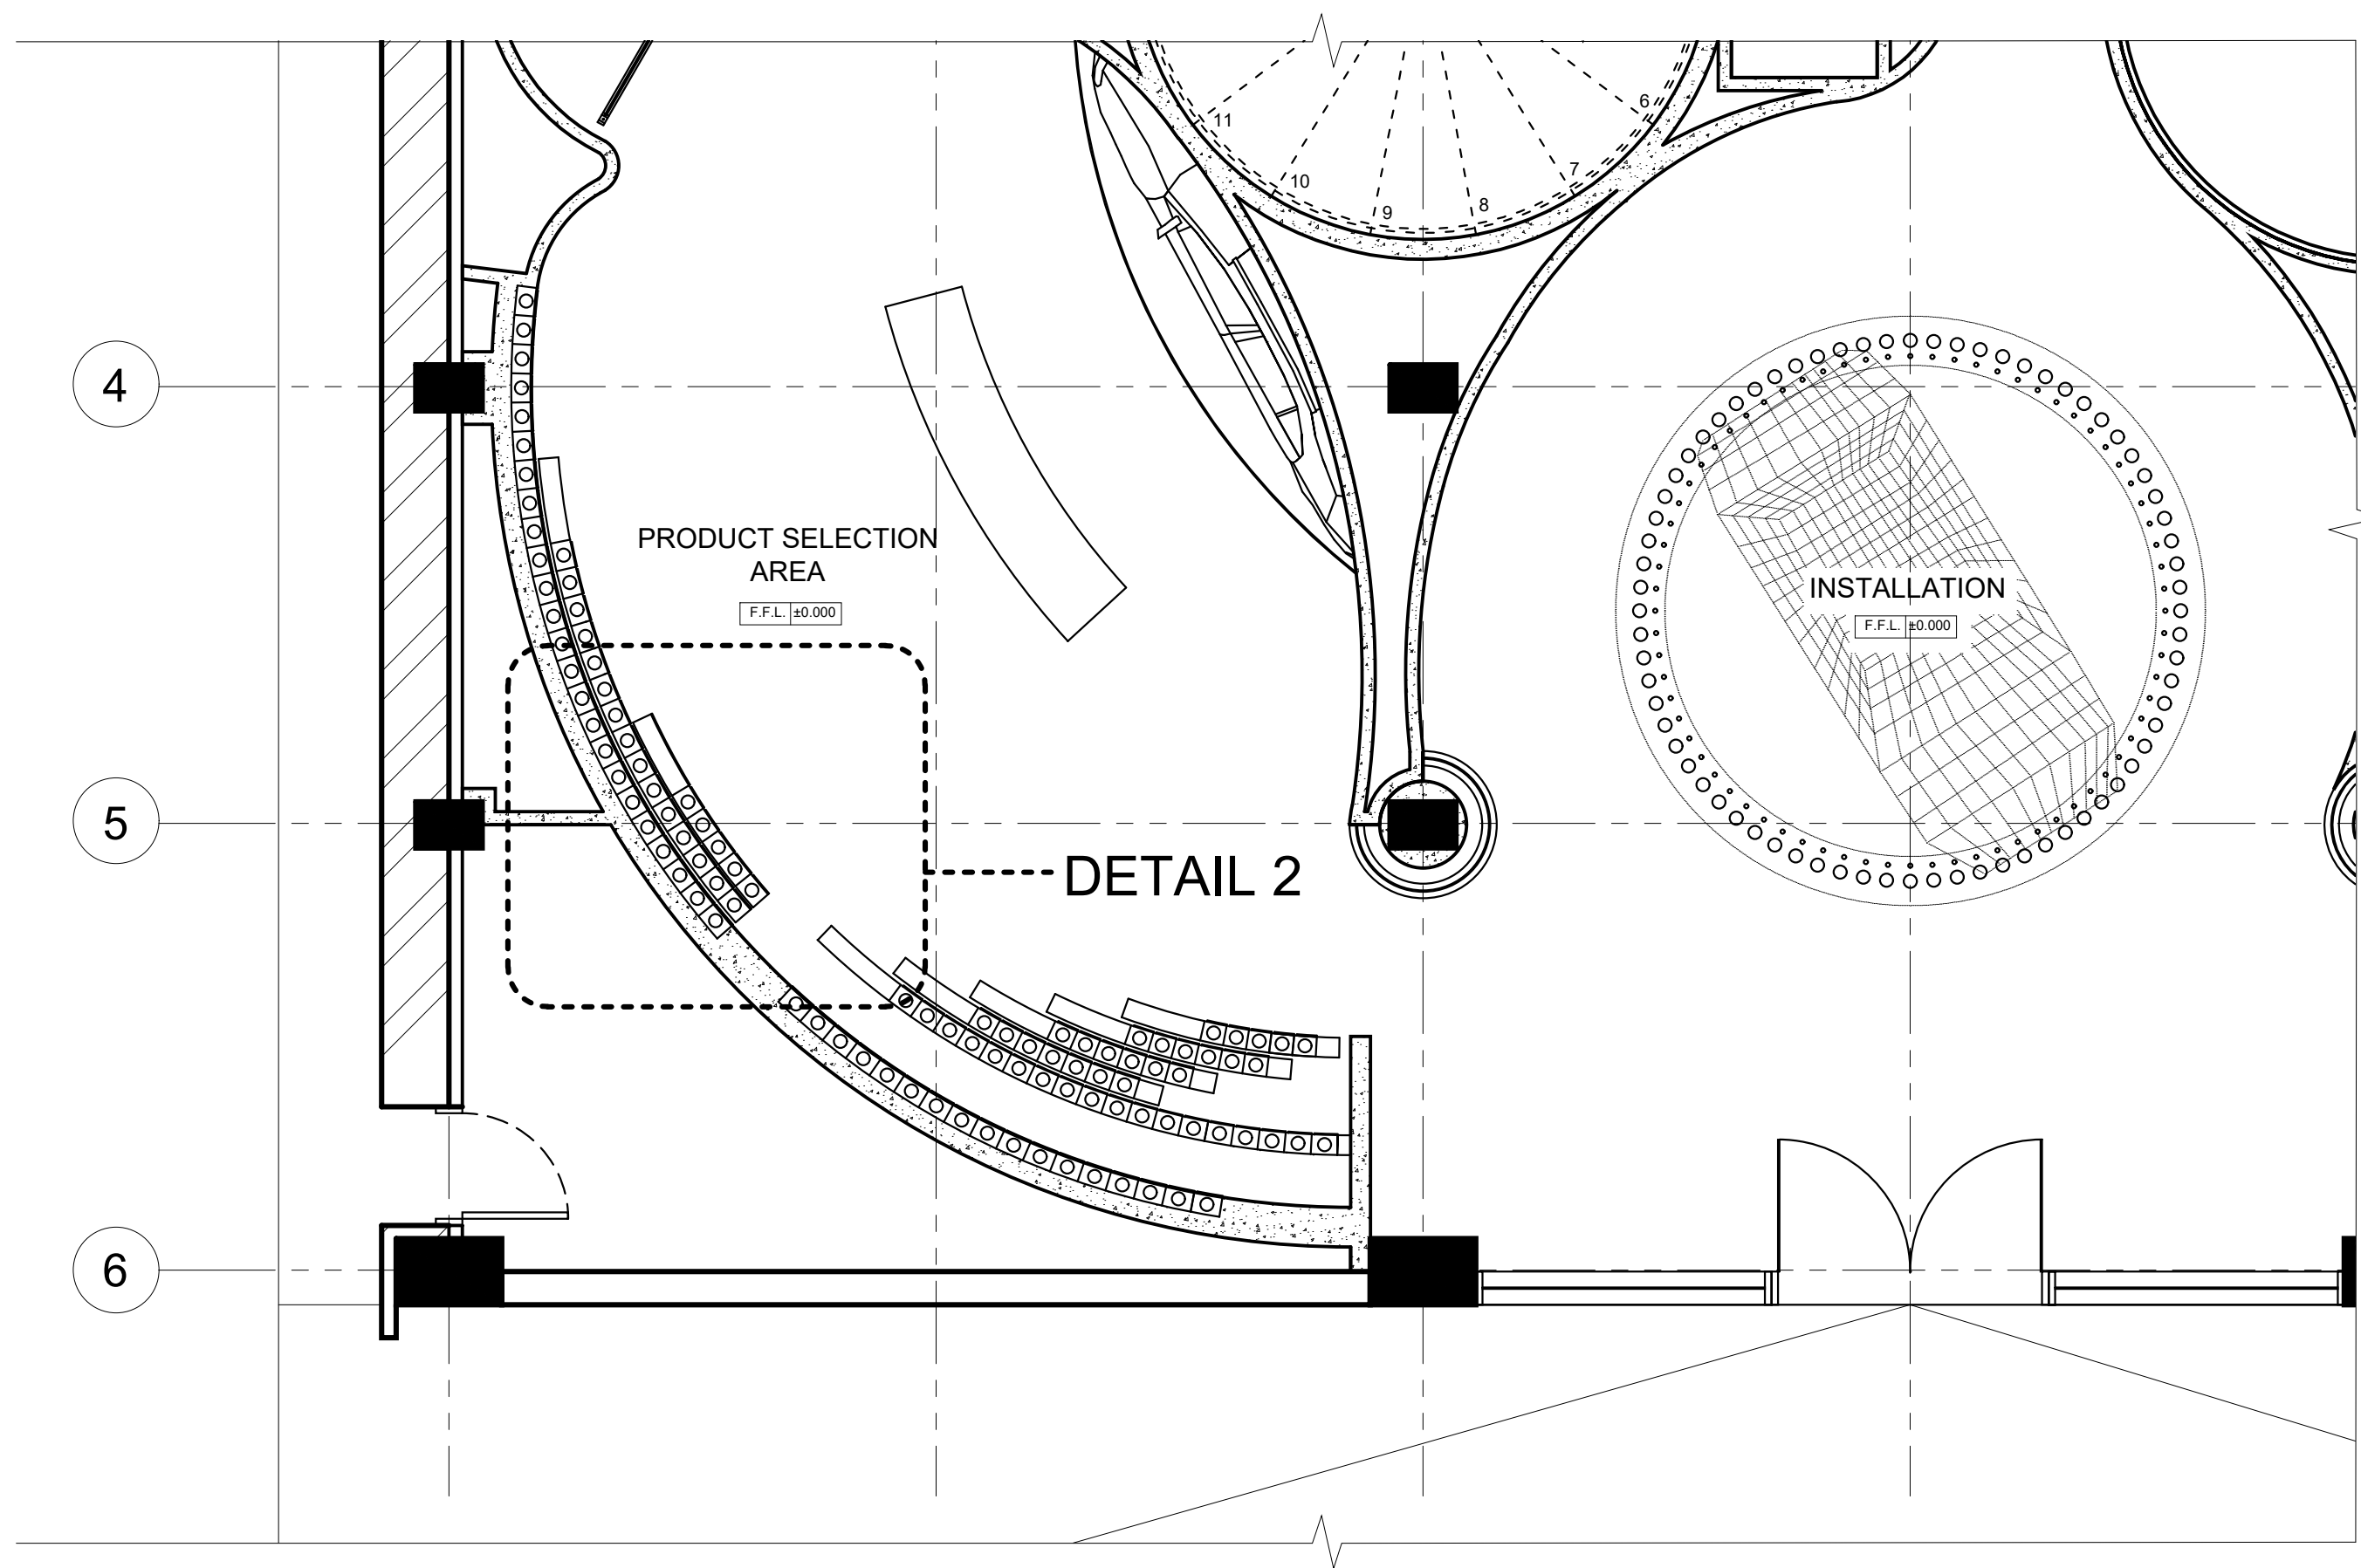


1
602
KEY PLAN
SCALE : 1 : 50

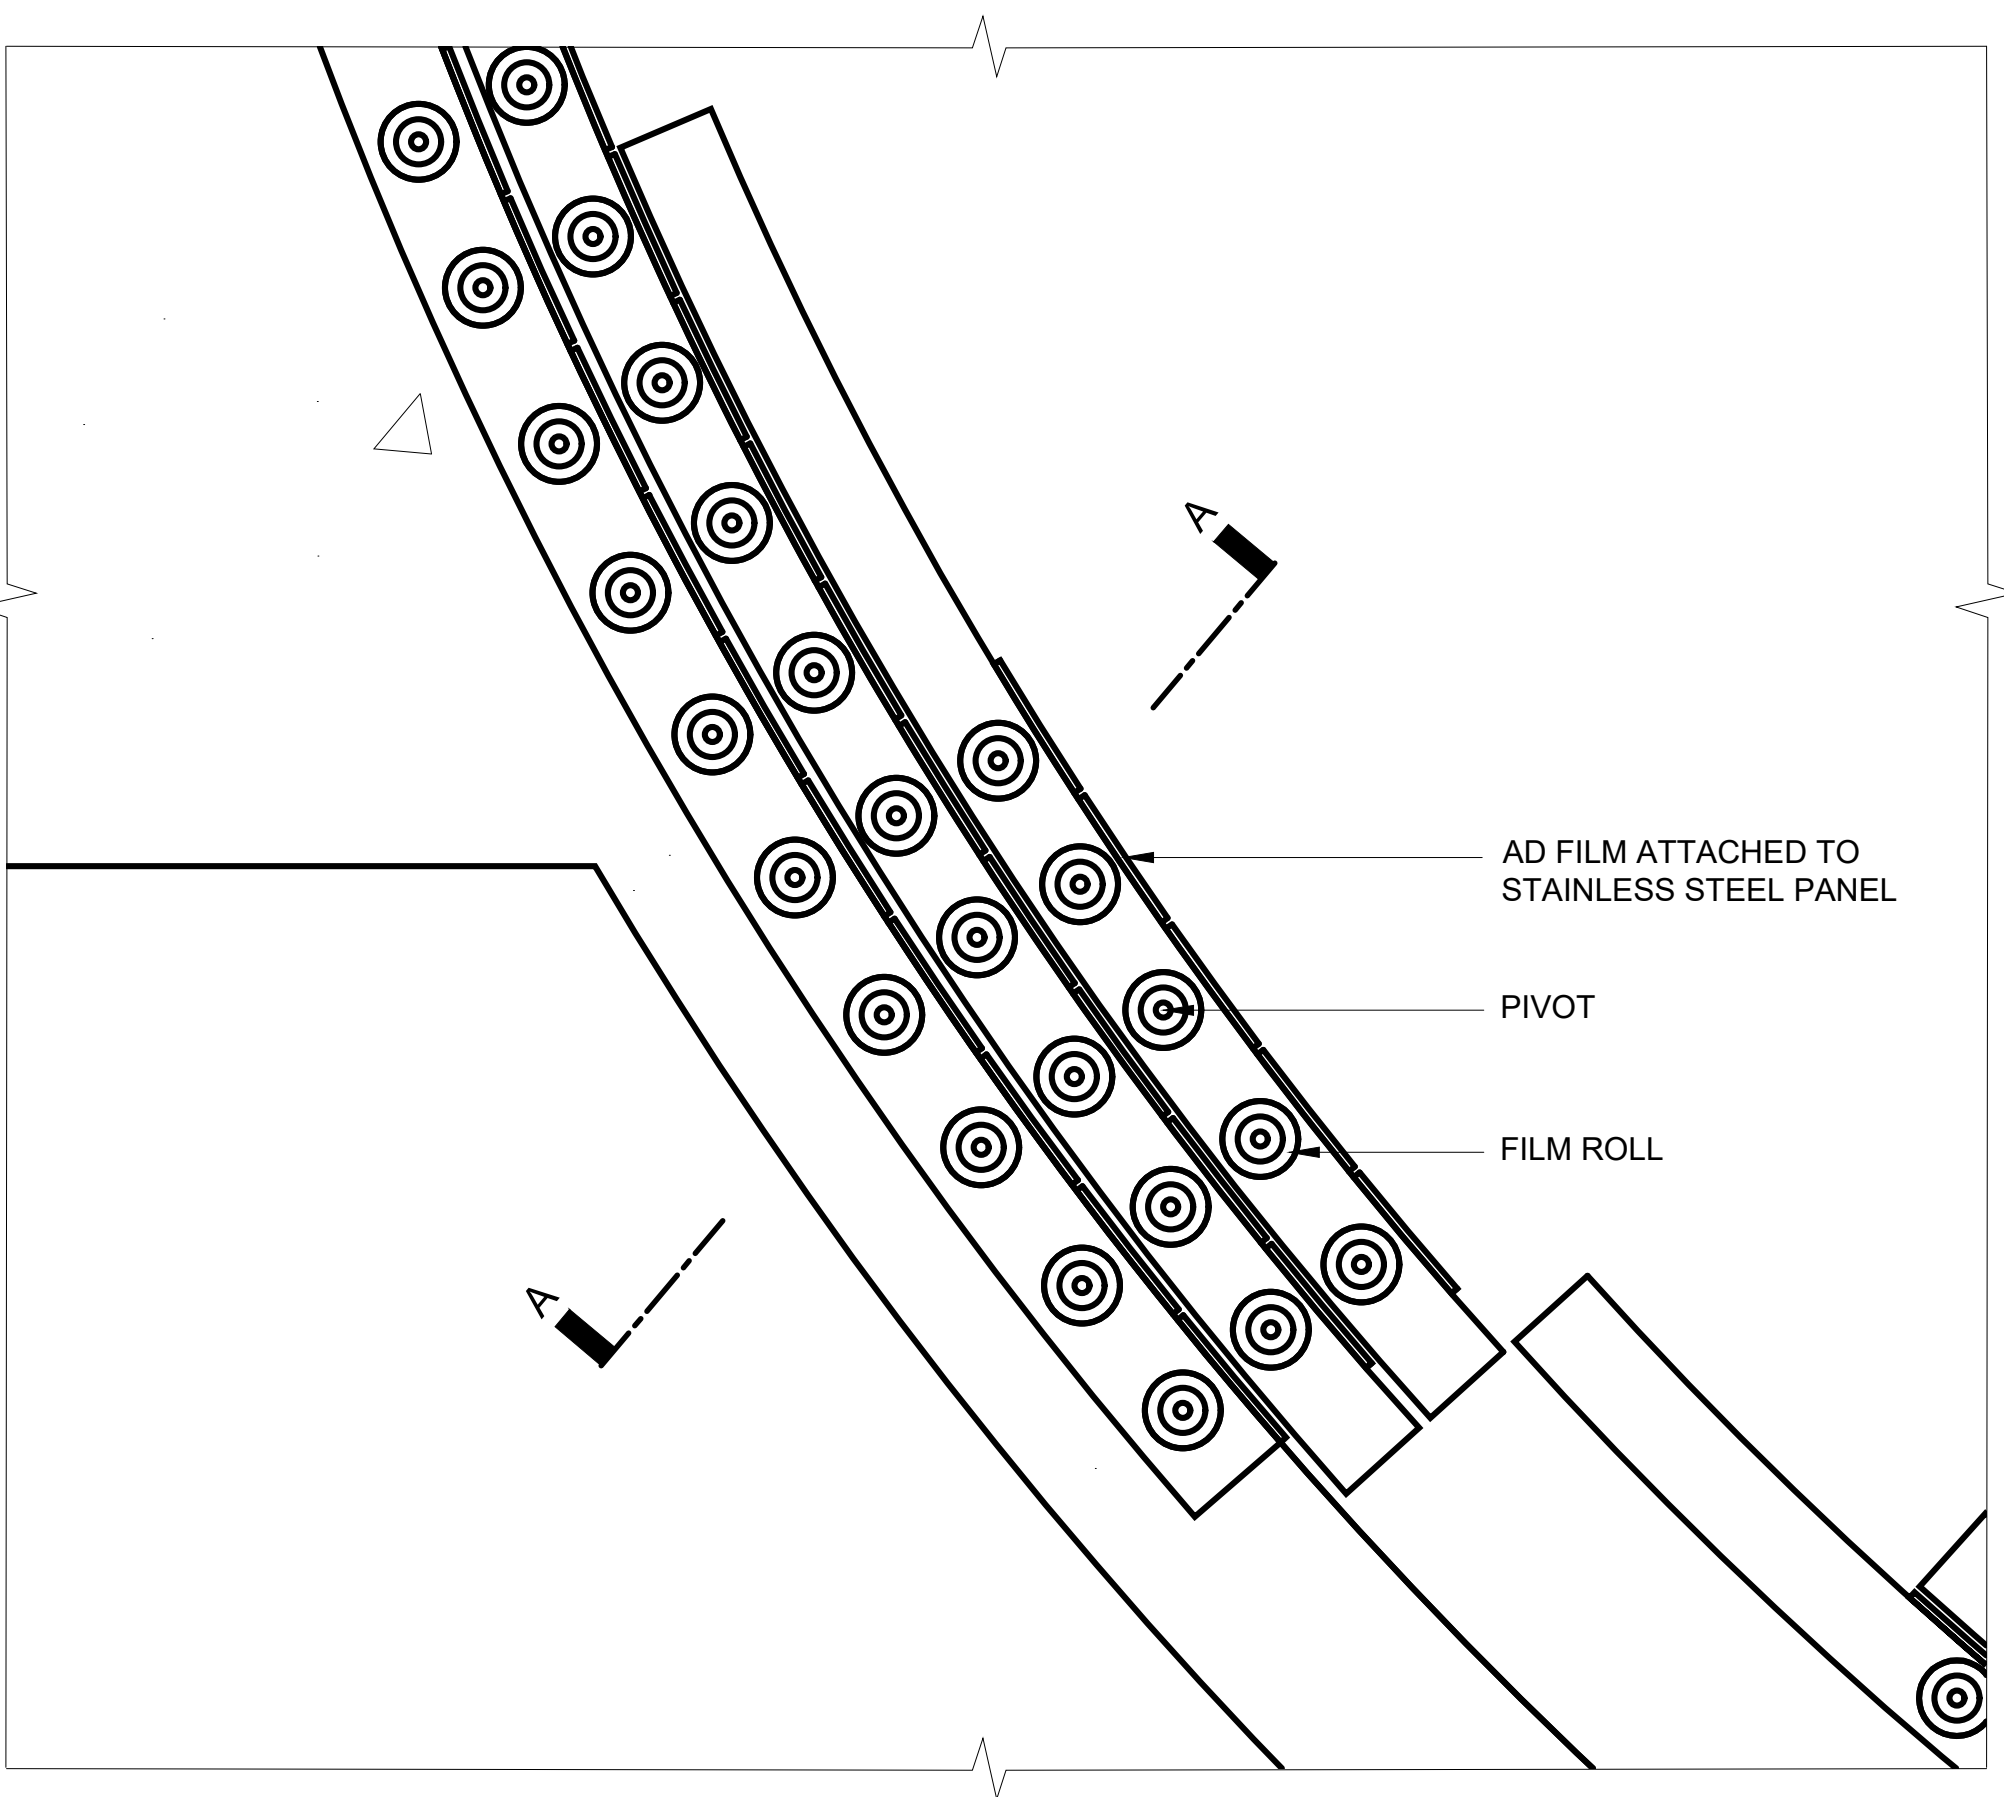


2
602
DETAIL 2: PLAN
SCALE : 1 : 25

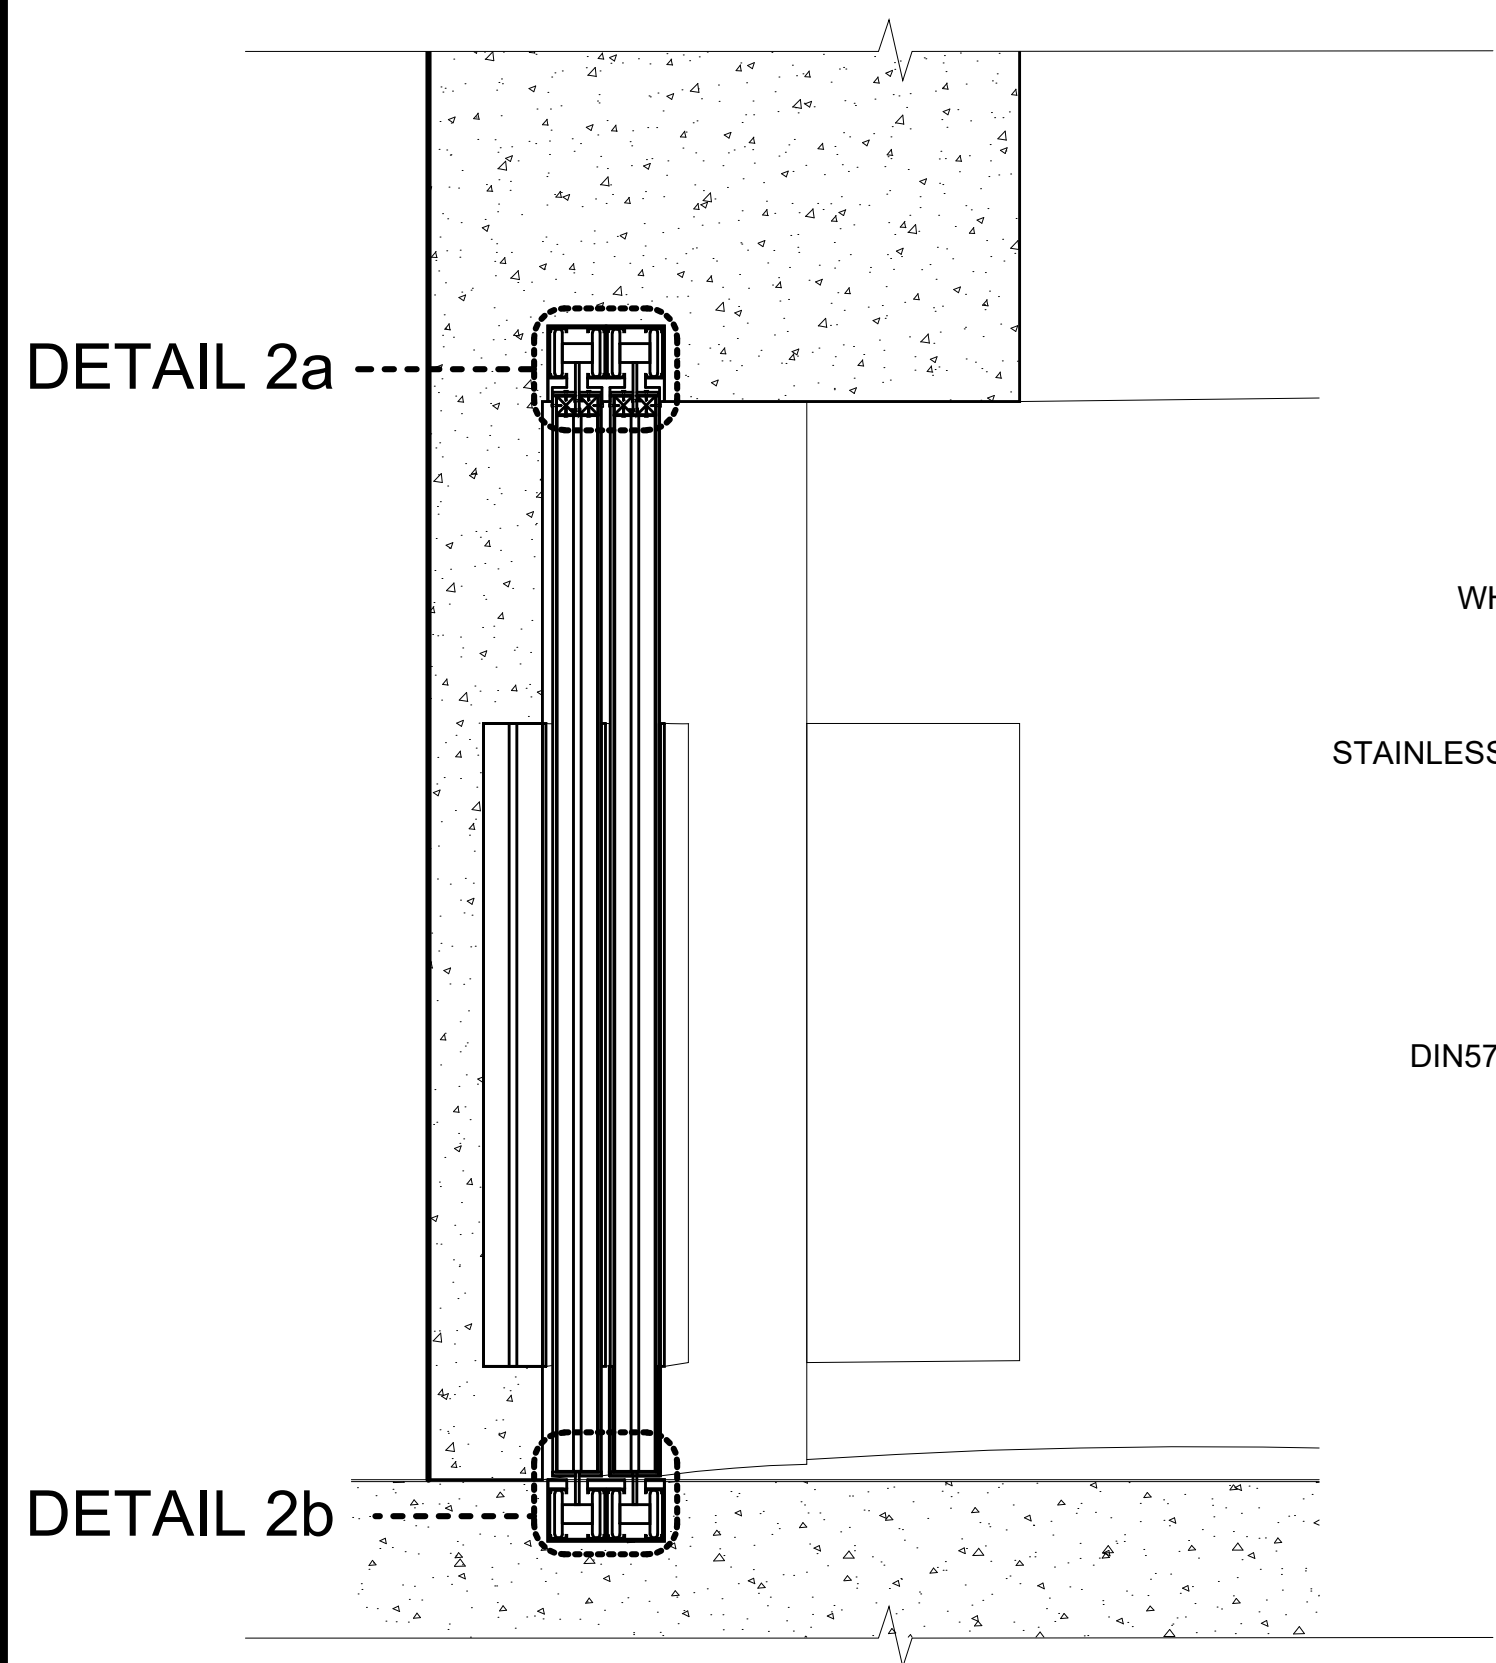

3
602
DETAIL 2: SECTION A-A
SCALE : 1 : 20

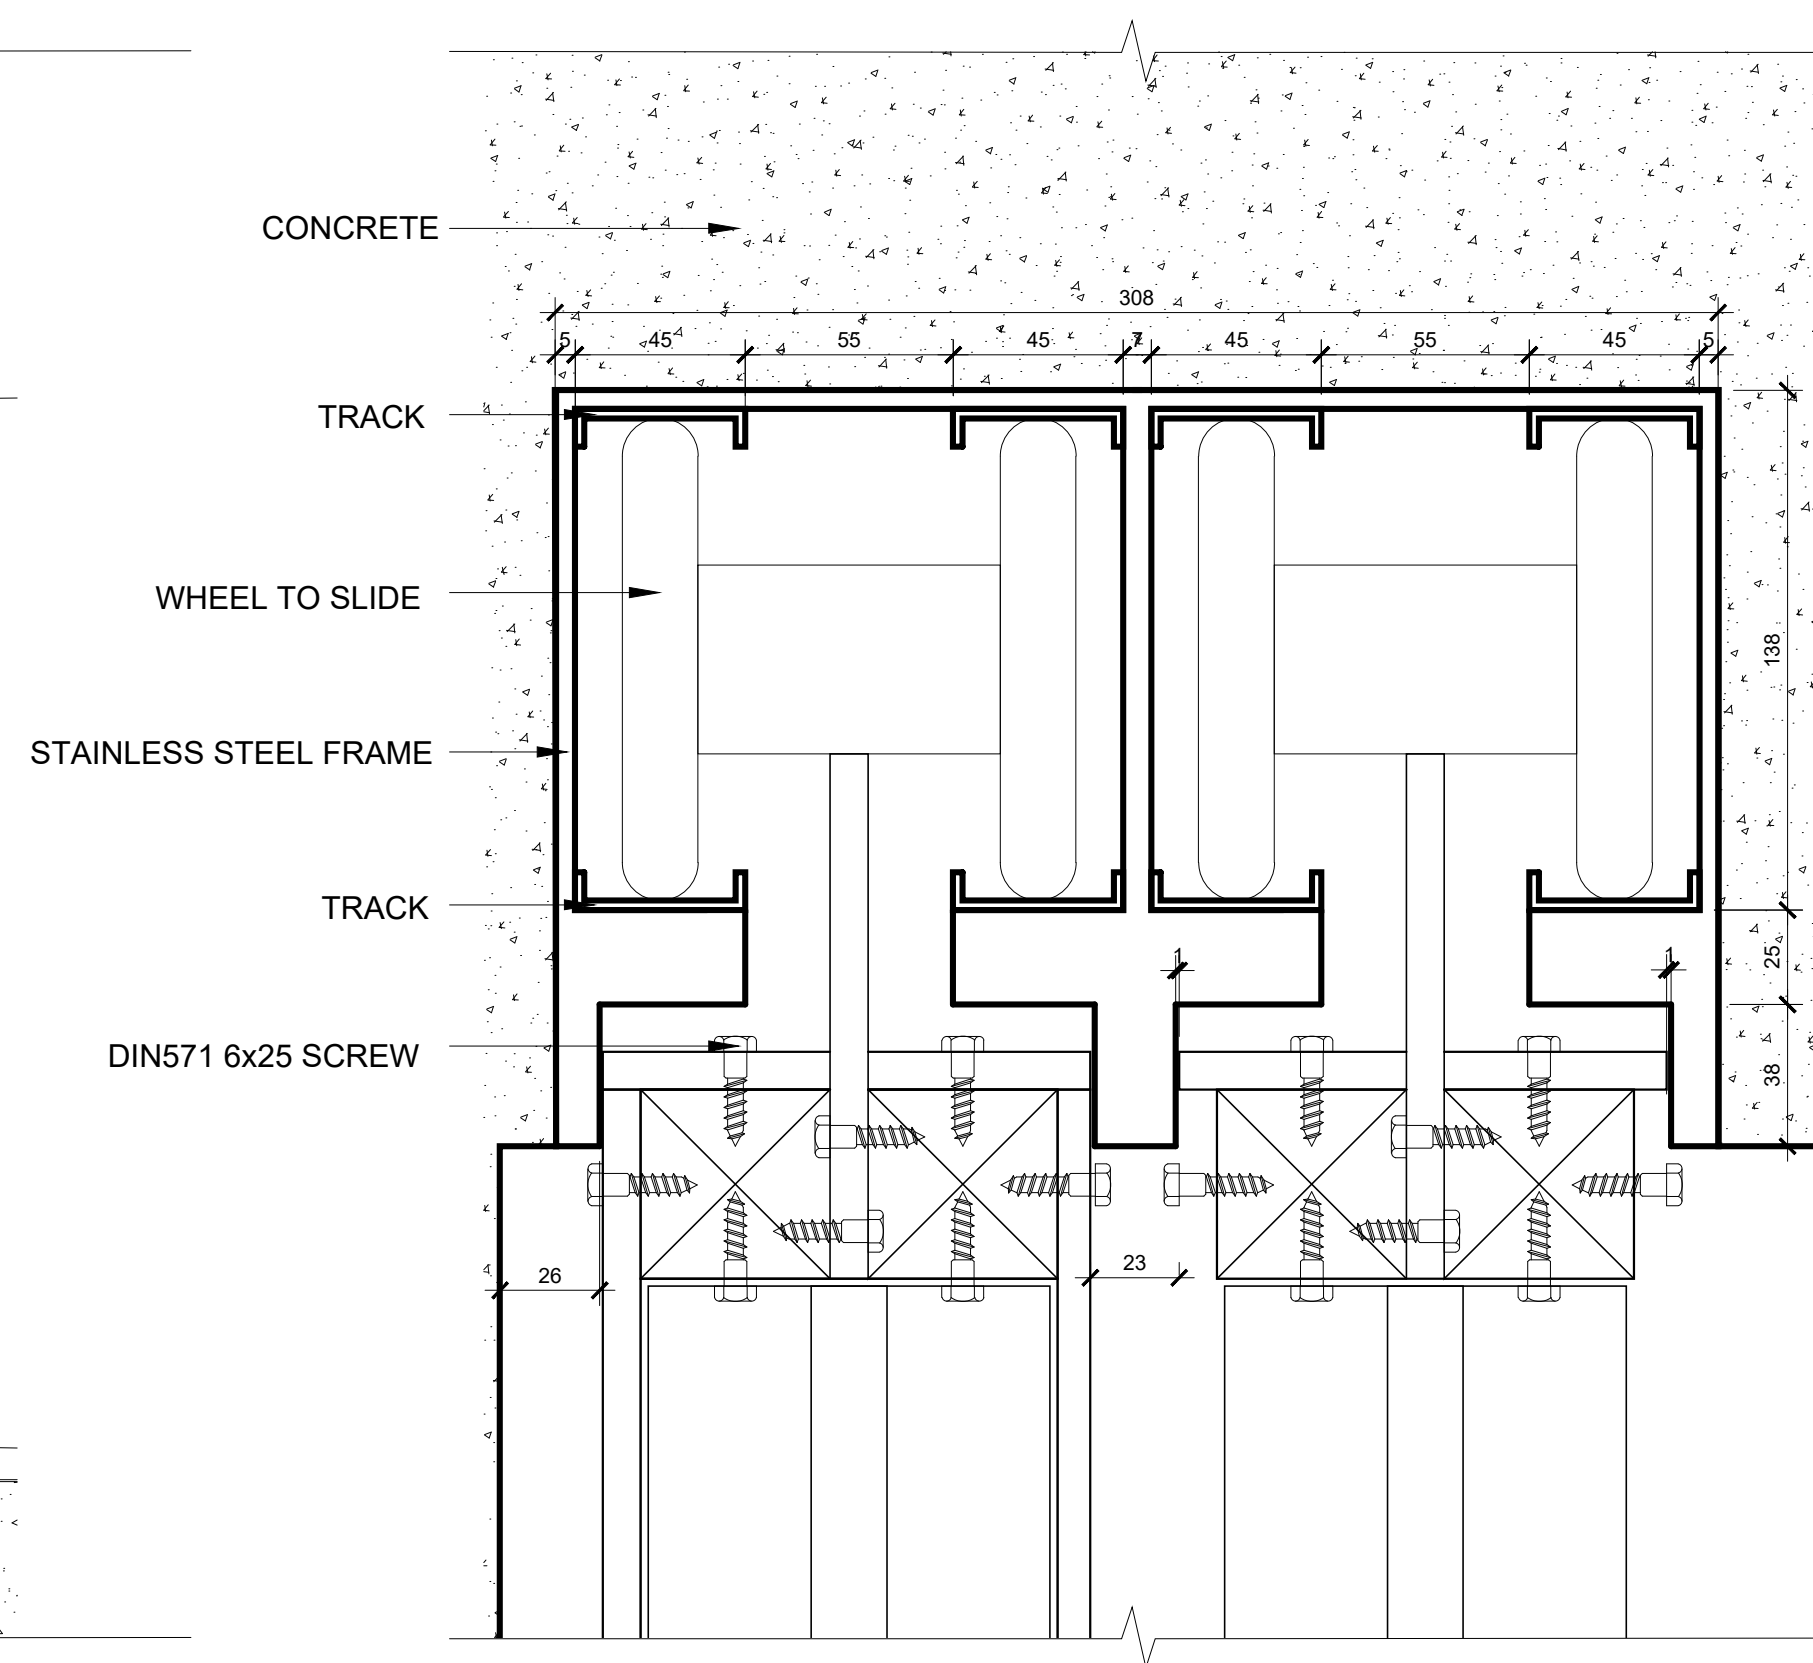

4
602
DETAIL 2a
SCALE : 1 : 2

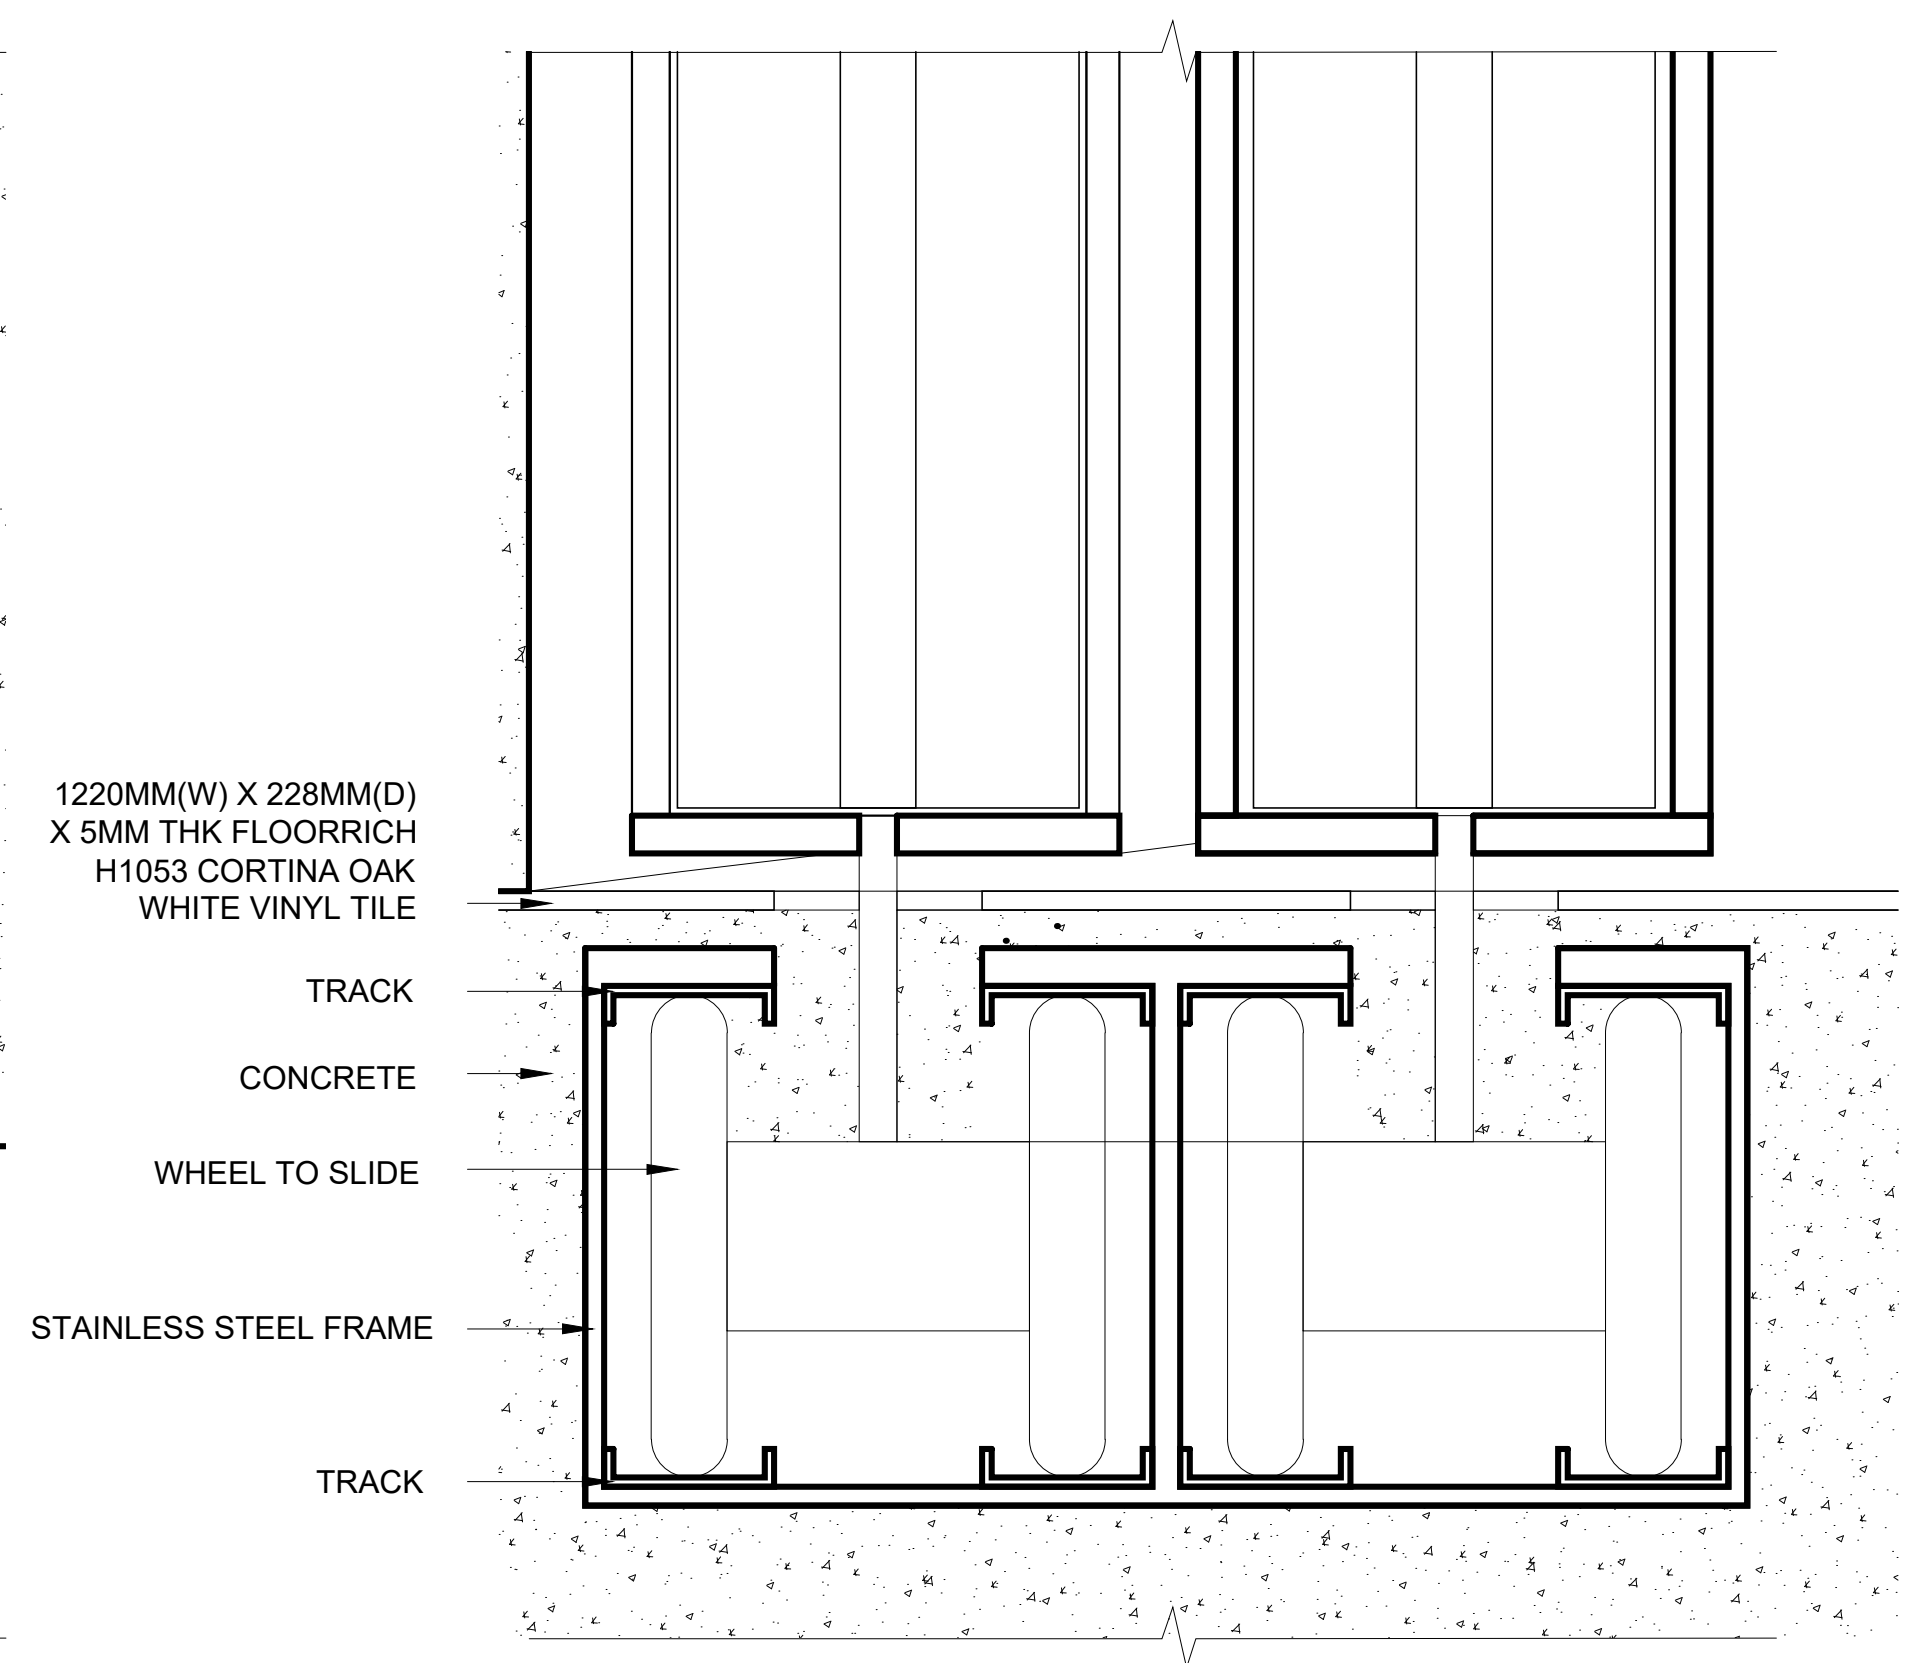

5
602
DETAIL 2b
SCALE : 1 : 2

AUTHORITY ENDORSEMENT

OFFICIAL STAMP

Project Ref No: 2013-0001

Qualified Person [QP] Declaration

Rev.	Date	Remarks

SP DESIGN SCHOOL

Land Owner / Developer:

SP Design School

Author: Architect/Designer

Project Description:

Proposed Avery Dennison Automotive Studio at
1010 Bukit Merah Lane 3, #01-105
Alexandra Village Industrial Estate
Singapore 159724

Drawing Title:

DETAIL 2

Project No.: 2020-0001
Drawing No.: ID-602

Project Code: 2020-0001
Rev.:

Scale:	Date:	Drawn:	Checked:
Varies	31/01/20	Hong Si Yu	MAT3 Tutor